


SYMBOL LEGEND

QUANT.	SYM.	DESCRIPTION	MODEL	BACK BOX
1	FACP	FIRE ALARM CONTROL PANEL	FS-250	
1	DACT	DIGITAL COMMUNICATOR	FS-DACT	
1	CELL	CELLULAR COMMUNICATOR	GS3055-ICF	
1	ANN	FIRE ALARM ANNUNCIATOR	FS-RD2	
14	◇	CEILING SMOKE DETECTOR/BASE	HFP-11/DB-11	SINGLE GANG OR OCTOGON BOX
1	H ₁₃₅	THERMAL DETECTOR/ BASE	HFPT-11/DB-11	SINGLE GANG OR OCTOGON BOX
59	H	THERMAL DETECTOR/ BASE	DT-135R	SINGLE GANG OR OCTOGON BOX
1	H ₂₀₀	200 DEGREE THERMAL DETECTOR/ BASE	DT-200F/HTRI-M	SINGLE GANG OR OCTOGON BOX
6	F	MANUAL PULL STATION	MSM-KD/HTRI-M	3.5" DEEP SINGLE GANG
24	T _L	SINGLE INPUT MONITOR MODULE	HTRI-R	4" SQUARE BOX
24	H<	FIRE ALARM MULTI HORN	ZH-R	4" SQUARE
12	⊠	FIRE ALARM MULTI CANDELLA HORN/STROBE	ZH-MC-R	4" SQUARE
1	⊠	FIRE ALARM MULTI CANDELLA STROBE	ZR-MC-R	4" SQUARE

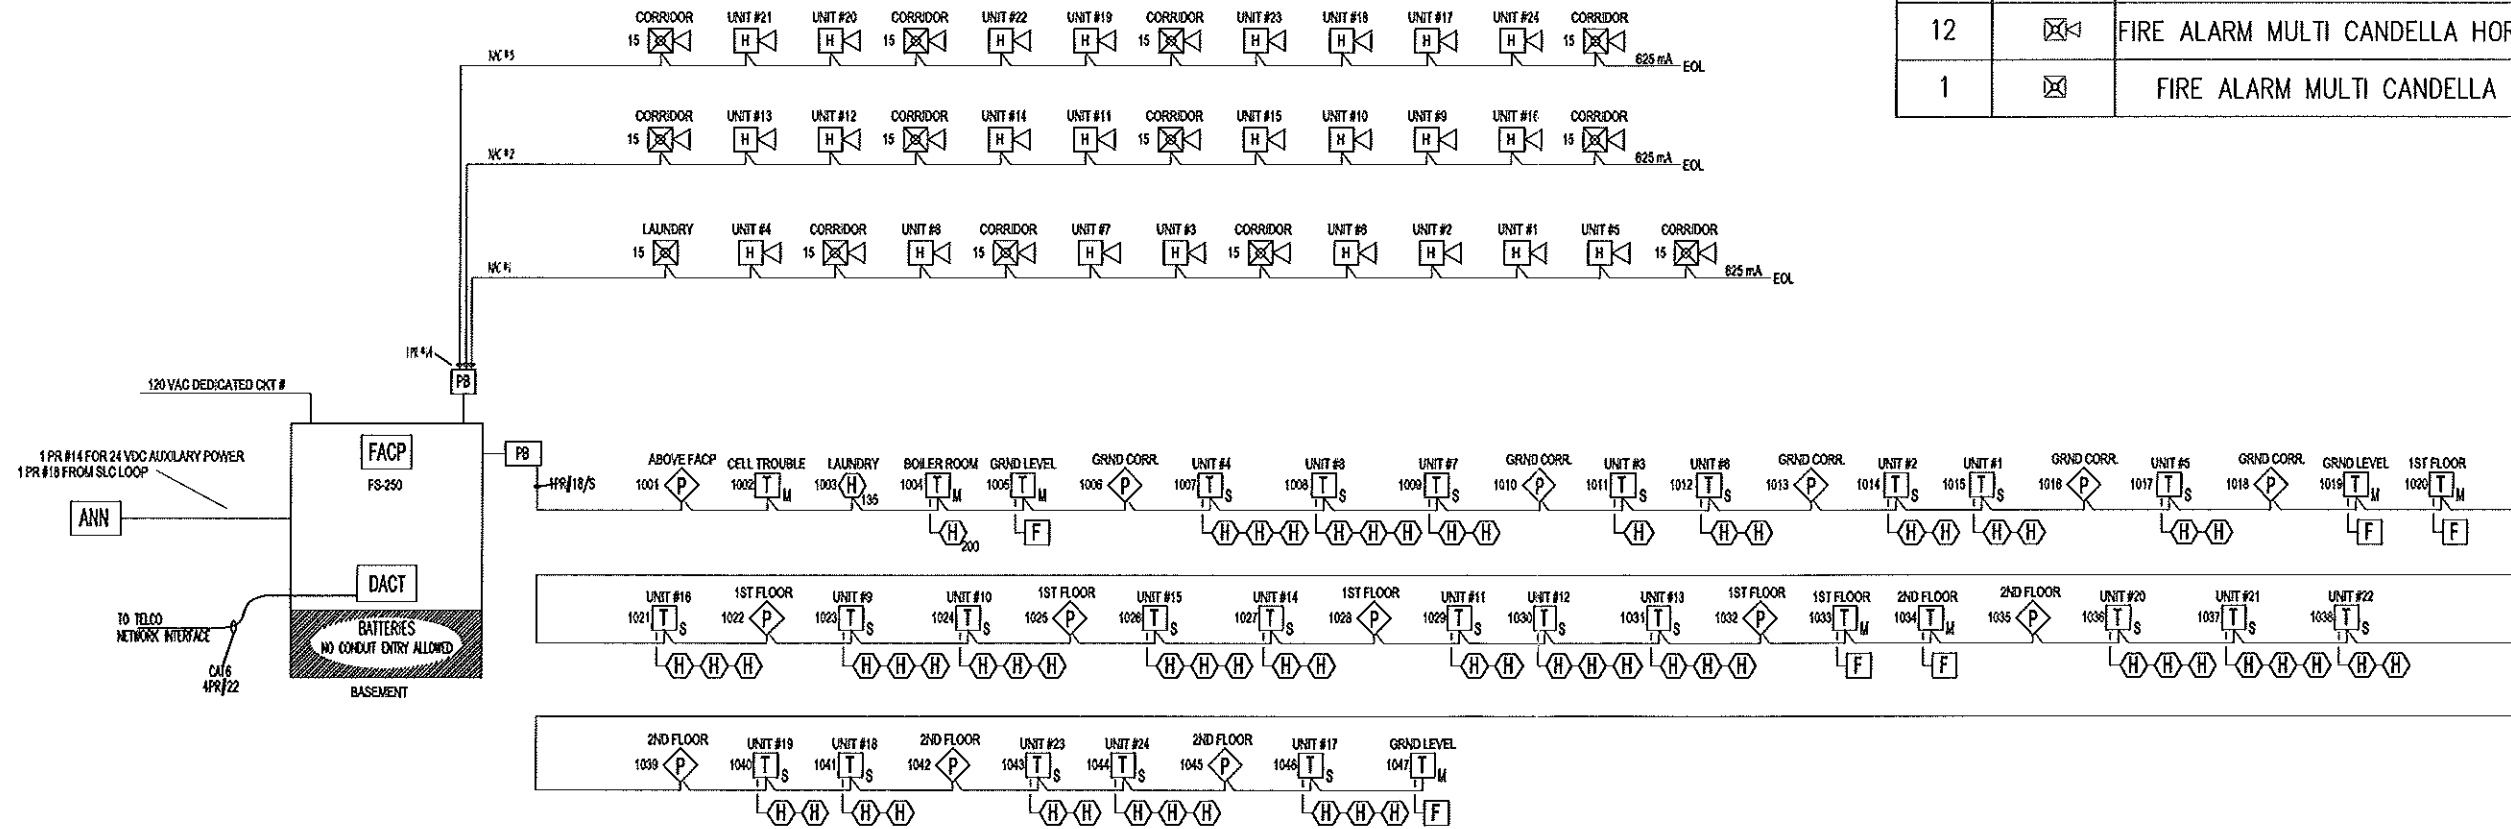

FIRE ALARM RISER DETAIL
SCALE: N.T.S.

GENERAL NOTES	DATE	REVISIONS	REQUIRED APPROVALS	HUNTINGTON APTS 326 AUBURN ST PORTLAND, ME CONTRACT WITH OWNER EASTERN FIRE SERVICES, INC. AUBURN/LEWISTON INDUSTRIAL AIRPARK, AUBURN, MAINE 04210	FIRE ALARM SYSTEM BUILDING 1 PLANS & DETAILS
SCOPE OF WORK: INSTALL NEW ADDRESSABLE FIRE ALARM SYSTEM. ALL INSTALLATION PRACTICES SHALL COMPLY WITH NFPA 70, 72			OWNER		DWG. NO. 4 OF 4
PHASE I: REPLACE CONTROL PANEL			PORTLAND FIRE DEPARTMENT		JOB NUMBER
PHASE II: INSTALL NEW DEVICES			DRAWN BY: CRM		SCALE: NTS
PHASE II TO BE COMPLETED IMMEDIATELY AFTER PHASE I			CHECKED BY: MLT	DATE: 1/25/13	
			CONTRACTOR LICENSE #		