
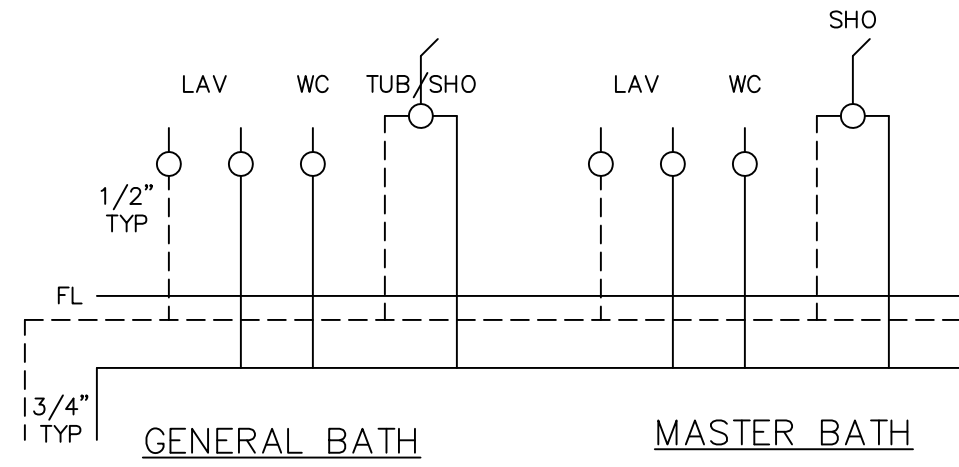
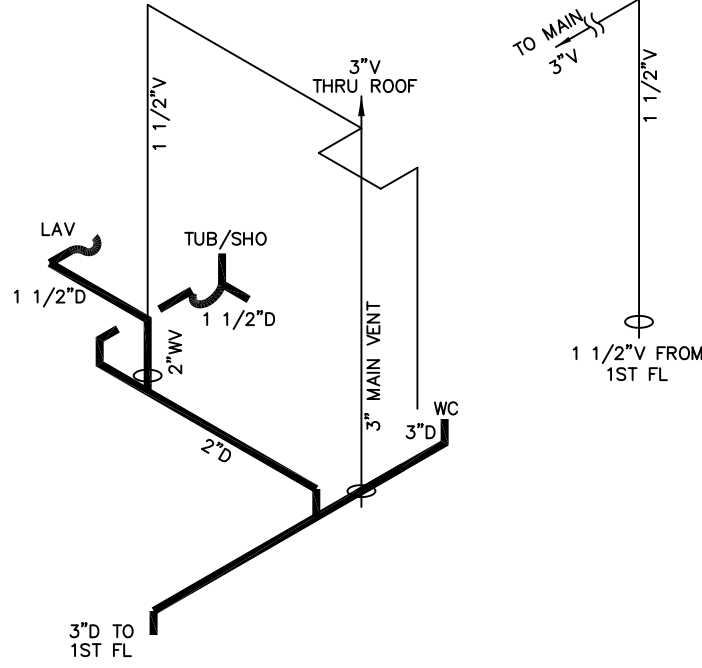
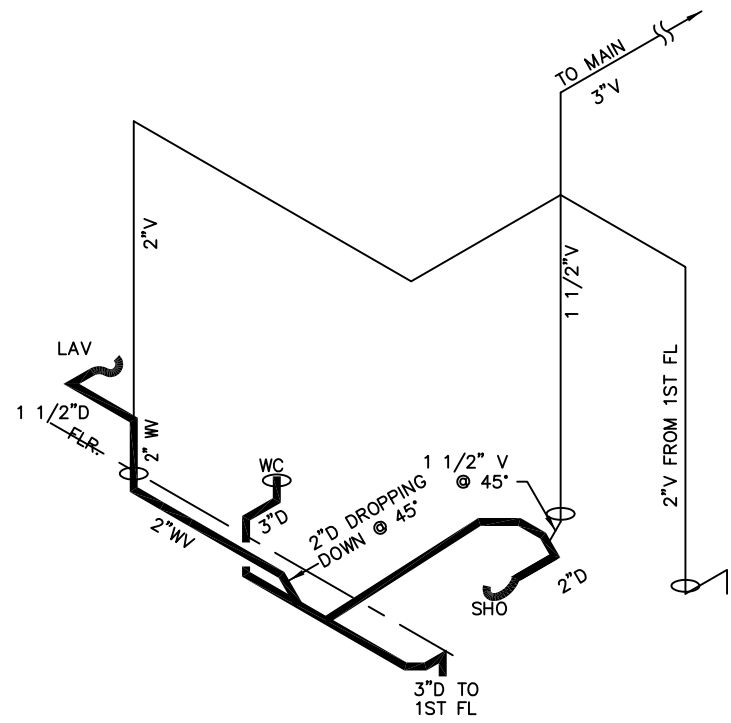


FRONT

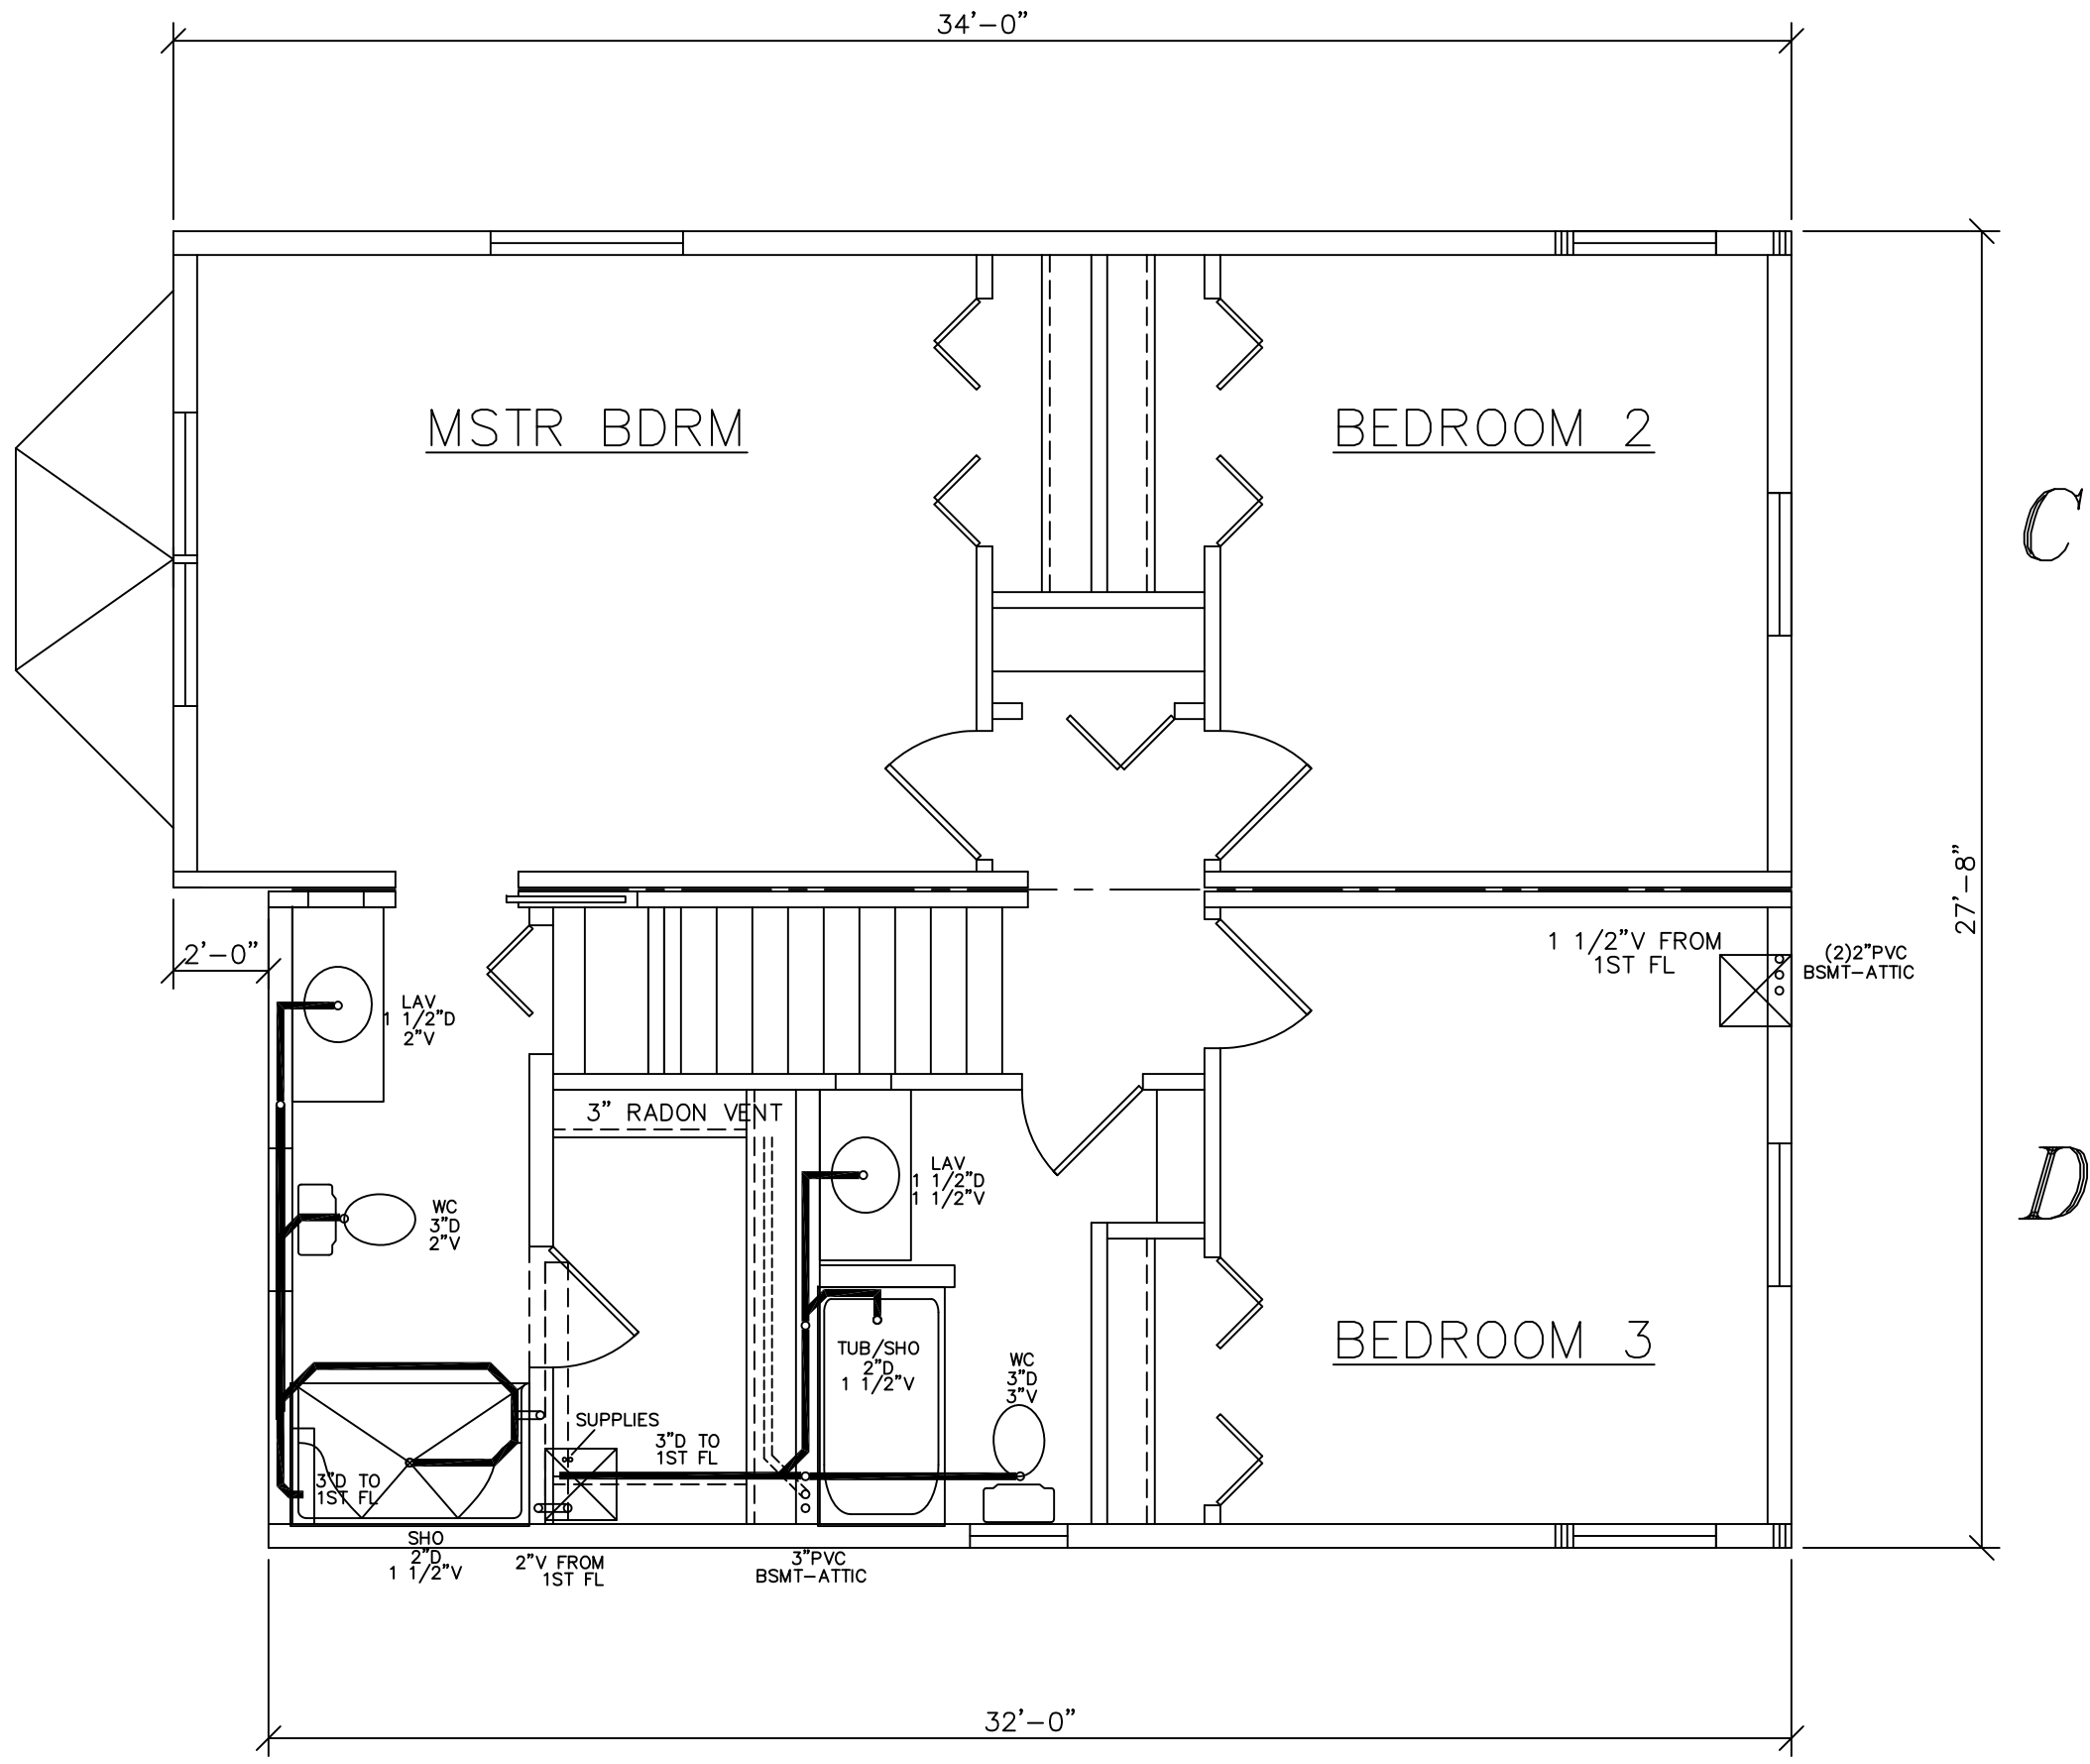

SEE STANDARD NOTES & DETAILS DWG #8

USE GROUP: SINGLE FAMILY		HOMEOWNER: BOUCHARD/MEOLI		SERIAL No. 17066		THIRD PARTY INSPECTION AGENCY	
CONST. TYPE: VB		BUILDER: SILVER BEACH LLC DBA SILVER BEACH HOMES 83 WELLMOOD RD PORTLAND ME 04103		PRODUCTION No.		PE / RA	
DESIGNER: MJG		SITE: 291 SUMMIT STREET PORTLAND, ME 04103		REVISION		DATE	
DATE: 05/05/17		RICHMOND CTM-L		CHECK		DATE	
SCALE: 1/4" = 1'-0"		SECOND FLOOR PLUMBING PLAN		DATE		DATE	
PAGE: 5B				DATE		DATE	
WESTCHESTER MODULAR HOMES INC 30 REAGANS MILL ROAD, WINGDALE, NEW YORK, 12594 TEL (845)832-9400 FAX (845)832-6698		DATE		DATE		DATE	