


477 Pamela Rd
LP Tank Placement

LP Tanks
on Pads


Doghouse

Heating System
mounted to wall

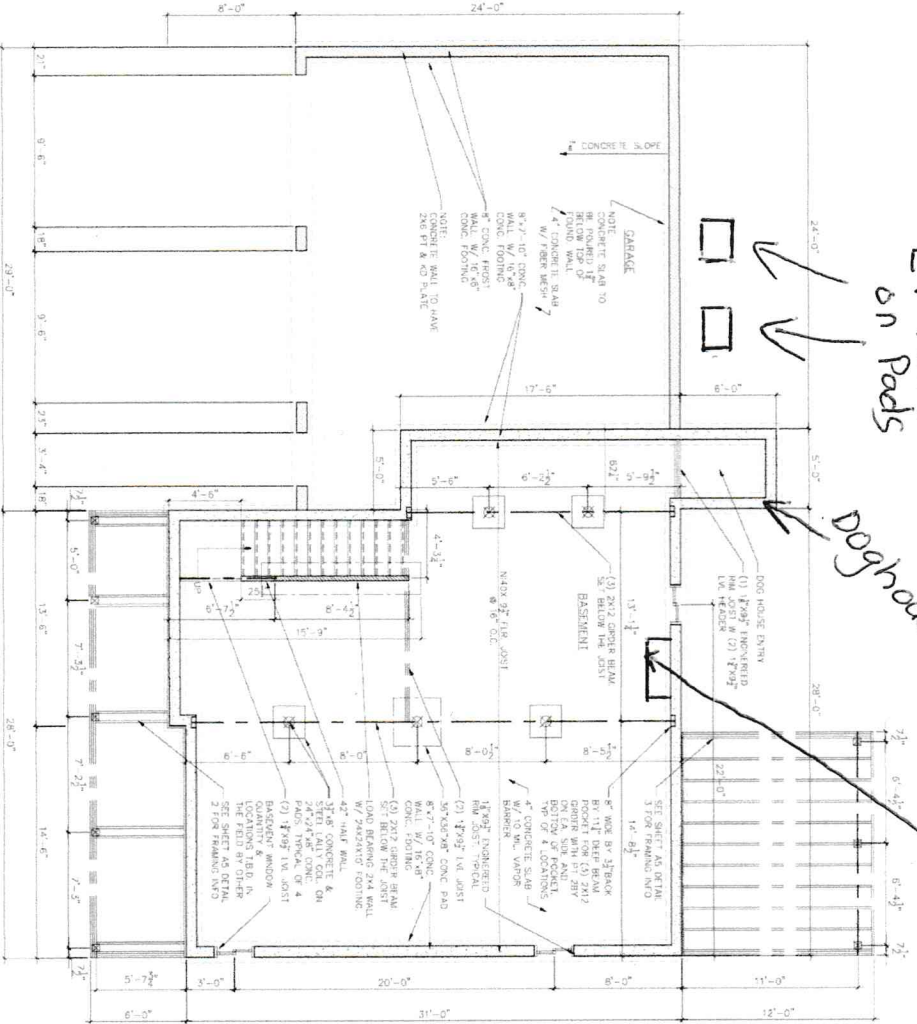

1 FOUNDATION PLAN

CLIENT _____
CLIENT _____

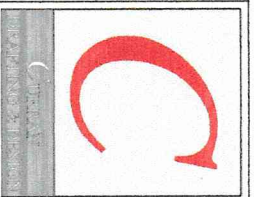

13 WINTERBURY WAY
PALMOUTH, MAINE 04158
TEL: (603) 653-5330
WWW.C2DHOME.COM

PROJECT NAME
REQUITA
SPEC #2

PROJECT LOCATION
PORTLAND, MAINE

BUILT BY

SHEET NAME

**FOUNDATION
PLAN &
DETAILS**

ALL NOTES, SPECIFICATIONS AND DIMENSIONS INDICATED ON THIS SHEET SHALL BE CONSIDERED TO BE THE BASIS FOR THE CONSTRUCTION OF THIS PROJECT. THE CONTRACTOR SHALL BE RESPONSIBLE FOR OBTAINING ALL NECESSARY PERMITS AND APPROVALS FROM THE LOCAL AUTHORITIES. THE CONTRACTOR SHALL BE RESPONSIBLE FOR OBTAINING ALL NECESSARY PERMITS AND APPROVALS FROM THE LOCAL AUTHORITIES. THE CONTRACTOR SHALL BE RESPONSIBLE FOR OBTAINING ALL NECESSARY PERMITS AND APPROVALS FROM THE LOCAL AUTHORITIES.

DRAWN BY: M.P.C.
CHECKED BY: M.P.C.
SCALE: AS NOTED
DATE: 10/28/16
FILE NUMBER: 16-0046
REVISIONS:

A-2