


SYSTEMS SYMBOLS LEGEND

- 2' x 4' LAY-IN FLUORESCENT FIXTURE
- 2' x 2' LAY-IN FLUORESCENT FIXTURE
- WALL MOUNTED EMERGENCY LIGHT.
- EXIT LIGHT
- MECHANICAL SUPPLY DIFFUSER
- MECHANICAL RETURN DIFFUSER
- SPEAKER

NOTE: LIGHTING IS FOR REFERENCE ONLY. FINAL LIGHTING LAYOUT AND FIXTURE SELECTION SHALL BE DESIGNED BY ELECTRICAL CONTRACTOR.

GC SHALL COORDINATE WITH OWNER FOR LIGHT SELECTION.


MECHANICAL CONTRACTOR TO MODIFY EXISTING HVAC SYSTEM TO MEET REQUIREMENTS OF NEW PLAN LAYOUT AND SPACE USAGE.

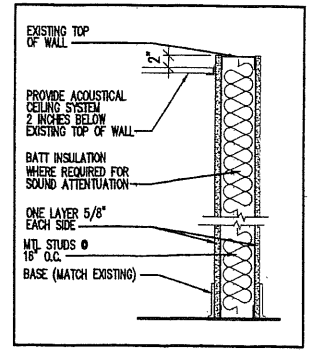

3 WALL TYPE
NOT TO SCALE


LEGEND

- NEW WALLS

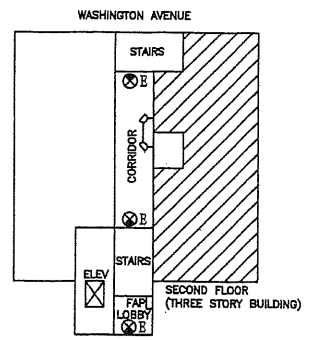

KEY PLAN
NOT TO SCALE

2 REFLECTED CEILING PLAN
SCALE: 1/4" = 1'-0"

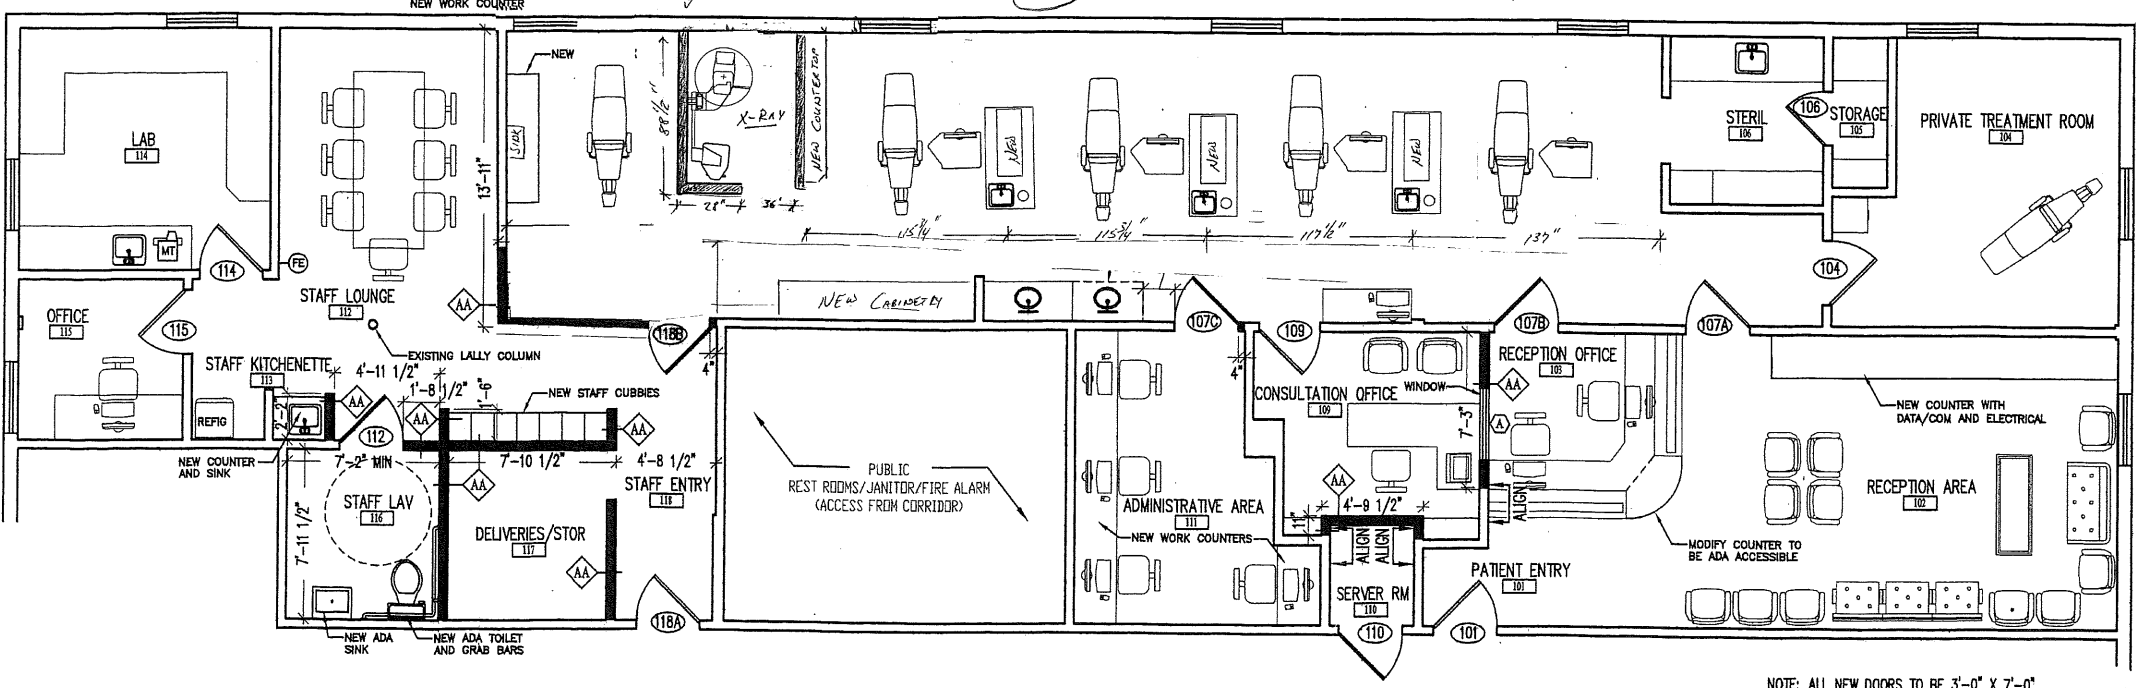

1 PROPOSED FLOOR PLAN
SCALE: 1/4" = 1'-0"

NOTE: NEW WORK @ X-RAY TO BE 2x4 Framing w/ 1/2" Drywall Eng. Side, unless directed otherwise.
12/21/12
per Bob Turner
Steel studs

NOTE: ALL NEW DOORS TO BE 3'-0" X 7'-0".

MINOR REVISION

RECEIVED
DEC 20 2012
Dept. of Building Inspections
City of Portland Maine

ISSUED:

06/04/12	INITIAL MEETING WITH PORTLAND CODE ENFORCEMENT
07/10/12	REVISIONS PER OWNERS REQUEST

DRAWN BY: BLB
CHECKED BY: DMD
DATE: JULY 10, 2012
SCALE: AS SHOWN
JOB NUMBER:

MAINE ORTHODONTICS
1321 WASHINGTON AVE
PORTLAND, ME 04103

Don Dyer, Architect
Maine Registered Architect
PO Box 191
Limaington, ME 04049
Phone: 207-423-5371
dda@maine.rr.com

TITLE:
PROPOSED FLOOR
PLAN & REFLECTED
CEILING PLAN

SHEET NO.

A2

2 of 2