
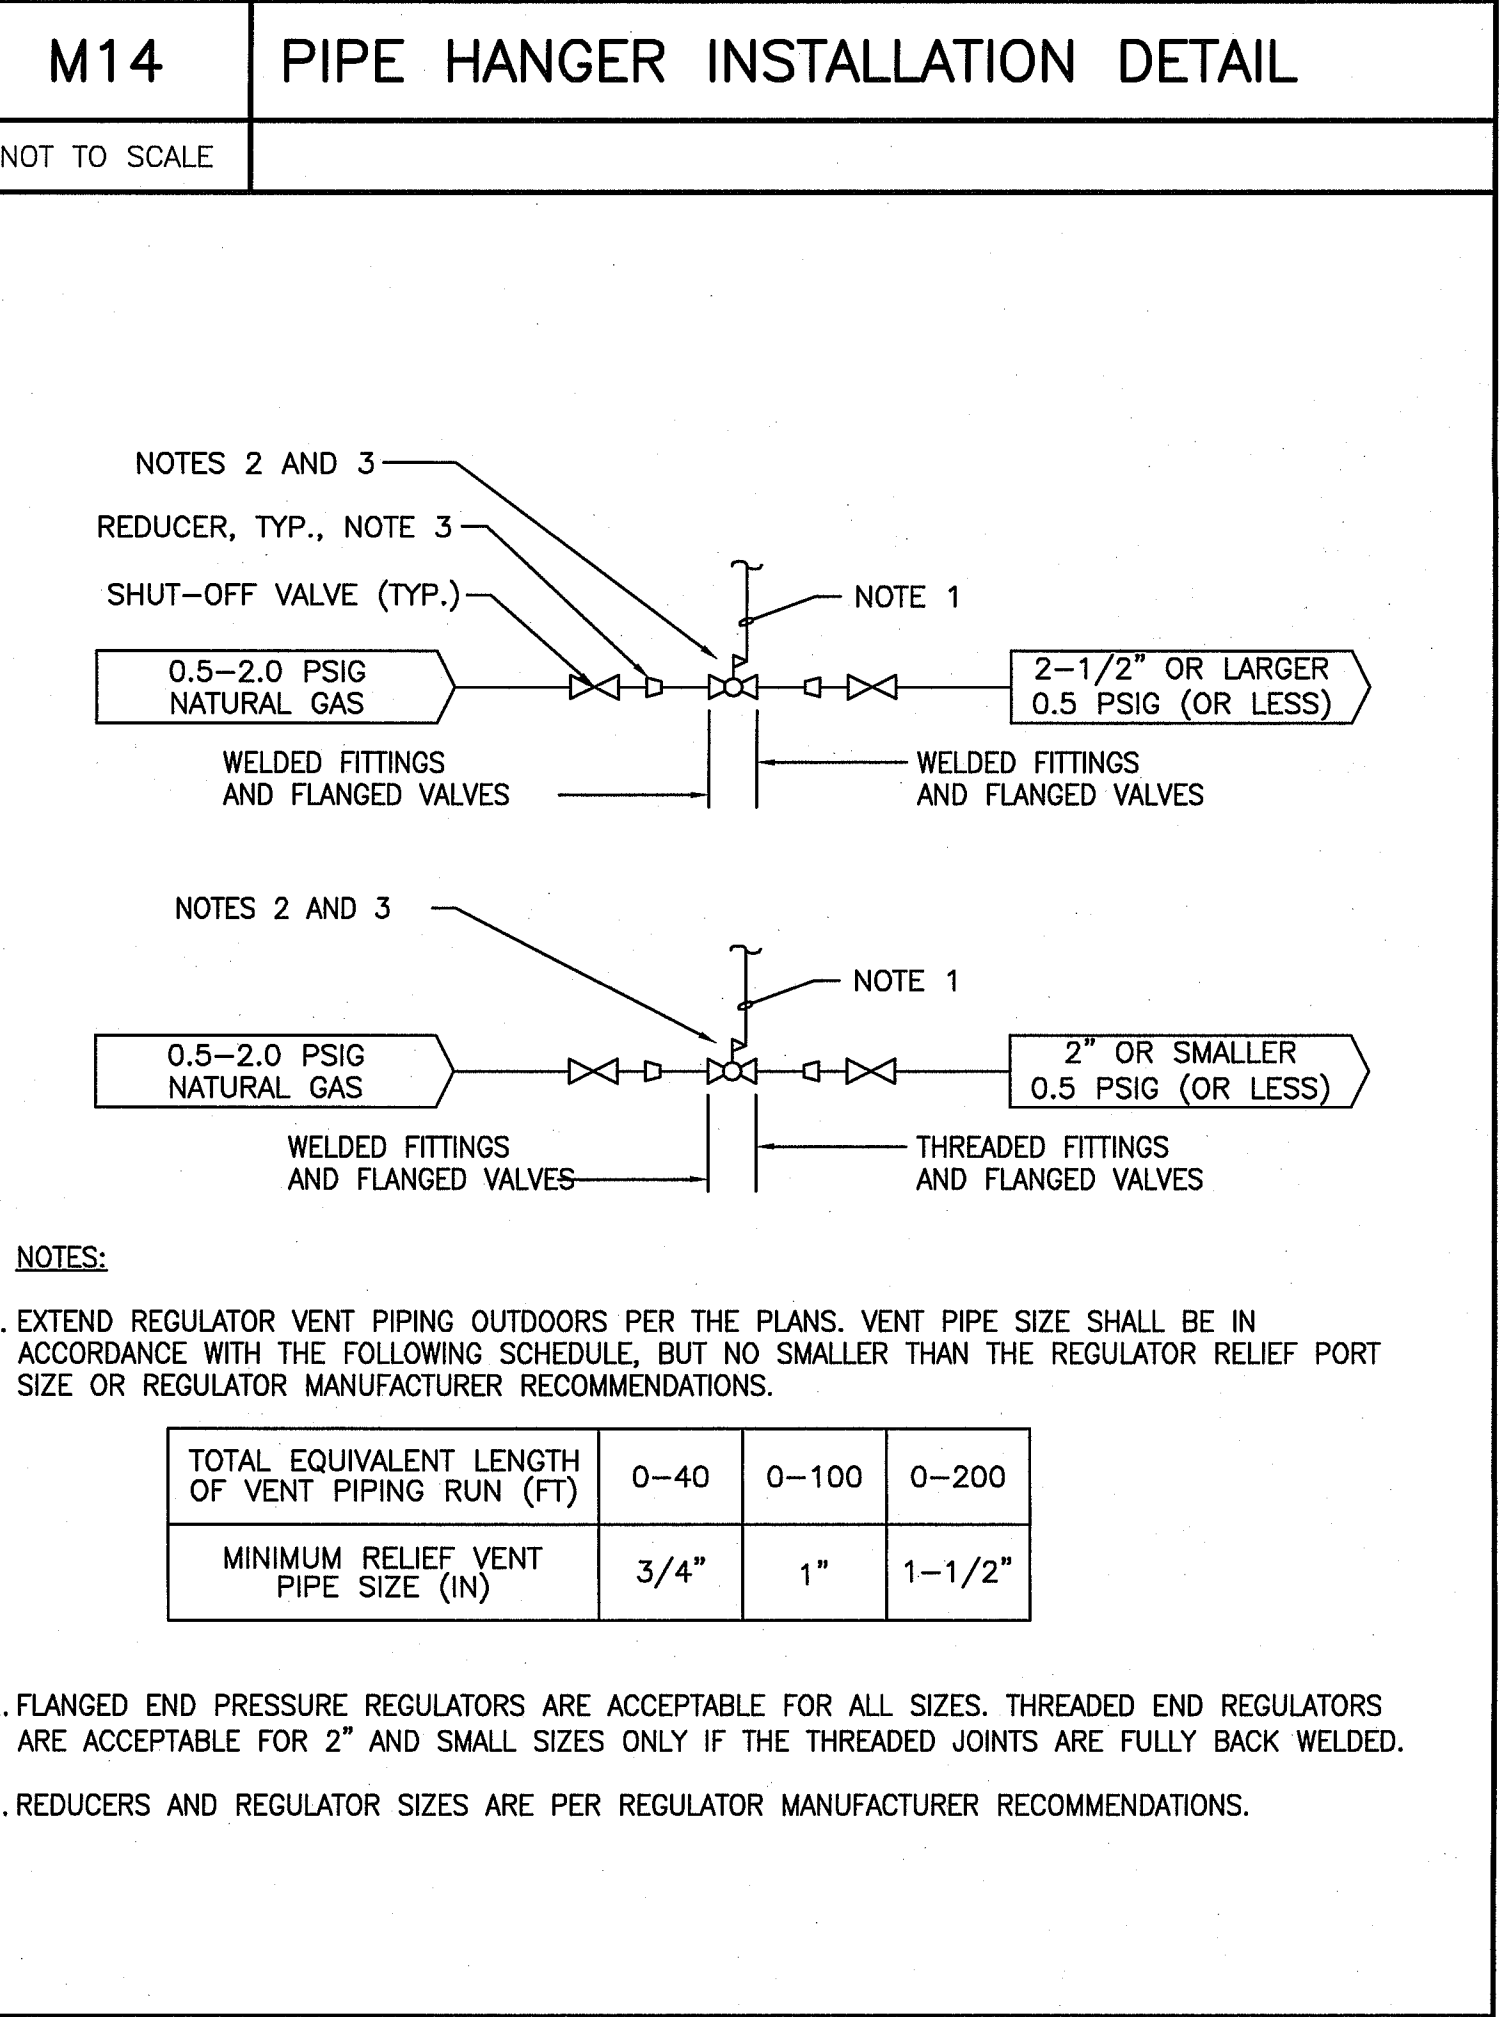
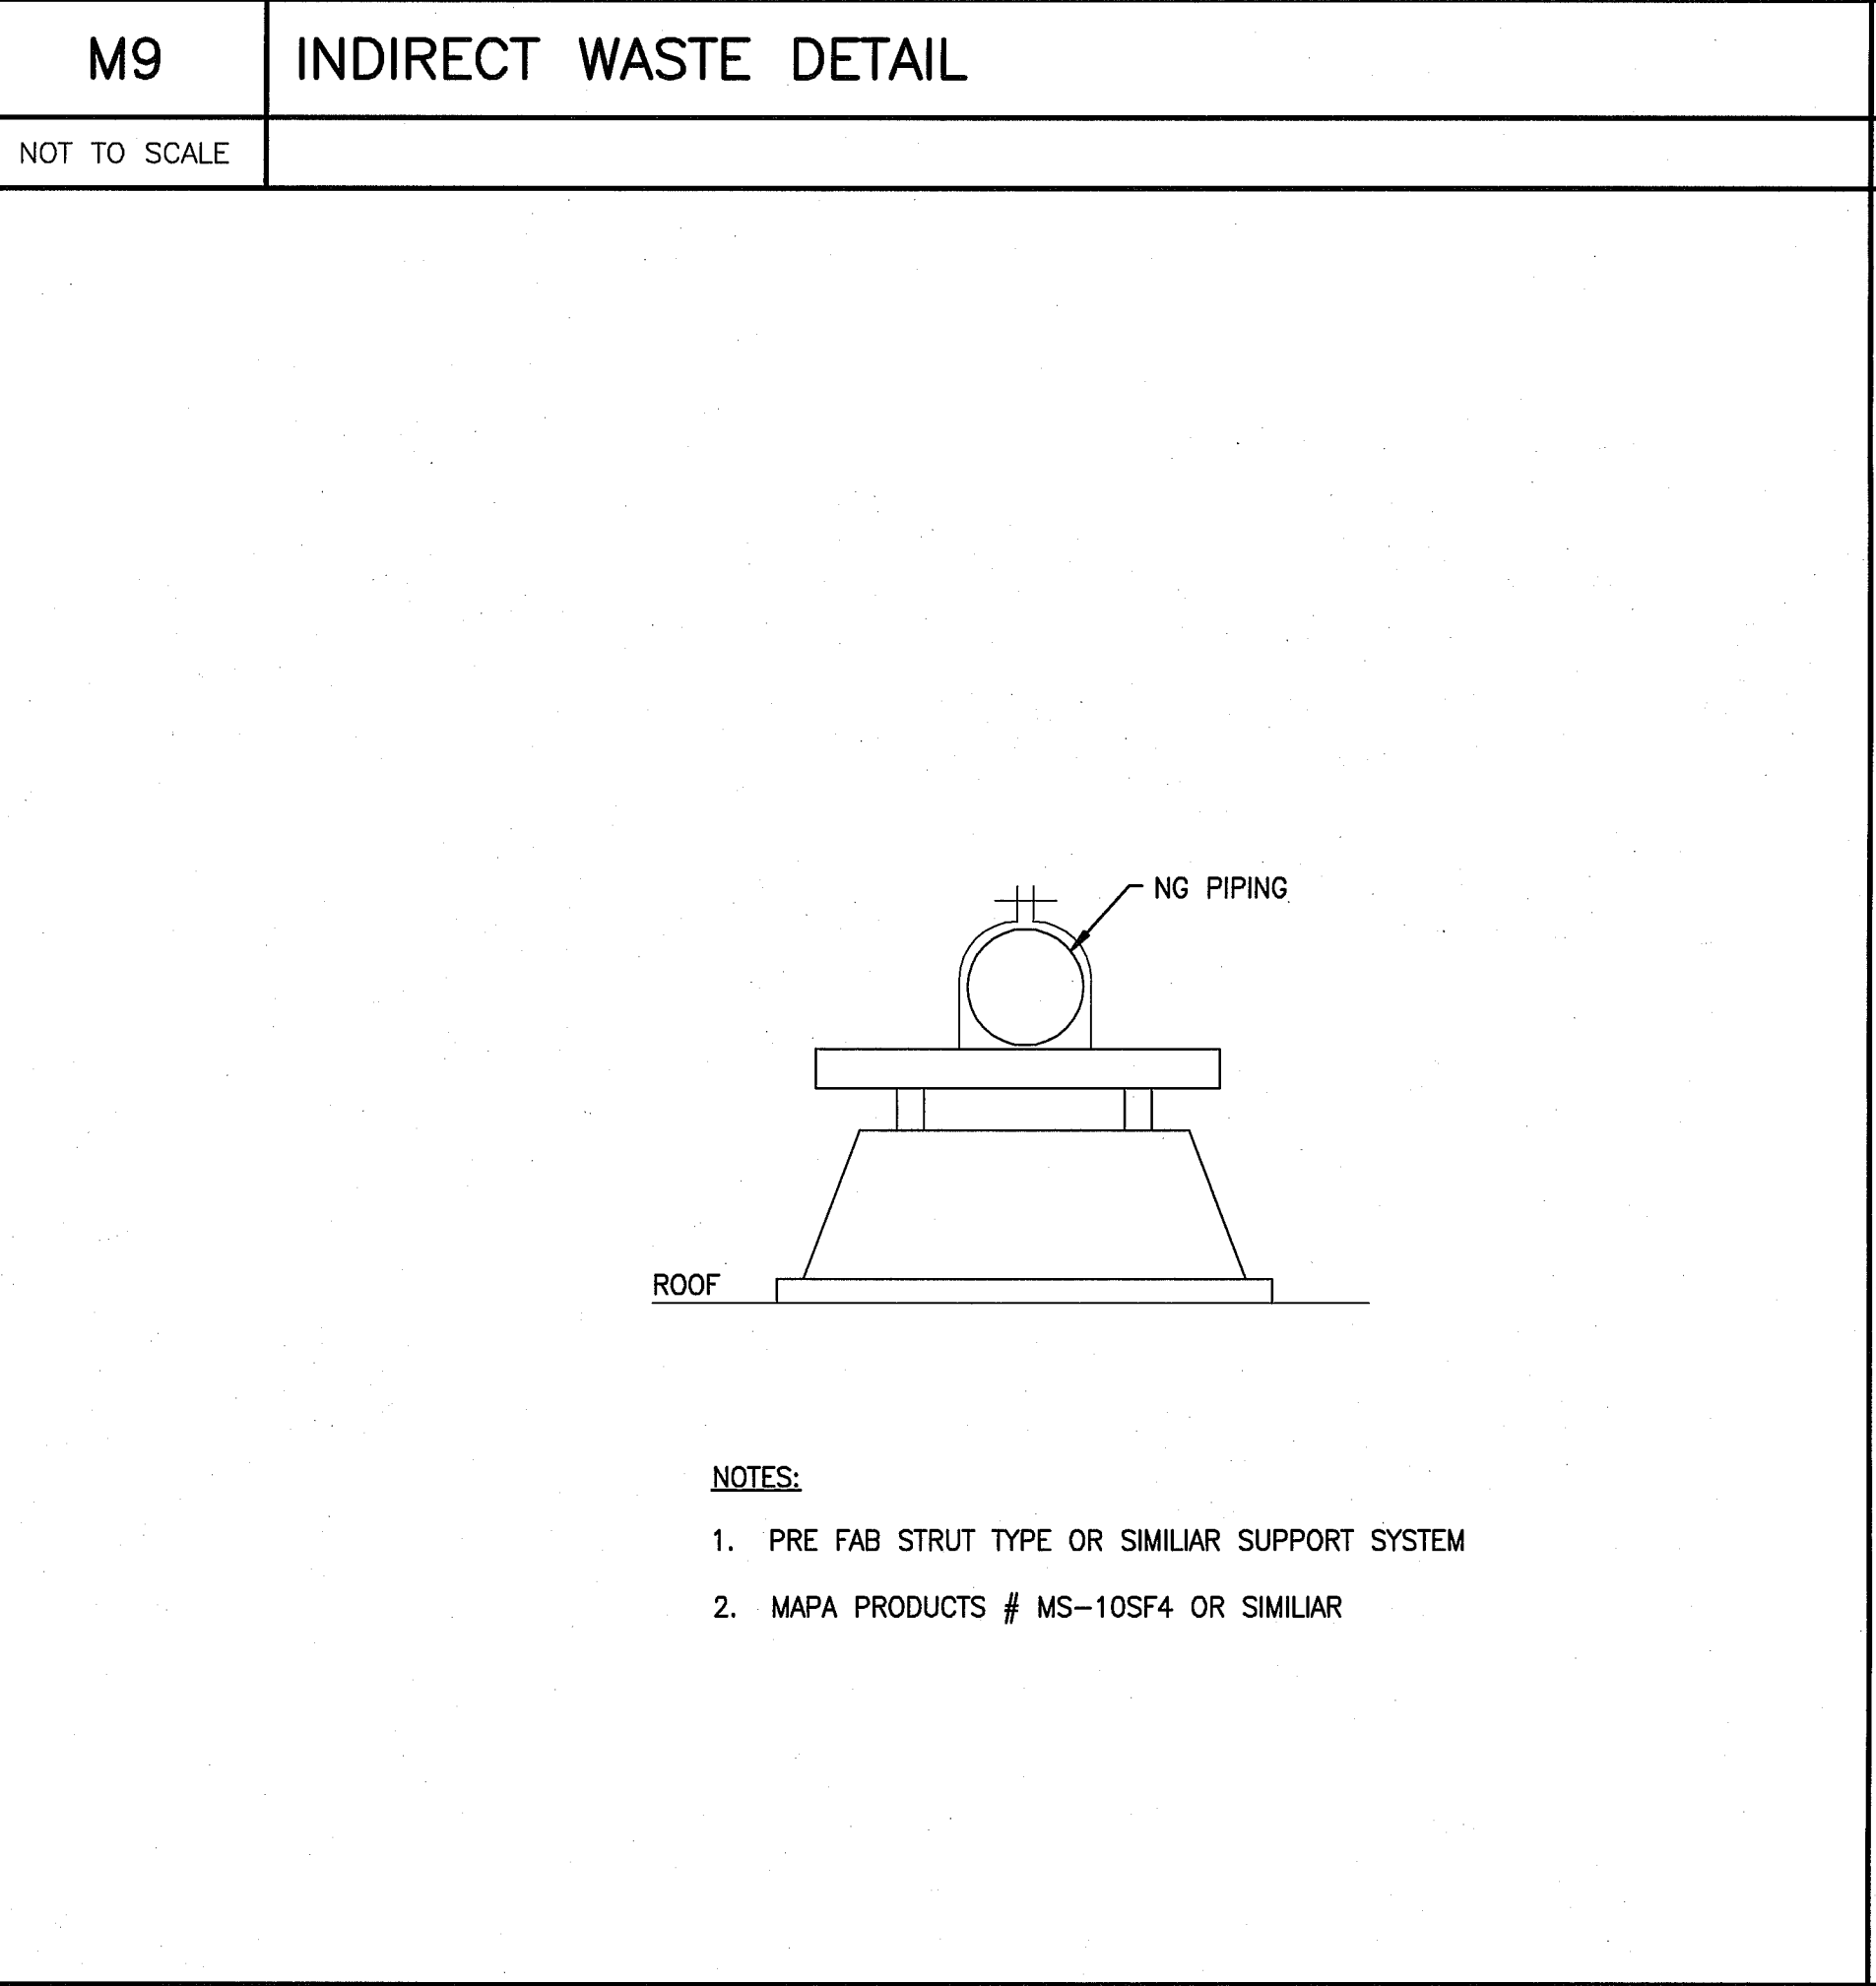





**NOTE:**  
1. SEE SHEET PL001 FOR LEGEND AND ABBREVIATIONS.

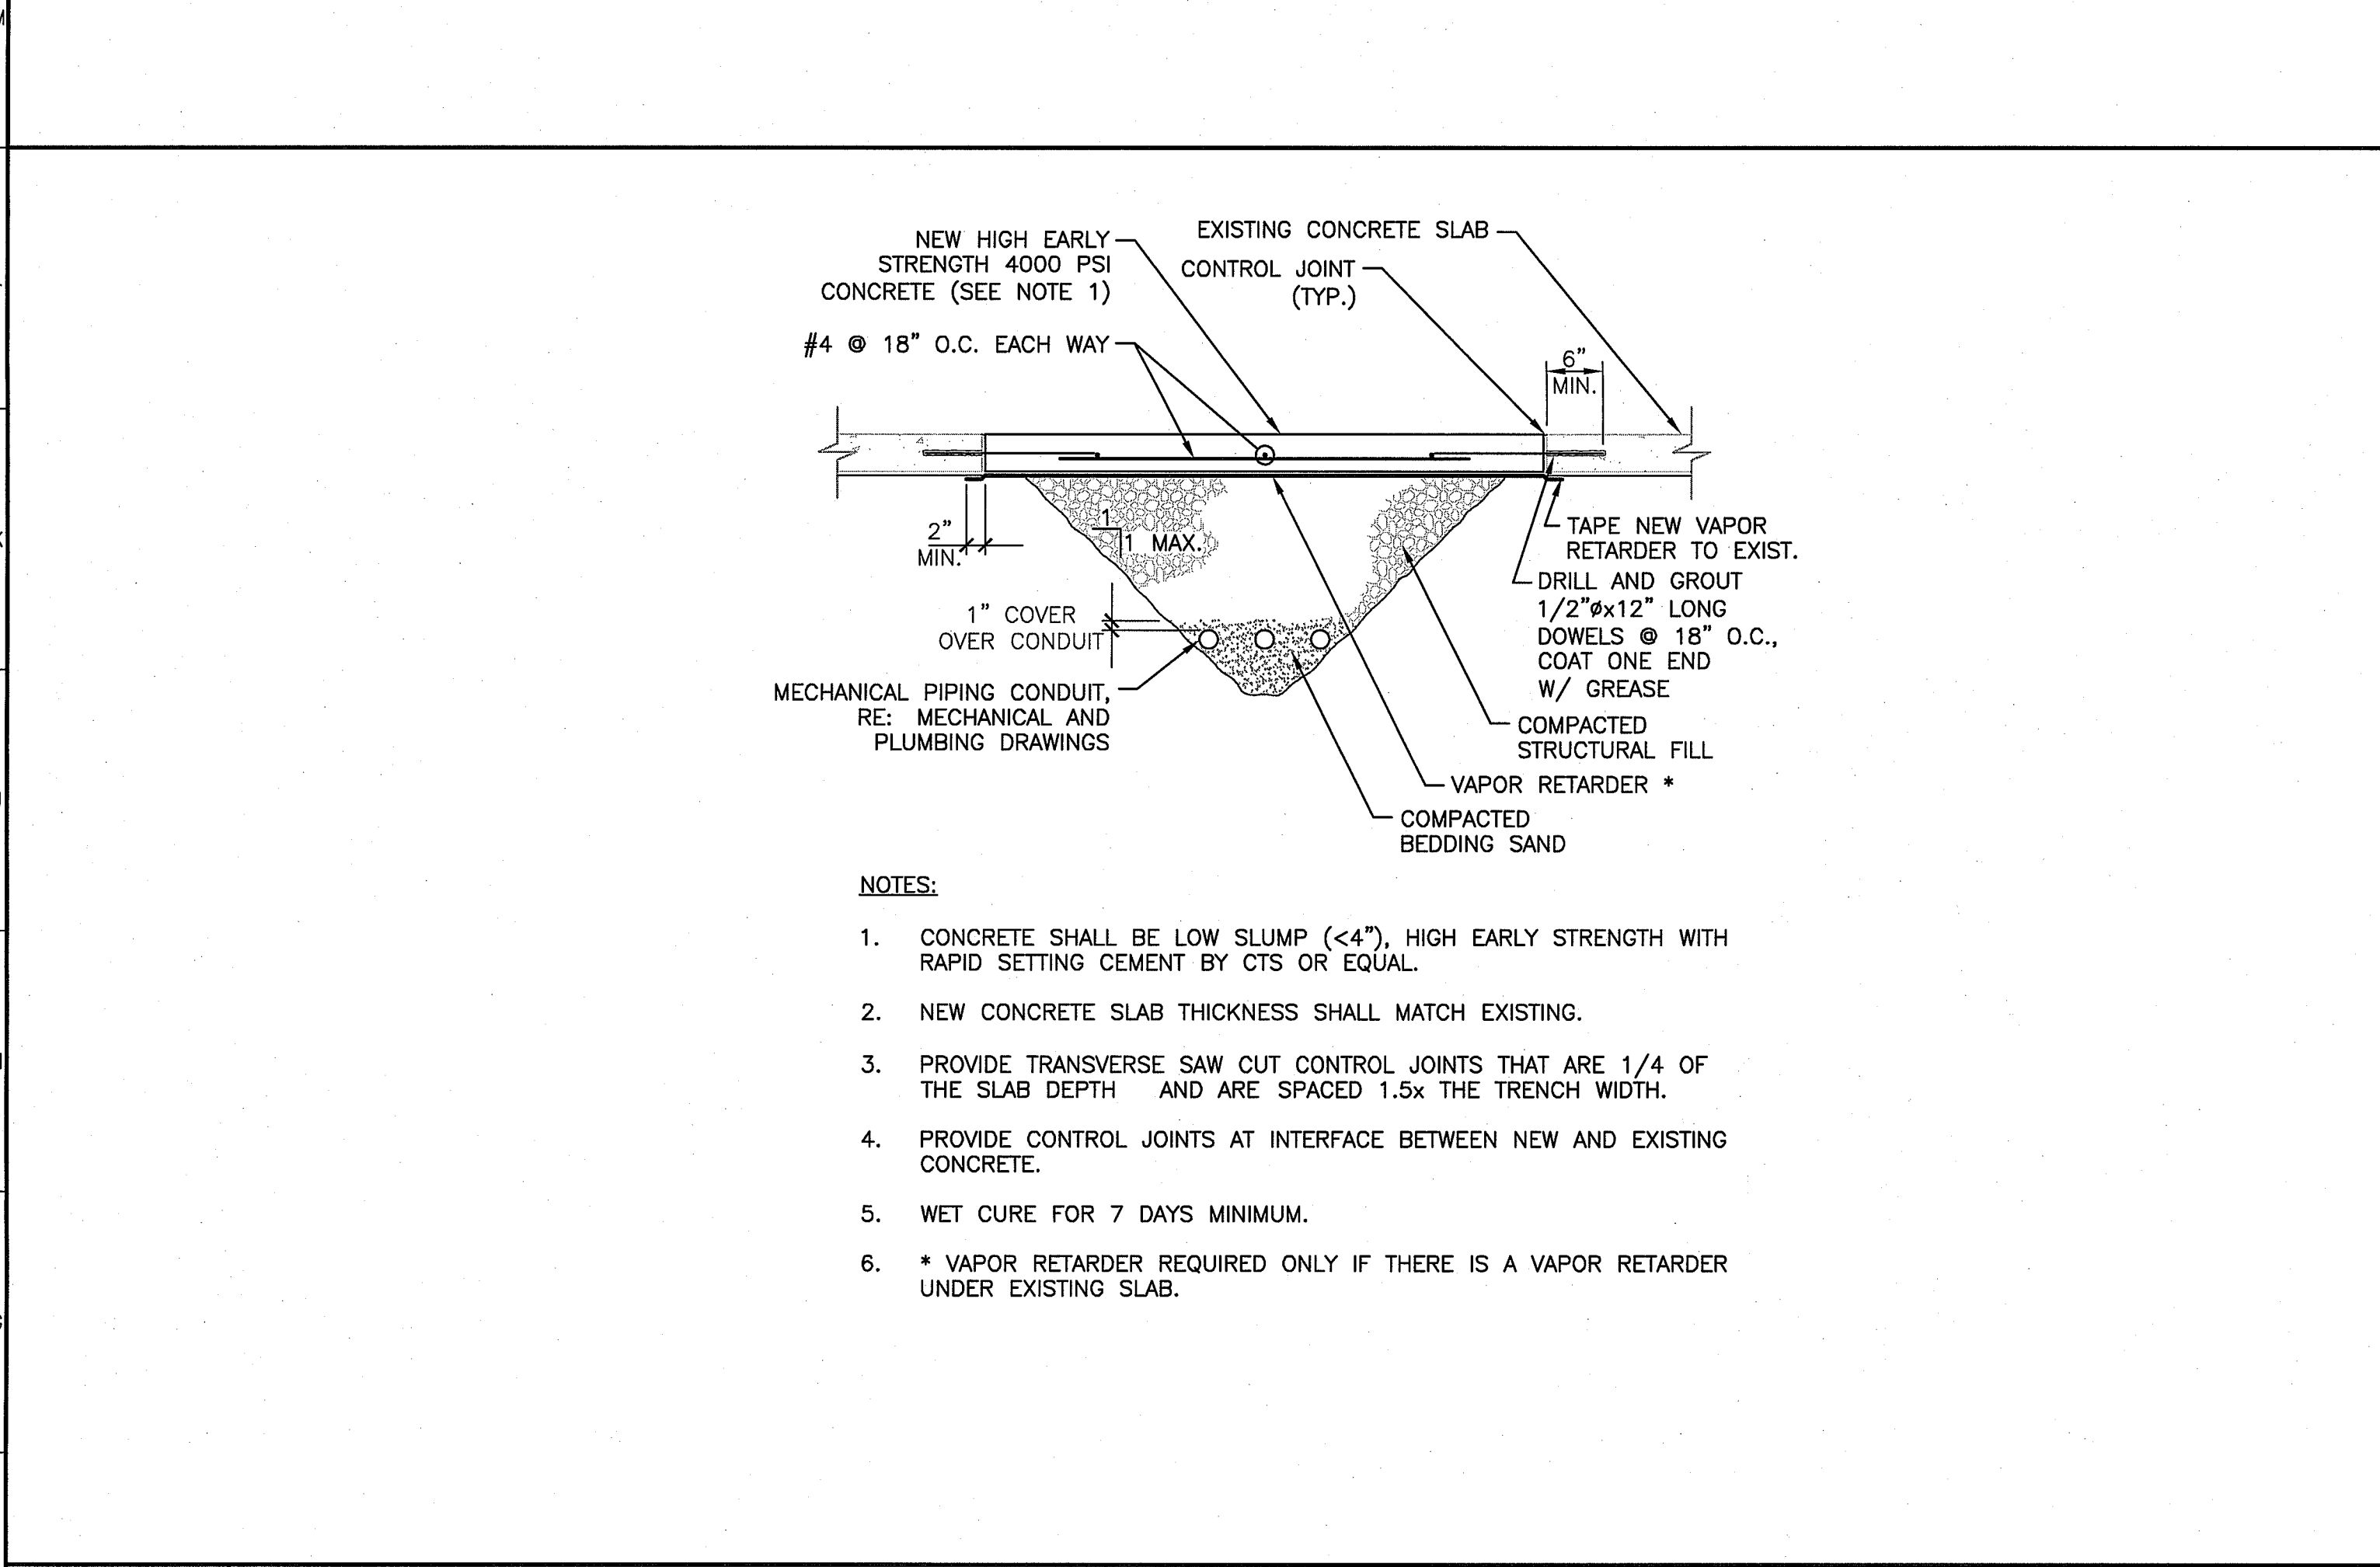

**NOTE:**  
1. EXTEND REGULATOR VENT PIPING OUTDOORS PER THE PLANS. VENT PIPE SIZE SHALL BE IN ACCORDANCE WITH THE FOLLOWING SCHEDULE, BUT NO SMALLER THAN THE REGULATOR RELIEF PORT SIZE OR REGULATOR MANUFACTURER RECOMMENDATIONS.

TOTAL EQUIVALENT LENGTH OF VENT PIPING RUN (FT)	0-40	0-100	0-200
MINIMUM RELIEF VENT PIPE SIZE (IN)	3/4"	1"	1-1/2"

2. FLANGED END PRESSURE REGULATORS ARE ACCEPTABLE FOR ALL SIZES. THREADED END REGULATORS ARE ACCEPTABLE FOR 2" AND SMALL SIZES ONLY IF THE THREADED JOINTS ARE FULLY BACK WELDED.  
3. REDUCERS AND REGULATOR SIZES ARE PER REGULATOR MANUFACTURER RECOMMENDATIONS.

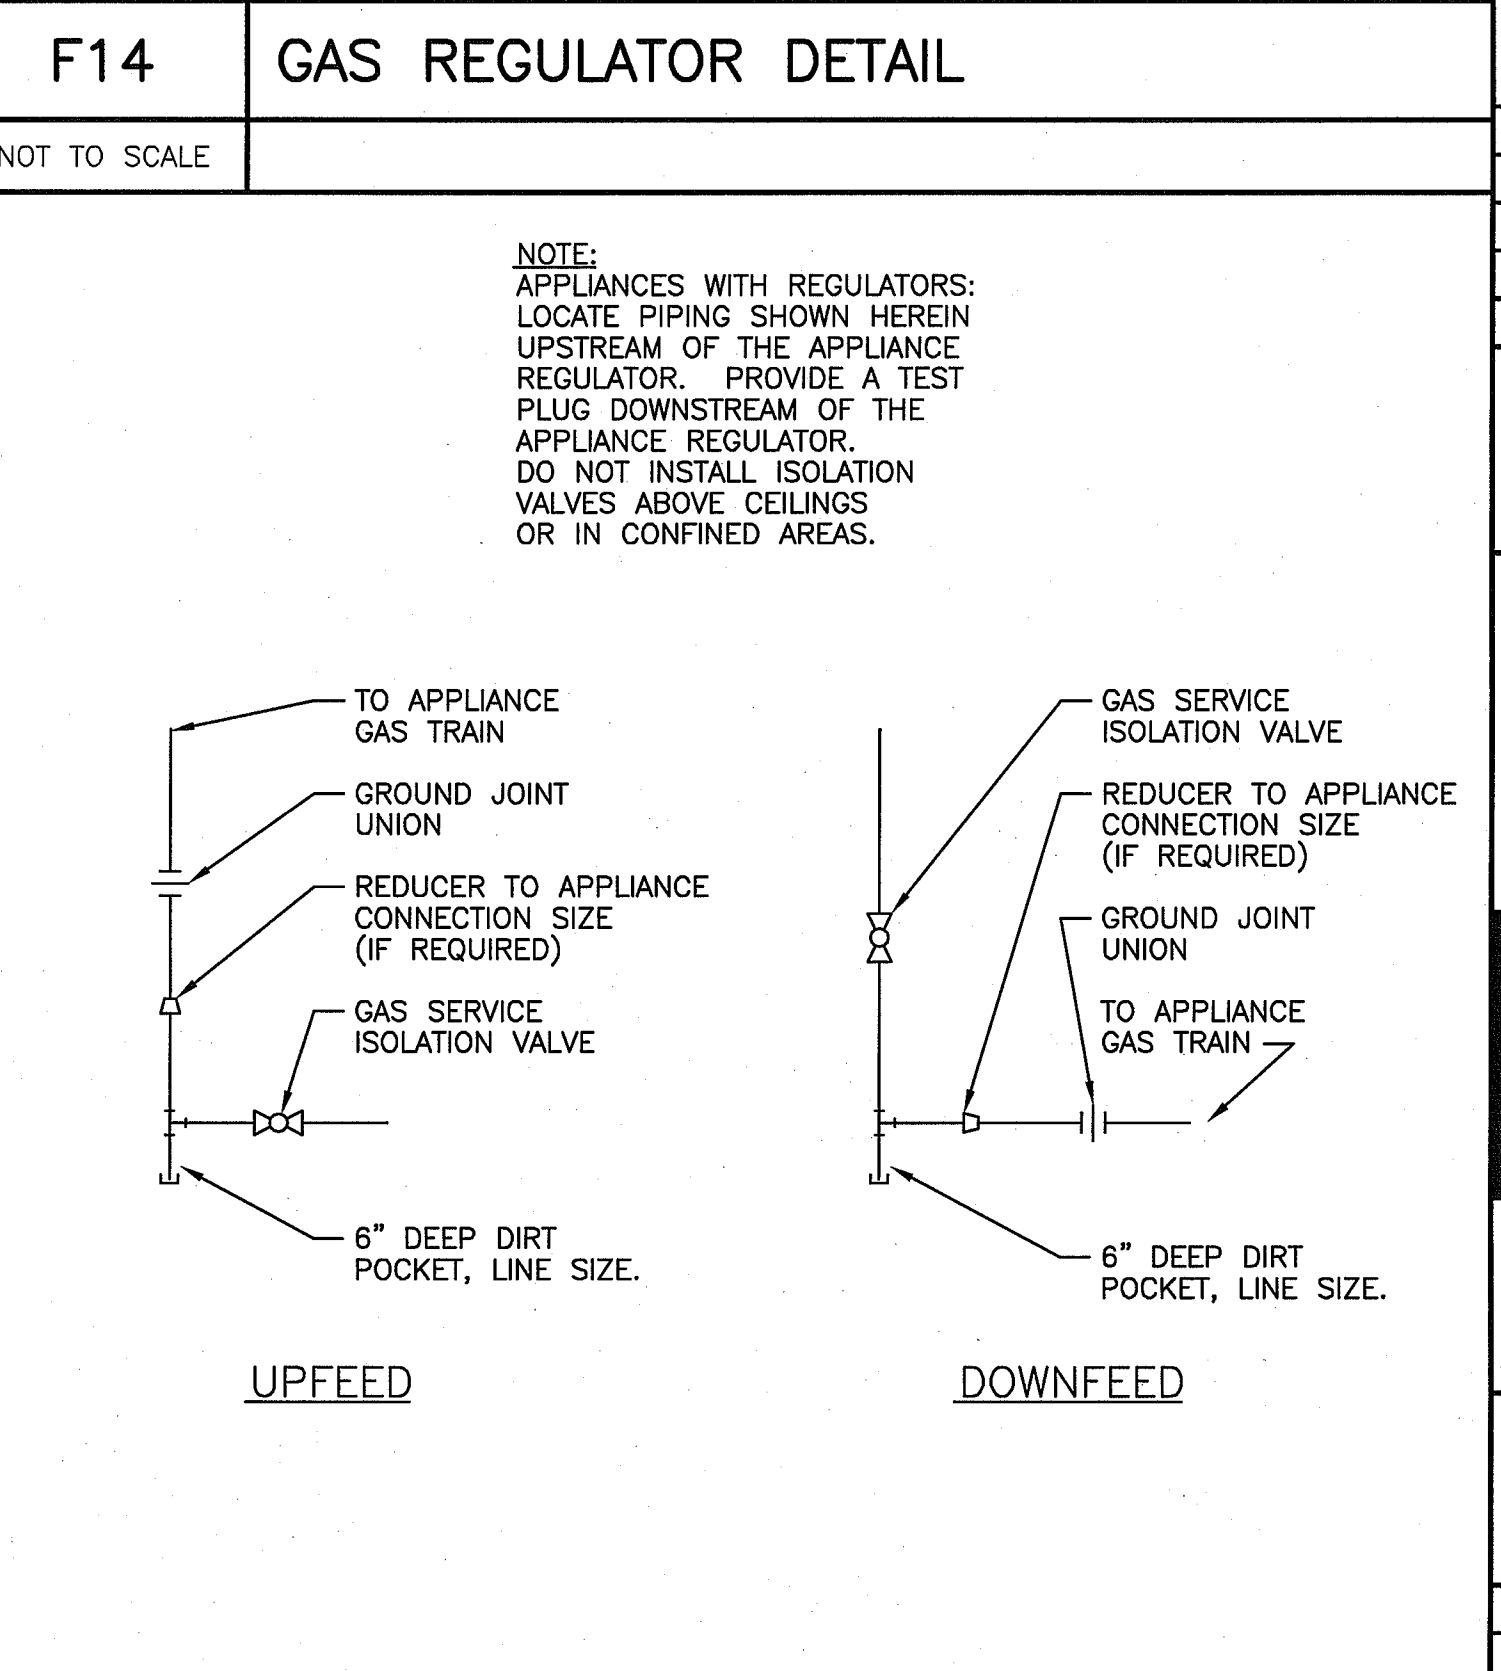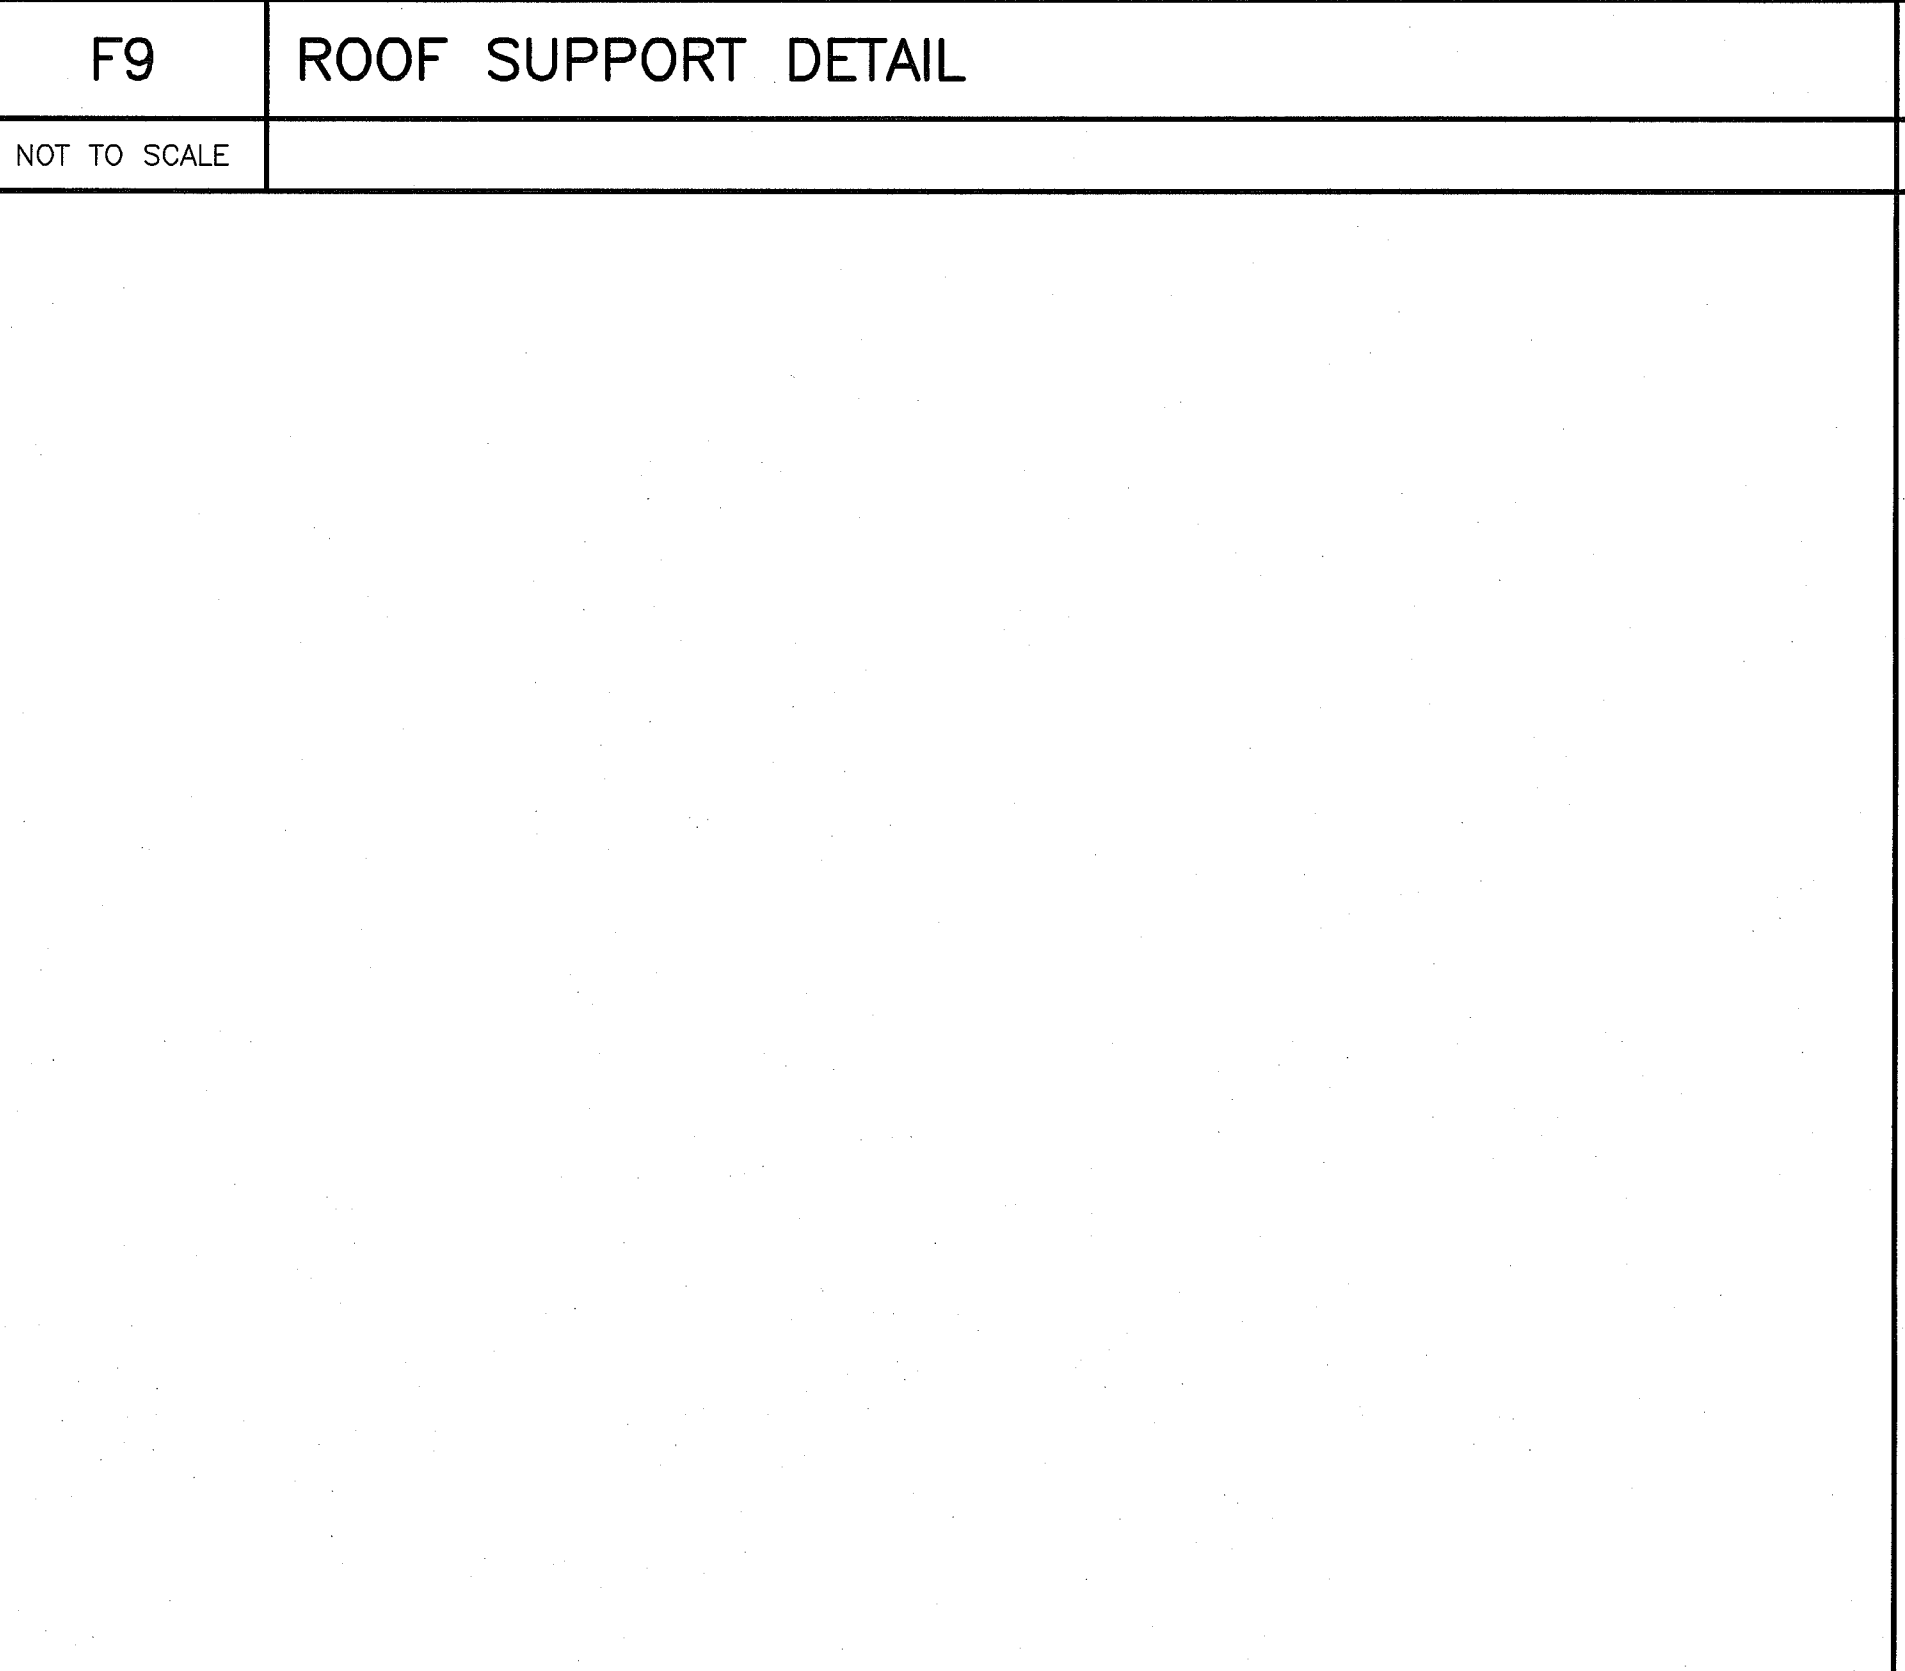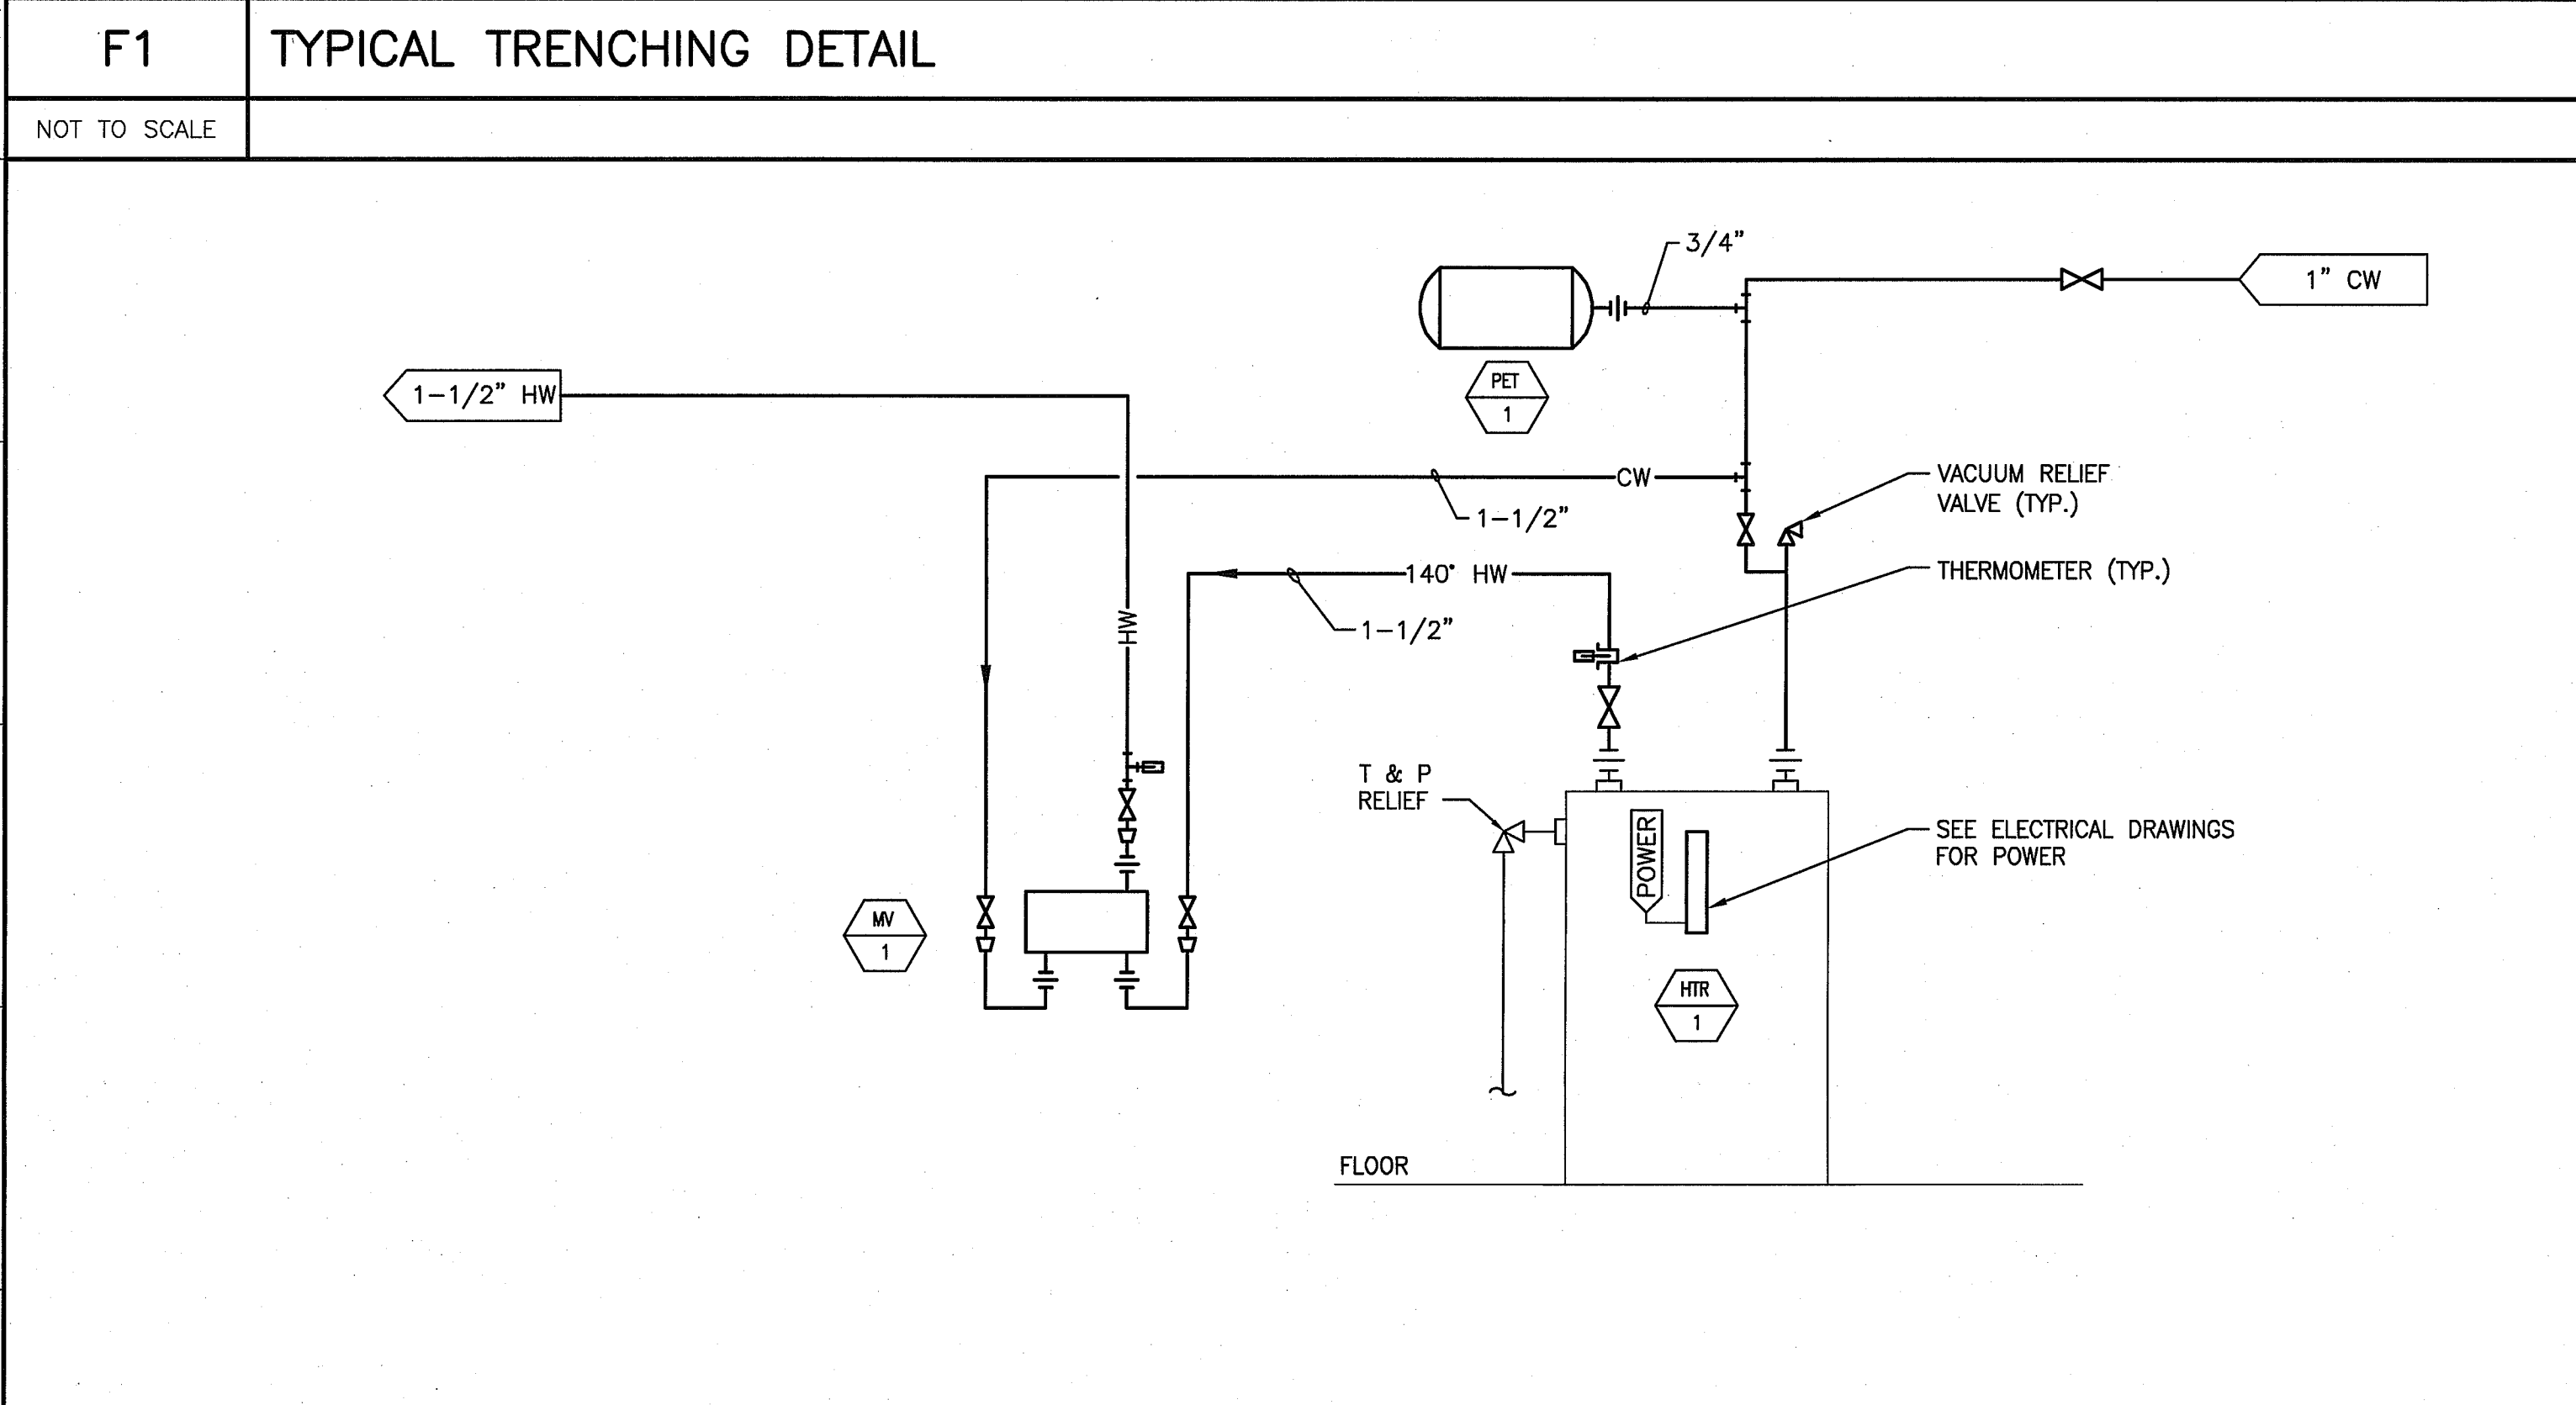

**CONFORMED SET**  
4-21-15

CURRENT ISSUE STATUS:

REV.	DESCRIPTION	DATE
1	CONFORMED SET	4-21-15
0	ISSUED FOR CONSTRUCTION	3-3-15

ARCHITECTURE  
ENGINEERING  
PLANNING  
INTERIOR DESIGN  
COMMISSIONING

**SMRT**  
L.L. BEAN  
CHESHIRE BUILDING RENOVATIONS  
PORTLAND, MAINE

144 Fore Street/P.O. Box 618  
Portland, Maine 04104  
tel. (207) 772-3846  
fax. (207) 772-1070  
www.smrtinc.com

**PLUMBING DETAILS**

SHEET TITLE:  
SCALE: 1/8"=1'-0" DATE: 3-3-15  
PROJECT MANAGER: JH GRAPHIC SCALE: 0"=1"  
JOB CAP/DRAWN: CAH/KPB  
A/E OF RECORD: CJM SHEET No.  
SMRT CAD FILE: PL501-14199  
PROJECT No. 14199-00

**PL501**

**A1** DOMESTIC WATER HEATER SCHEMATIC

**F9** ROOF SUPPORT DETAIL

**F14** GAS REGULATOR DETAIL

**A14** GAS CONNECTION DETAIL