



J1	--	J4	--
NTS	-	NTS	-

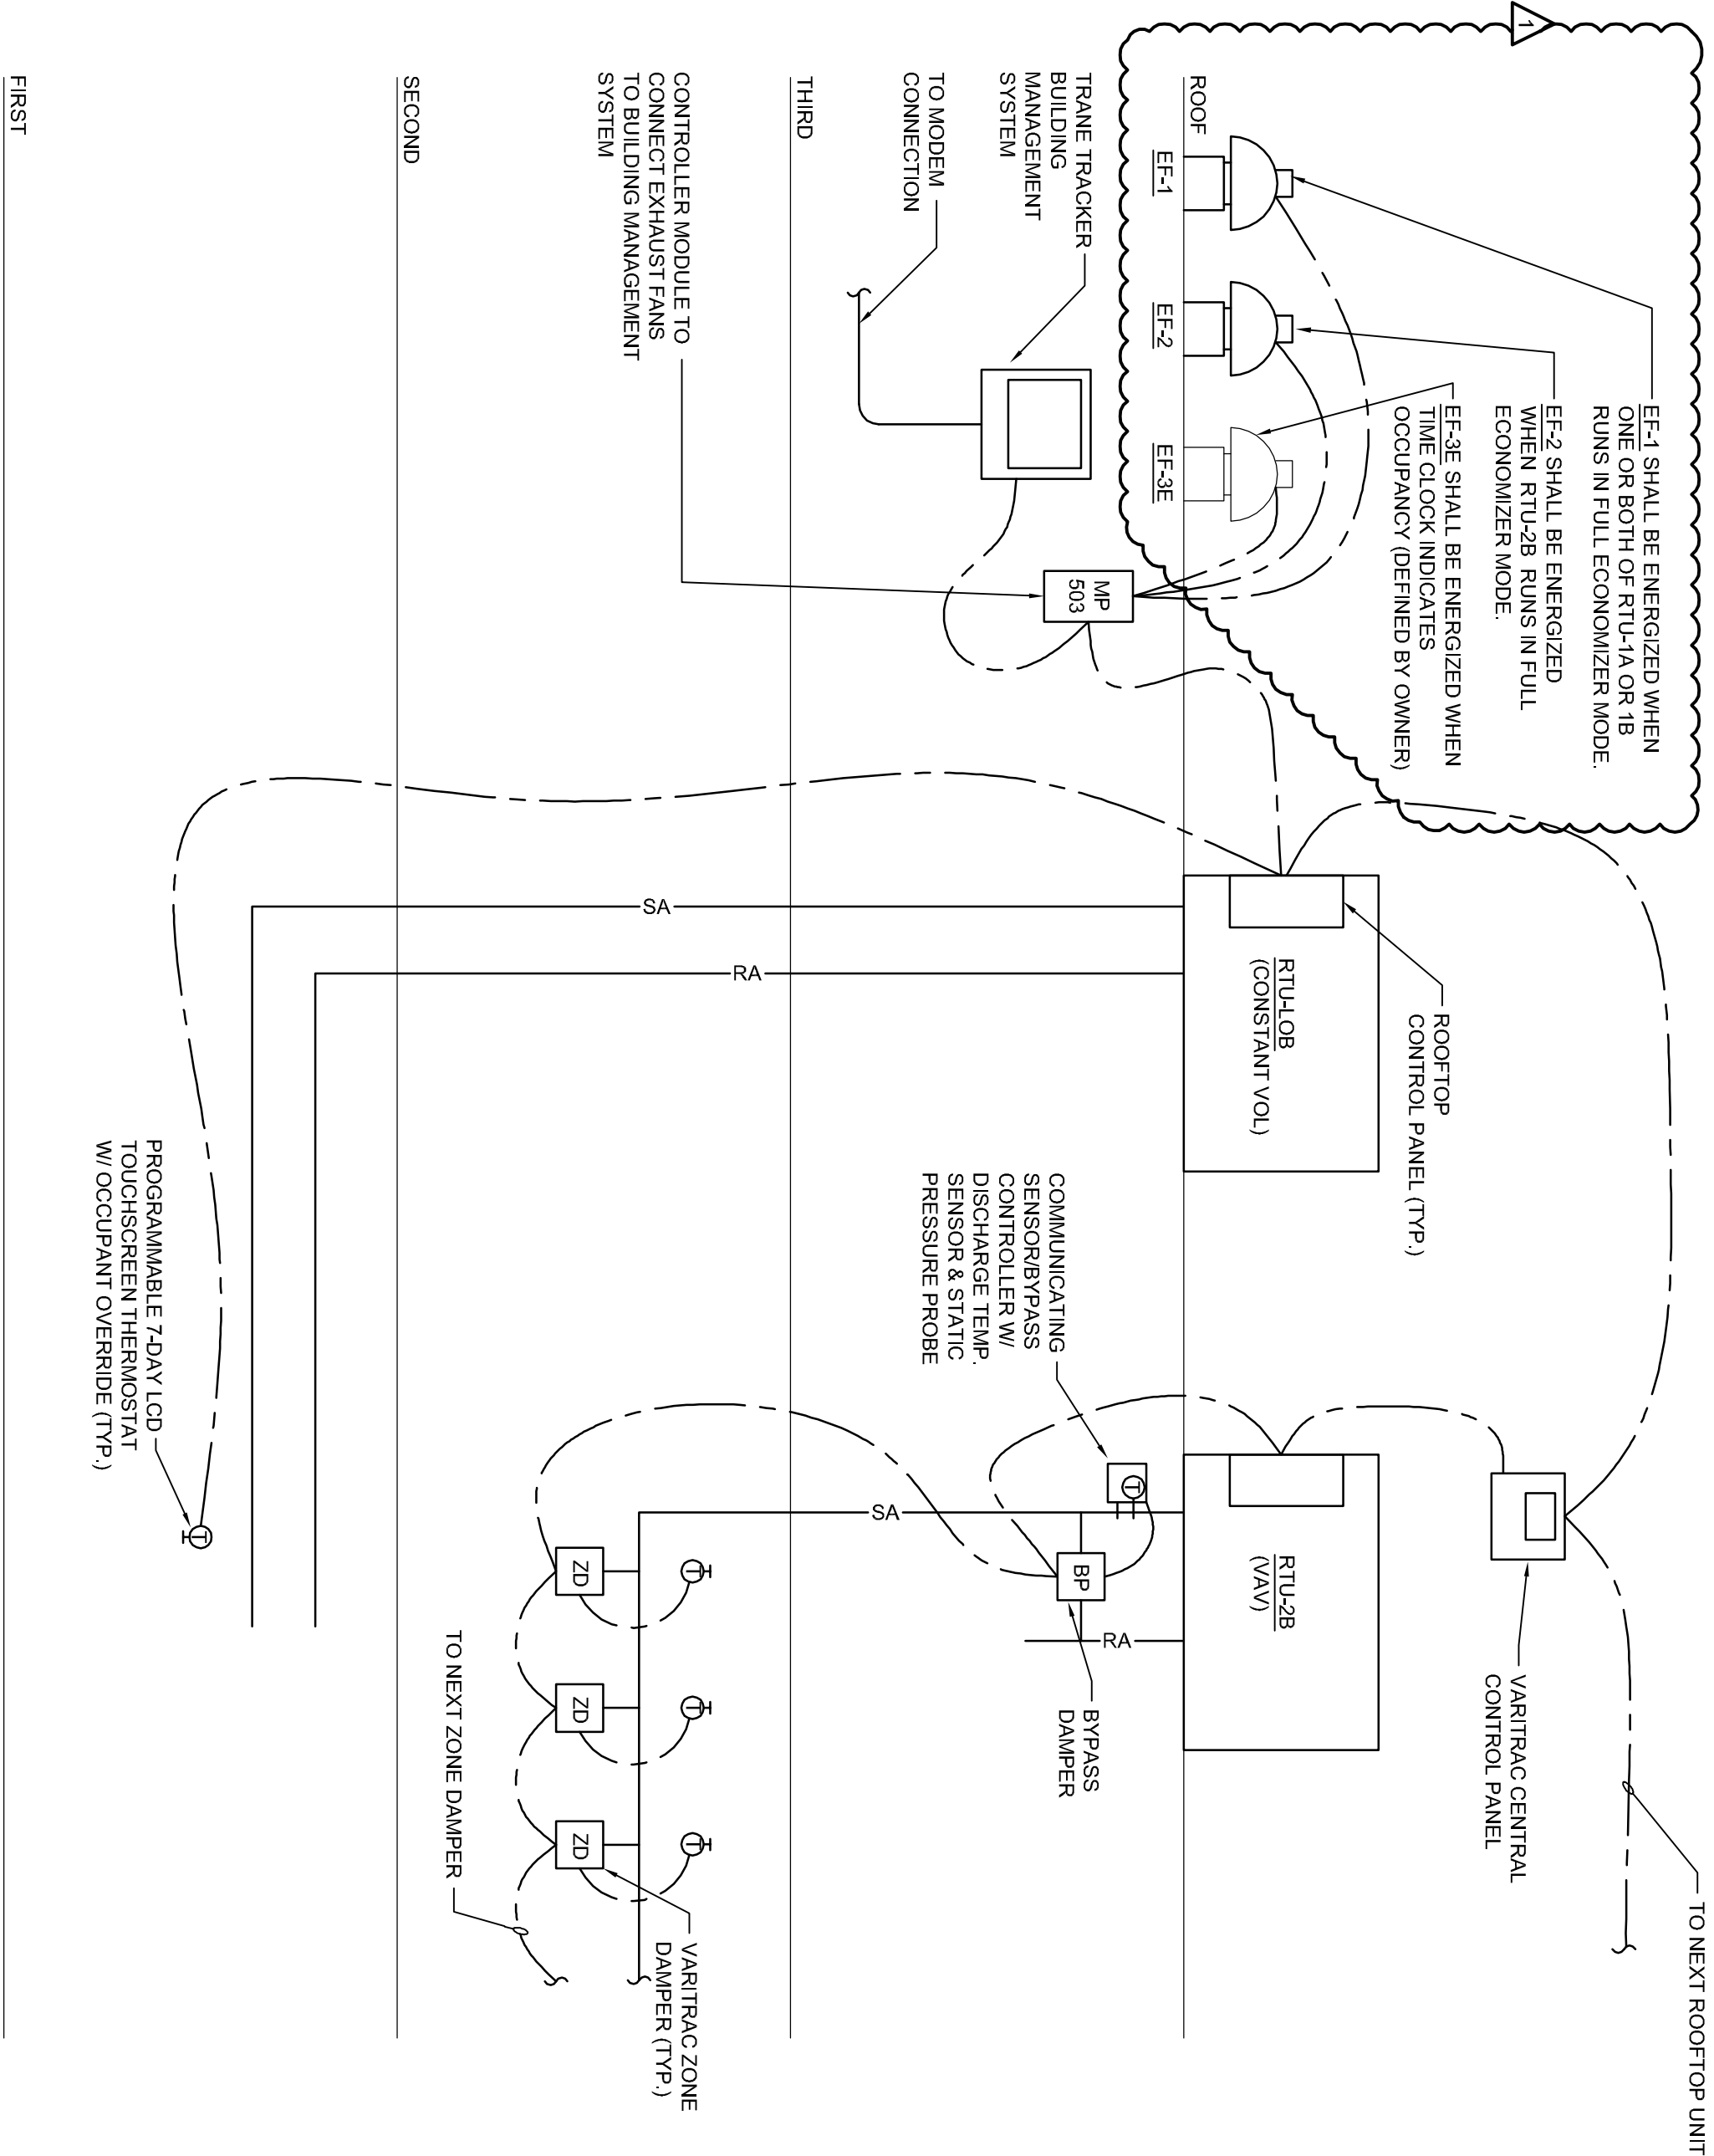


A1	BUILDING CONTROL SYSTEM SCHEMATIC
NTS	-


J8	--
NTS	-

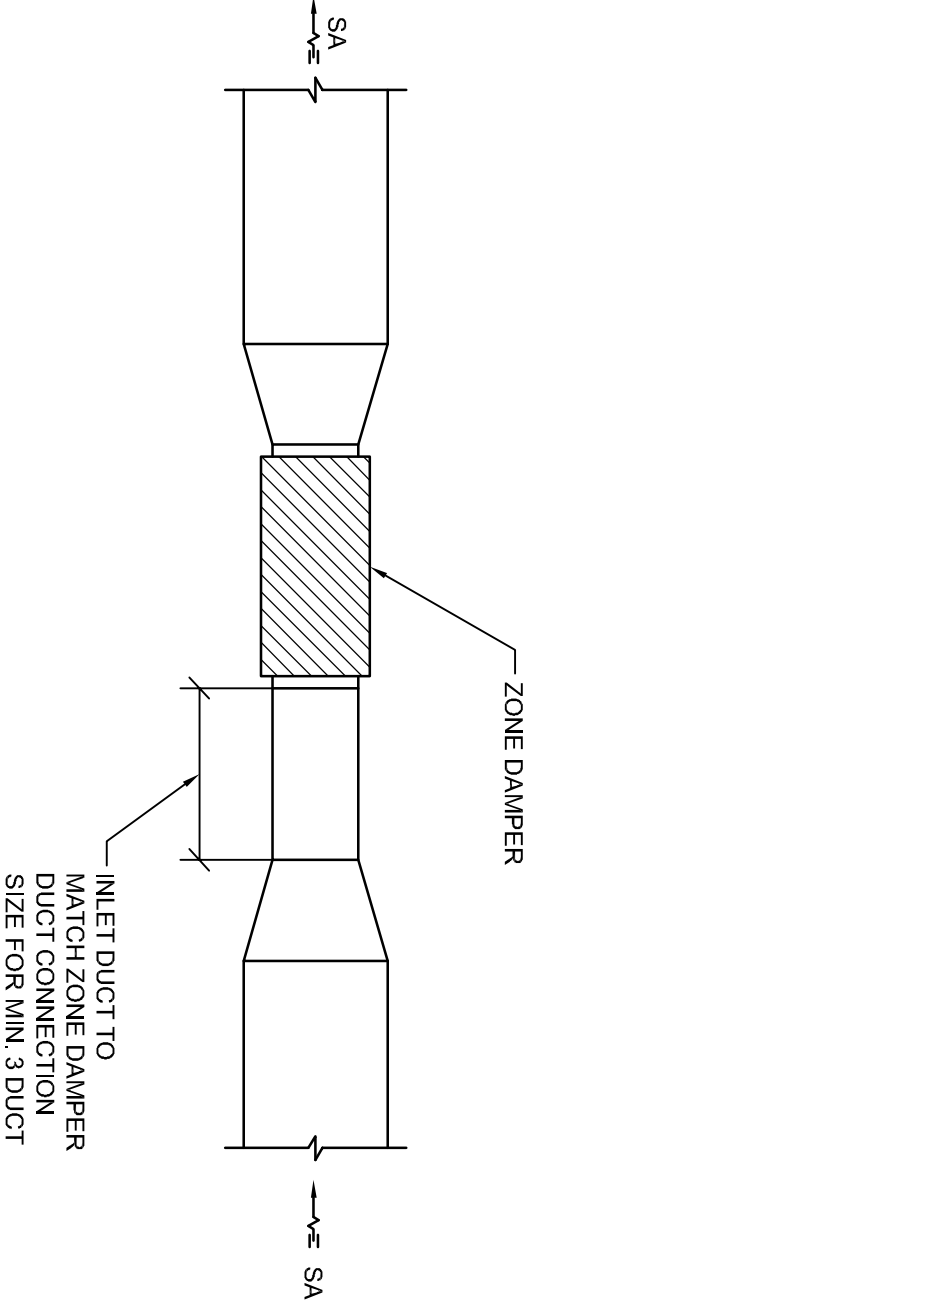


A8	NATURAL GAS PIPING SCHEMATIC
NTS	-

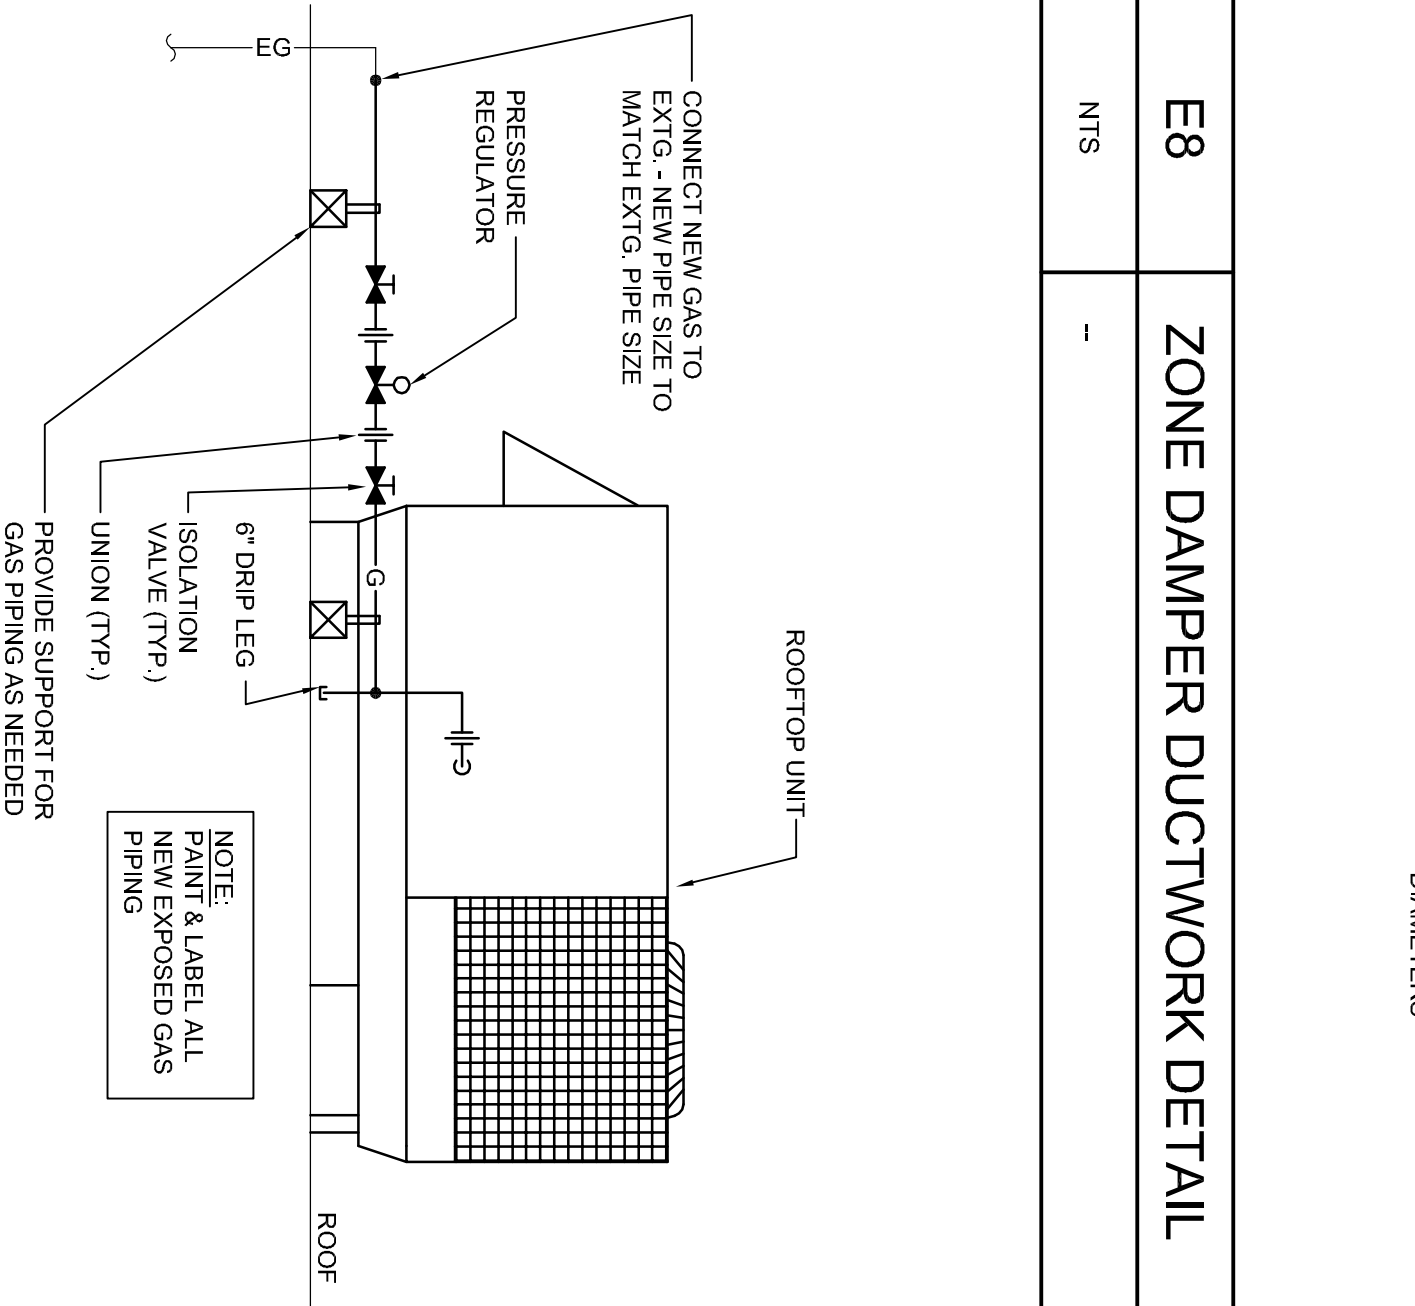


J11	PLENUM RETURN GRILLE DETAIL
NTS	-

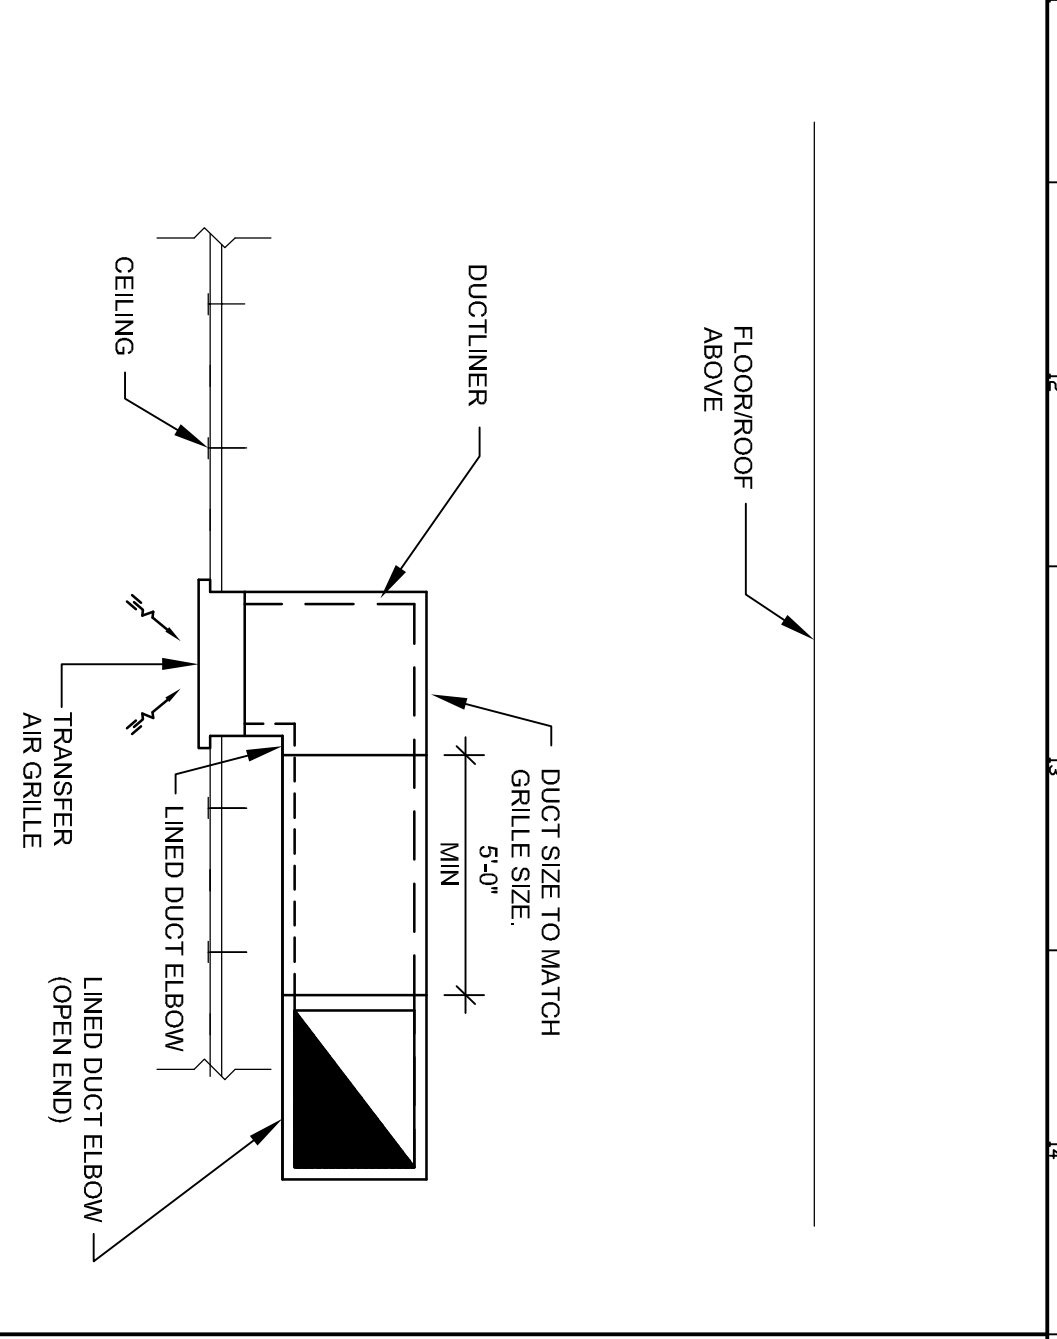

E11	ROOFTOP UNIT W/ BYPASS DAMPER DETAIL
NTS	-

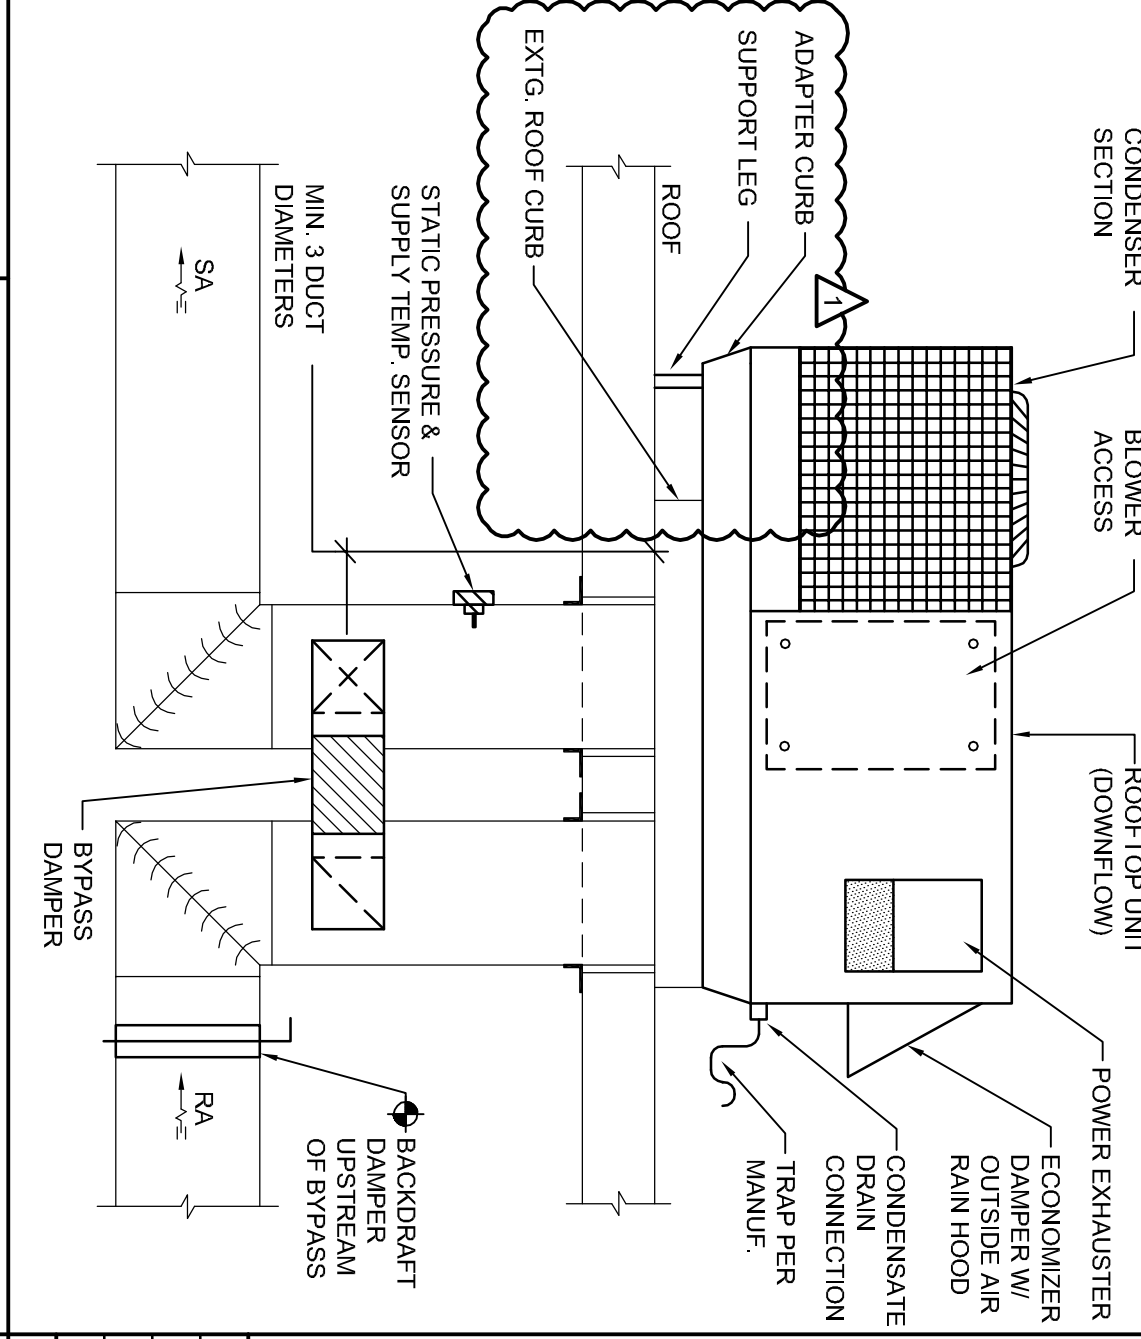

A11	TYP. DIFFUSER/GRILLE DETAIL
NTS	-

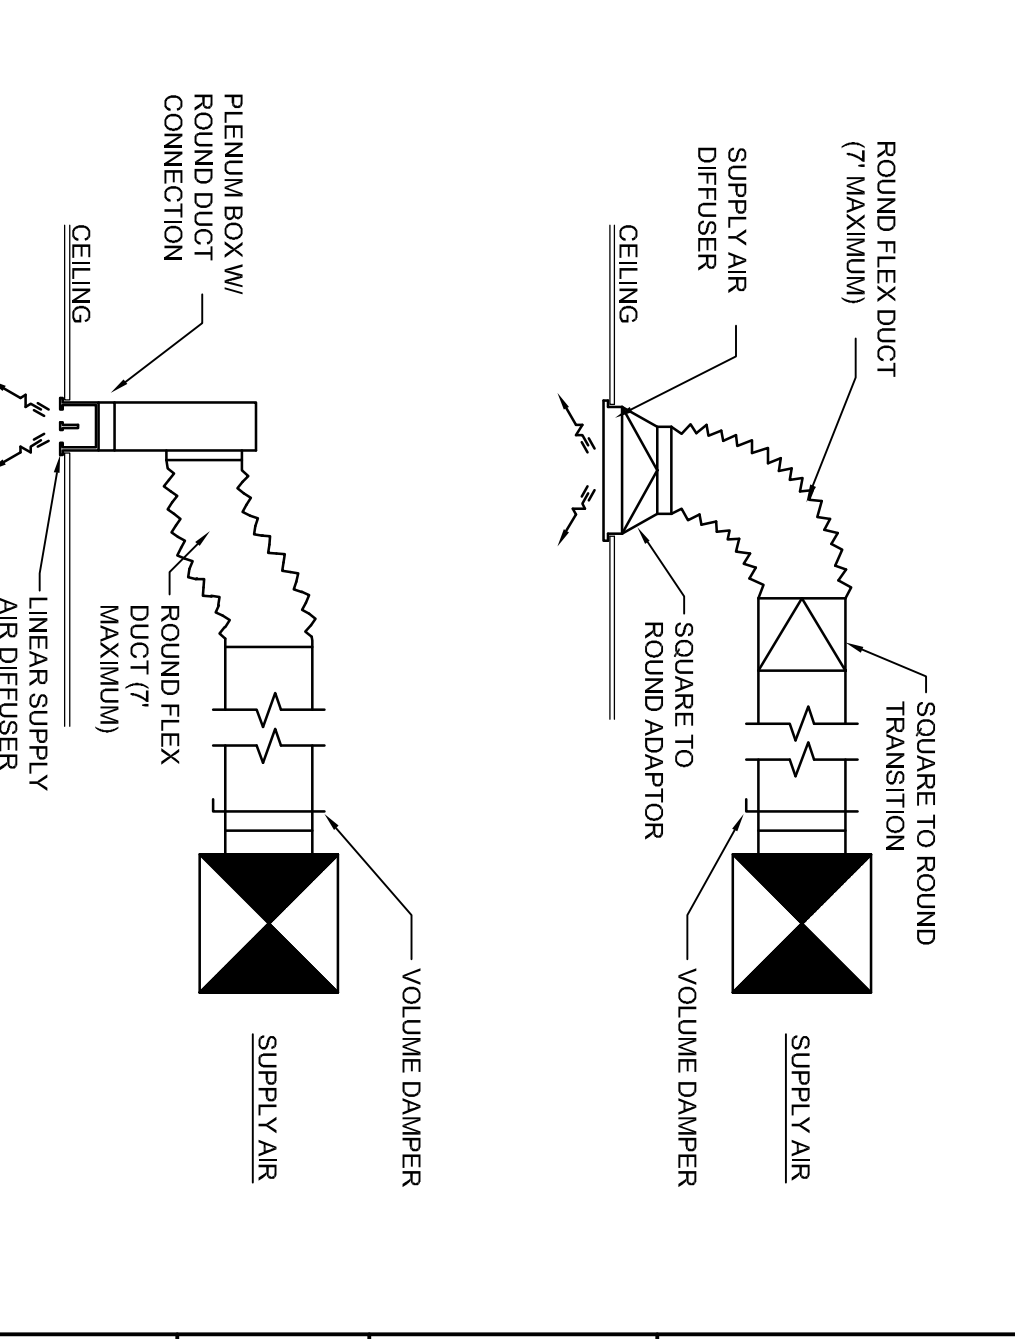

CONSTRUCTION DOCUMENTS	
10.18.10	
REV.	DESCRIPTION
1	REISSUED
0	CONSTRUCTION DOCS
DATE	10.18.10

WBRC
 ARCHITECTS • ENGINEERS
 BANGOR, MAINE 04907-2411
 PORTLAND, ME 04106-1101
 SAKSOTLA, FLORIDA 941-556-0757
 WWW.WBRC.AE.COM

PROJECT: MARTIN'S POINT HEALTH CARE NORTHPORT PLAZA HVAC RENOVATIONS PORTLAND, ME
 MECHANICAL DETAILS

SHEET TITLE: 3626.00 - M-501
 PROJECT No.: 3626.00
 SCALE: AS NOTED
 DRAWN BY: CGJ
 CHECKED BY: RLR
 DATE OF RECORD: 10/18/10

STATE OF MAINE
 ROLINS, RICHARD
 LICENSED PROFESSIONAL ENGINEER
 ID: 22,10

M-501