






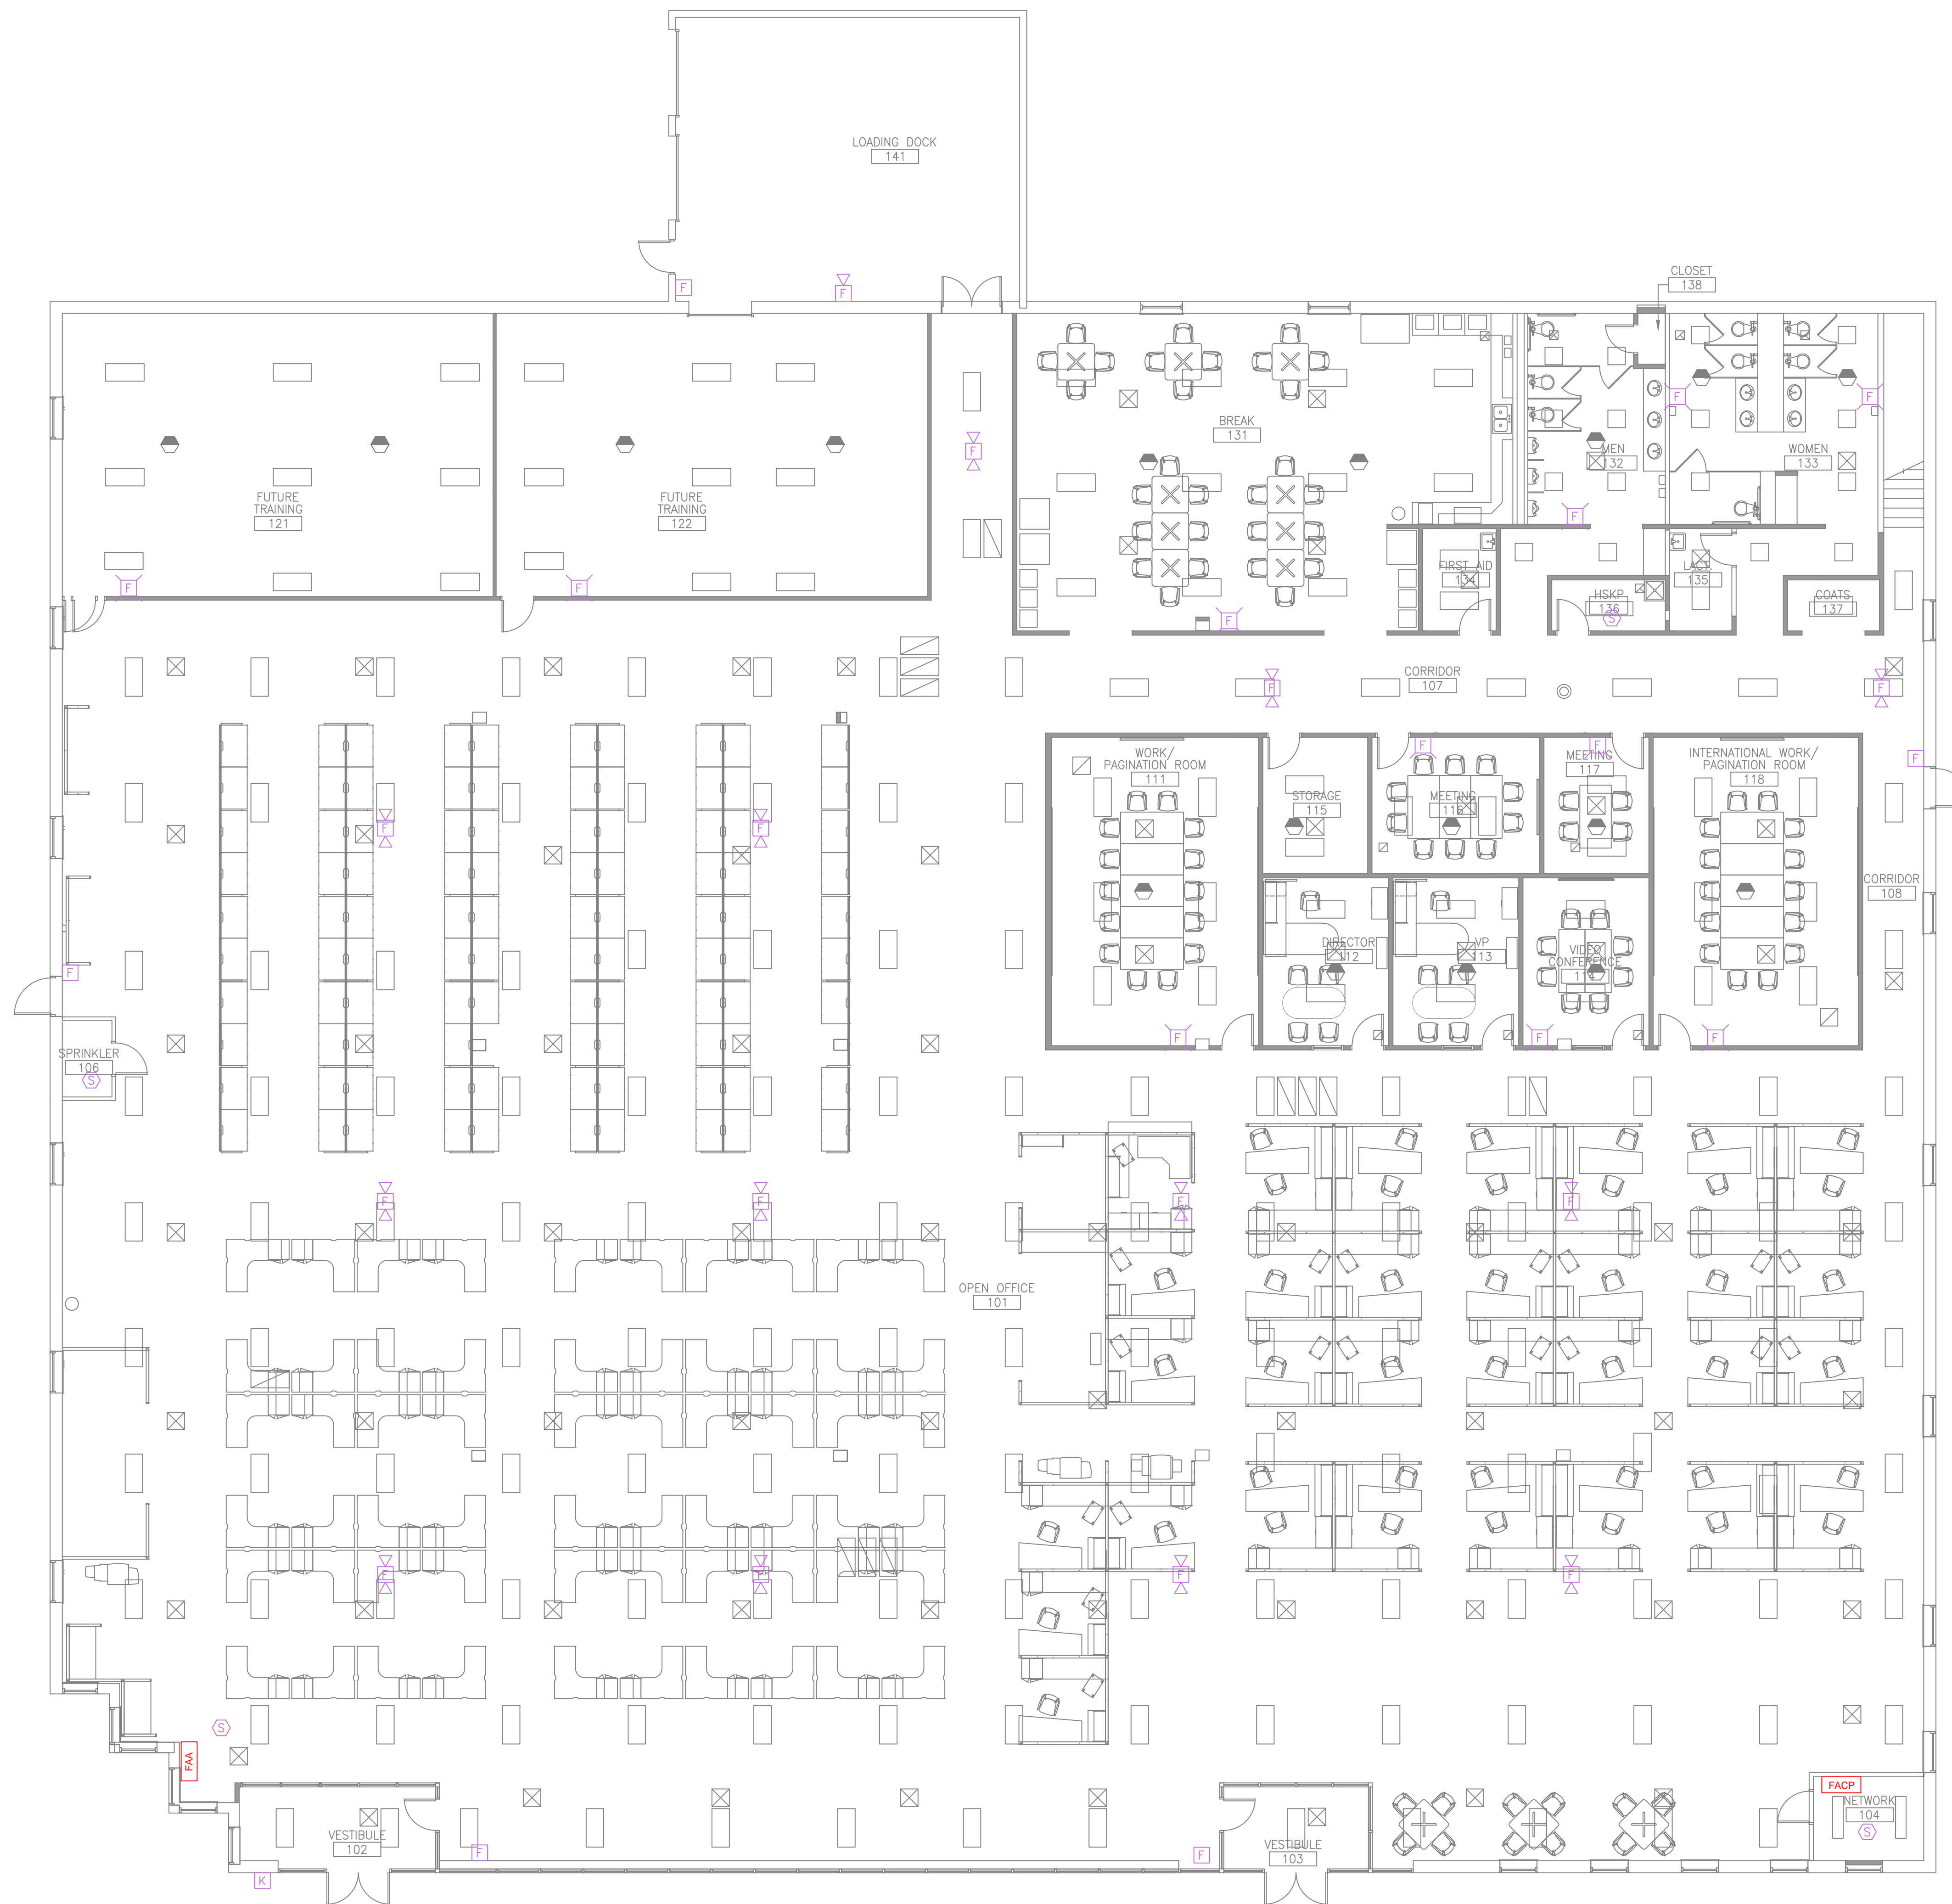


LEGEND

-  PULL STATION
-  SMOKE DETECTOR
-  HORN/STROBE
-  HORN/STROBE (CEILING)
-  STROBE (XX NOTES CANDELA)
-  FIRE ALARM CONTROL PANEL
-  FIRE ALARM REMOTE ANNUNCIATOR




REVISION 0 SUBMITTAL DATE: 07/24/2015

FIRE ALARM LAYOUT

PROJECT NAME
 LL BEAN CHESHIRE BUILDING
 43 NORTHPORT DRIVE
 PORTLAND, MAINE 04103

SCALE NTS
 BY: JRS

 **NORRIS INC**
 Prepared For Tomorrow, Delivered Today
 2257 BROADWAY, SO. PORTLAND, MAINE

FA-L