


# RF Coaxial Cable & Combiner Configuration

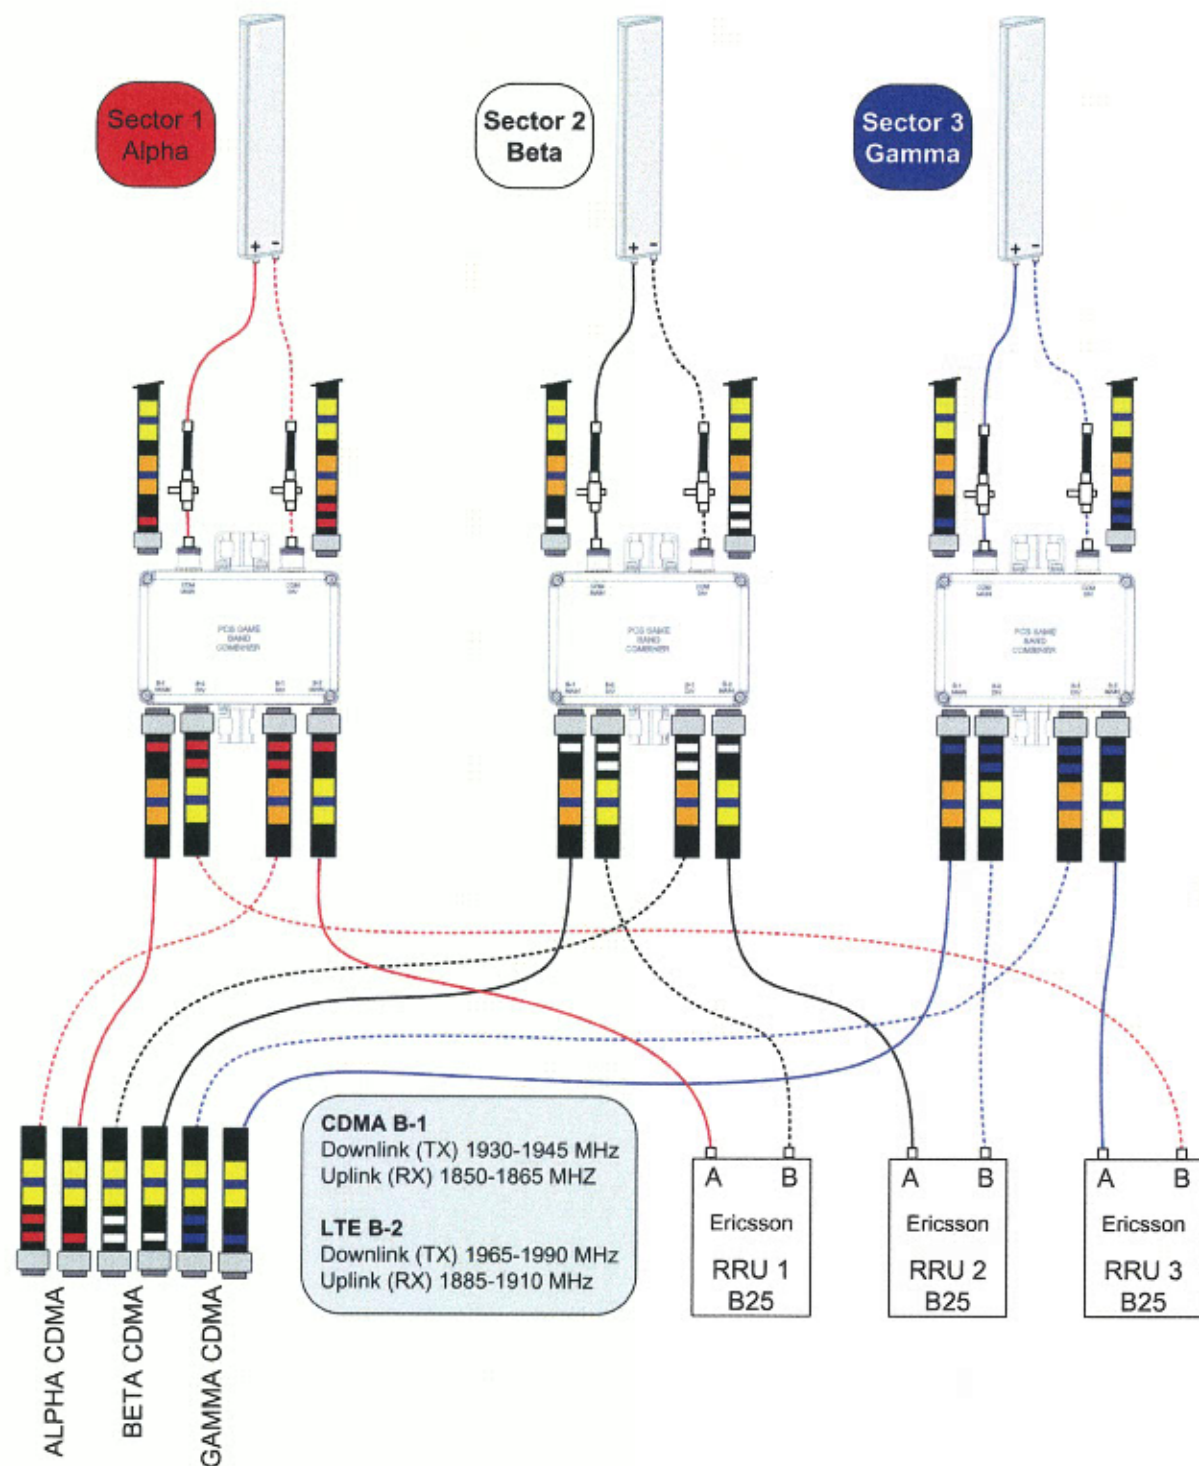

**ONE-LINE DIAGRAM**  
SCALE: N.T.S.

PLANS PREPARED FOR:

**US Cellular**  
We connect with you  
10 Corporate Drive, Suite 210, Bedford, NH 03110

PROJECT INFORMATION

**853408-NORTH DEERING**  
1335 WASHINGTON AVE  
PORTLAND, ME 04103  
(CUMBERLAND COUNTY)

PLANS PREPARED BY:

**amec**  
343 Gorham Road, South Portland ME 04108  
P: (207) 761-1770 F: (207) 774-1246 www.amec.com

PROJECT COORDINATION & MANAGEMENT:

**KJK Wireless, LLC**  
127 Ridge Road, Nashua, NH 03062  
Phone: (603) 888-8974

SEAL

MICHAEL S. DELETETSKY  
No. 5023  
PROFESSIONAL ENGINEER  
LICENSED  
23 May 2012

△	5/23/13	ISSUED FOR CONSTRUCTION
REV	DATE	ISSUED FOR

PROJECT NO: 3618138235

DRAWN BY: CBM

RELEASED BY: MSD

SHEET TITLE  
**ONE-LINE  
DIAGRAM**

SHEET NUMBER	REVISION:
<b>E-3</b>	<b>0</b>