




49 DARTMOUTH STREET
PORTLAND, MAINE 04101
207-775-1059
www.pdtarchs.com

COPYRIGHT
PDT Architects
Reuse or reproduction of the
contents of this document is not
permitted without written
permission of PDT Architects.

CUMBERLAND COUNTY FEDERAL CREDIT UNION
1345 Washington Avenue, Portland, ME

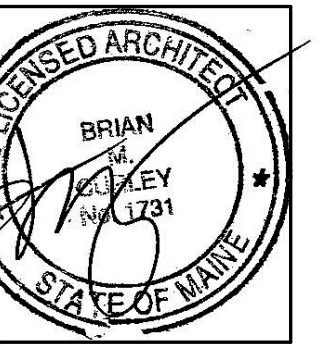

JOB NO.
12044

DRWN. Author
CHECK Checker


SCALE:
1/4" = 1'-0"

ISSUE
30 August, 2013

TITLE
ELECTRICAL/DATA
PLAN


SHEET

A104

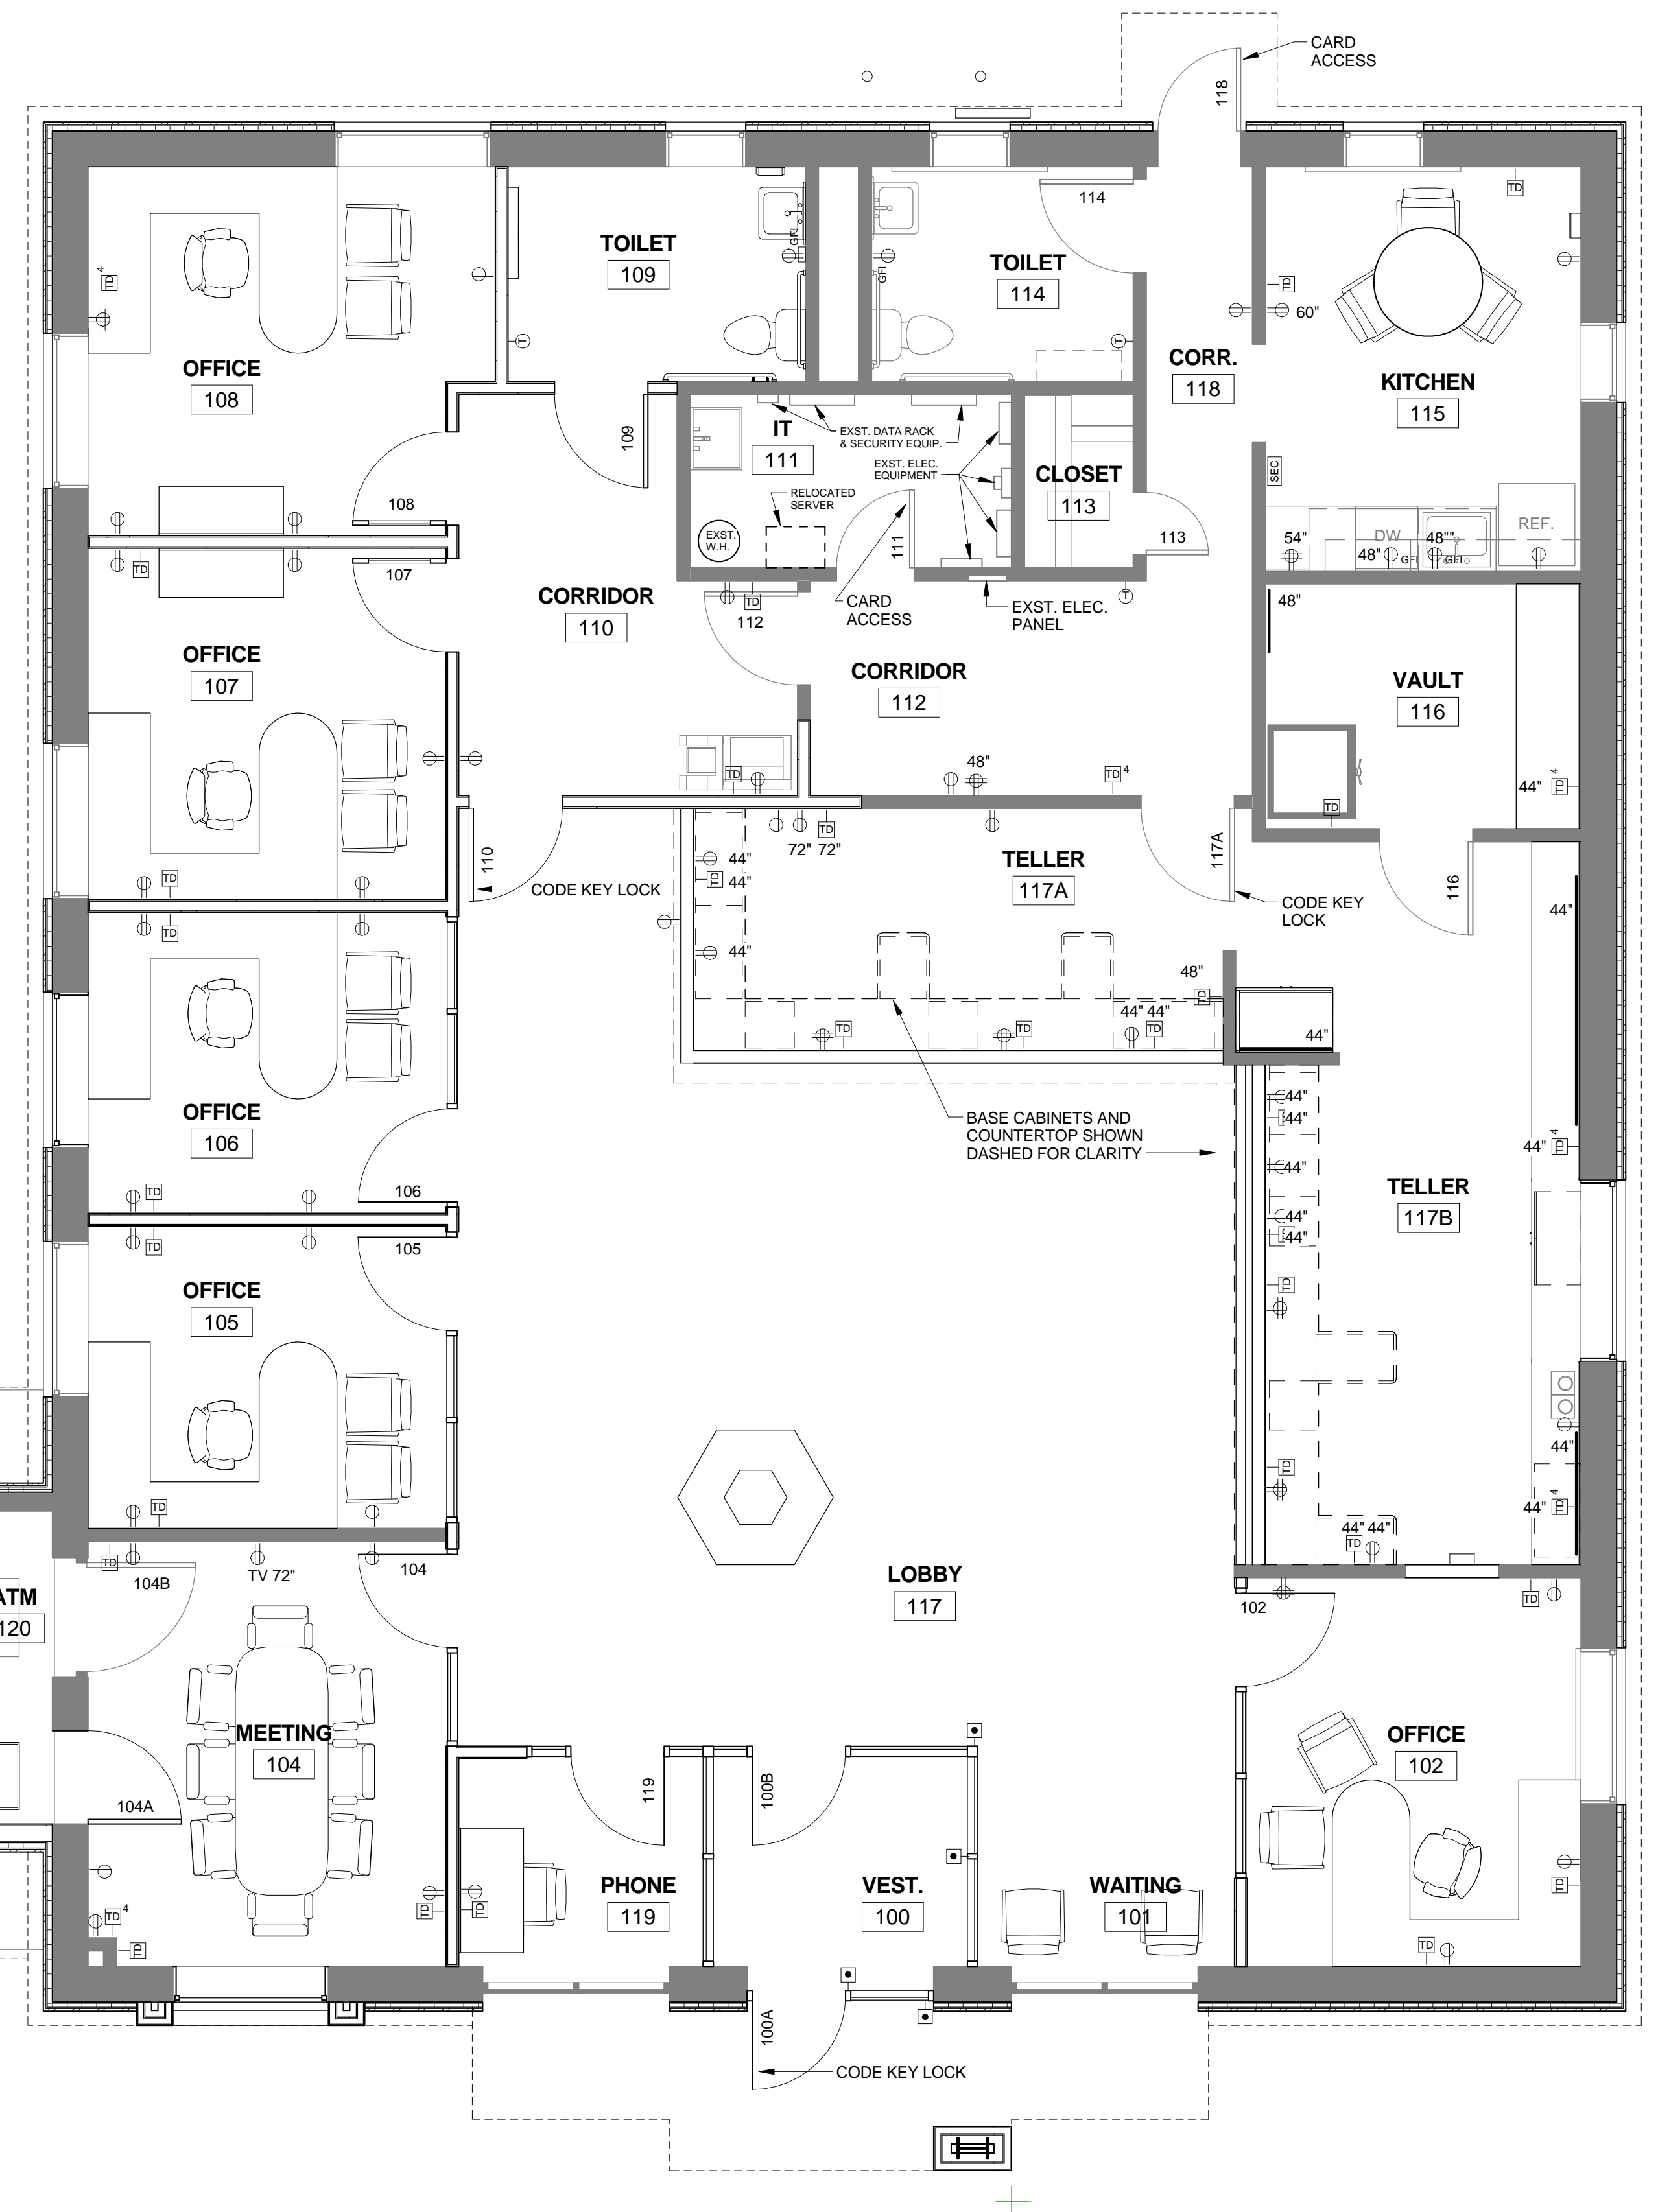

ELECTRICAL LEGEND	
	DUPLEX OUTLET
	QUAD OUTLET
	GFCI OUTLET
	TEL/DATA OUTLET
	QUAD TEL/DATA OUTLET
	TELEPHONE OUTLET # = NO. OF JACKS
	CATV OUTLET
	POWER STRIP
	ADA PUSH PADDLE
	THERMOSTAT

NOTES:
1. COLOR OF ELECTRICAL AND DATA WALL PLATES TO BE CCFU'S CUSTOM GRAY.
2. AT EXST. EXTERIOR WALLS TO RECEIVE (1) LAYER 3/8" G.W.B. FURR OUT ALL ELECTRICAL AND DATA WALL PLATES.

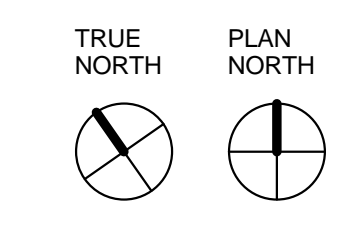

A5 FIRST FLOOR ELECTRICAL PLAN
1/4" = 1'-0"