



ARCHITECTS

49 DARTMOUTH STREET
PORTLAND, MAINE 04101
207-775-1059
www.pdtarchts.com

COPYRIGHT
PDT Architects

Reuse or reproduction of
the contents of this document is not
permitted without written
permission of PDT Architects.

Cumberland Counter Federal Credit Union
1345 Washington Ave. Portland, ME 04103

JOB NO.
13-0075

DRWN. MKL
CHECK Checker

SCALE:
1/4" = 1'-0"

ISSUE
07-15-13


TITLE
Structural Plan
Views

SHEET
S101


Structural Integrity
Consulting Engineers

180 Beacon Street
Portland, ME, 04103
p. 207-774-4614
f. 866-793-7835
www.structuralinteg.com

BUILD WITH CONFIDENCE

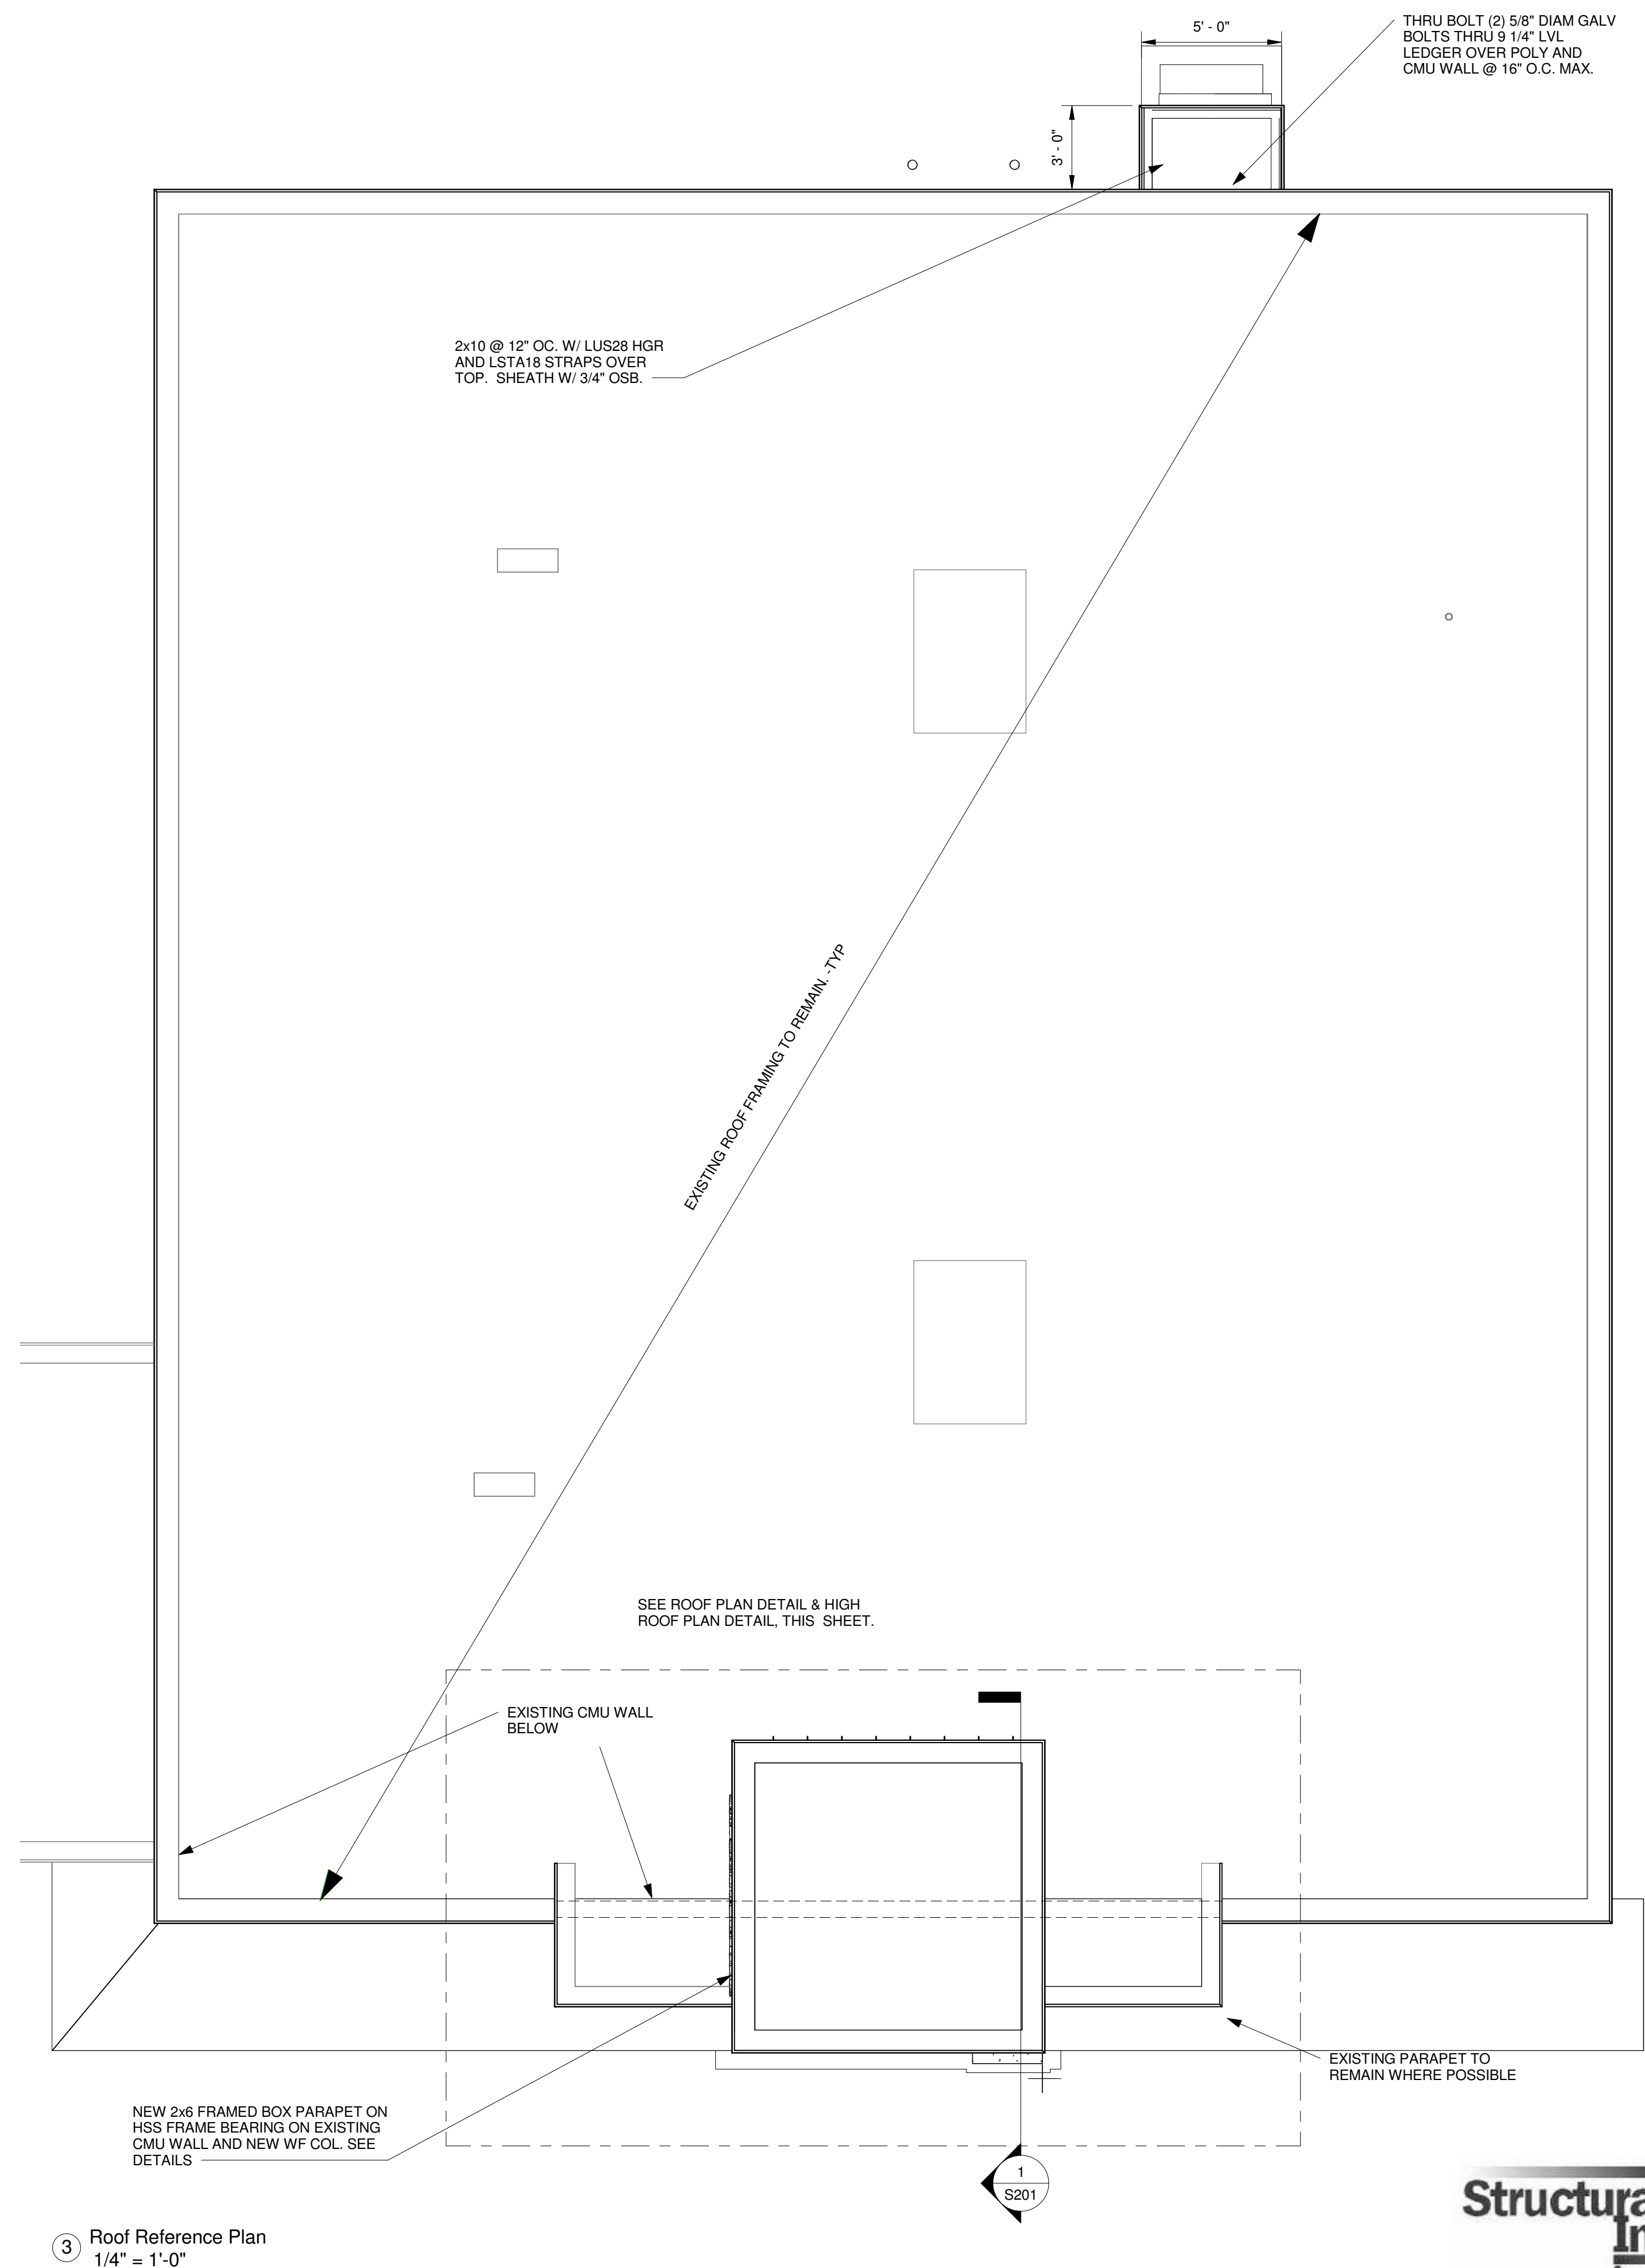

3 Roof Reference Plan
1/4" = 1'-0"

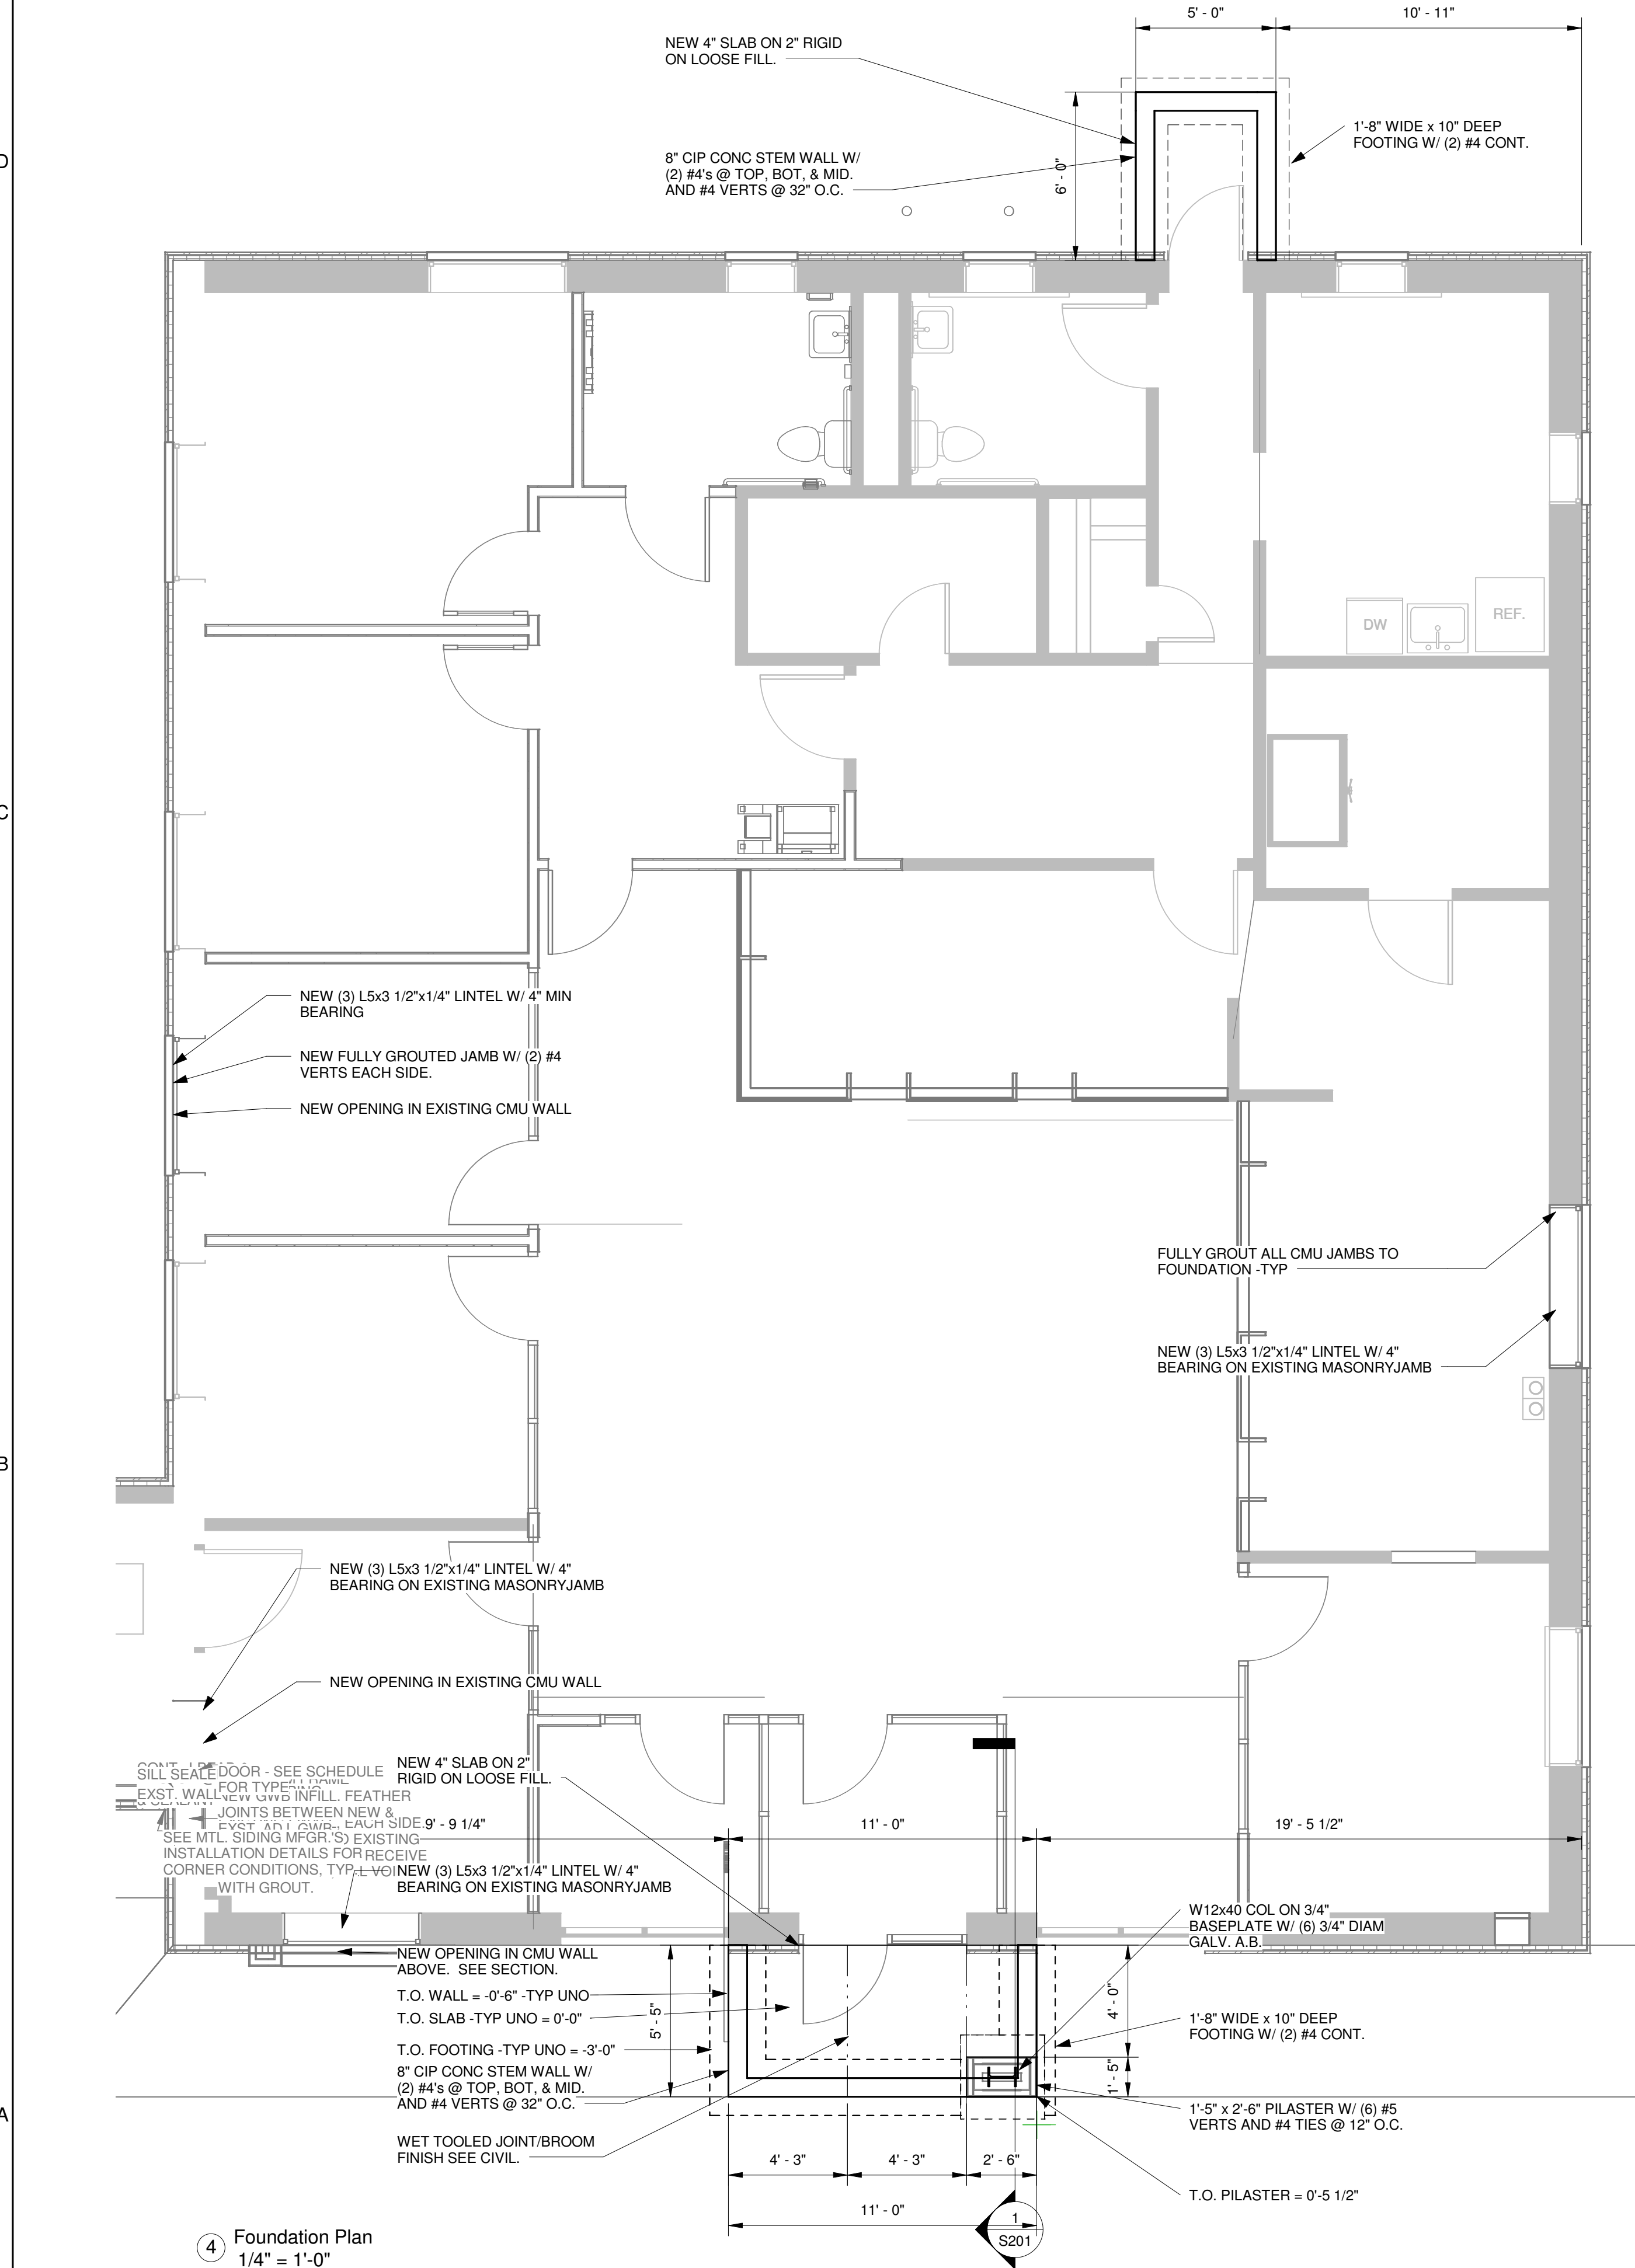

4 Foundation Plan
1/4" = 1'-0"