



ARCHITECTS

49 DARTMOUTH STREET  
PORTLAND, MAINE 04101  
207-775-1059  
www.pdtarch.com

COPYRIGHT  
PDT Architects

Reuse or reproduction of the  
contents of this document is not  
permitted without written  
permission of PDT Architects.

Cumberland County Federal Credit Union  
1345 Washington Ave. Portland, ME 04103

JOB NO.  
13-0075

DRWN. MKL  
CHECK ACJ

SCALE:  
As indicated

ISSUE  
07-15-13

TITLE  
Details and  
Sections


SHEET

S201


**Structural Integrity**  
Consulting Engineers

180 Beacon Street  
Portland, ME, 04103  
p. 207-774-4614  
f. 866-793-7835  
www.structuralinteg.com


BUILD WITH CONFIDENCE

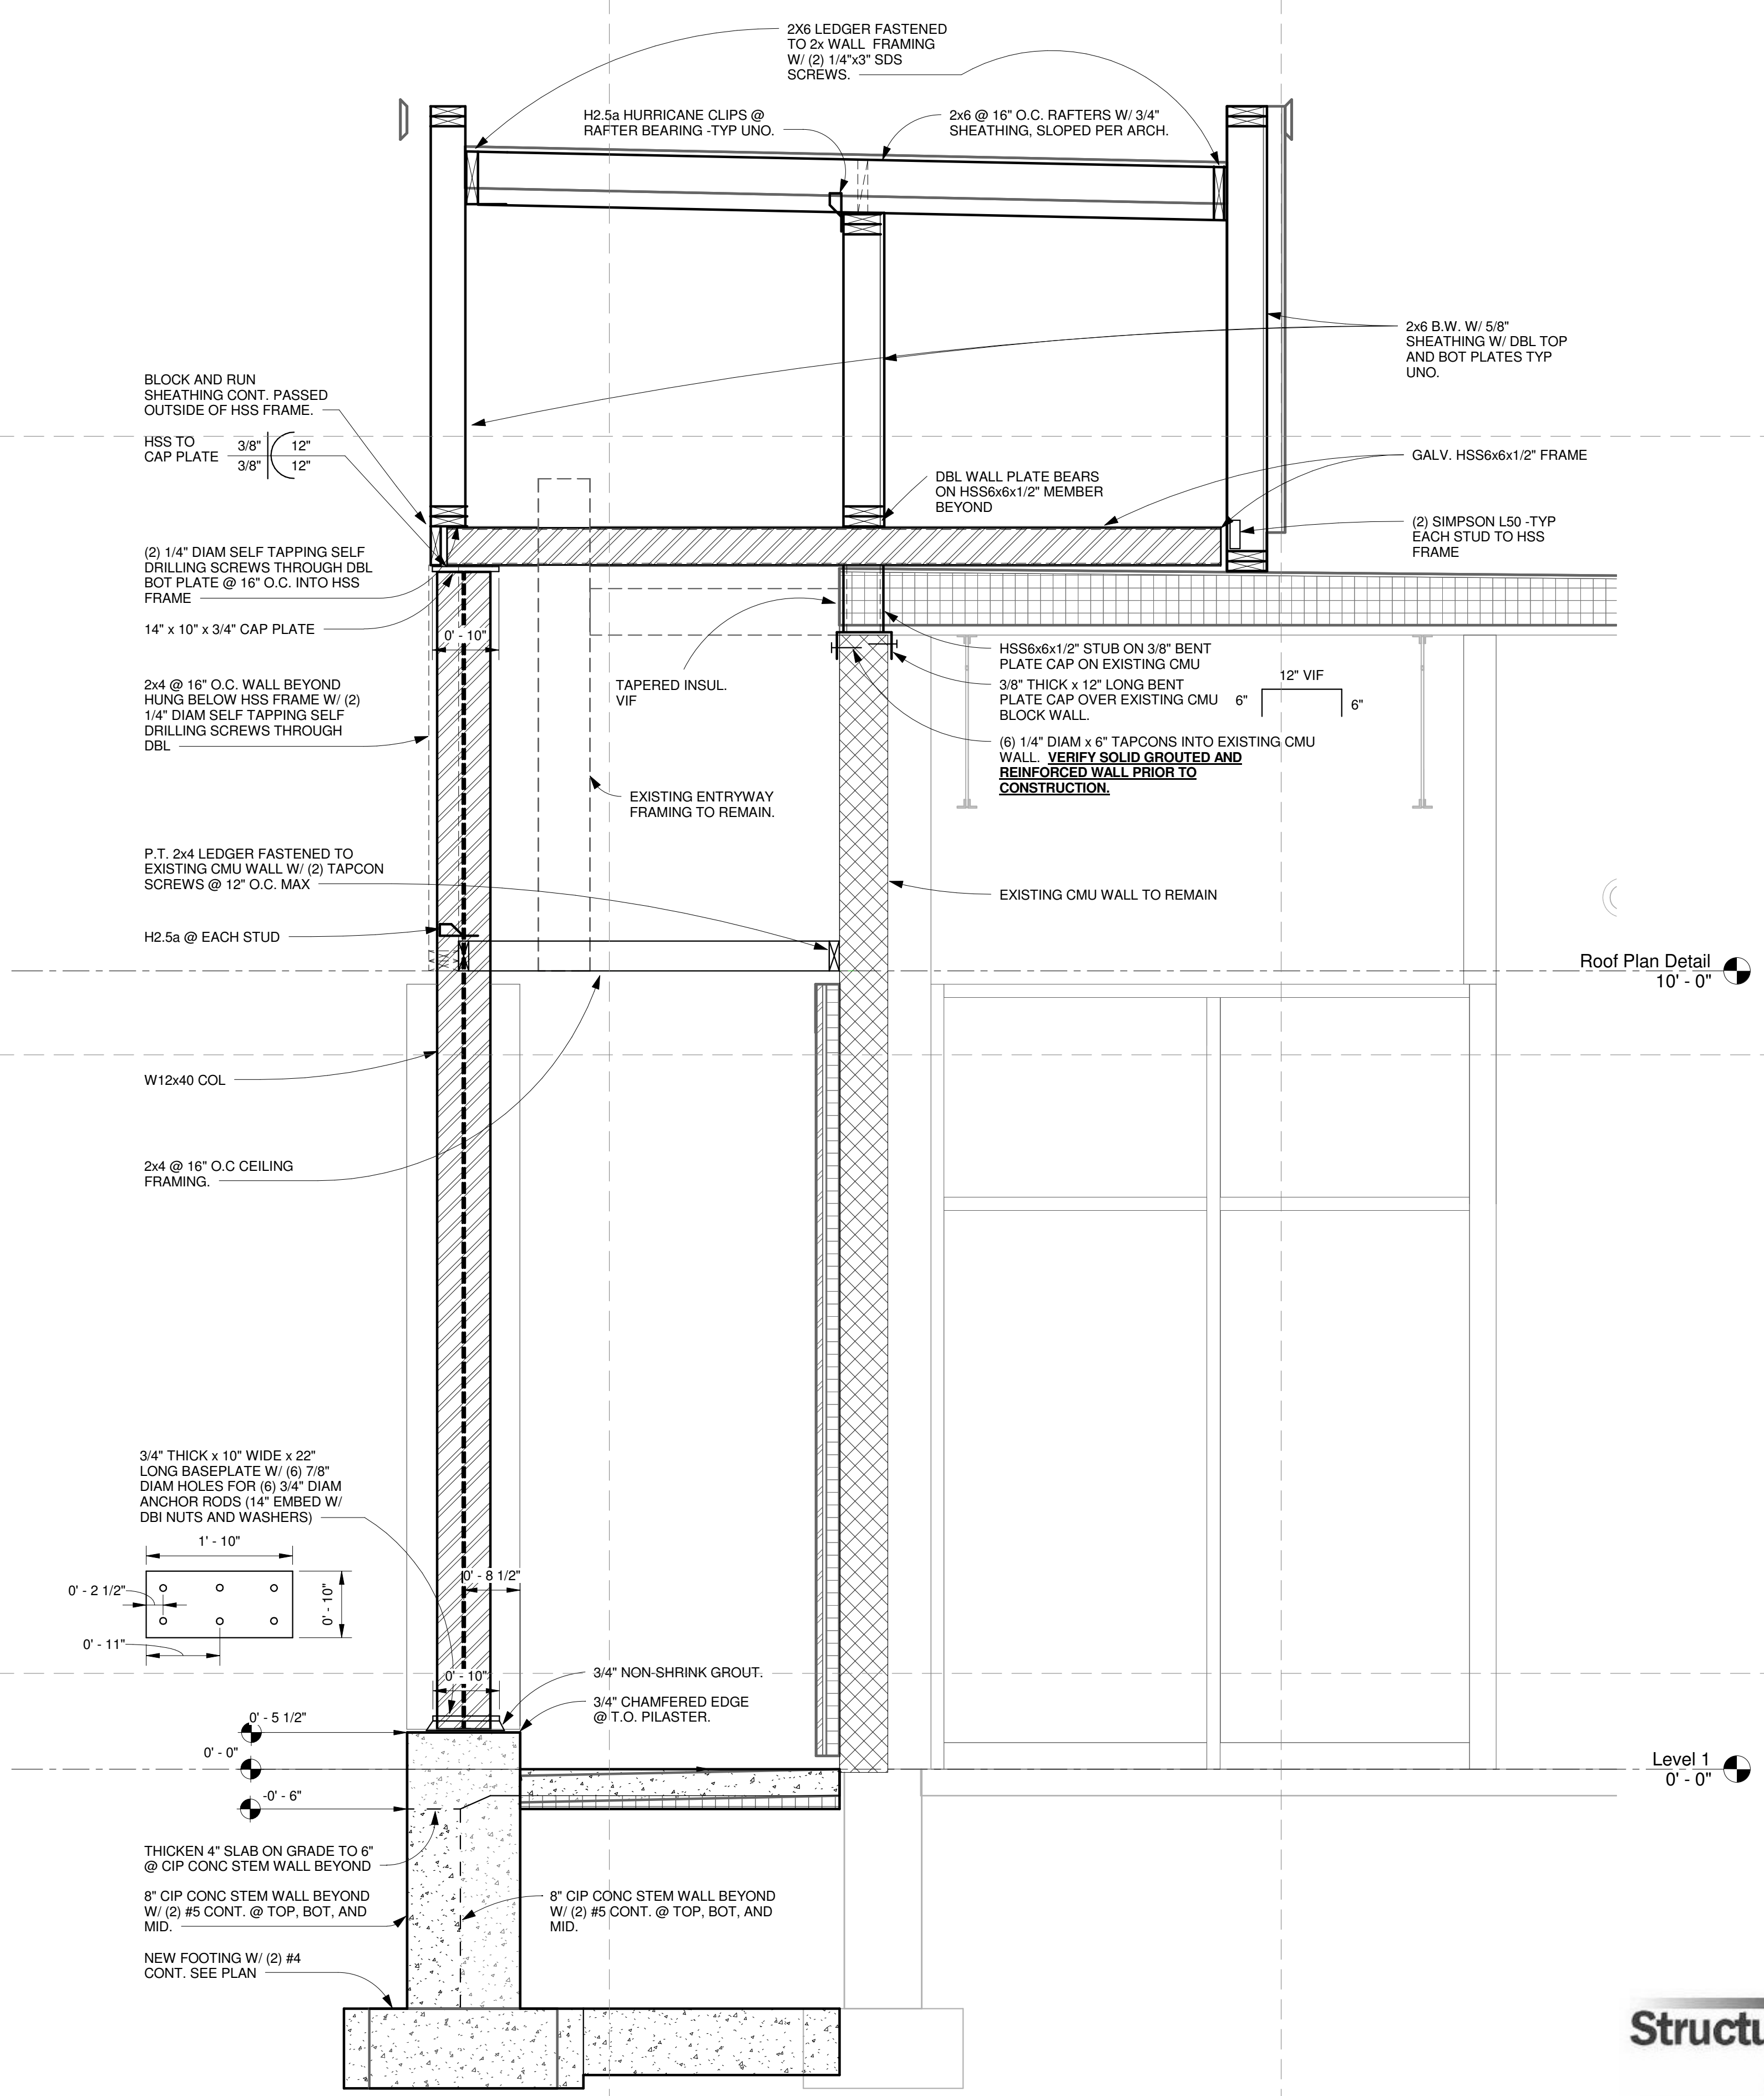

1 Section 1  
3/4" = 1'-0"

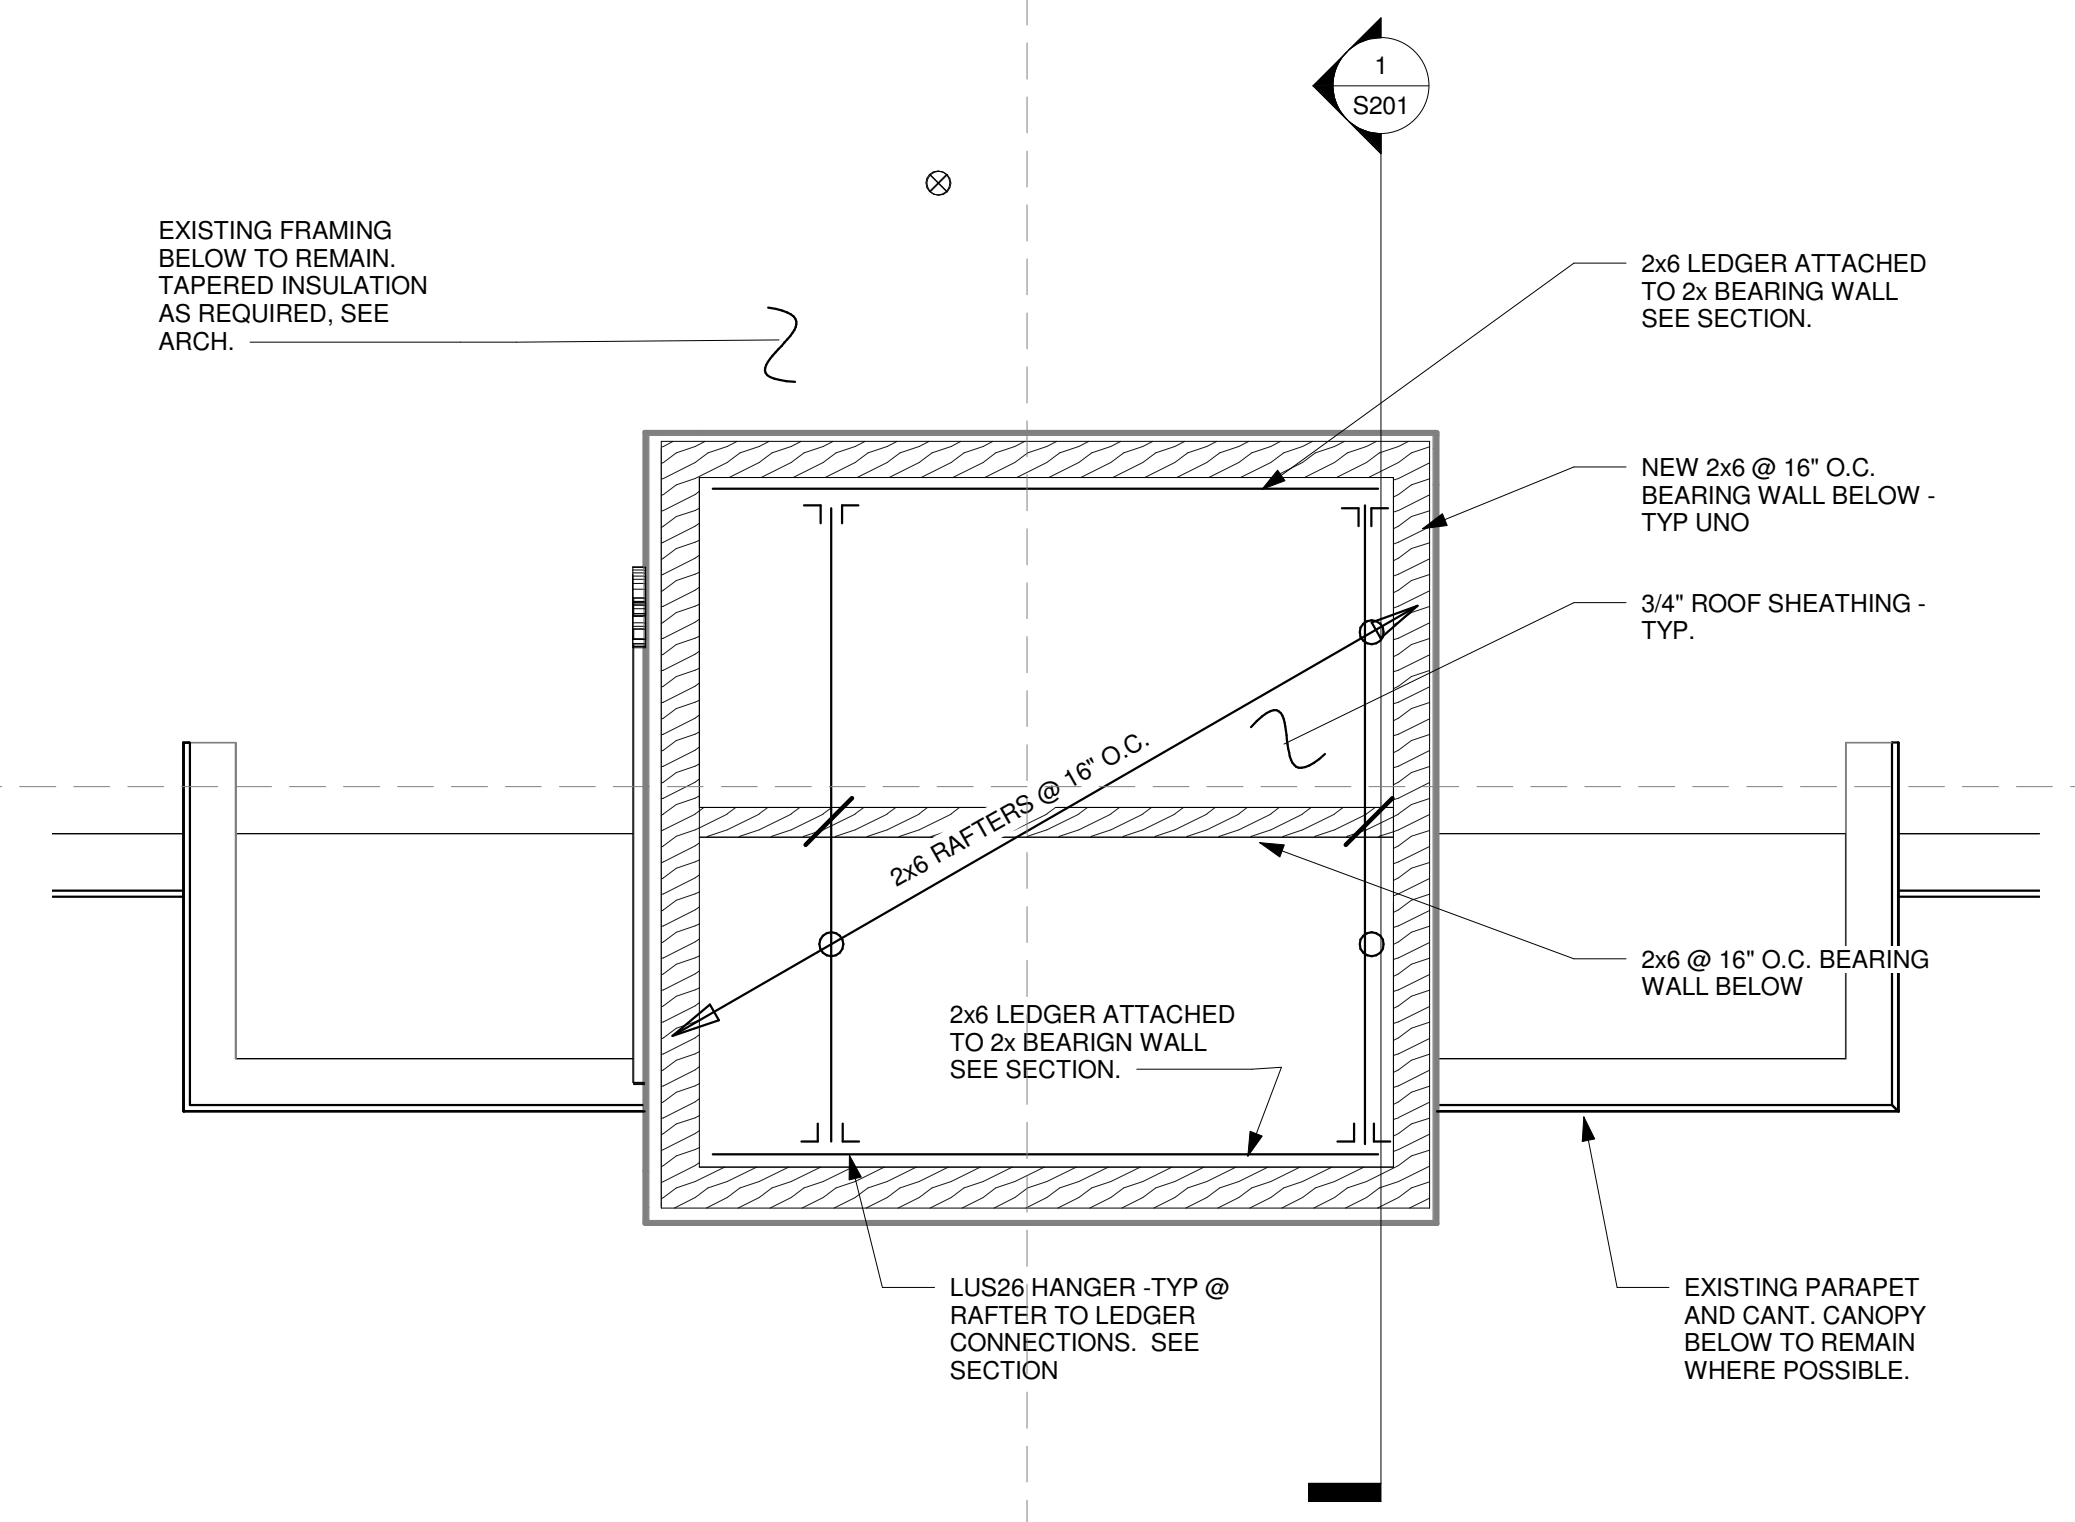

2 High Roof  
3/8" = 1'-0"

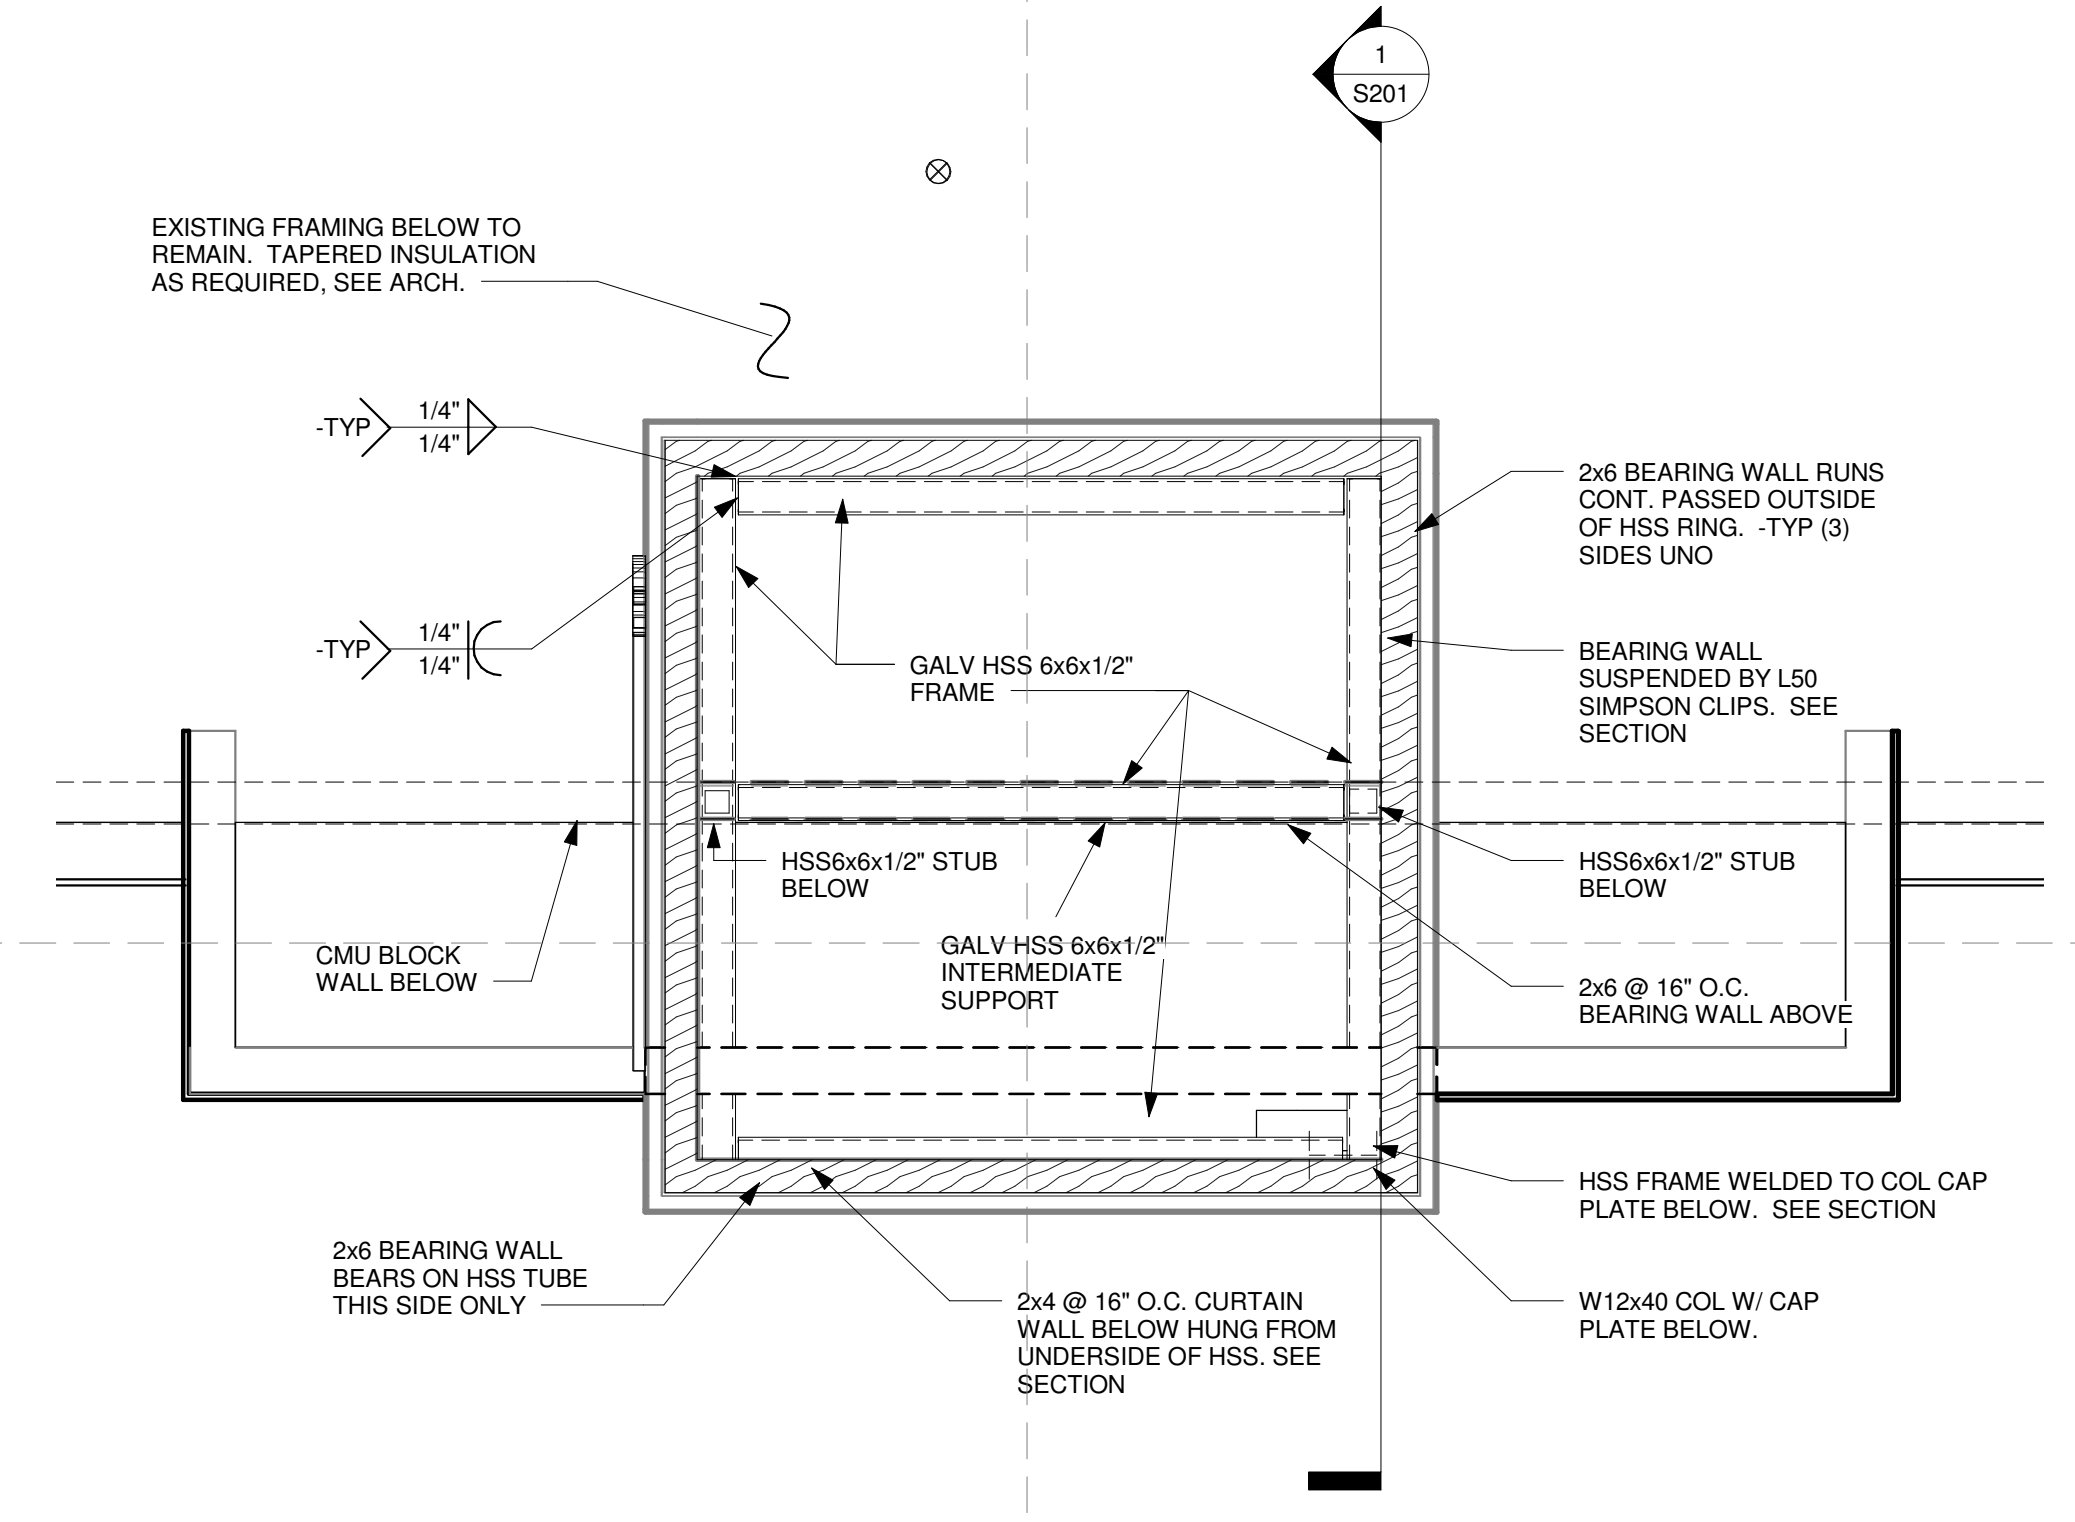

3 Roof Plan Detail  
3/8" = 1'-0"

5

4

3

2

1

D

C

B

A

C

B

A