


NOTES THIS SHEET

- ROUTE GAS DOWN & MANIFOLD BRANCHES OFF FULL SIZE HEADER IN WALL. CONNECT TO EQUIPMENT NUMBERS 39, 41, 42, AND 43. PROVIDE MANUAL SHUT-OFF VALVES UP FRONT FOR EACH PIECE OF EQUIPMENT.
- PROVIDE MANUAL SHUT-OFF VALVE, UNIONS, AND SOLENOID VALVE FOR INTERTIE WITH HOOD FIRE SUPPRESSION SYSTEM.
- SEE FIRST FLOOR CORE PLAN FOR CONTINUATION OF 1-1/4" 140" HW, 3/4" 140" HWR, 1-1/4" CW, 1-1/4" 120" HW, 3/4" 120" HWR.
- 1/2" CW DN TO PRESSURE REDUCING VALVE, THEN TO EQUIPMENT.
- HW DN TO CHECK VALVE, STRAINER, PRESSURE REDUCING VALVE & WATER HAMMER ARRESTER, THEN TO EQUIPMENT.
- 2" GAS UP.
- 1/2" CW DN TO PRESSURE REDUCING VALVE APPROVED BACK FLOW PREVENTER.
- ROUTE 3/4" CONDENSATE DRAIN TO DISHWASHER.

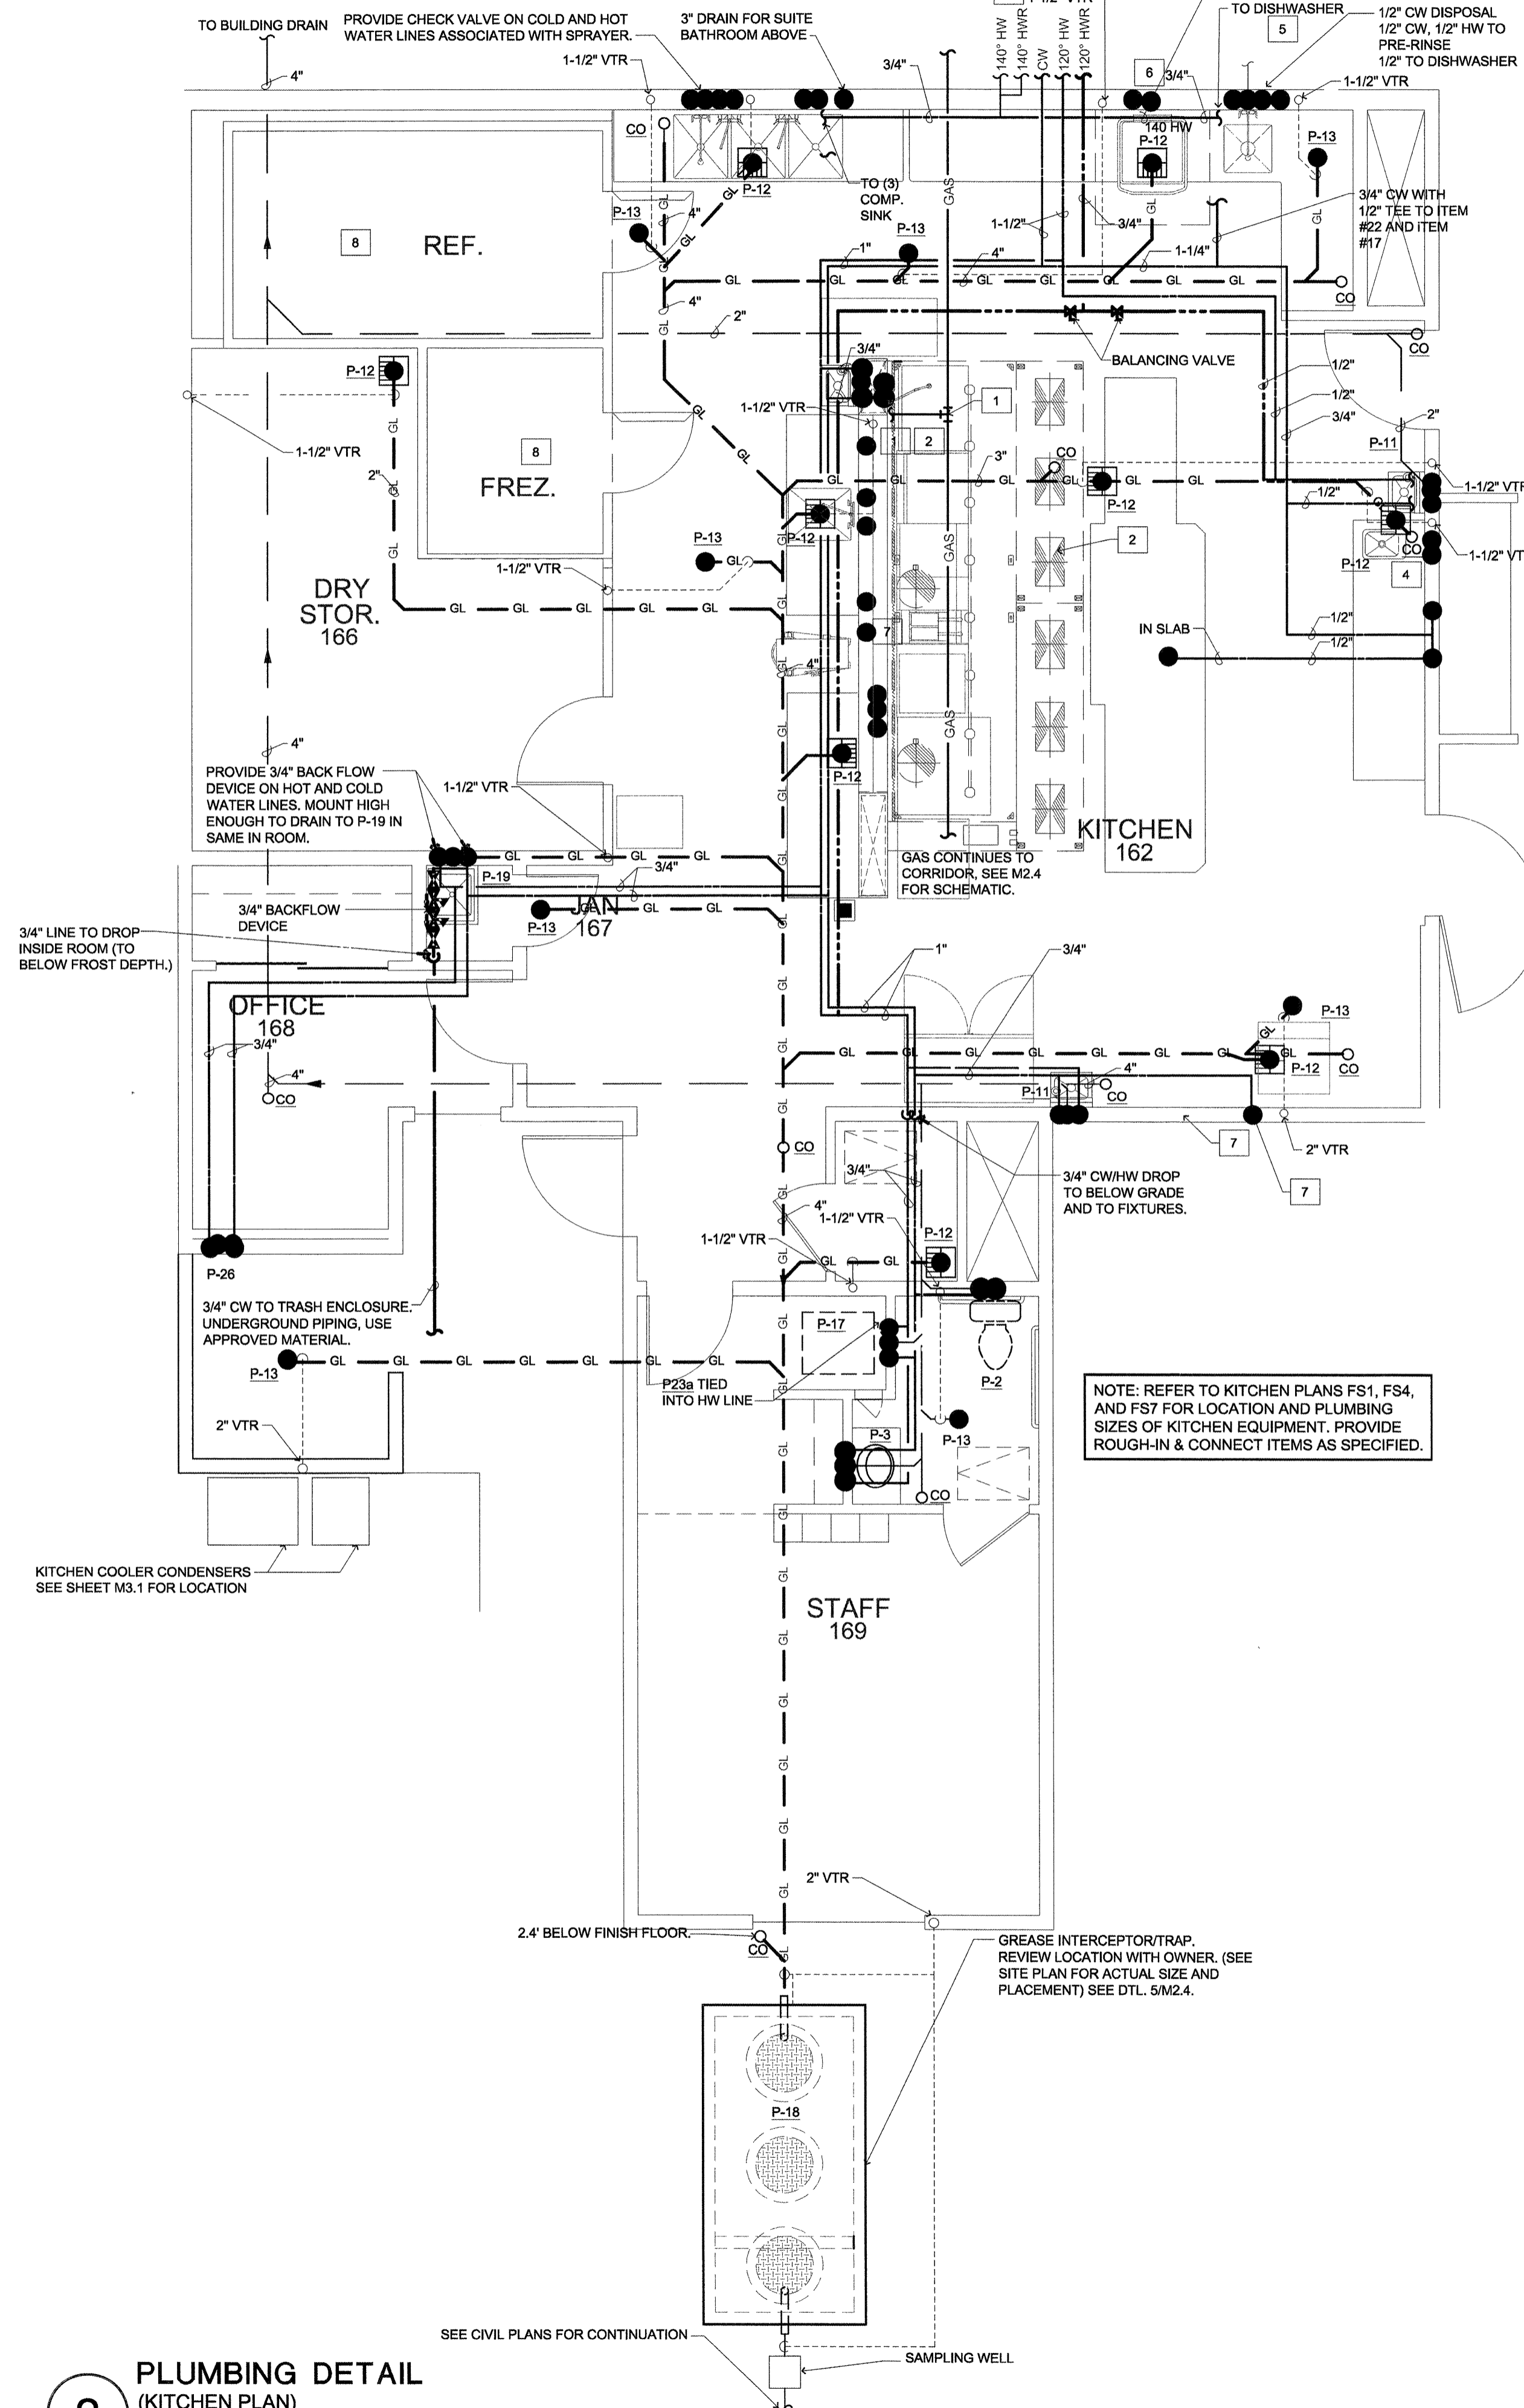


PLUMBING KEY NOTES

- GAS MAIN SEE 1/M2.4
- SEE 2/M2.3 FOR THIS AREA.
- TYPICAL RISER, SEE 4/M2.2.
- ROUTE PIPING TO FIXTURES ON FLOOR ABOVE/BELOW.
- CONNECT INTERIOR ROOF DRAIN TO STORM WATER SYSTEM. SEE CIVIL PLANS. DISCHARGE 6" ABOVE LOWER ROOF AS SHOWN. MIN. 1/8" PER FT. SLOPE.
- PROVIDE SHUT-OFF VALVES AND ACCESS. SEE RISER 3/M2.2.
- ROUTE GAS PIPING UP/DOWN. SEE 1/M2.4
- HOSE BIBB (P-23) - (FROST FREE)
- HOSE BIBB (P-23) IN MECH. WELL. - (FROST FREE)
- FUTURE DOOR (DO NOT PLUMB IN THIS LOCATION).
- CLEAN OUT OR MANHOLE AS REQ'D BY LOCAL CODE.
- PROVIDE CONDENSATE LINE FOR FUTURE THRU-WALL PTAC UNITS IN "C" UNIT SPARE BEDROOMS.
- ROUTE WATER MAINS OVERHEAD TO MECH. ROOM
- 3/4" CONDENSATE DRAIN. SEE 7/M2.1.
- NO PLUMBING ROUTED IN STAIR WALL-UTILIZE 2X6 FUR OUT.
- 3" ROOF DRAIN, UNLESS NOTED OTHERWISE ON DRAWING.
- SLEEVE WASTE PIPING THROUGH FOUNDATION.


PLUMBING FIXTURE SCHEDULE

SYM	DESCRIPTION	CONNECTION SIZE			
		W	V	CW	HW
P-1	WATER CLOSET - NIAGARA - N228 COMBO ELONGATED ADA FLOOR MOUNTED, TANK TYPE, FLAPPERLESS, ELONGATED 16.5 IN. H.C. HT. BOWL, VITREOUS CHINA, BOLT CAPS, SUPPLY AND STOP, 1.6 GPF SEAT. BEMIS 1600PRO W/ COVER, FLUSH CONTROL TO BE LOCATED ON THE WIDE SIDE OF TOILET AREA AWAY FROM WALL.	3"	2"	1/2"	--
P-2	WATER CLOSET - SAME AS P-1 EXCEPT SEAT. SEAT: BEMIS 1850CV W/ COVER, W/ OPEN FRONT. FLUSH CONTROL TO BE LOCATED ON THE WIDE SIDE OF TOILET AREA AWAY FROM WALL.	3"	2"	1/2"	--
P-3	LAVATORY - ELIER 051-0124, MURRAY OVAL (20"x17"), COUNTERTOP, FRONT OVERFLOW, SELF-RIMMING, SEALANT, FAUCET HOLES 4" OC. ADA VITREOUS CHINA. FITTINGS: 1-1/4 IN. BY 1-1/2 IN. P-TRAP. SUPPLIES AND STOPS. FAUCET: LEVER HANDLE TYPE, 1.5 GPM AERATOR.	1-1/2"	1-1/2"	1/2"	1/2"
P-3a	LAVATORY - UNDER COUNTER WITH OVERFLOW: KOHLER K-2609 OVAL (20"x17"), ADA STAINLESS STEEL FITTINGS: 1-1/4 IN. BY 1-1/2 IN. P-TRAP. SUPPLIES AND STOPS. FAUCET: SINGLE HOLE COUNTER MOUNT SINGLE LEVER HANDLE WITH CHROME FINISH. MOEN 6400, 1.5 GPM AERATOR.	1-1/2"	1-1/2"	1/2"	1/2"
P-4	SINK - ELKAY DAYTON D11719 SINGLE COMPARTMENT, 22 GAUGE STAINLESS STEEL, SOUND DEADENED, 17"x19" (BOWL DIM. 14"x14") SELF-RIMMING, 4 IN. CENTER-2 HOLE, J-35 CUP STRAINER. FITTINGS: SUPPLIES, STOPS, 1-1/2 IN. P-TRAP. FAUCET: MOEN 4904, KITCHEN DECK/SINGLE HANDLE TYPE, 4 IN. CENTERS, GOOSENECK SPOUT, ESCUTCHEON, WITH 1.5 GPM AERATOR.	2"	1-1/2"	1/2"	1/2"
P-4a	SINK - ELKAY ELUHAD1316 ADA UNDER COUNTER SINGLE COMPARTMENT, 18 GAUGE STAINLESS STEEL, SOUND DEADENED, 16X18-1/2X5-1/8" DEEP WITH J-35 CUP STRAINER. FITTINGS: SUPPLIES, STOPS, 1-1/2 IN. P-TRAP. FAUCET: MOEN 7423 WITH 1.5 GPM AERATOR.	2"	1-1/2"	1/2"	1/2"
P-4b	SINK - MOEN K02045622 ADA SINGLE COMPARTMENT, HEAVY GAUGE STAINLESS STEEL, SOUND DEADENED, 15"x15" (BOWL DIM. 12"x10"), 5-1/2" DEEP, SELF-RIMMING, 4 IN. CENTER-2 HOLE, J-35 CUP STRAINER. FITTINGS: SUPPLIES, STOPS, 1-1/2 IN. P-TRAP. FAUCET: MOEN 4904, KITCHEN DECK/SINGLE HANDLE TYPE, 4 IN. CENTERS, GOOSENECK SPOUT, ESCUTCHEON, WITH 1.5 GPM AERATOR.	2"	1-1/2"	1/2"	1/2"
P-5	MISC. SINK - JUST DL-2128-A-GR DOUBLE COMPARTMENT, 18 GAUGE STAINLESS STEEL, SOUND-DEADENED, 21 IN. FRONT TO BACK x 28 IN. LEFT TO RIGHT, 18 IN. DEEP, THREE HOLE (2) J35-99 DRAIN. FITTINGS: SUPPLIES, STOPS, 1-1/2 IN. P-TRAP. FAUCET: KITCHEN DECK/SINGLE HANDLE TYPE, 8 IN. CENTERS, SWING SPOUT, AERATOR, MOEN 6742S. DISPOSAL: IN SINK-ERATOR 777SS	2"	1-1/2"	1/2"	1/2"
P-6	SHOWER ENCLOSURE - 60" IN. X 36 IN. CLEAR INSIDE DIMENSIONS. FIBERGLASS SHOWER ENCLOSURE. FITTINGS: P-TRAP, GRID DRAIN. BATHSHOWER VALVE: CP METAL, SINGLE-HANDLE PRESSURE BALANCING W/ ADJUSTABLE TEMPERATURE LIMIT. SINGLE LEVER HANDLE. LIMIT FLOW TO 1.75 GPM. MOEN TL182EP (WITH STOPS) SHOWER ONLY. INTERIOR ELEVATIONS: AQUATIC 1603-CFS WITH 1-1/4" DAM. PROVIDE BLOCKING FOR GRAB BARS ON SHOWER, PER DETAIL 12/A8.3a.	2"	1-1/2"	1/2"	1/2"
P-7	SHOWER ENCLOSURE - 60" IN. X 36 IN. CLEAR INSIDE DIMENSIONS. FIBERGLASS SHOWER ENCLOSURE. FITTINGS: P-TRAP, GRID DRAIN. BATHSHOWER VALVE: CP METAL, SINGLE-HANDLE PRESSURE BALANCING W/ ADJUSTABLE TEMPERATURE LIMIT. MOEN 62370 VALVE. SINGLE LEVER HANDLE. LIMIT FLOW TO 1.75 GPM. MOEN 5224GBM17 (WITH STOPS), HANDLED SINGLE FUNCTION SPRAY SHOWER, 70" METAL SPIRAL HOSE, VACUUM BREAKER AND 24" GRAB BAR. MOEN TL181 TRIM. INTERIOR ELEVATIONS: AQUATIC 1603-CFS WITH 1-1/4" DAM. PROVIDE BLOCKING ON SHOWER. PROVIDE AND INSTALL "L" SHAPED GRAB BAR, PER DETAIL 12/A8.3a.	2"	1-1/2"	1/2"	1/2"
P-8	BATHTUB - 5 FT. ONE PIECE FIBERGLASS TUB/SHOWER, WITH GRAB BAR. IN TYPICAL SUITE BOTTOM MAX 1/2" ABOVE FLOOR, LEDGE TO BE 1/8" ABOVE FLOOR. MINIMUM WATER CAPACITY 36 GALLONS. APPROVAL OF FIXTURE AT TIME OF SUBMITTAL. FITTINGS: TRIP LEVER WASTEBASKET VALVE, CP METAL, SINGLE HANDLE PRESSURE BALANCING W/ ADJUSTABLE TEMPERATURE LIMIT. SINGLE LEVER HANDLE, LIMIT FLOW TO 1.75 GPM. MOEN TL183EP (WITH STOPS) & 62370 SHOWER & TUB TRIM. LOCATE GRAB BAR AS PER ARCH. INTERIOR ELEVATIONS: LOCATION: ALL BATHTUBS AS SHOWN ON ARCH. AQUATIC 2603-SG. PROVIDE BLOCKING ON TUB PER DETAIL 12/A8.3a.	2"	1-1/2"	1/2"	1/2"
P-9	NOT USED.				
P-10	SELF-CONTAINED, WALL HUNG ELECTRIC WATER COOLER - ELKAY EZSTL8C. BARRIER-FREE ACCESS, 8.8 GPM CAPACITY AT 80°F AMBIENT/80°F IN50°F OUTLET WATER TEMPERATURE. HANGER (SUPPORT CARRIER), PLUG-IN, 3-WIRE CORD, 1/5 HP/115V/1 PHASE. FITTINGS: 1 1/4 IN. X 1 1/2 IN. P-TRAP, SCREWDRIVER STOP, TUBING SUPPLY.	1-1/2"	1-1/2"	3/8"	--
P-11	HAND SINK - FITTINGS: 1-1/4 IN. BY 1-1/2 IN. P-TRAP. SUPPLIES AND STOPS. CARRIER: AMERICAN STANDARD 38240-106 WALL HANGER. ACCESSORIES INCLUDE: MOEN 8248 BLADE HANDLES PRESSURE BALANCING MIXING VALVE: MOEN 104451 (MAX HW TEMP. 110°F), FAUCET-MOUNT EYEWASH, EMEDCO EW7-CV. SINK PROVIDED KITCHEN EQUIP. CONTRACTOR.	1-1/2"	1-1/2"	1/2"	1/2"
P-12	FLOOR SINK - 12-1/2 IN. SQUARE TOP, 6 IN. DEEP, HEAVY CAST-IRON WITH ACID-RESISTANT COATING INTERIOR, NICKEL BRONZE RIM AND 1/2 GRATE, COORDINATE W/ KITCH SUPPLIER. COMMERCIAL ENAMEL 906-2	3"	1-1/2"	--	--
P-13	FLOOR DRAIN - CAST-IRON BODY WITH ADJUSTABLE ROUND POLISHED NICKEL BRONZE TOP. STRAINER DIAMETER 6 IN. 1/2" TRAP PRIMER CONNECTION WITH INTEGRAL SEEPAGE PAN. PROVIDE WITH P-TRAP, 3 INCH DRAIN, J.R. SMITH 2005-A ON CONCRETE FLOOR, 2005-A-DX ON WOOD FLOOR. 2 INCH DRAIN ON ALL PUBLIC RESTROOMS.	3"	1-1/2"	--	--
P-14	LAUNDRY SINK - MUSTEE UTILITY TUB 19F, FLOOR-MOUNTED OR MUSTEE UTILITY SINK 10C, COUNTER-MOUNTED SEE PLANS. MOEN 8277 FAUCET ASSEMBLY.	2"	1-1/2"	1/2"	1/2"
P-15	SHAMPOO SINK - BELVEDERE NO. 3803 COLOR WHITE, W/403 VACUUM BREAKER, 314 FLO-TEMP PLATE, 622 FLO-TEMP. MIXING VALVE, 5001244 HOSE RECEIVER AND HT-1 HAIR TRAP.	2"	1-1/2"	1/2"	1/2"
P-16	ADA COMPLIANT SINGLE COMPARTMENT MOEN 22131 SINK, 26 GA. SOUND DEADENED, 10" FRONT TO BACK, 21" LEFT TO RIGHT, 1 1/2" DEEP. DRAIN LOCATION RIGHT REAR. SELF RIMMING, 4-HOLE, 4" O.C. J-V-35 DRAIN. FITTINGS: SUPPLIES, STOPS, P-TRAP, INSULATED DRAIN, AND HW PIPING. FAUCET: PROVIDE (2) SINGLE HANDLE KITCHEN FAUCET WITH SWING SPOUT AND AERATOR. MOEN 6742S.	1-1/2"	1-1/2"	1/2"	1/2"
P-16A	ADA COMPLIANT UNDER COUNTER TWO COMPARTMENT ELKAY ELUHAD1316 SINK, 18 GA. 30-3/4" X 18-1/2" WITH J-V-35 DRAIN. FITTINGS: SUPPLIES, STOPS, P-TRAP, INSULATED DRAIN, AND HW PIPING. FAUCET: PROVIDE (2) SINGLE HANDLE KITCHEN FAUCET WITH SWING SPOUT AND AERATOR. MOEN 6742S.	1-1/2"	1-1/2"	1/2"	1/2"
P-17	WASHING MACHINE SUPPLY AND DRAIN RECESSED BOX: 1/2 IN. HOT AND COLD BOTTOM SUPPLY CONNECTION WITH SHUT-OFF VALVES, 2 IN. DRAIN CONNECTION. FIRE-RATED WASHING MACHINE BOX GUY GRAY FR12 AND FILTR0L 160 LINT FILTER. LOCATION: AT ALL WASHING MACHINES.	2"	1-1/2"	1/2"	1/2"
P-18	GREASE INTERCEPTOR - AS REQUIRED BY LOCAL OFFICIAL. COMPLETE W/SEALED (AIR-TIGHT) METAL LID AND RINGS. SEE 5/M2.4 FOR CAPACITY.				
P-19	SERVICE SINK - FIAT T8500 FLOOR MOUNTED, 24 IN. X 24 IN. X 10 IN., MOLDED IN STONE, S.S. DOMED STRAINER, RIM GUARDS AND HSG-2424 WALL GUARDS. MOEN 8199 HOSE & BRACKET, FAUCET: MOEN 8230, HOSE END SPOUT WITH INTEGRAL VACUUM BREAKER, PAIL HOOK AND WALL BRACE. PROVIDE CHECK VALVE ON BOTH HOT AND COLD WATER LINE.	3"	1-1/2"	1/2"	1/2"
P-20	POST HYDRANT (NON FREEZE), 6" DEPTH OF BURY WADE W8610.	--	--	3/4"	--
P-21	WATER SOFTENER: CULLIGAN HI-FLO 3, HC 150 T-D, OWNER SUPPLIED CONTR. TO INSTALL, CONTRACTOR TO INSTALL SHUT-OFF AND BY-PASS AND VALVES WHETHER SOFTENER IS PROVIDED OR NOT.	--	--	2"	--
P-22	BOOSTER PUMP, HYFAB MVP-850-208 FACTORY PACKAGED, UL LISTED, DUPLEX DOMESTIC WATER BOOSTER PUMP W/ VARIABLE SPEED. PUMP CAPACITY OF 180 GPM @ 50 PSI BOOST. 34 GAL. HYDRO-PNEUMATIC TANK 4" 316 S.S. FLANGED MANIFOLD S.S. BASE, 250 PSI SS CHECK VALVES, BUTTERFLY VALVES AND A NEMA1 CONTROL PANEL. 208/300.	--	--	--	--
P-23	HOSE BIBB: WOODFORD #25, FROST PROOF W/ VACUUM BREAKER	--	--	3/4"	--
P-23a	HOSE BIBB: CHICAGO NO 998 - RCF - W/ INTEGRAL VACUUM BREAKER	--	--	--	3/4"
P-24	ROOF DRAIN - JR SMITH 1330 W/UNDERDECK CLAMP.	3"	--	--	--
P-25	ROOF OVERFLOW DRAIN - JR SMITH 1330 W/2" HIGH SOLID WATER DAM W/UNDERDECK CLAMP. WITH J.R. SMITH 1770 DOWNSPOUT NOZZLE AT DISCHARGE - 3".	3"	--	--	--
P-26	HOSE BIBB: WOODFORD #V22, HOT AND COLD WATER FROST PROOF W/ VACUUM BREAKER VERTICAL MOUNT.	--	--	3/4"	3/4"
P-27	SINK: ADA COMPLIANT WALL MOUNT LAVATORY KOHLER K-2005 20" X 16", VITREOUS CHINA, FRONT OVERFLOW FAUCET 3 HOLES ON 8" O.C. WITH RIGHT SIDE SOAP DISPENSER. ADA COMPLIMENT DRAIN AND FAUCET HARDWARE, MOEN 8224.	1-1/2"	1-1/2"	1/2"	1/2"
P-28	URINAL: ADA WALL-MOUNTED, WALL-HANGER BRACKETS, VITREOUS CHINA, 1 GPF: KOHLER STANWELL K-4972-ET WITH FLUSH VALVE: SLOAN MODEL 180-1.0 ROYAL MODEL FLUSHMETER.	1-1/2"	1-1/4"	1"	--
P-29	NOT USED				
P-30	THERMOSTATIC MIXING VALVE. LEONARD TM2020B.	--	--	2"	2"
P-31	SUMP PUMP OIL MINDER DUAL PUMP LIQUIDATOR SYSTEM: STANCOR SE-100HM OIM PACKAGED SYSTEM. POWER: 1HP 115V 16A. OPERATION: 2" PIPE AT (TDH) 3000 GPH AT 47 FT. DETAIL 15/M2.1.	2"	--	--	--
P-32	SUMP PUMP: LITTLE GIANT WRS-6, 1/3HP, 115 VOLTS, 5 GALLON. DETAIL 3/M2.3.	2"	--	--	--

NOTE: REFER TO ARCHITECTURAL SHEETS FOR KITCHEN EQUIPMENT SCHEDULES AND ADA LAVATORY MOUNTING HEIGHTS.

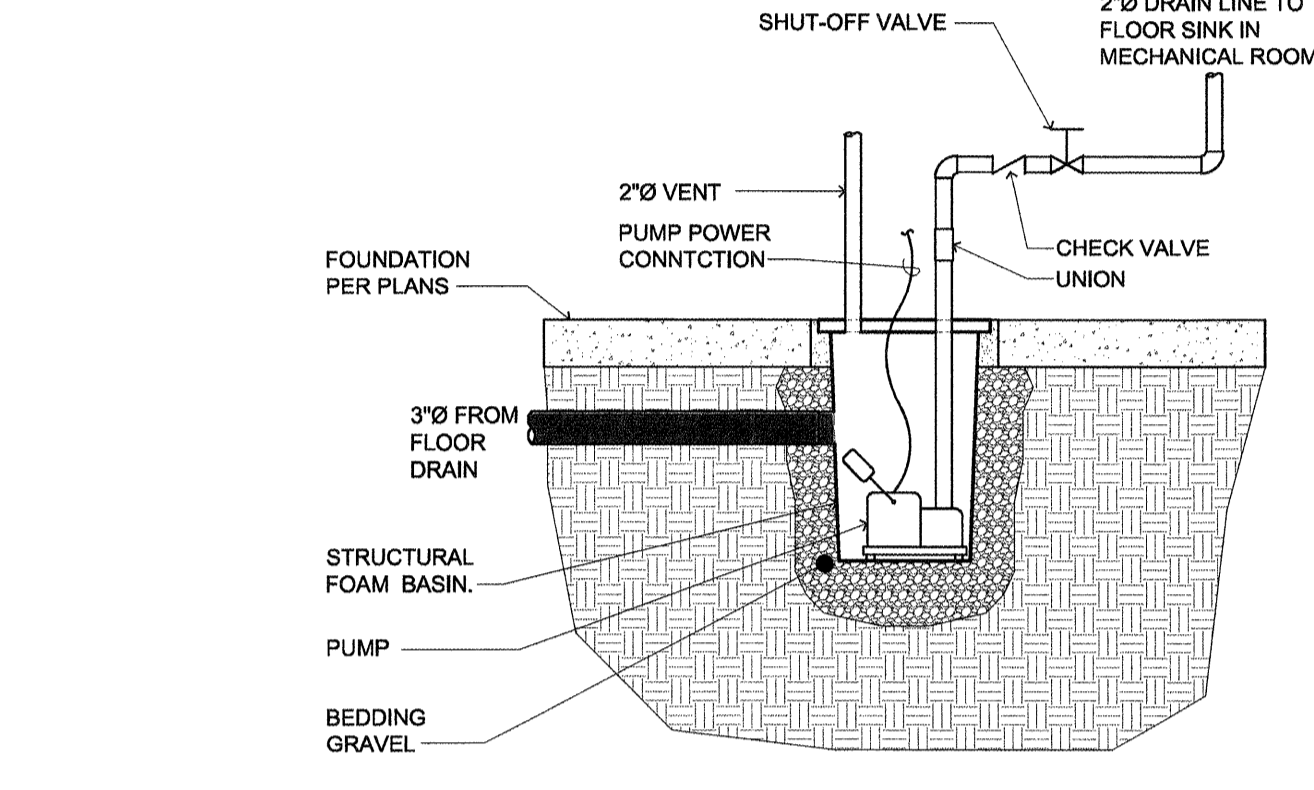

3 SUMP PUMP (P-32) THEATER
SCALE: N.T.S.

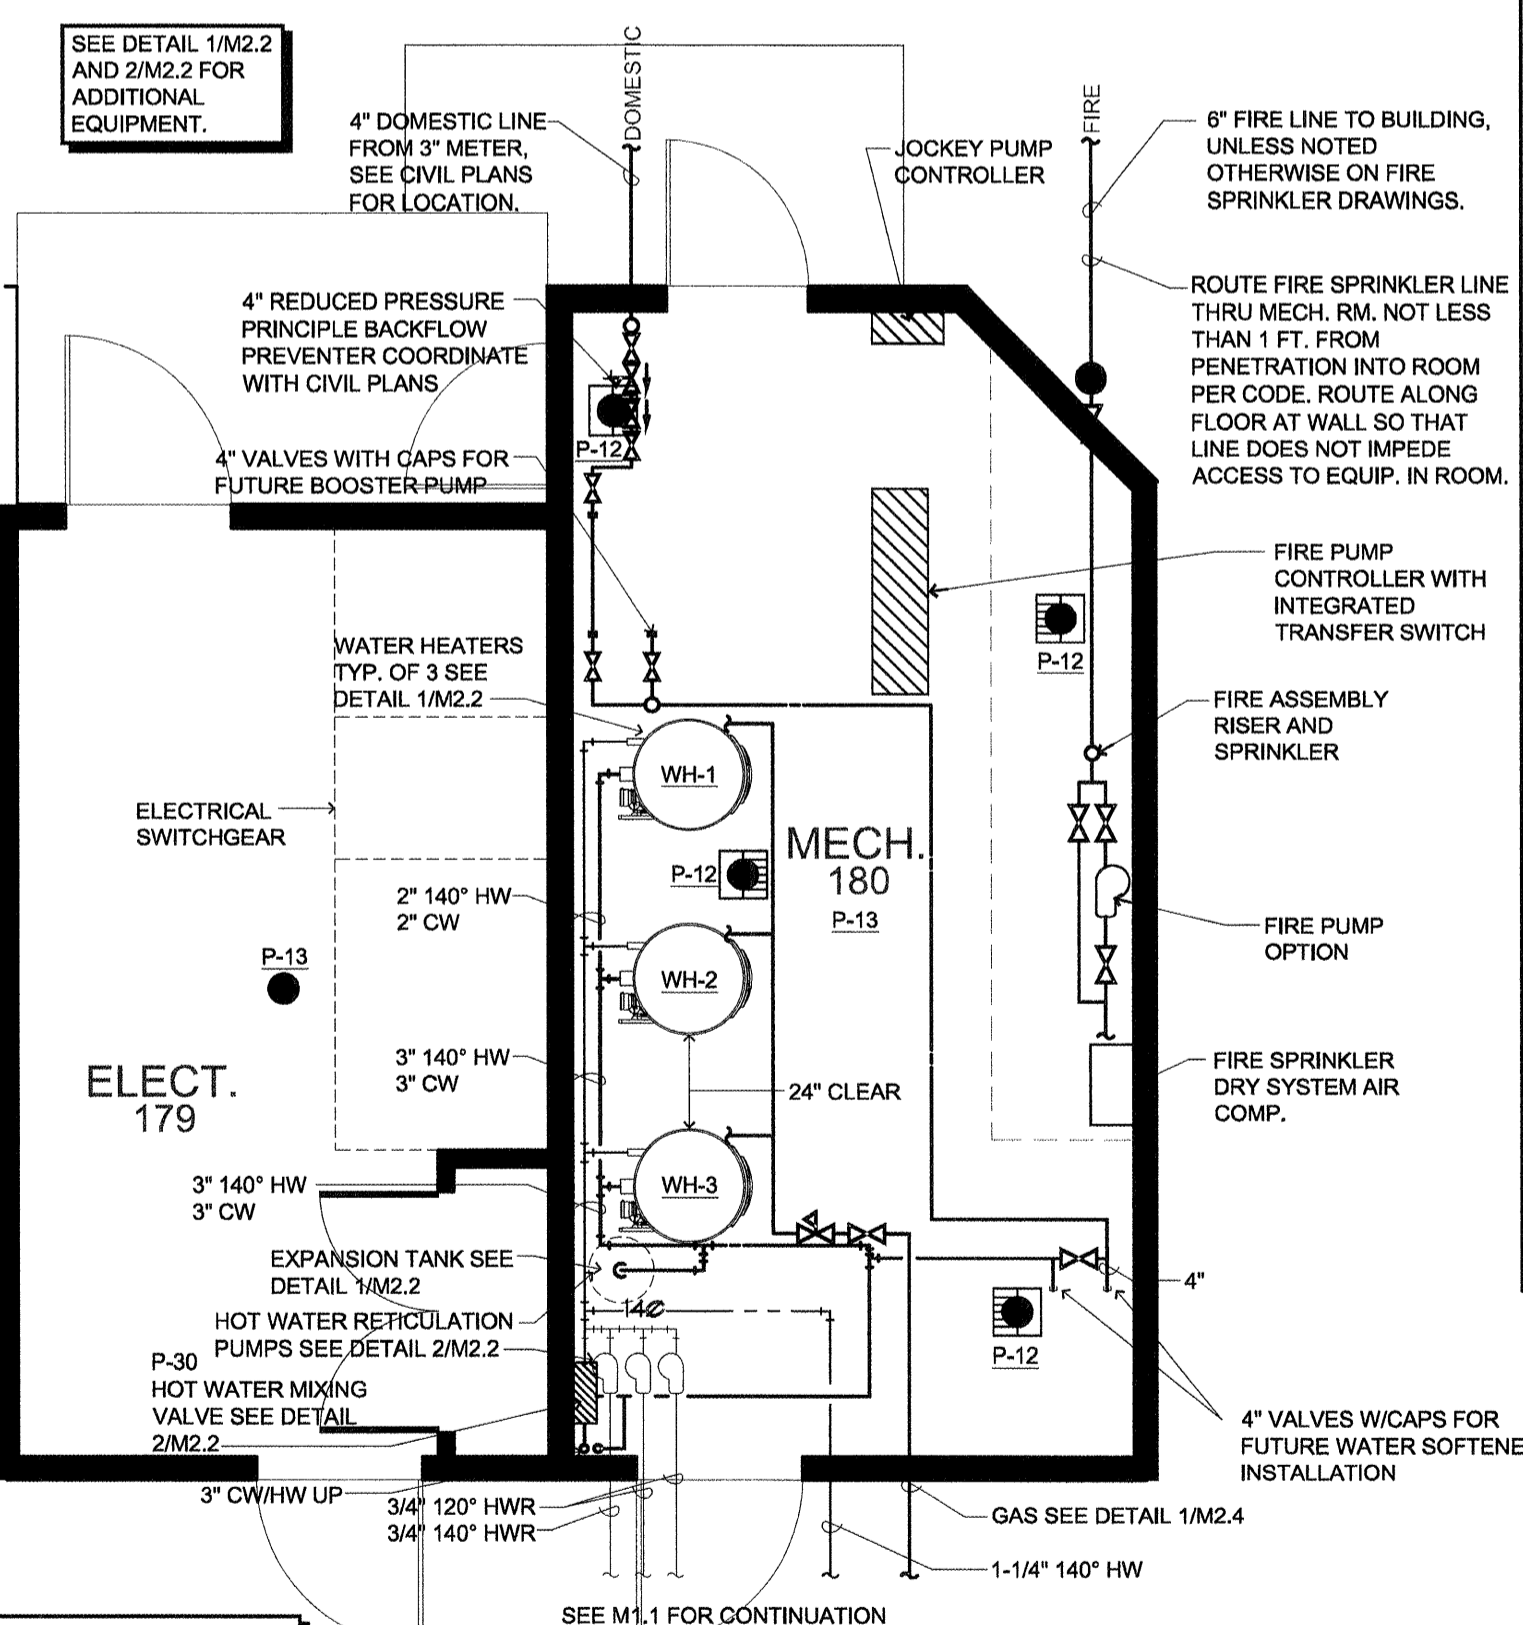

1 PLUMBING DETAIL (MECHANICAL ROOM PLAN)
SCALE: 1/4" = 1'-0"

PLUMBING LEGEND

--- COLD WATER PIPING	--- HOSE BIBB WITH INTEGRAL VACUUM BREAKER
--- 120°F DOMESTIC HOT WATER PIPING	--- PIPE WITH END CAP, REFER TO NOTE ON DWG.
--- 120°F DOMESTIC HOT WATER RECIRC. PIPING	--- ROOF DRAIN
--- 140°F DOMESTIC HOT WATER PIPING	--- OVERFLOW DRAIN
--- 140°F DOMESTIC HOT WATER RECIRC. PIPING	--- SANITARY SEWER BELOW GRADE
--- SD --- STORM DRAIN ABOVE GRADE	--- SANITARY SEWER ABOVE SLAB/GRADE
--- SD --- STORM DRAIN BELOW GRADE	--- CLEANOUTS TO GRADE OR FINISH FLOOR, WITH COVER.
--- GL --- VEGET PIPING	--- FLOOR SINK
--- GAS --- NATURAL GAS PIPING	--- FLOOR DRAIN
--- PIPING BELOW GRADE	--- PLUMBING CONNECTION
--- UNION: GATE OR BALL VALVE: CHECK VALVE	--- FIRE DEPARTMENT CONNECTION
--- PRESSURE REGULATING VALVE	
--- BALANCING VALVE	

lenity architecture
3150 Letta Court SE, Salem, Oregon 97301
P: 503 399 1090 W: lenityarchitecture.com

COLSON AND COLSON
GENERAL CONTRACTOR, INC.
2860 MAGLCHRIST STREET SE, SUITE 200
SALEM, OREGON, 97302
PHONE (503) 586-7401

PORTLAND RETIREMENT RESIDENCE
802 OCEAN AVE. PORTLAND, MAINE 04103

PLUMBING DETAILS AND SCHEDULES

DATE: 8/28/2015
REVISED DATE: 9/22/2015

SHEET M2.3

PLUMBING