


DIFFUSER, REGISTER AND GRILLE SCHEDULE


SYM	TYPE	FACE	FRAME	DAMPER	FINISH	MODEL NO.
CD-1	CEILING DIFFUSER	LOUVERED	T-BAR	MVD	WHITE	E.H. PRICE SMD
CD-2	CEILING DIFFUSER	LOUVERED	SURFACE	ORD	WHITE	E.H. PRICE SMD
CD-3	CEILING SUPPLY/EXHAUST	LOUVERED	SURFACE	N/A	WHITE	ALDES 'CAR'
CRG-1	CEILING GRILLE	PERFORATED	T-BAR	MVD	WHITE	E.H. PRICE PDR
CRG-2	CEILING GRILLE	PERFORATED	SURFACE	ORD	WHITE	E.H. PRICE PDR
CRG-3	CEILING FILTER GRILLE	PERFORATED	T-BAR	MVD	WHITE	E.H. PRICE 10FF
RG-1	SIDEWALL GRILL	FIXED BAR	1" BORDER	ORD	WHITE	E.H. PRICE S30
SR-1	SIDEWALL SUPPLY GRILL	DOUBLE DEF.	1" BORDER	ORD	WHITE	E.H. PRICE S30
TG-1	TRANSFER GRILL	FIXED BAR	1" BORDER	ORD	WHITE	E.H. PRICE S30
CG-1	CEILING GRILLE	FIXED BAR	SURFACE	ORD	WHITE	E.H. PRICE S30
WL-1	WALL LOUVER	FIXED BAR	6" DEEP	ORD	MILL	RUSKIN ELF6375DX
WL-2	WALL LOUVER	FIXED BAR	2" DEEP		MILL	GREENHECK BRH-201 SIZE: 22X10

ORD = OPPOSED BLADE DAMPER
MVD = MANUAL VOLUME DAMPER


SEE DETAILS 8/M2.1, 9/M2.1, AND 9/M4.0 FOR ALLOWABLE BORING / NOTCHING OF MEMBERS.

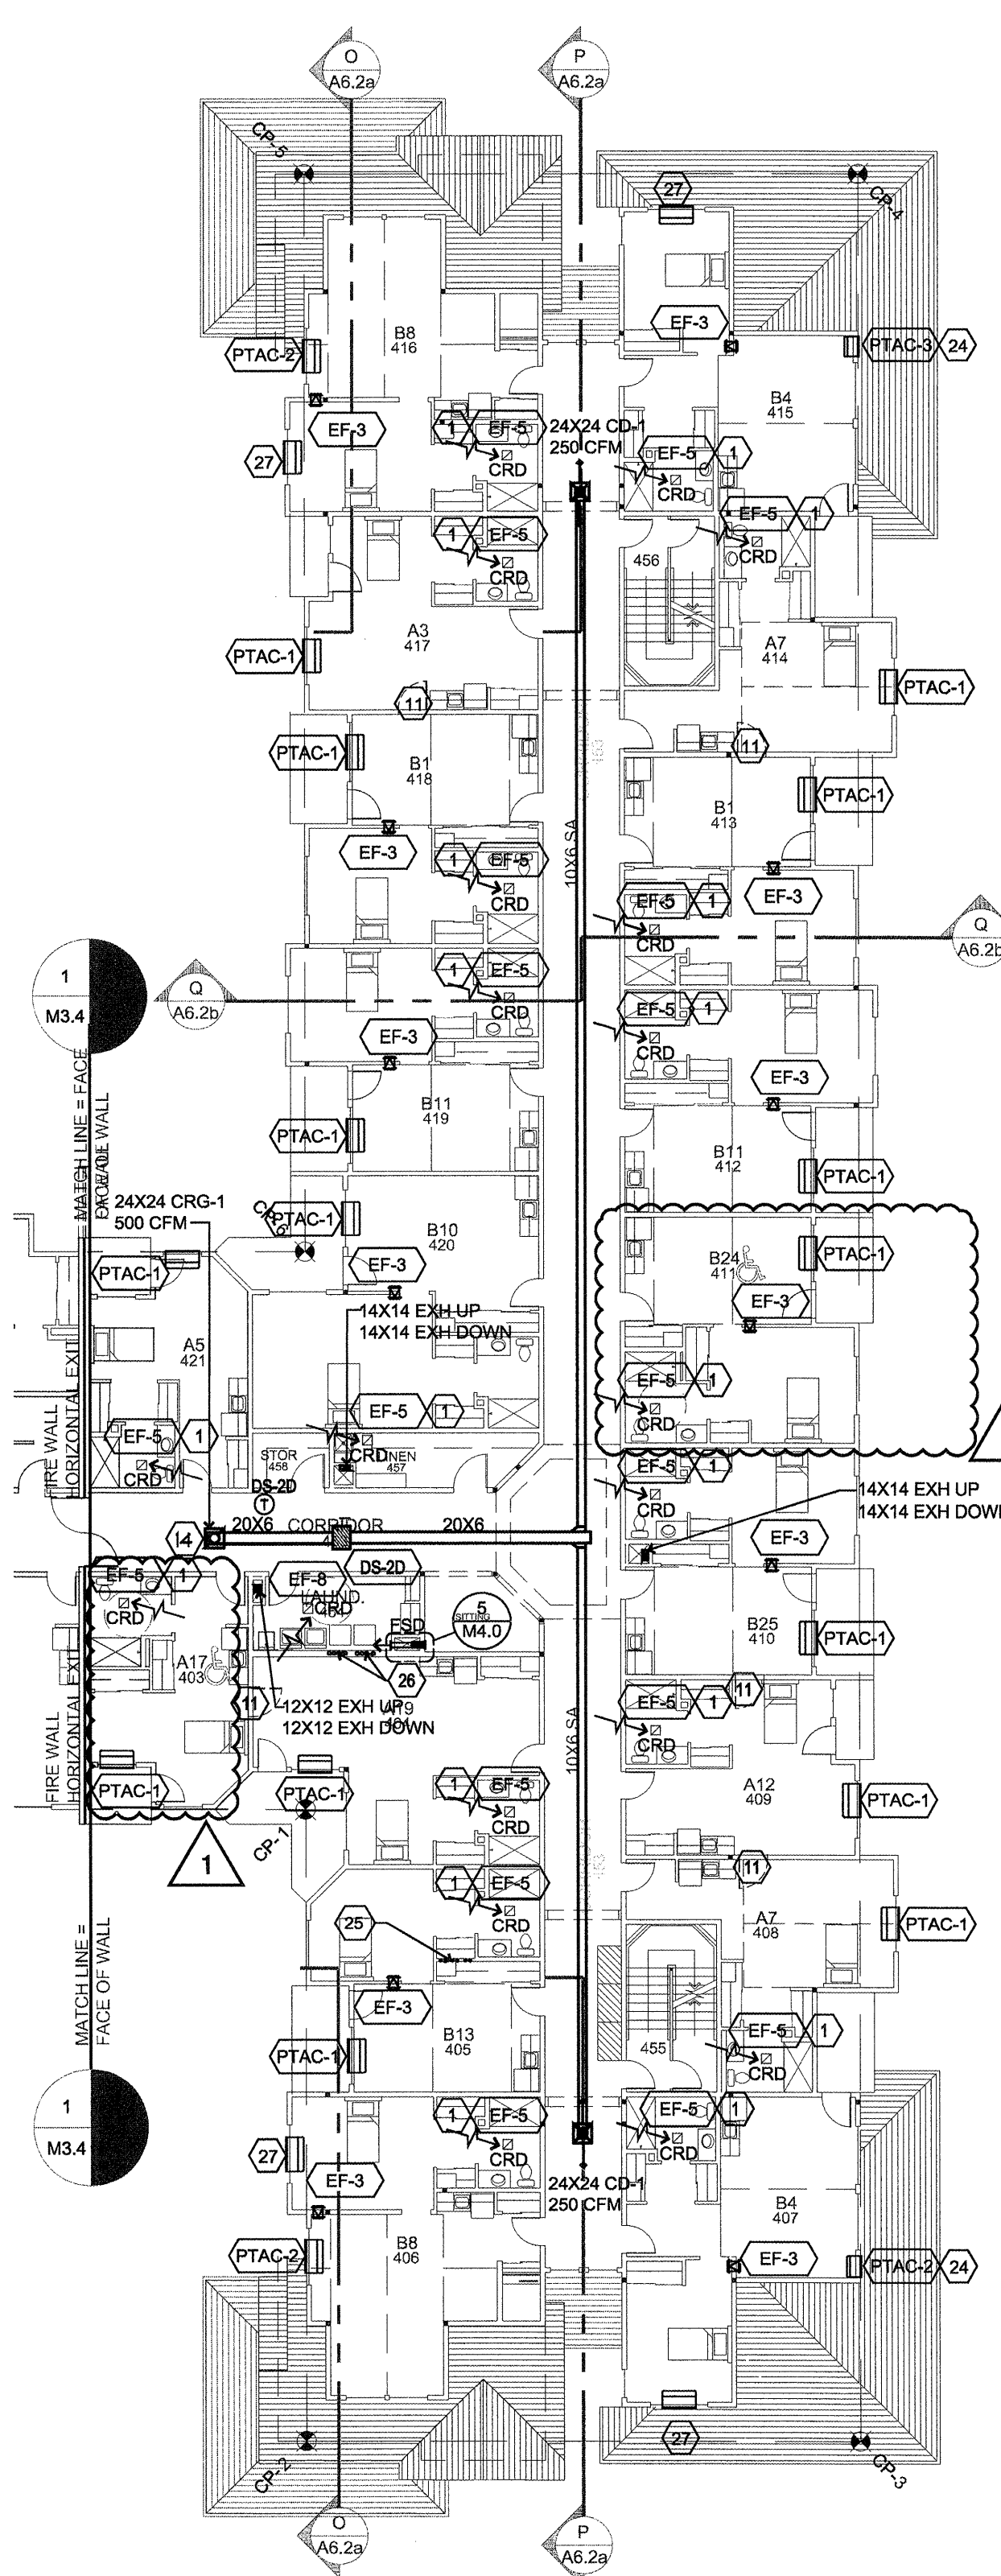


4 FOURTH FLOOR - HVAC
M3.6 SCALE: 1/16" = 1'-0"

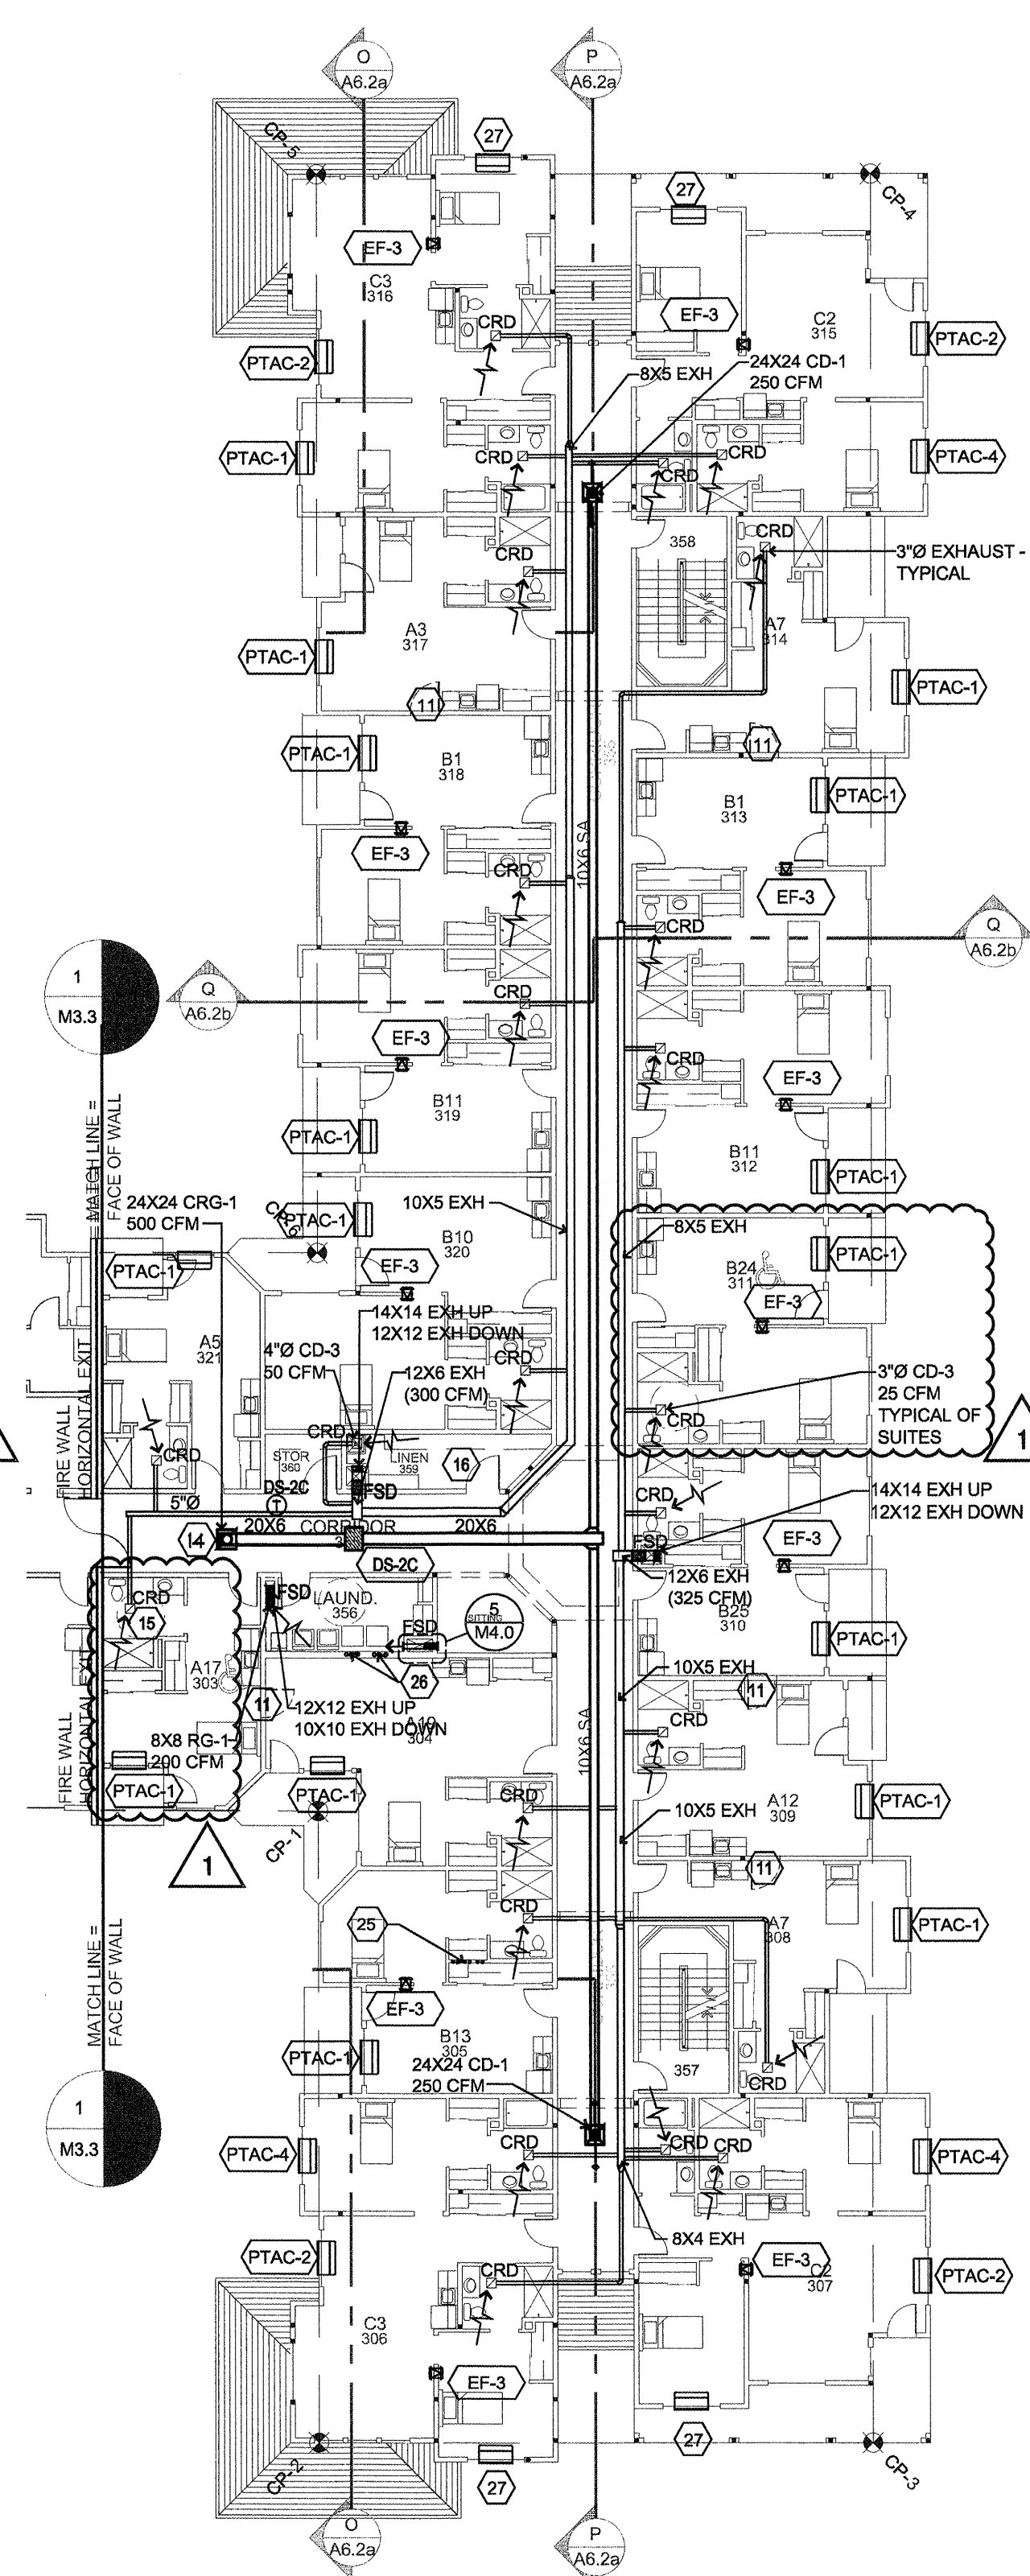

3 THIRD FLOOR - HVAC
M3.6 SCALE: 1/16" = 1'-0"

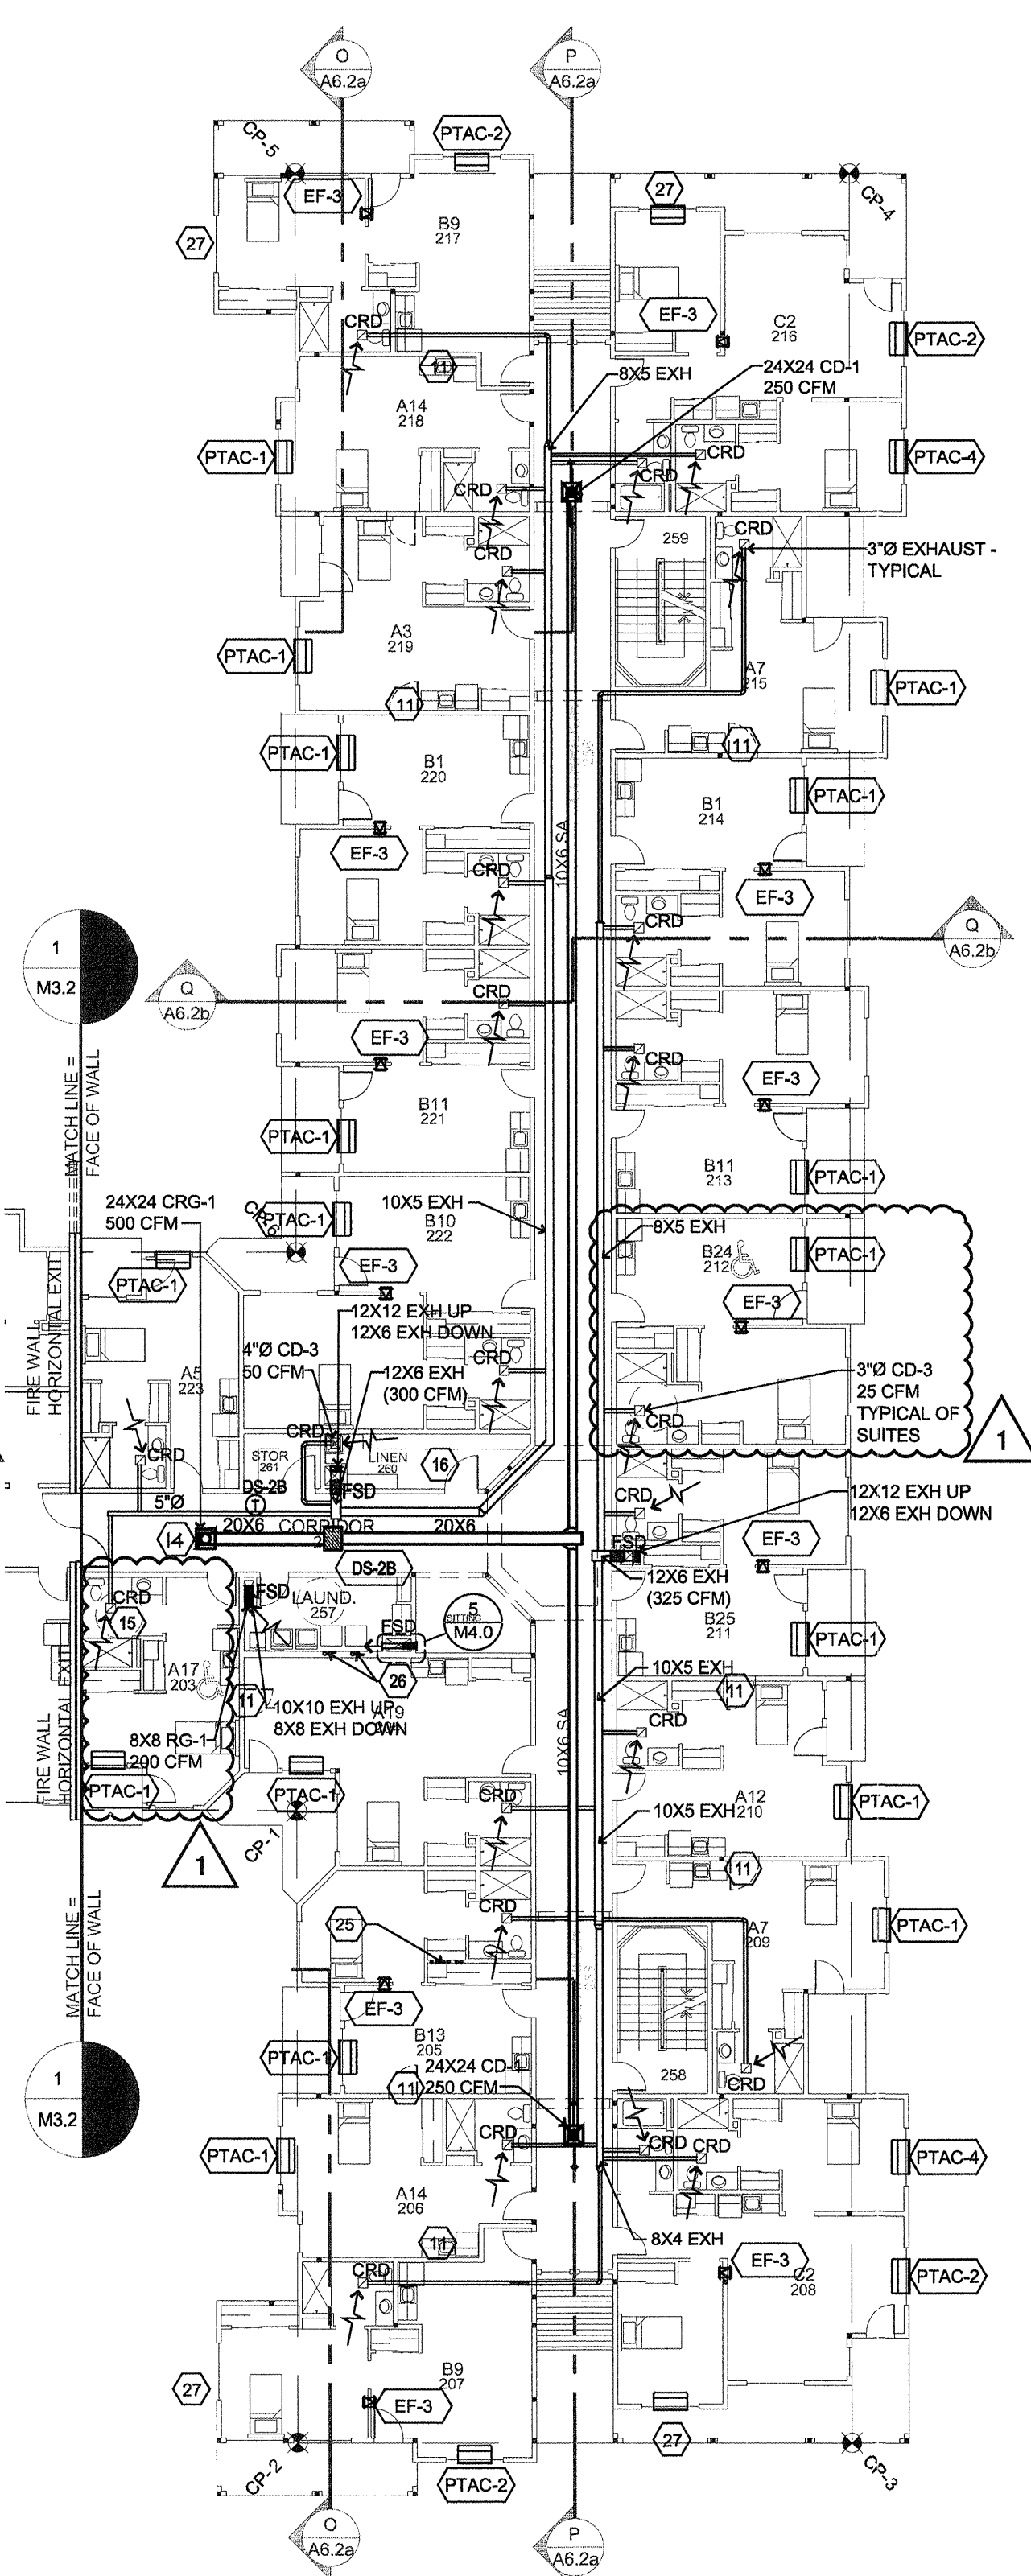


2 SECOND FLOOR - HVAC
M3.6 SCALE: 1/16" = 1'-0"

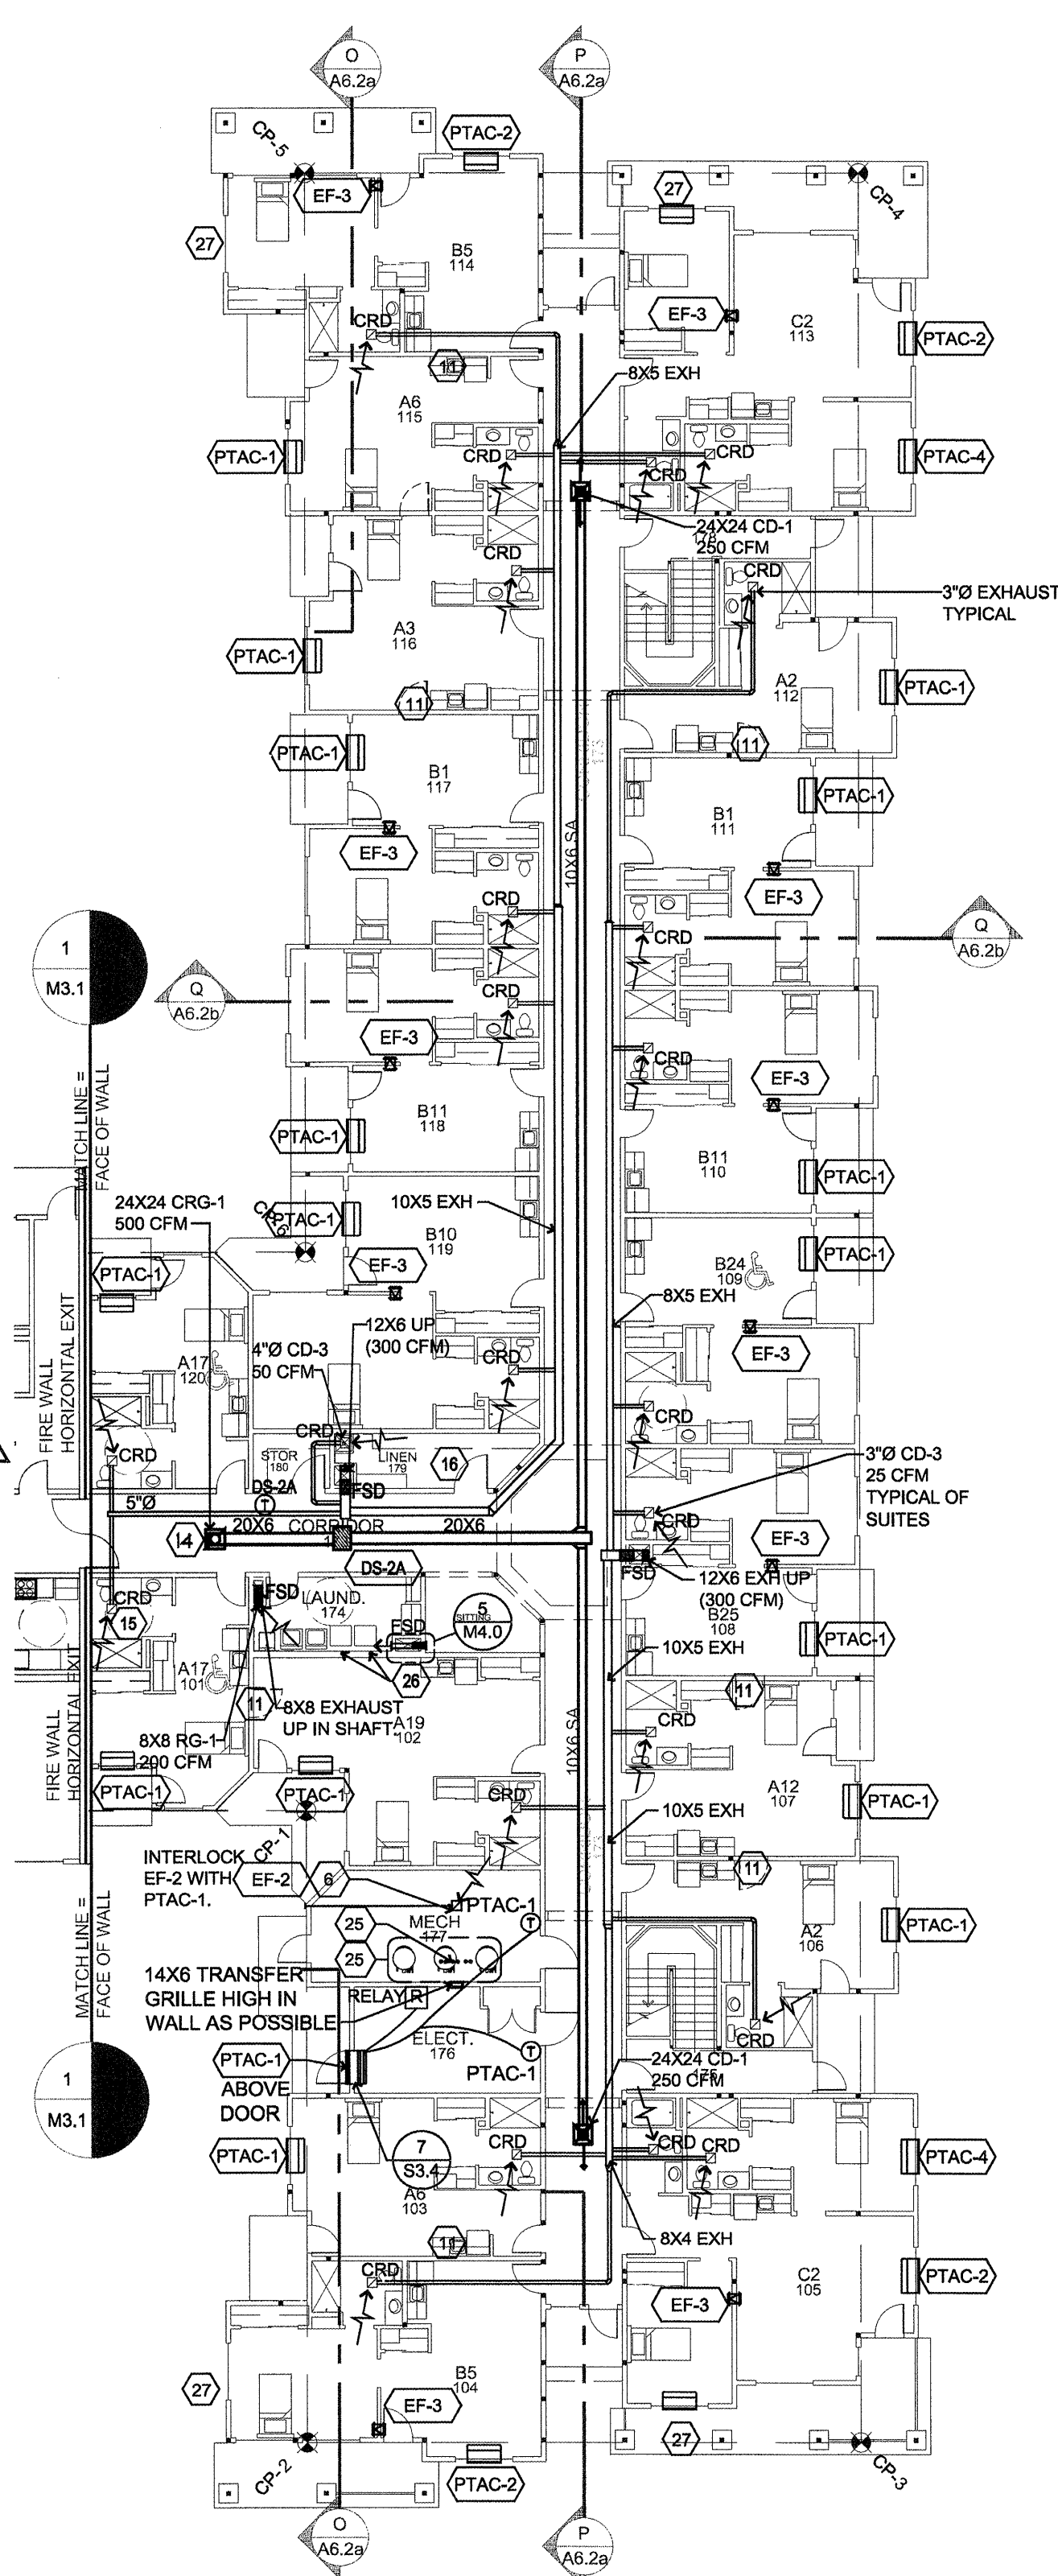

1 FIRST FLOOR - HVAC
M3.6 SCALE: 1/16" = 1'-0"

WING 'B' HVAC PLAN
SCALE: 1/8" = 1'-0"

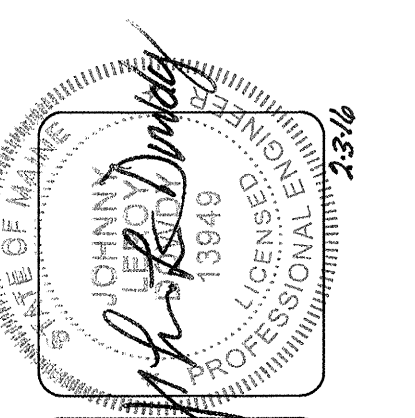

lenity architecture
350 W. Main St., Suite 200
Salem, Oregon 97301
P: 503.399.1090 F: 503.399.0565

COLSON AND COLSON
GENERAL CONTRACTOR, INC.
2260 McGLICHRIST STREET SE, SUITE 200
SALEM, OREGON, 97302
PHONE (503) 586-7401

PORTLAND RETIREMENT RESIDENCE
802 OCEAN AVE. PORTLAND, MAINE 04103

WING 'B' HVAC PLAN

DATE: 8/28/2015

REVISED DATE: 9/22/2015

SHEET: M3.6

