


DIFFUSER, REGISTER AND GRILLE SCHEDULE


SYM	TYPE	FACE	FRAME	DAMPER	FINISH	MODEL NO.
CD-1	CEILING DIFFUSER	LOUVERED	T-BAR	MVD	WHITE	E.H. PRICE SMD
CD-2	CEILING DIFFUSER	LOUVERED	SURFACE	OBD	WHITE	E.H. PRICE SMD
CD-3	CEILING SUPPLY/EXHAUST	LOUVERED	SURFACE	NA	WHITE	ALDES "CAF"
CRG-1	CEILING GRILLE	PERFORATED	T-BAR	MVD	WHITE	E.H. PRICE PDR
CRG-2	CEILING GRILLE	PERFORATED	SURFACE	OBD	WHITE	E.H. PRICE PDR
CRG-3	CEILING FILTER GRILLE	PERFORATED	T-BAR	MVD	WHITE	E.H. PRICE 10FF
RS-1	SIDEWALL GRILLE	FIXED BAR	1" BORDER	OBD	WHITE	E.H. PRICE 530
SR-1	SIDEWALL SUPPLY GRILLE	DOUBLE DEFL.	1" BORDER	OBD	WHITE	E.H. PRICE 520
TG-1	TRANSFER GRILLE	FIXED BAR	1" BORDER	OBD	WHITE	E.H. PRICE 530
CTG-1	CEILING GRILLE	FIXED BAR	SURFACE	OBD	WHITE	E.H. PRICE 530
WL-1	WALL LOUVER	FIXED BAR	6" DEEP	OBD	MILL	RUSKIN ELF6375DX
WL-2	WALL LOUVER	FIXED BAR	2" DEEP	MILL	GREENHECK EHH-201	SIZE: 22X10

OBD = OPPOSED BLADE DAMPER.
MVD = MANUAL VOLUME DAMPER.


SEE DETAILS 8/M2.1, 9/M2.1, AND 9/M4.0 FOR ALLOWABLE BORING / NOTCHING OF MEMBERS.

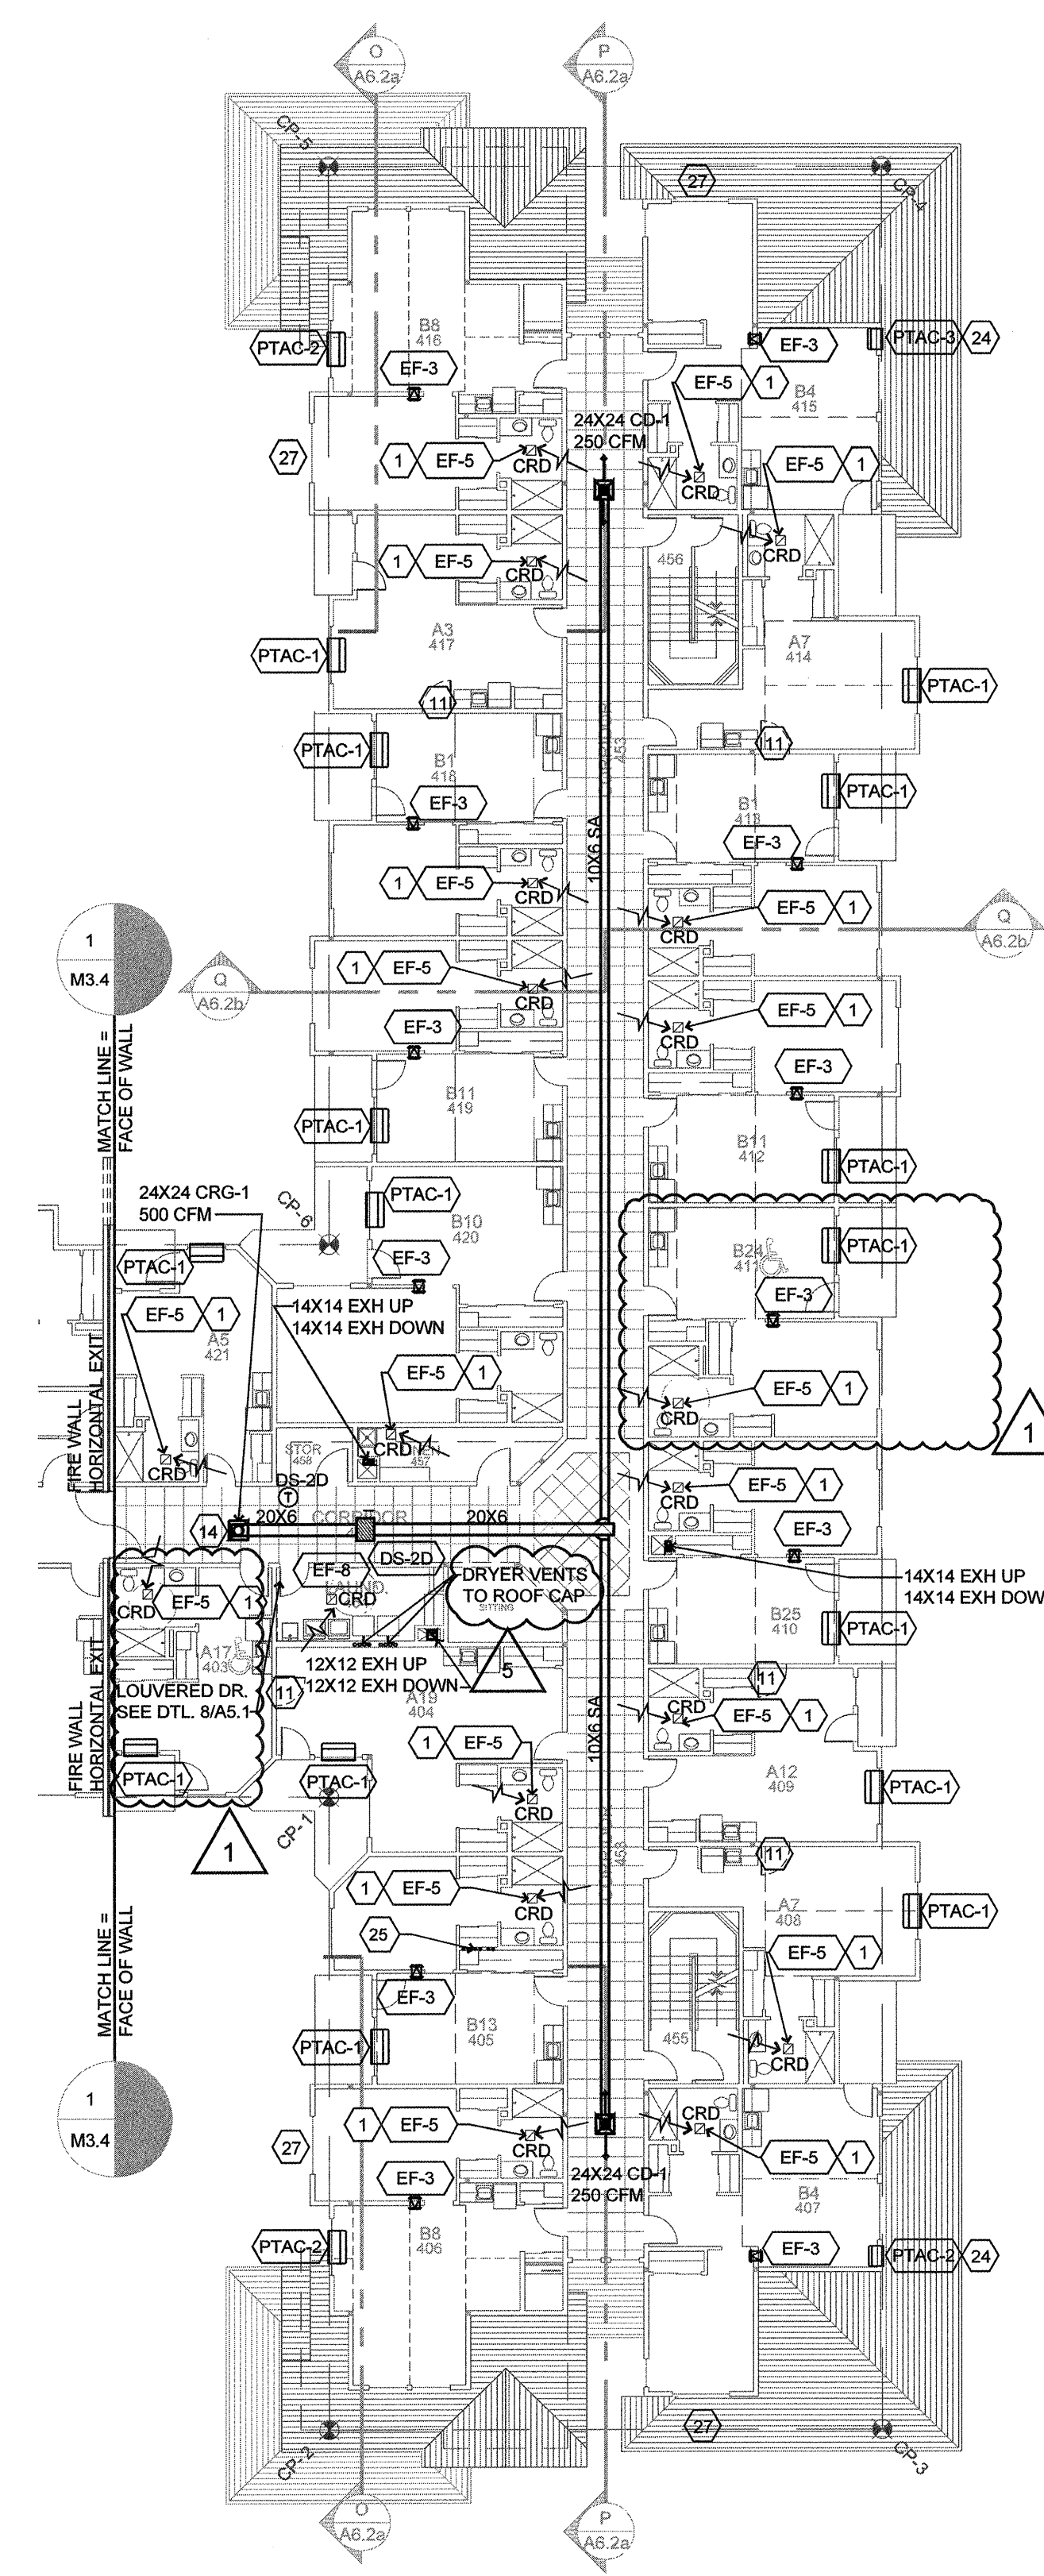


4 FOURTH FLOOR - HVAC
M3.6 SCALE: 1/16" = 1'-0"

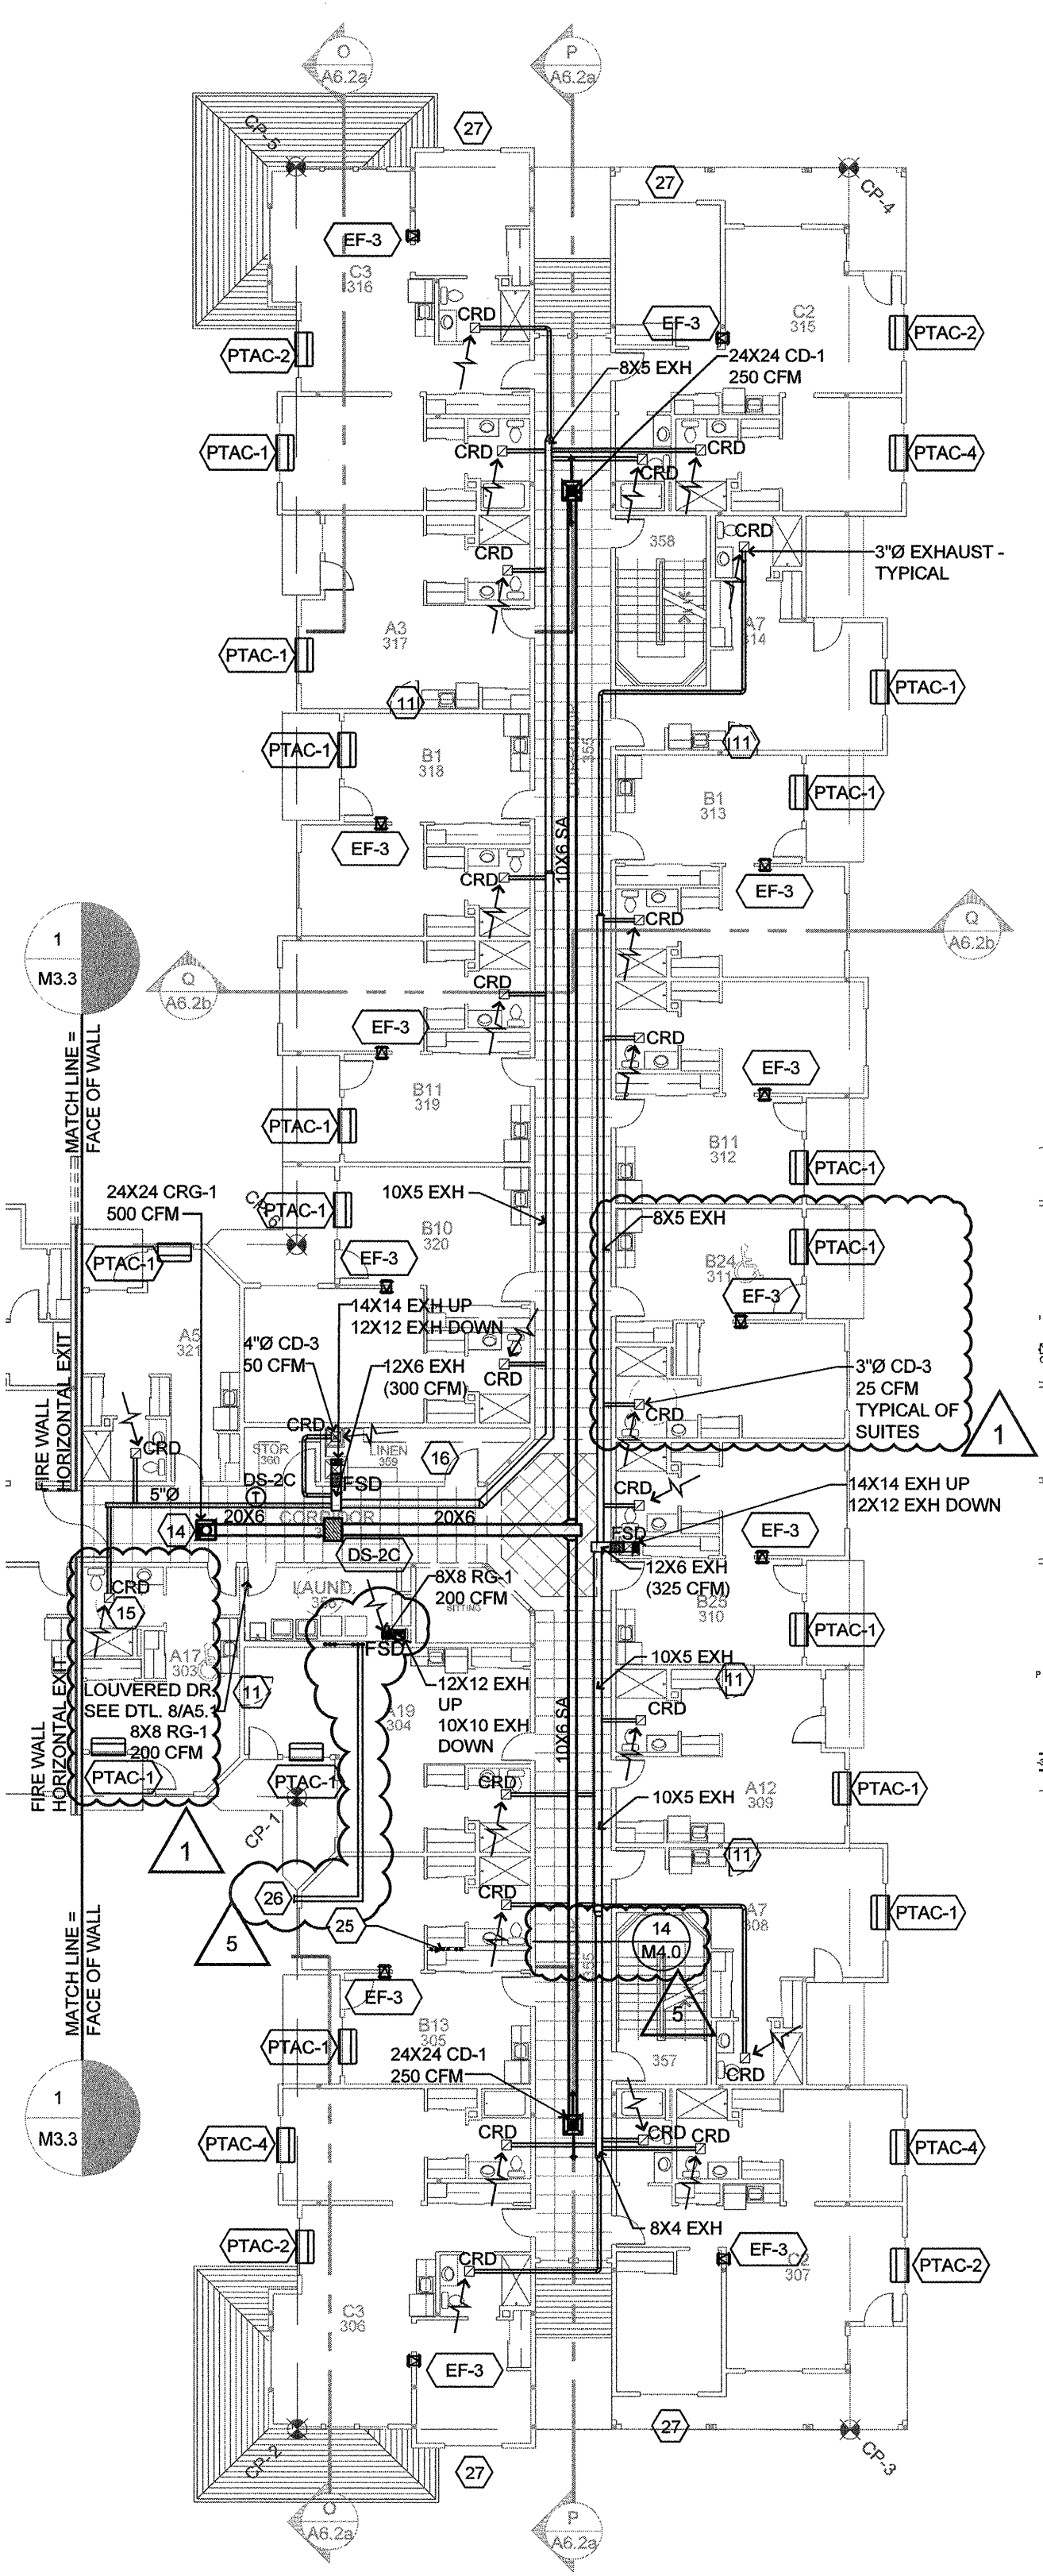

3 THIRD FLOOR - HVAC
M3.6 SCALE: 1/16" = 1'-0"

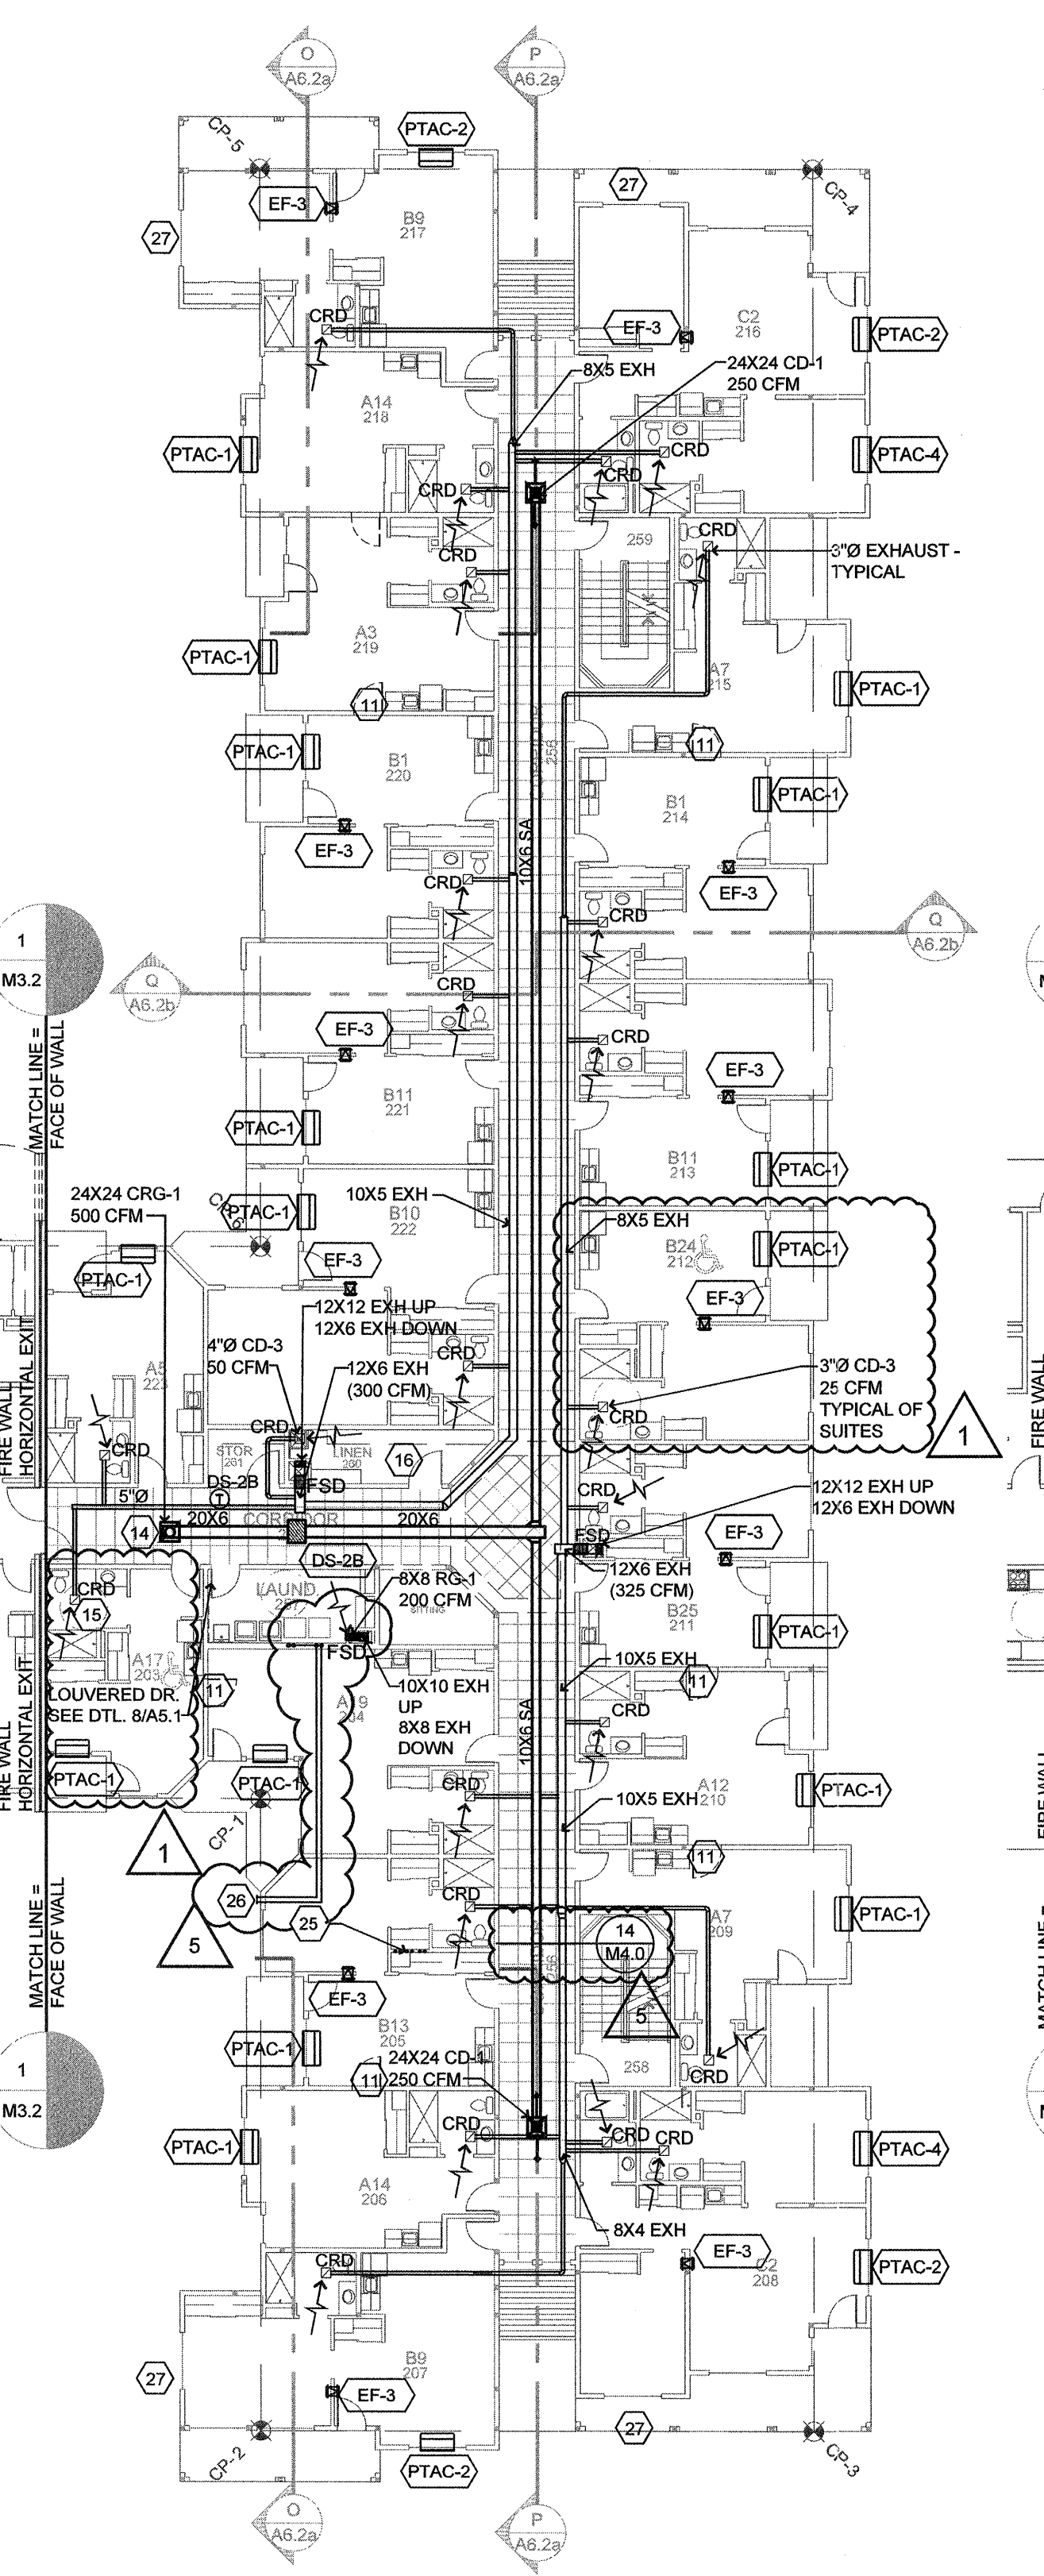


2 SECOND FLOOR - HVAC
M3.6 SCALE: 1/16" = 1'-0"

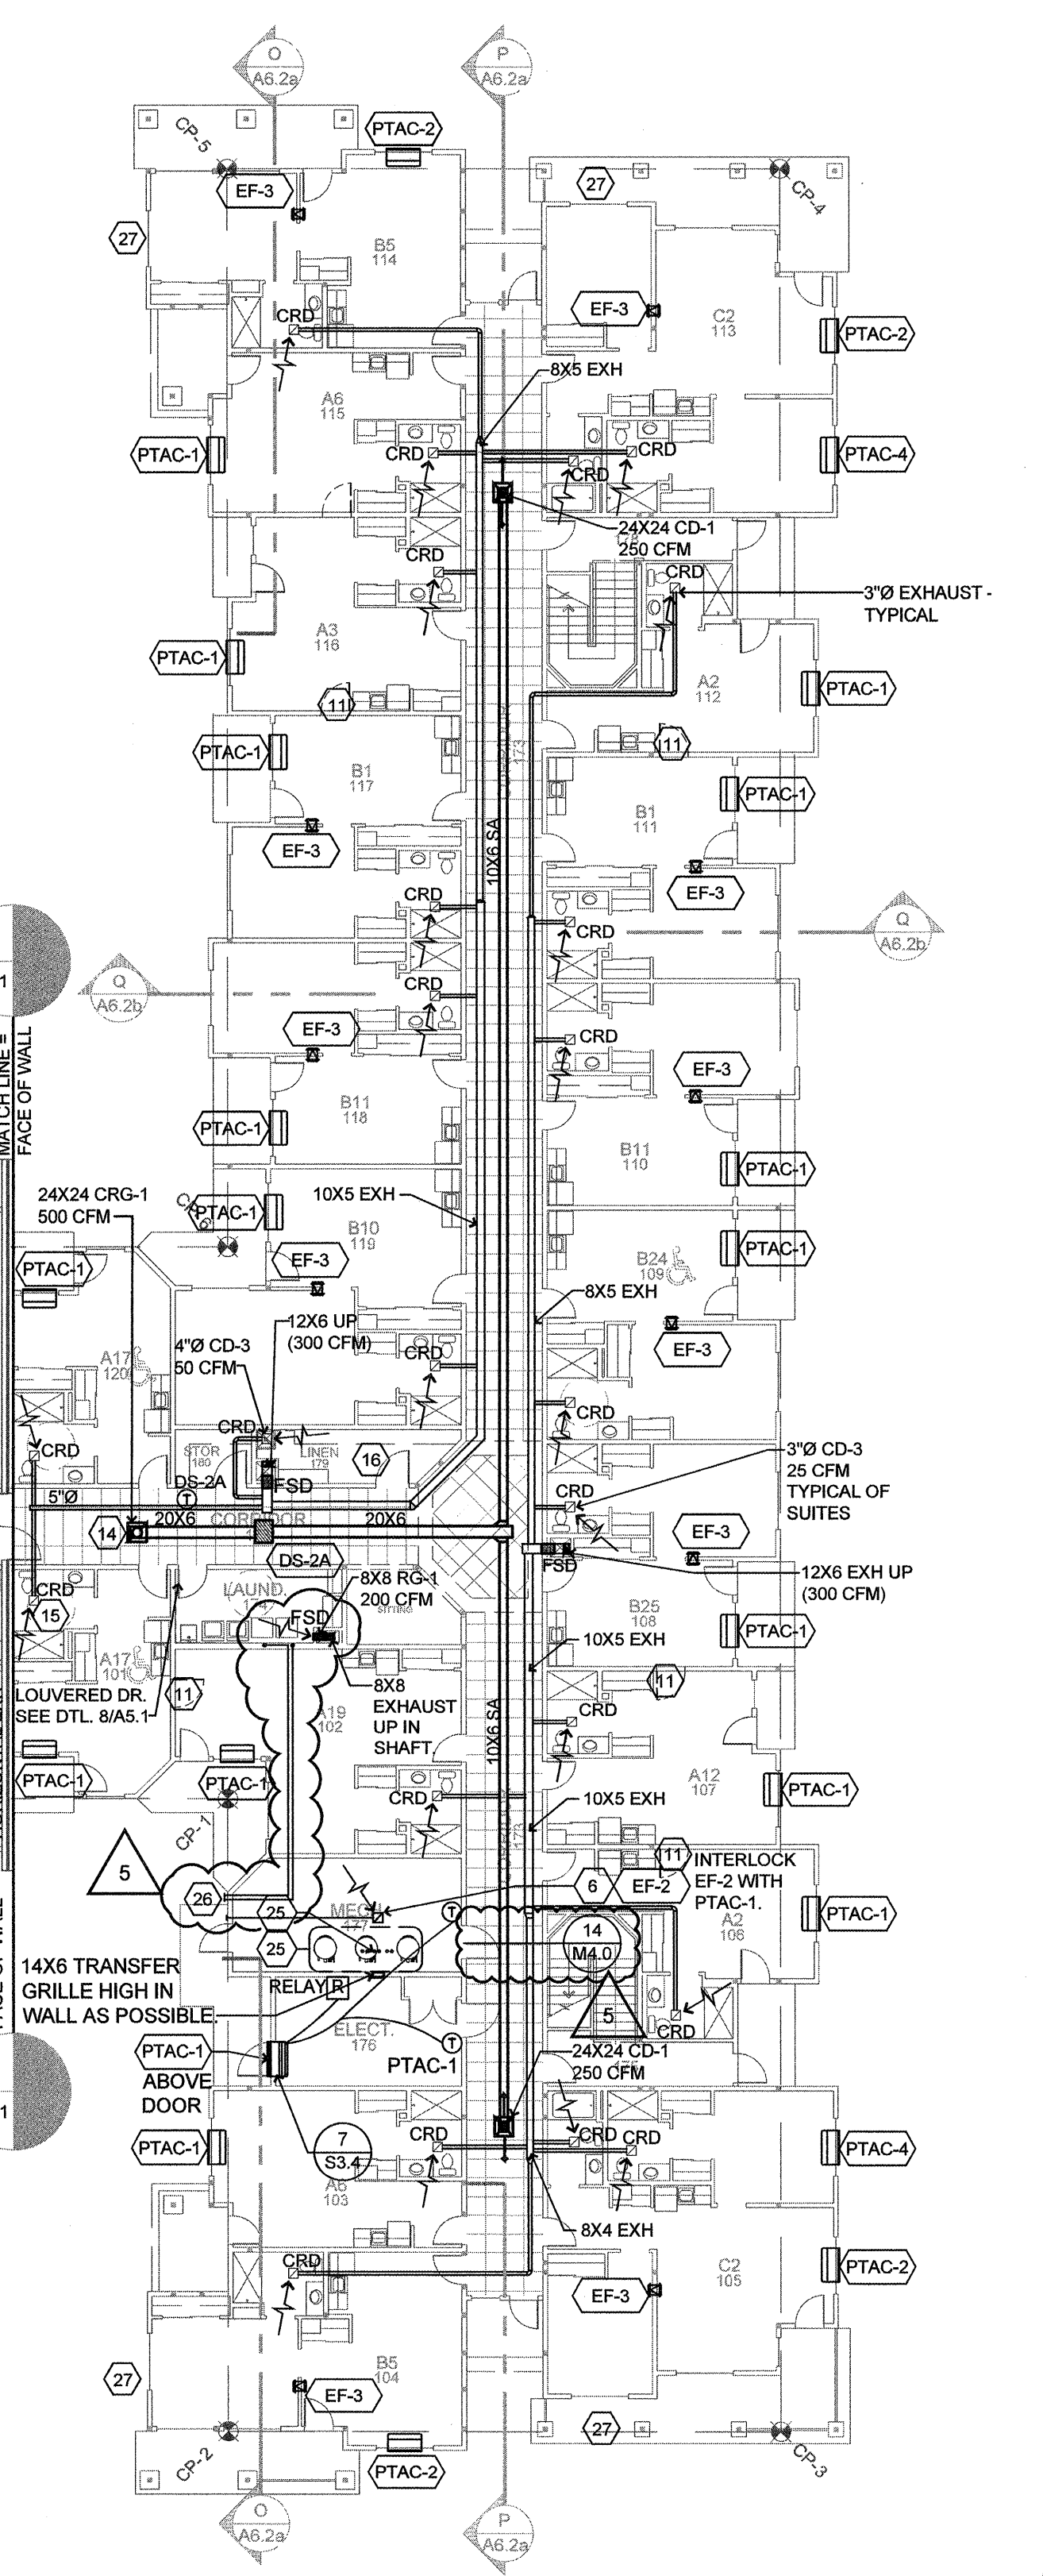

1 FIRST FLOOR - HVAC
M3.6 SCALE: 1/16" = 1'-0"

WING 'B' HVAC PLAN
SCALE: 1/8" = 1'-0"

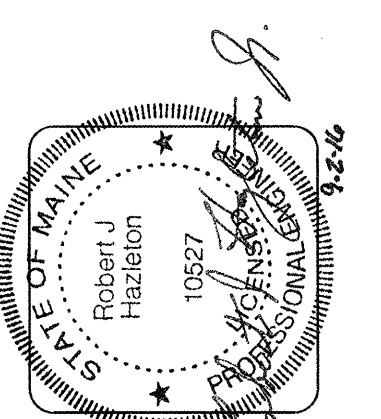

lenity architecture
3150 Lettice Court, SE, Salem, Oregon 97301
P: 503.399.1090 F: 503.399.0585

COLSON AND COLSON
GENERAL CONTRACTOR, INC.
2280 MACGILCHRIST STREET, SE, SUITE 200
SALEM, OREGON, 97302
PHONE (503) 586-7401

PORTLAND
RETIREMENT RESIDENCE
802 OCEAN AVE. PORTLAND, MAINE 04103

WING 'B'
HVAC PLAN

DATE: 8/28/2015
REVISED DATE: 9/22/2015
2/2/2016
7/18/2016

SHEET
M3.6

