

**HVAC KEY NOTES:**

- 1 4" EXHAUST DUCT FROM BATHROOM EXHAUST FAN TO APPROVED DISCHARGE CAP WITH INTEGRAL BACK DRAFT DAMPER. MAINTAIN 3FT MIN. CLEARANCE TO BUILDING OPENINGS, AND 10' MIN. FROM MECHANICAL FRESH AIR INTAKES. SEE 3/M4.0 FOR ROOF DISCHARGE DETAIL.
- 2 HOOD DRAWINGS (H-1 - H-8) FOR ADDITIONAL INFORMATION.
- 3 SEE SHEET M4.2 FOR KITCHEN HOOD SECTIONS.
- 4 DISHWASHER: TYPE II HOOD AND EXHAUST SYSTEM.
- 5 6" SHEETMETAL EXHAUST DUCT IN SOFFIT TO APPROVED SOFFIT CAP WITH BACKDRAFT DAMPER.
- 6 6" EXHAUST DUCT TO APPROVED DISCHARGE CAP WITH INTEGRAL BACK DRAFT DAMPER. MAINTAIN 3FT MIN. CLEARANCE TO ALL OPENINGS, SEE 3/M4.0 FOR ROOF DISCHARGE DETAIL.
- 7 7" RANGE EXHAUST DUCT TO APPROVED CAP. PROVIDE UL LISTED FIRE CAULKING AT RATED MEMBRANE PENETRATIONS.
- 8 OUTDOOR COOLER/ FREEZER UNITS. ROUTE REFRIGERATION LINES UNDER SLAB IN 6" CONDUIT WITH LONG SWEEPS.
- 9 INSTALL ATTIC FANS (EF-9) NEAR ROOF PEAK, OPPOSITE OF MAIN PARKING.
- 10 8" EXHAUST DUCT FROM EXHAUST FAN TO APPROVED DISCHARGE CAP WITH INTEGRAL BACK DRAFT DAMPER. MAINTAIN 3FT MIN. CLEARANCE TO ALL OPENINGS, SEE 3/M4.0 FOR ROOF DISCHARGE DETAIL.
- 11 LOCATION OF FUTURE DOOR
- 12 MECHANICAL SHAFT COORDINATE WITH ARCHITECTURAL AND STRUCTURAL. SEE DETAILS 8/A8.8 AND 2/S2.5.
- 13 SPLIT SYSTEM EVAPORATORS, SEE MECH. SPECIFICATIONS
- 14 FILTER RETURN GRILLE FOR T-BAR INSTALLATION.
- 15 LAUNDRY MAKE UP AIR -SEE DETAIL 5/M4.0
- 16 ROUTE DRAIN OVER AND DOWN IN WALL. DAYLIGHT INTO JANITOR SINK.
- 17 NOT USED.
- 18 8x8 EXHAUST DUCT TO APPROVED CAP.
- 19 ROUTE ALL DUCTWORK UNDER MECHANICAL WELL INTO ATTIC SPACE.
- 20 SEE SHEETS SMOKE CONTROL SHEETS SC1.1, 1.2 1.3, 1.4 AND SC2.1 FOR ATRIUM SMOKE EXHAUST
- 21 COORDINATE DUCT ROUTING CLOSELY W/ STRUCTURAL. NOTIFY ARCHITECT IF CONFLICTS OCCUR. TYPICAL FOR ALL AREAS OF BUILDING.
- 22 W/ FSD AT TOP OF SHAFT
- 23 DRYER VENT, (4" MIN., MATCH DRYER DISCHARGE) EXHAUST DUCT TO APPROVED ROOF CAP WITH INTEGRAL BACK DRAFT DAMPER.
- 24 MOUNT PTAC UNIT 8" ABOVE OUTSIDE ROOF LINE. PROVIDE REMOTE THERMOSTAT OR REMOTE CONTROLLER WHERE MANUFACTURER EQUIPMENT HAS NO OPTION FOR REMOTE THERMOSTAT.
- 25 WATER HEATER VENTING UP. PROVIDE 3" PVC FOR VENT AND 3" PVC FOR COMBUSTION AIR. SEE DETAILS 1/M2.2 AND 14/M4.0.
- 26 DRYER VENT, 4" EXHAUST DUCT TO IN-Q-VATE DRYER BOX AT WALL PENETRATION. PROVIDE UL LISTED RATED SEAL AT MEMBRANE PENETRATIONS, SEE SHEET M4.0 FOR DRYER DETAILS.
- 27 PROVIDE CONDENSATE LINE FOR FUTURE THRU-WALL PTAC UNITS IN "C" UNIT SPARE BEDROOMS.


**lenity**  
 architecture  
 3150 Wells Court SE, Salem, Oregon 97301  
 P 503 999 1080  
 F 503 999 0565  
 www.lenityarchitecture.com

**COLSON AND COLSON**  
 GENERAL CONTRACTOR, INC.  
 2260 McMillan Street SE, Suite 200  
 Salem, Oregon, 97302  
**PHONE (503) 586-7401**

**PORTLAND**  
 RETIREMENT RESIDENCE  
 802 OCEAN AVE. PORTLAND, MAINE 04103

**ATTIC CORE**  
 HVAC PLAN

DATE  
 8/28/2015  
 REVISED DATE  
 9/22/2015  
**SHEET**  
**M3.5**

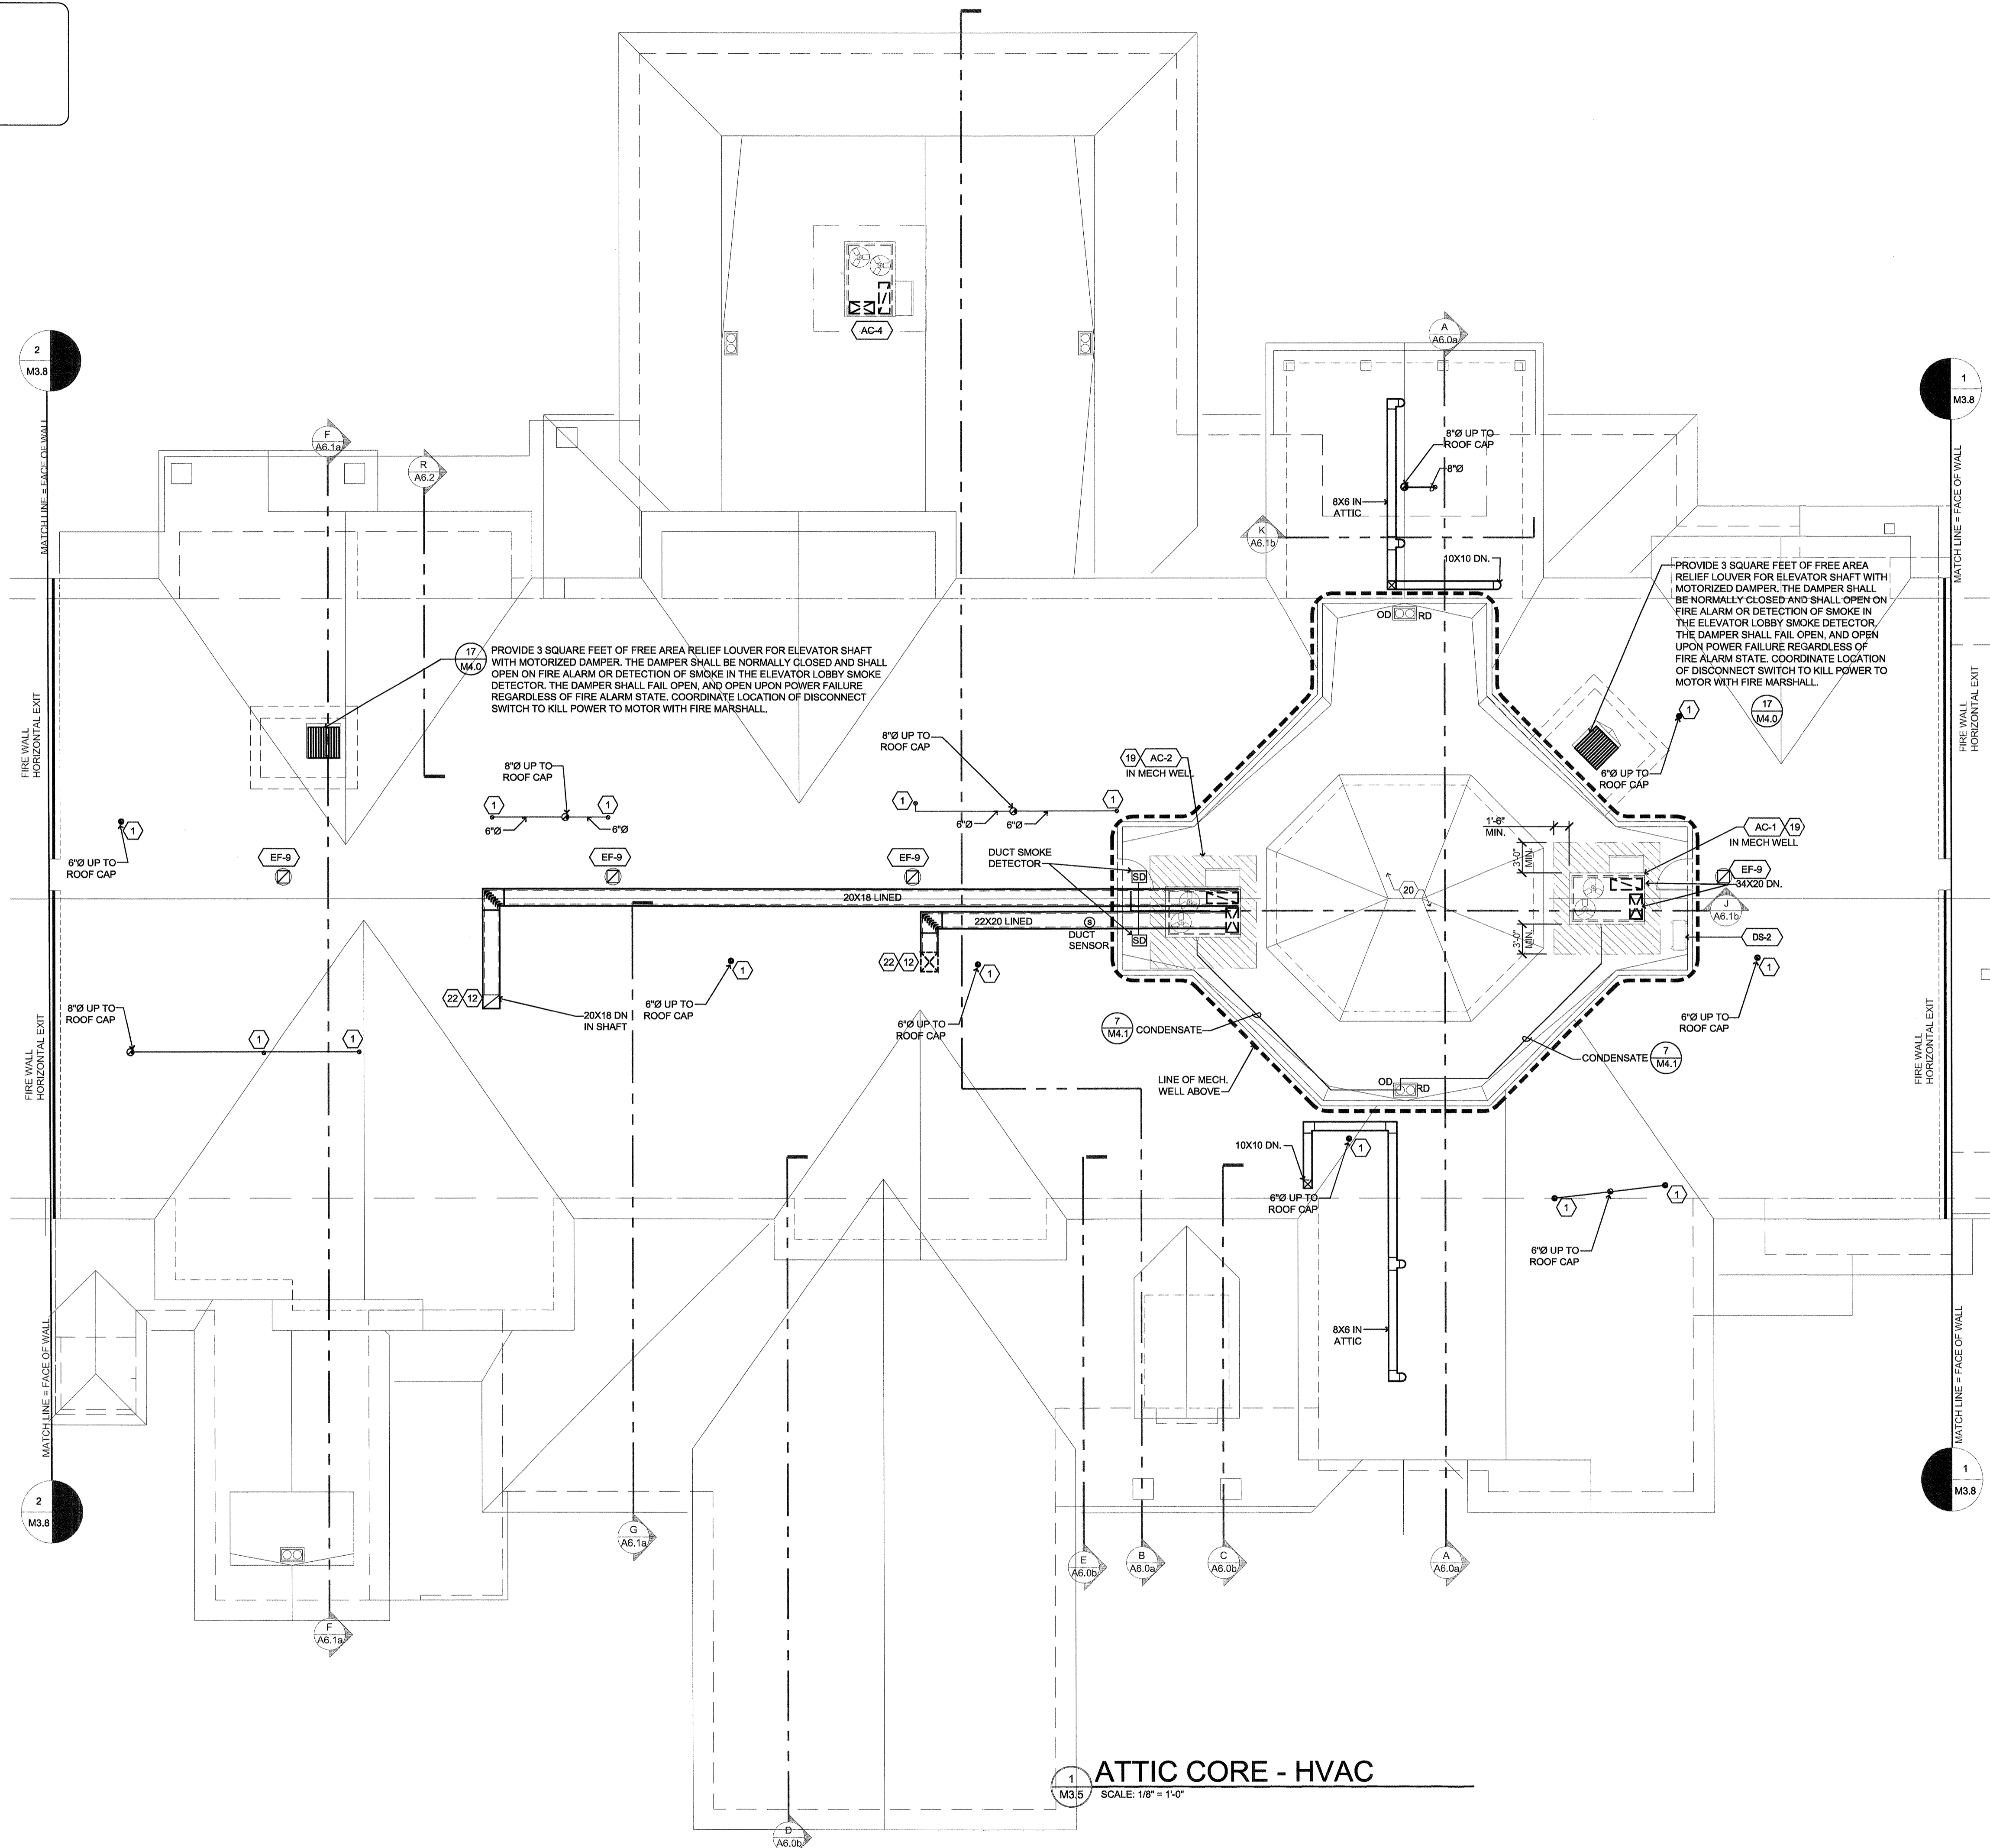

**DIFFUSER, REGISTER AND GRILLE SCHEDULE**

SYM	TYPE	FACE	FRAME	DAMPER	FINISH	MODEL NO.
CD-1	CEILING DIFFUSER	LOUVERED	T-BAR	MVD	WHITE	E.H. PRICE 580
CD-2	CEILING DIFFUSER	LOUVERED	SURFACE	CRD	WHITE	E.H. PRICE 580
CD-3	CEILING SUPPLY/EXHAUST	LOUVERED	SURFACE	N/A	WHITE	ALDES "CAR"
CRG-1	CEILING GRILLE	PERFORATED	T-BAR	MVD	WHITE	E.H. PRICE PDR
CRG-2	CEILING GRILLE	PERFORATED	SURFACE	CRD	WHITE	E.H. PRICE PDR
CRG-3	CEILING FILTER GRILLE	PERFORATED	T-BAR	MVD	WHITE	E.H. PRICE TOFF
RG-1	SIDEWALL GRILL	FIXED BAR	1" BORDER	CRD	WHITE	E.H. PRICE 530
SR-1	SIDEWALL SUPPLY GRILL	DOUBLE DEFL.	1" BORDER	CRD	WHITE	E.H. PRICE 520
TG-1	TRANSFER GRILL	FIXED BAR	1" BORDER	CRD	WHITE	E.H. PRICE 530
CTG-1	CEILING GRILLE	FIXED BAR	SURFACE	CRD	WHITE	E.H. PRICE 530
WL-1	WALL LOUVER	FIXED BAR	8" DEEP	CRD	MILL	RUSKIN ELP8750X
WL-2	WALL LOUVER	FIXED BAR	2" DEEP		MILL	GREENHECK EHH-201 SIZE: 22X10

CRD = OPPOSED BLADE DAMPER  
 MVD = MANUAL VOLUME DAMPER

SEE DETAILS 8/M2.1, 9/M2.1, AND 9/M4.0 FOR ALLOWABLE BORING / NOTCHING OF MEMBERS.

**ATTIC CORE - HVAC**  
 SCALE: 1/8" = 1'-0"