




**8 EXTERIOR TRUSS BLOCKING (ROOF AT CANOPY)**  
SCALE: 3/4" = 1'-0"

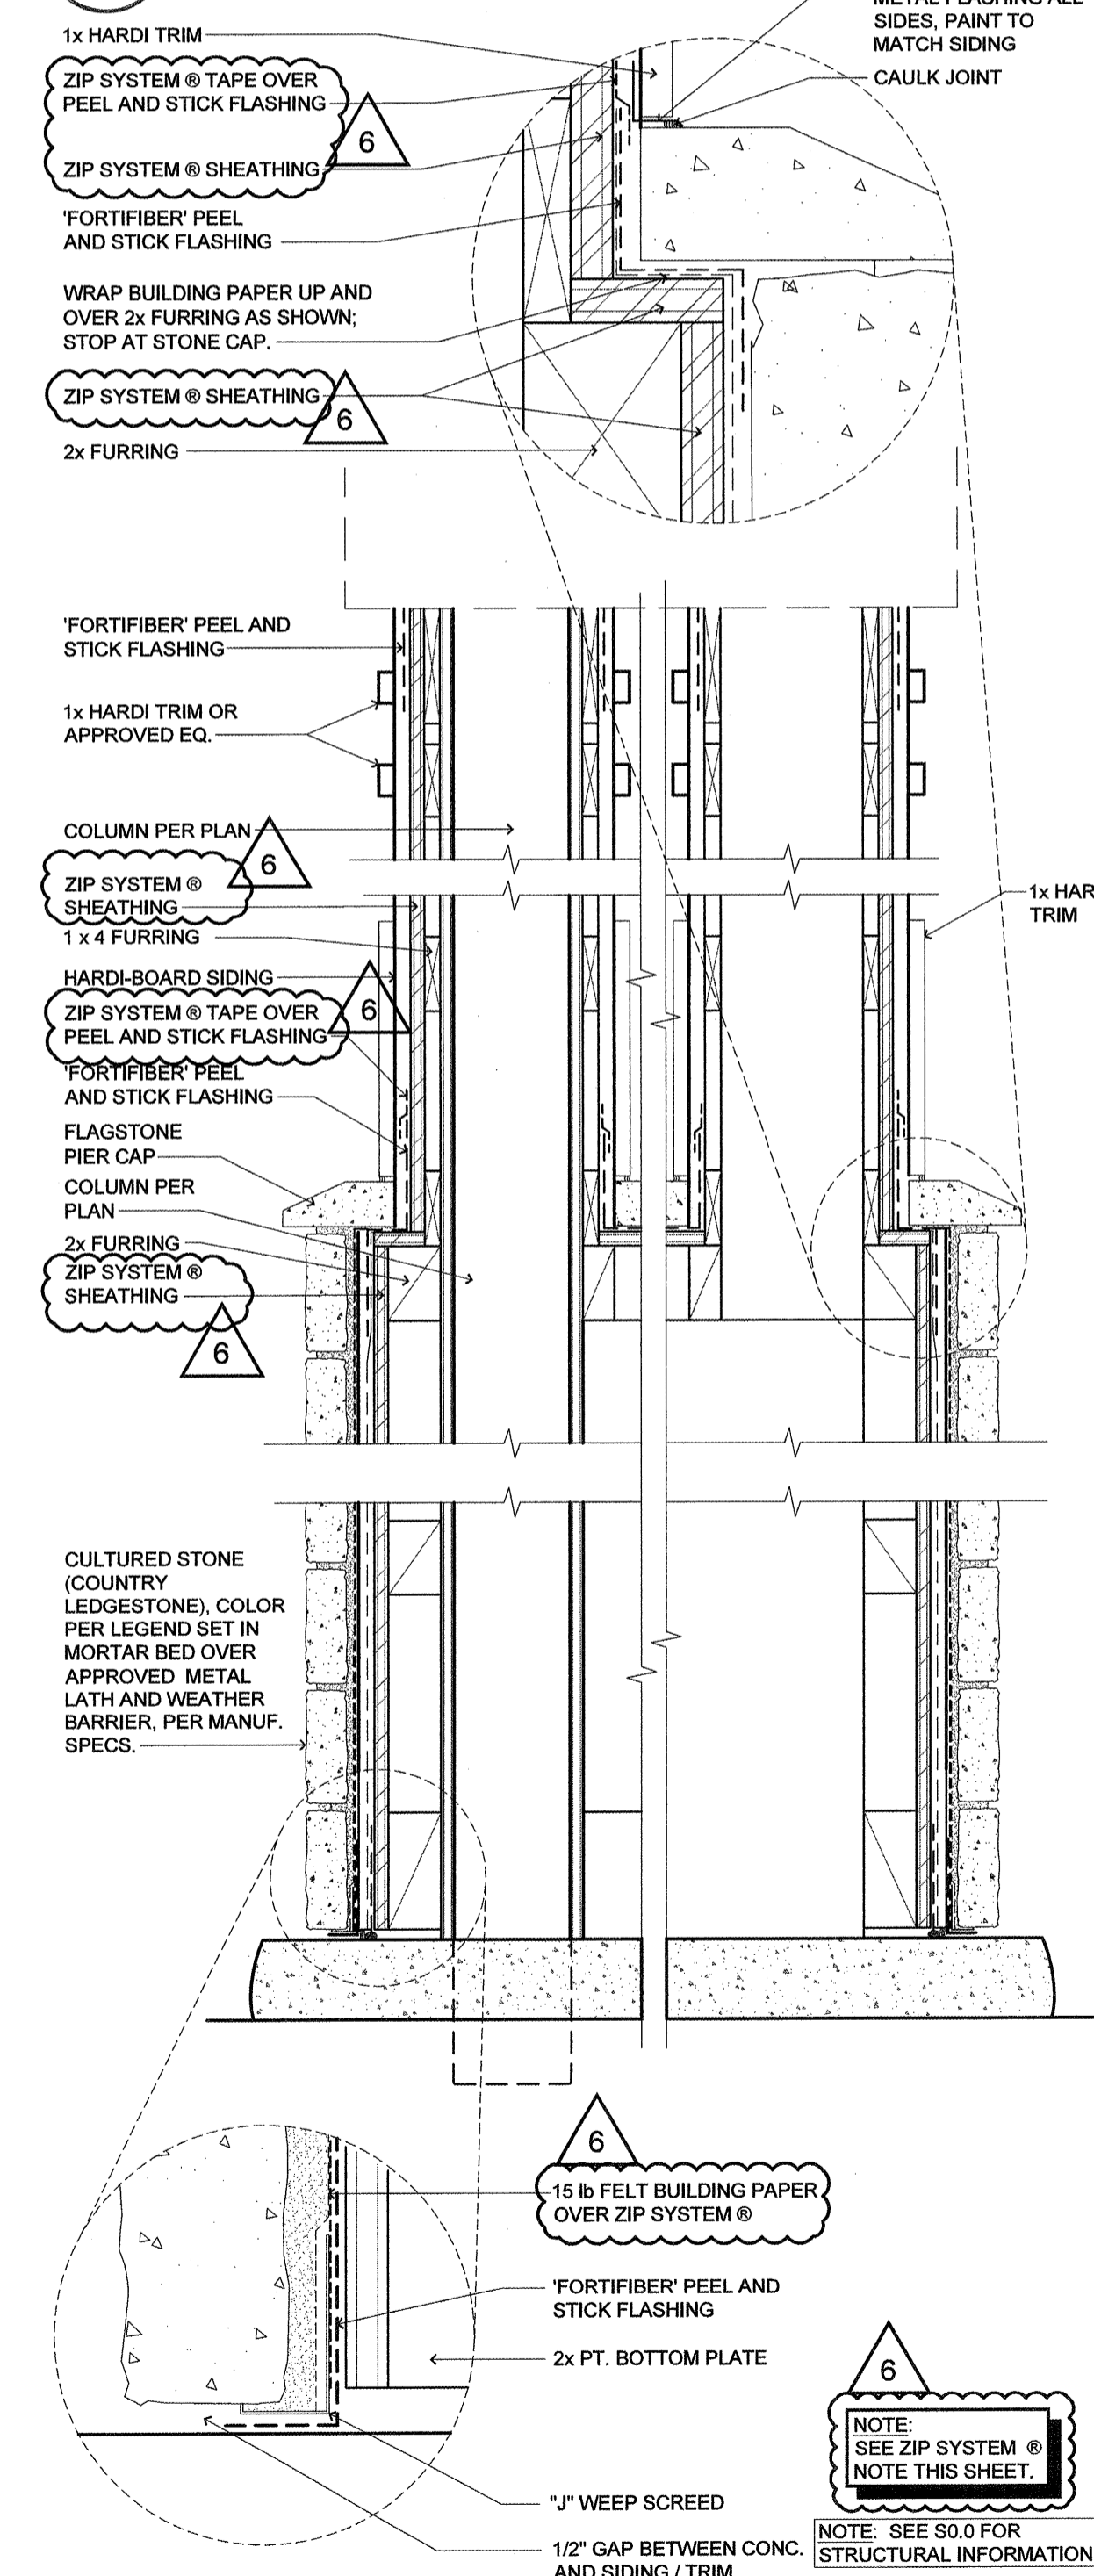


**5 ENTRY CANOPY COLUMN (TRIM AND FLASHING)**  
SCALE: 1 1/2" = 1'-0"

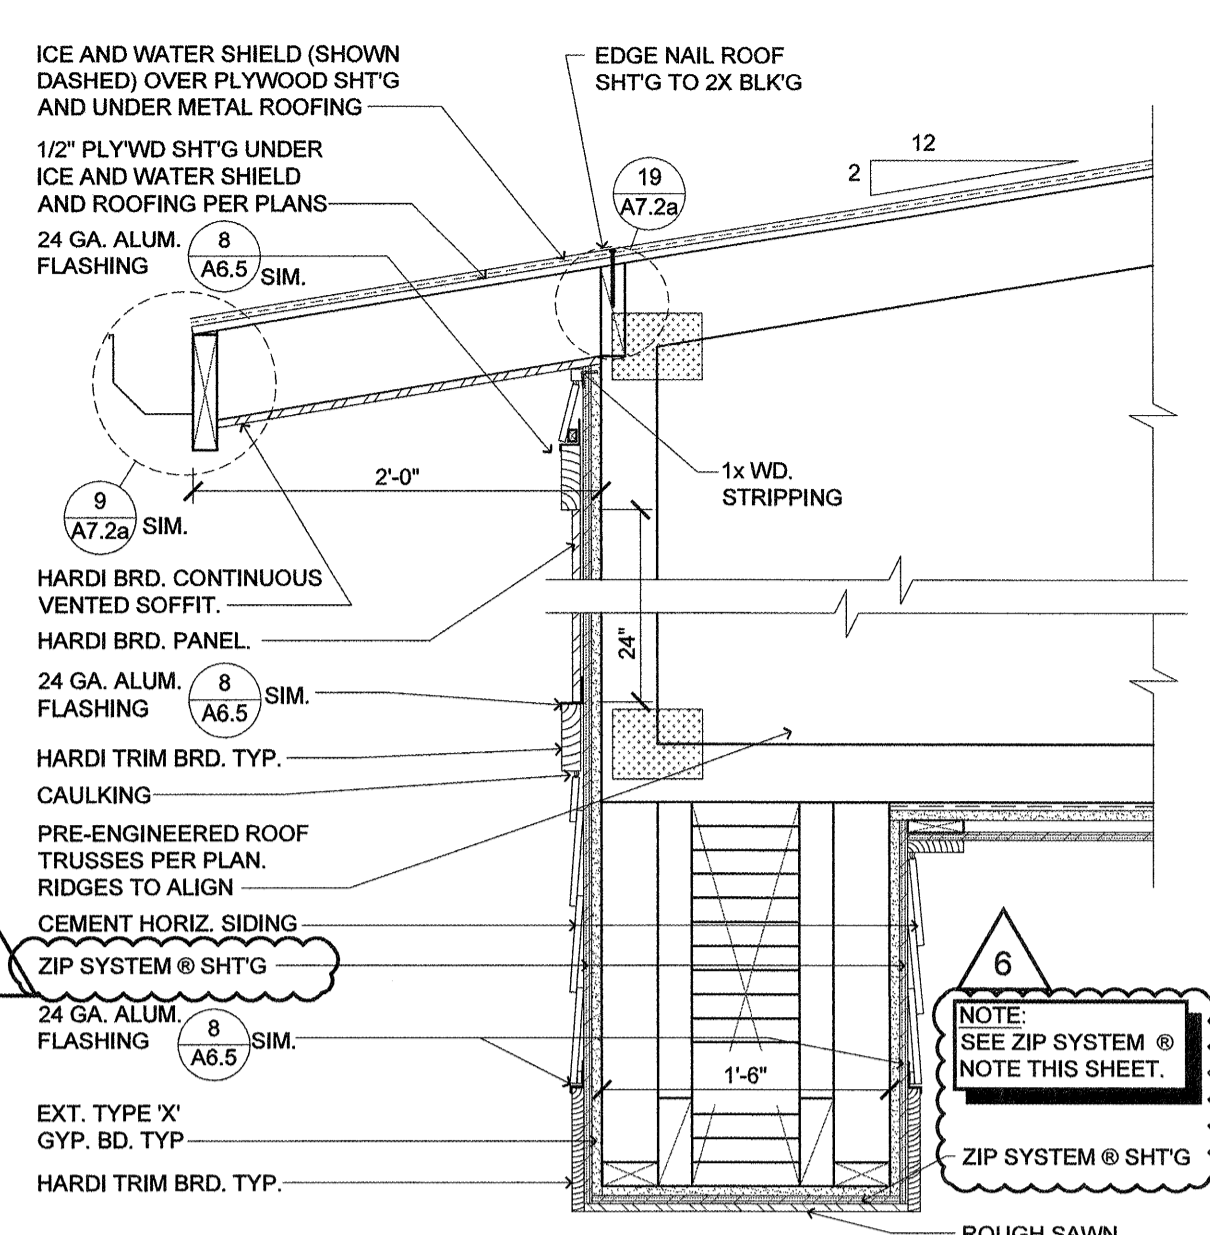

**7 TRIM WORK ON SOFFIT BOX (ENTRY CANOPY)**  
SCALE: 1/2" = 1'-0"

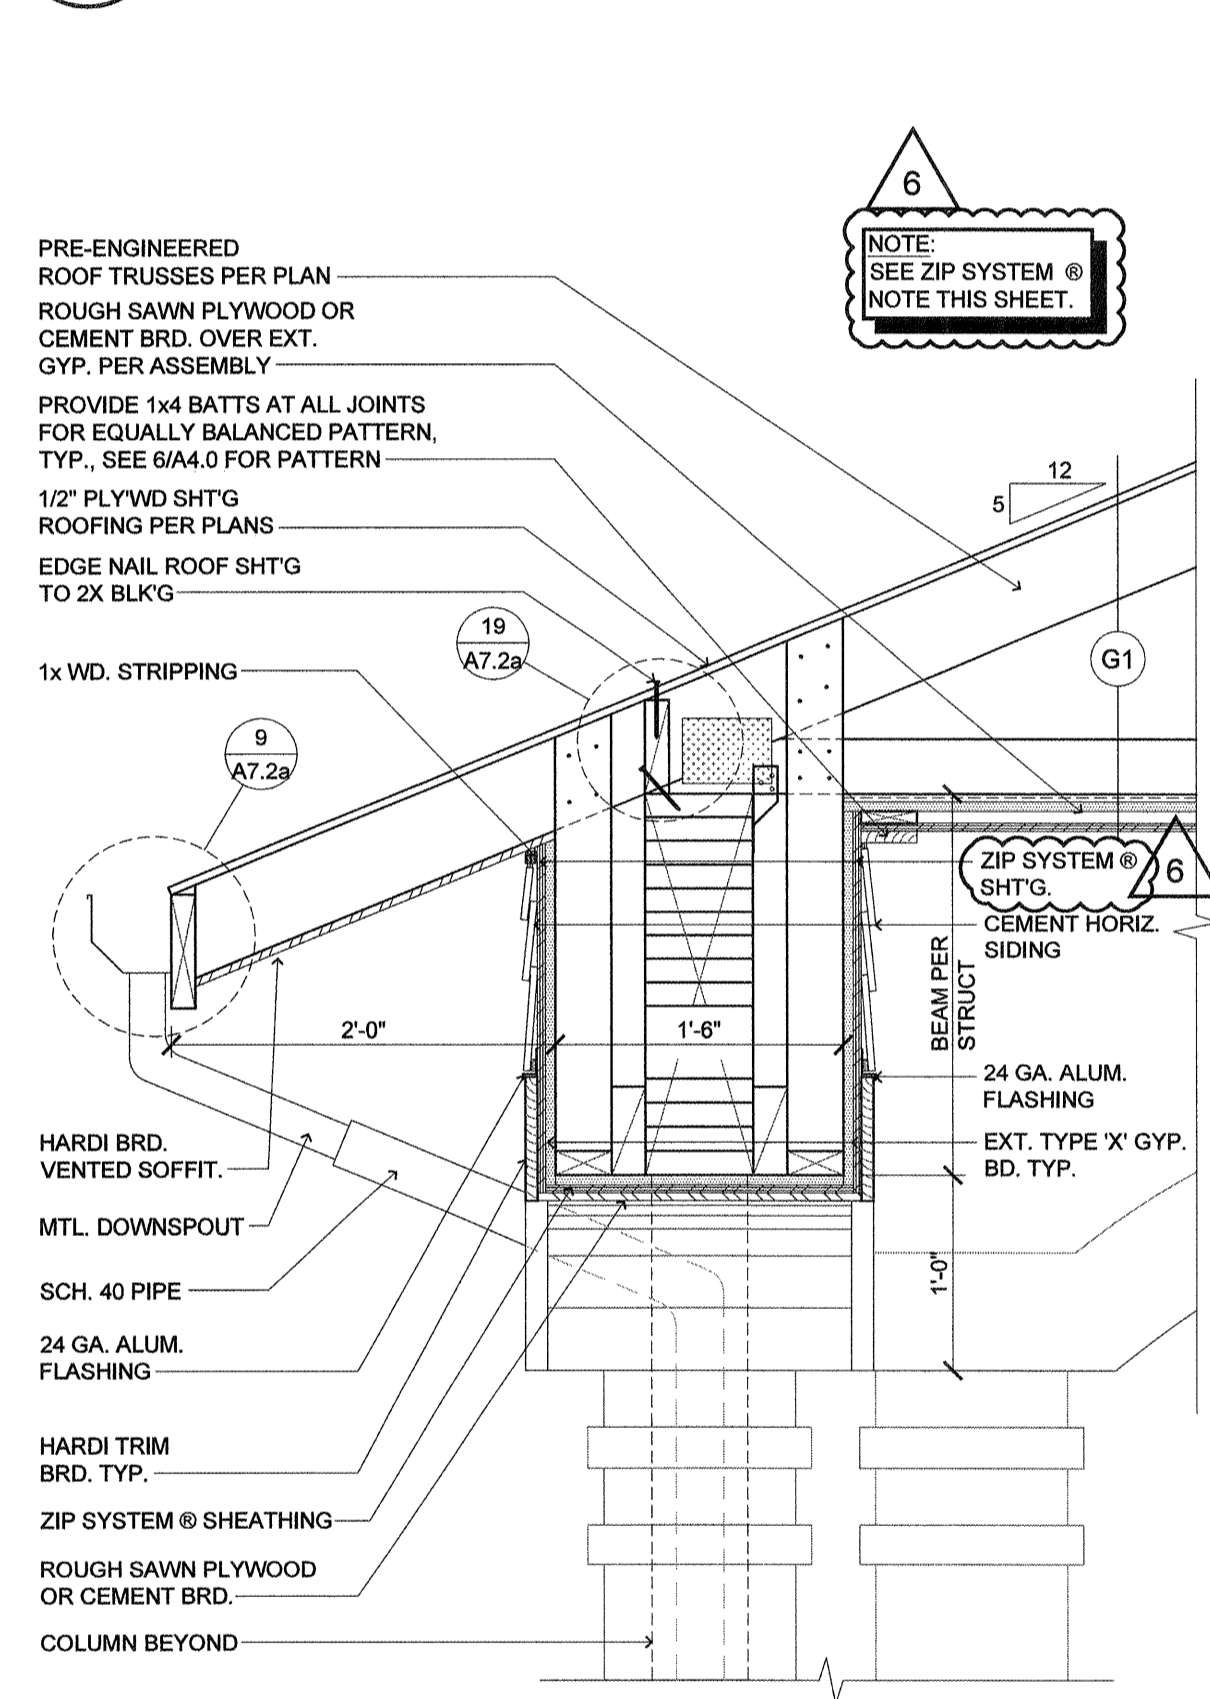

**4 TRIM WORK ON SOFFIT BOX (ENTRY CANOPY)**  
SCALE: 1" = 1'-0"

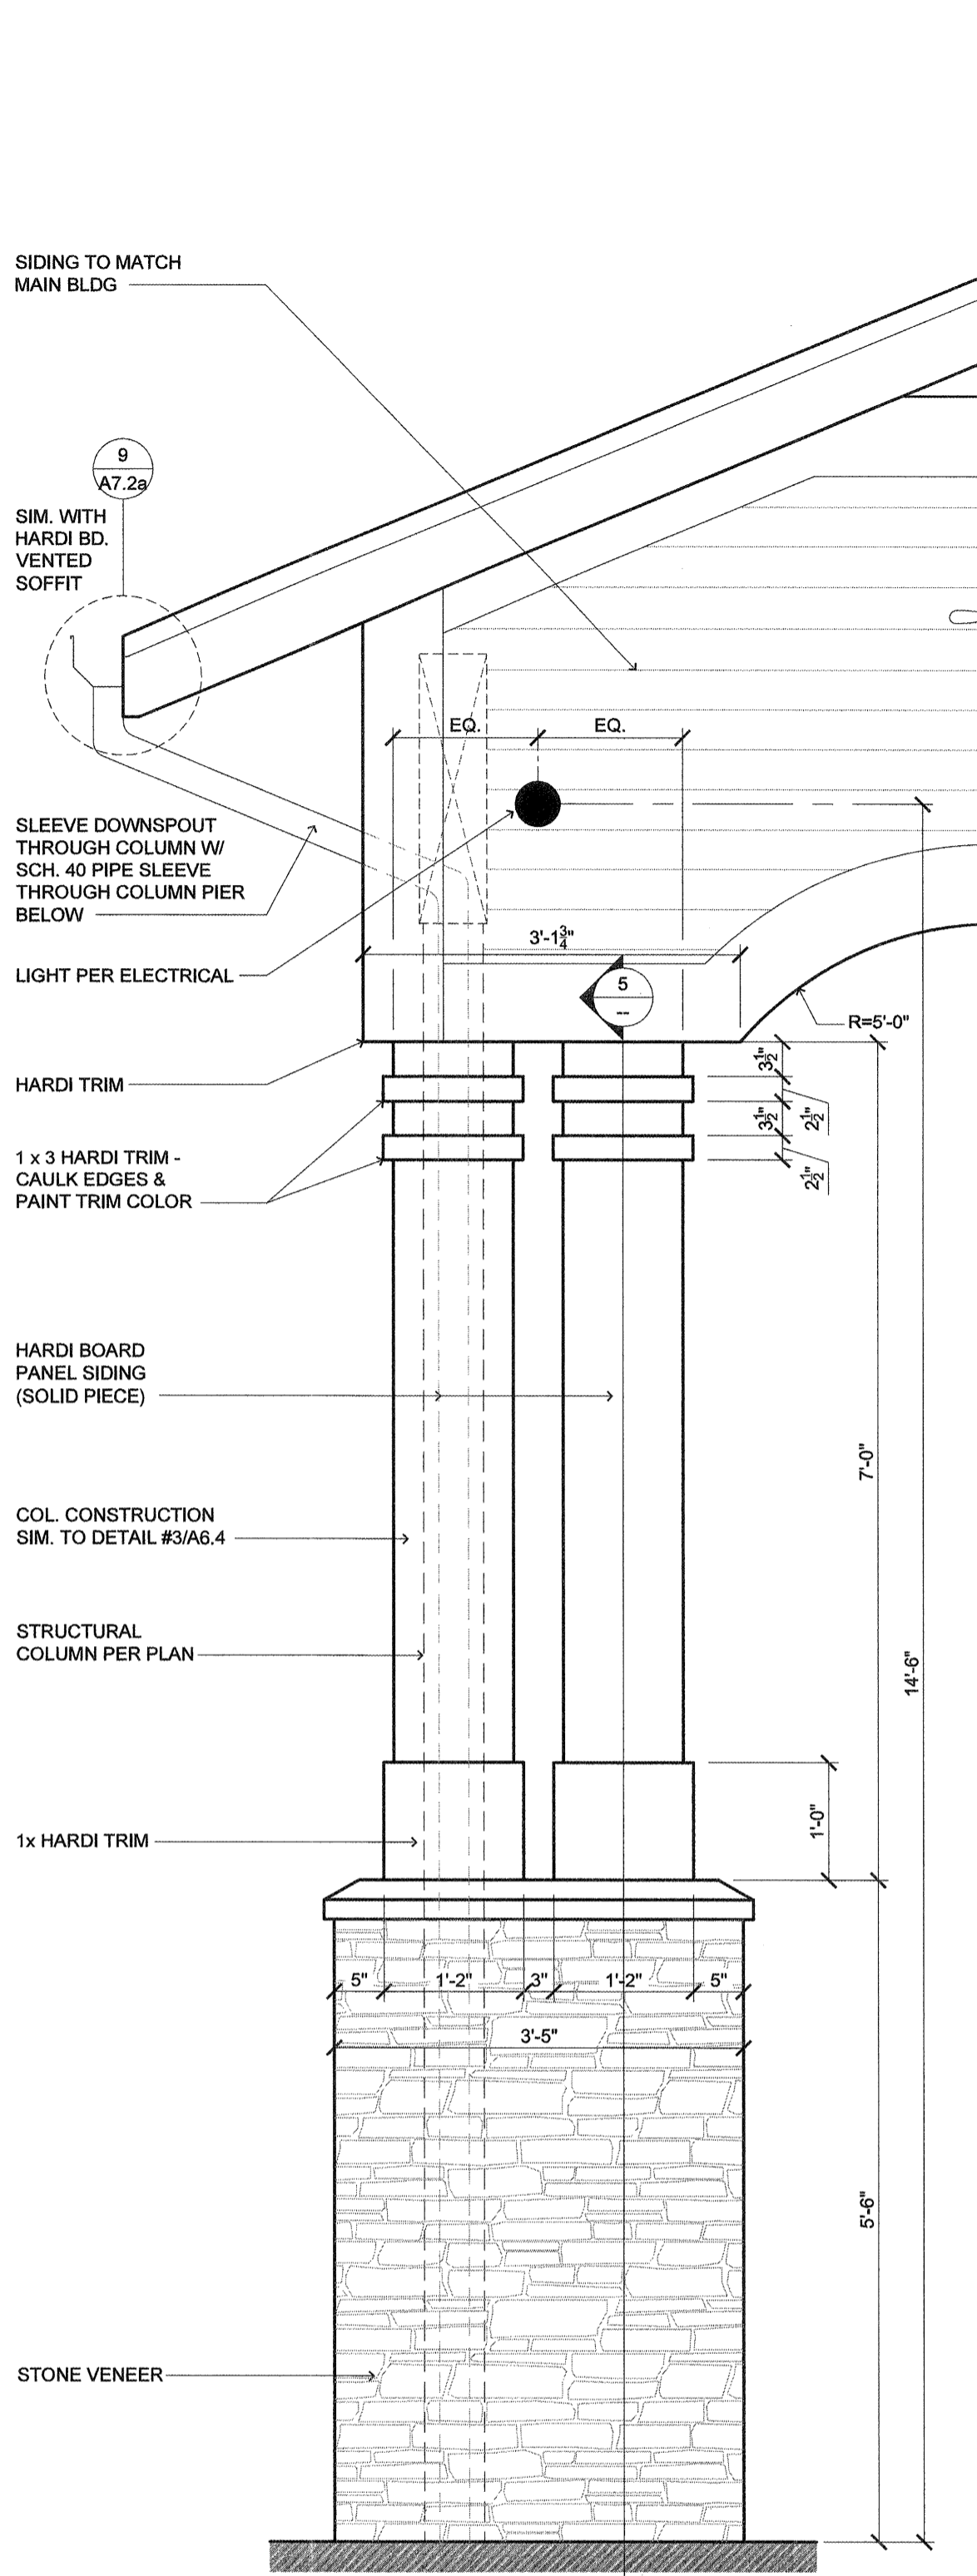

**6 ENTRY CANOPY (TYPICAL CEILING LAYOUT)**  
SCALE: 1/8" = 1'-0"

NOTE: ICE AND WATER SHIELD TO BE APPLIED TO THE ENTIRE 2:12 SECTION OF THE ENTRY CANOPY.

SEE DETAIL 1 AND 3 ON S2.3 FOR ALLOWABLE BORING / NOTCHING OF MEMBERS.

NOTE: ALL SEAMS AT ZIP SYSTEM @ MUST BE TAPED BEFORE ANY DECKS OR LOWER ROOFS ARE ADDED. ALL ZIP SYSTEM @ TAPE TO BE APPLIED WITH ROLLER. NO EXCEPTIONS.


NOTE: BUILDING PAPER TO ONLY BE USED AT STONE LOCATIONS. ALL JOINTS TO BE TAPED WITH SHEATHING TAPE. SYSTEM MUST BE INSTALLED IN ACCORDANCE WITH MANUF. INSTALLATION INSTRUCTIONS TO PROVIDE 10 YR. WARRANTY TO GENERAL CONTRACTOR

SEE SHT. A1.1 SITE FOR ADDITIONAL INFORMATION AND NOTES.


SEE SHT S0.0 FOR STRUCTURAL INFORMATION AND DIMENSIONS AND ADDITIONAL NOTES.

SEE "E" SHT FOR ELECTRICAL INFORMATION AND ADDITIONAL NOTES.

SEE ROOF PLAN FOR D.S. AND ROOF SLOPE.

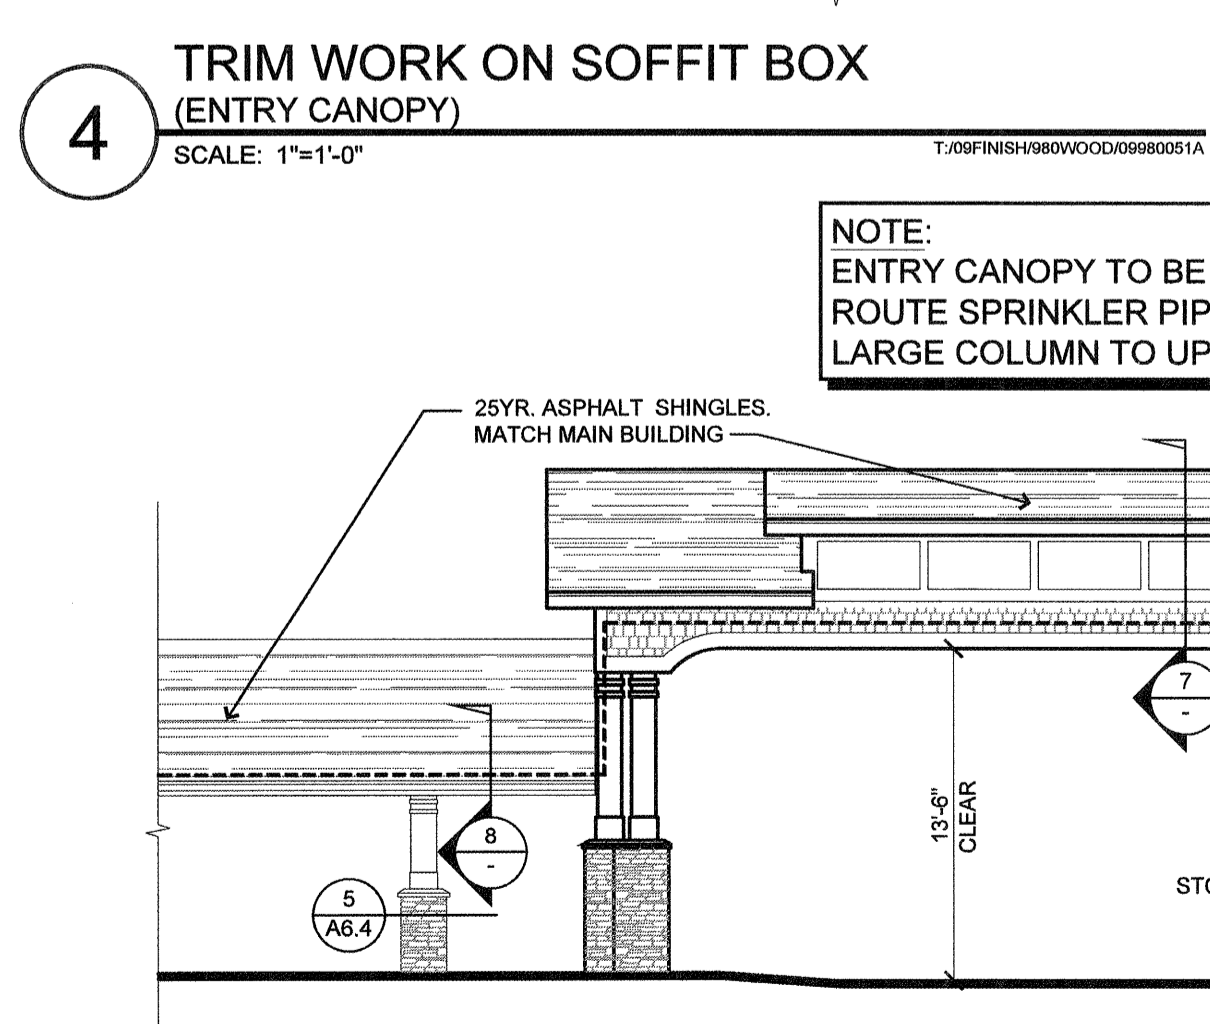

**3 ELEVATIONS (COVERED ENTRY CANOPY)**  
SCALE: 1/8" = 1'-0"


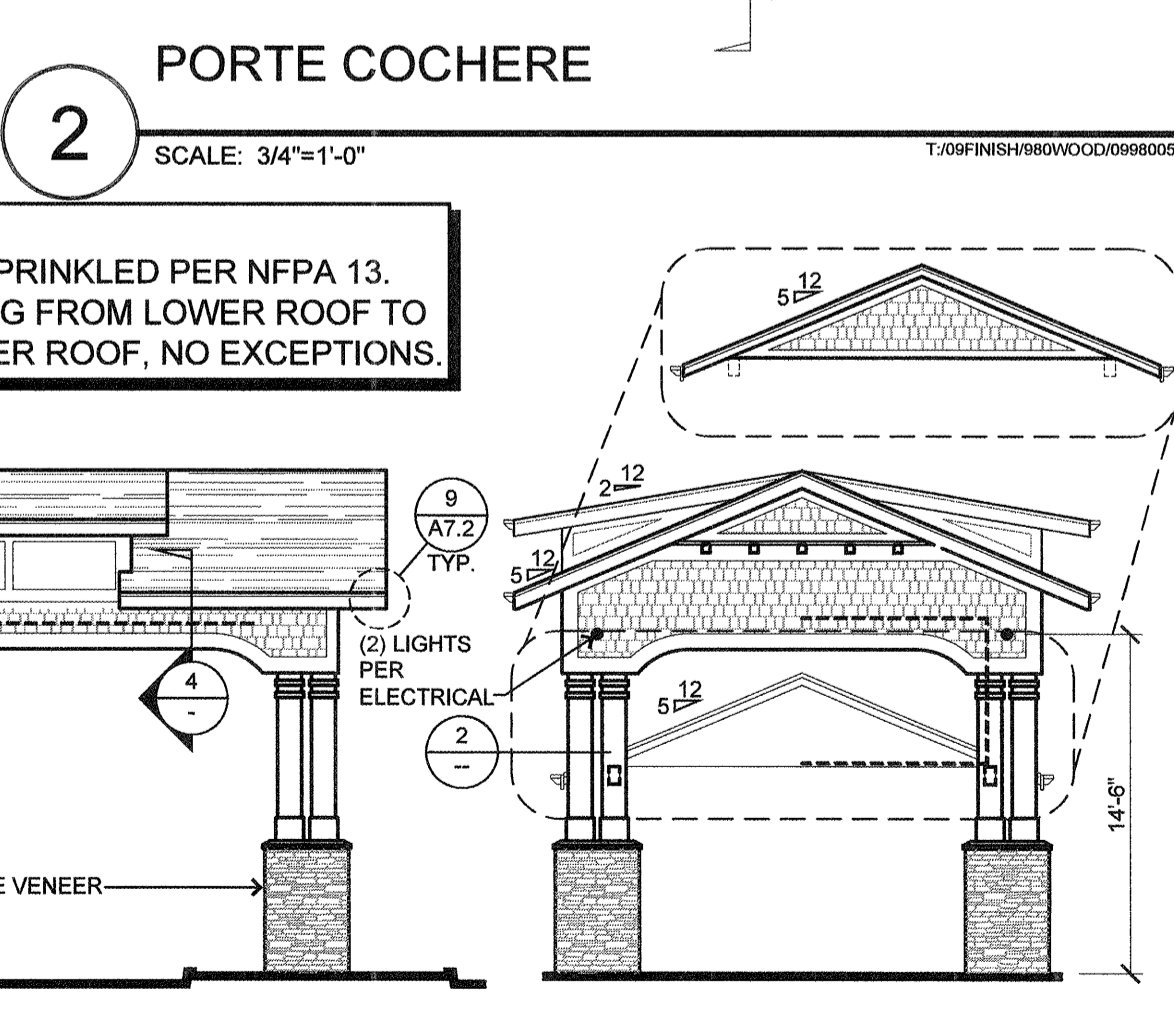


**2 PORTE COCHERE**  
SCALE: 3/4" = 1'-0"

NOTE: ENTRY CANOPY TO BE SPRINKLED PER NFPA 13. ROUTE SPRINKLER PIPING FROM LOWER ROOF TO LARGE COLUMN TO UPPER ROOF. NO EXCEPTIONS.

**1 LAYOUT (COVERED ENTRY CANOPY)**  
SCALE: 1/8" = 1'-0"

NOTE: ICE AND WATER SHIELD TO BE APPLIED TO THE ENTIRE 2:12 SECTION OF THE ENTRY CANOPY.

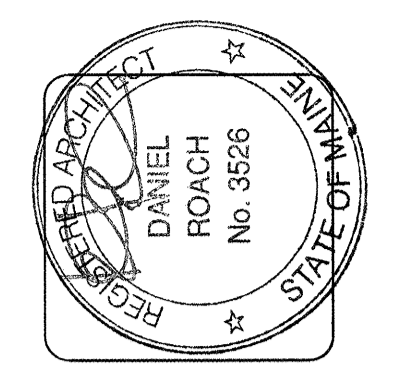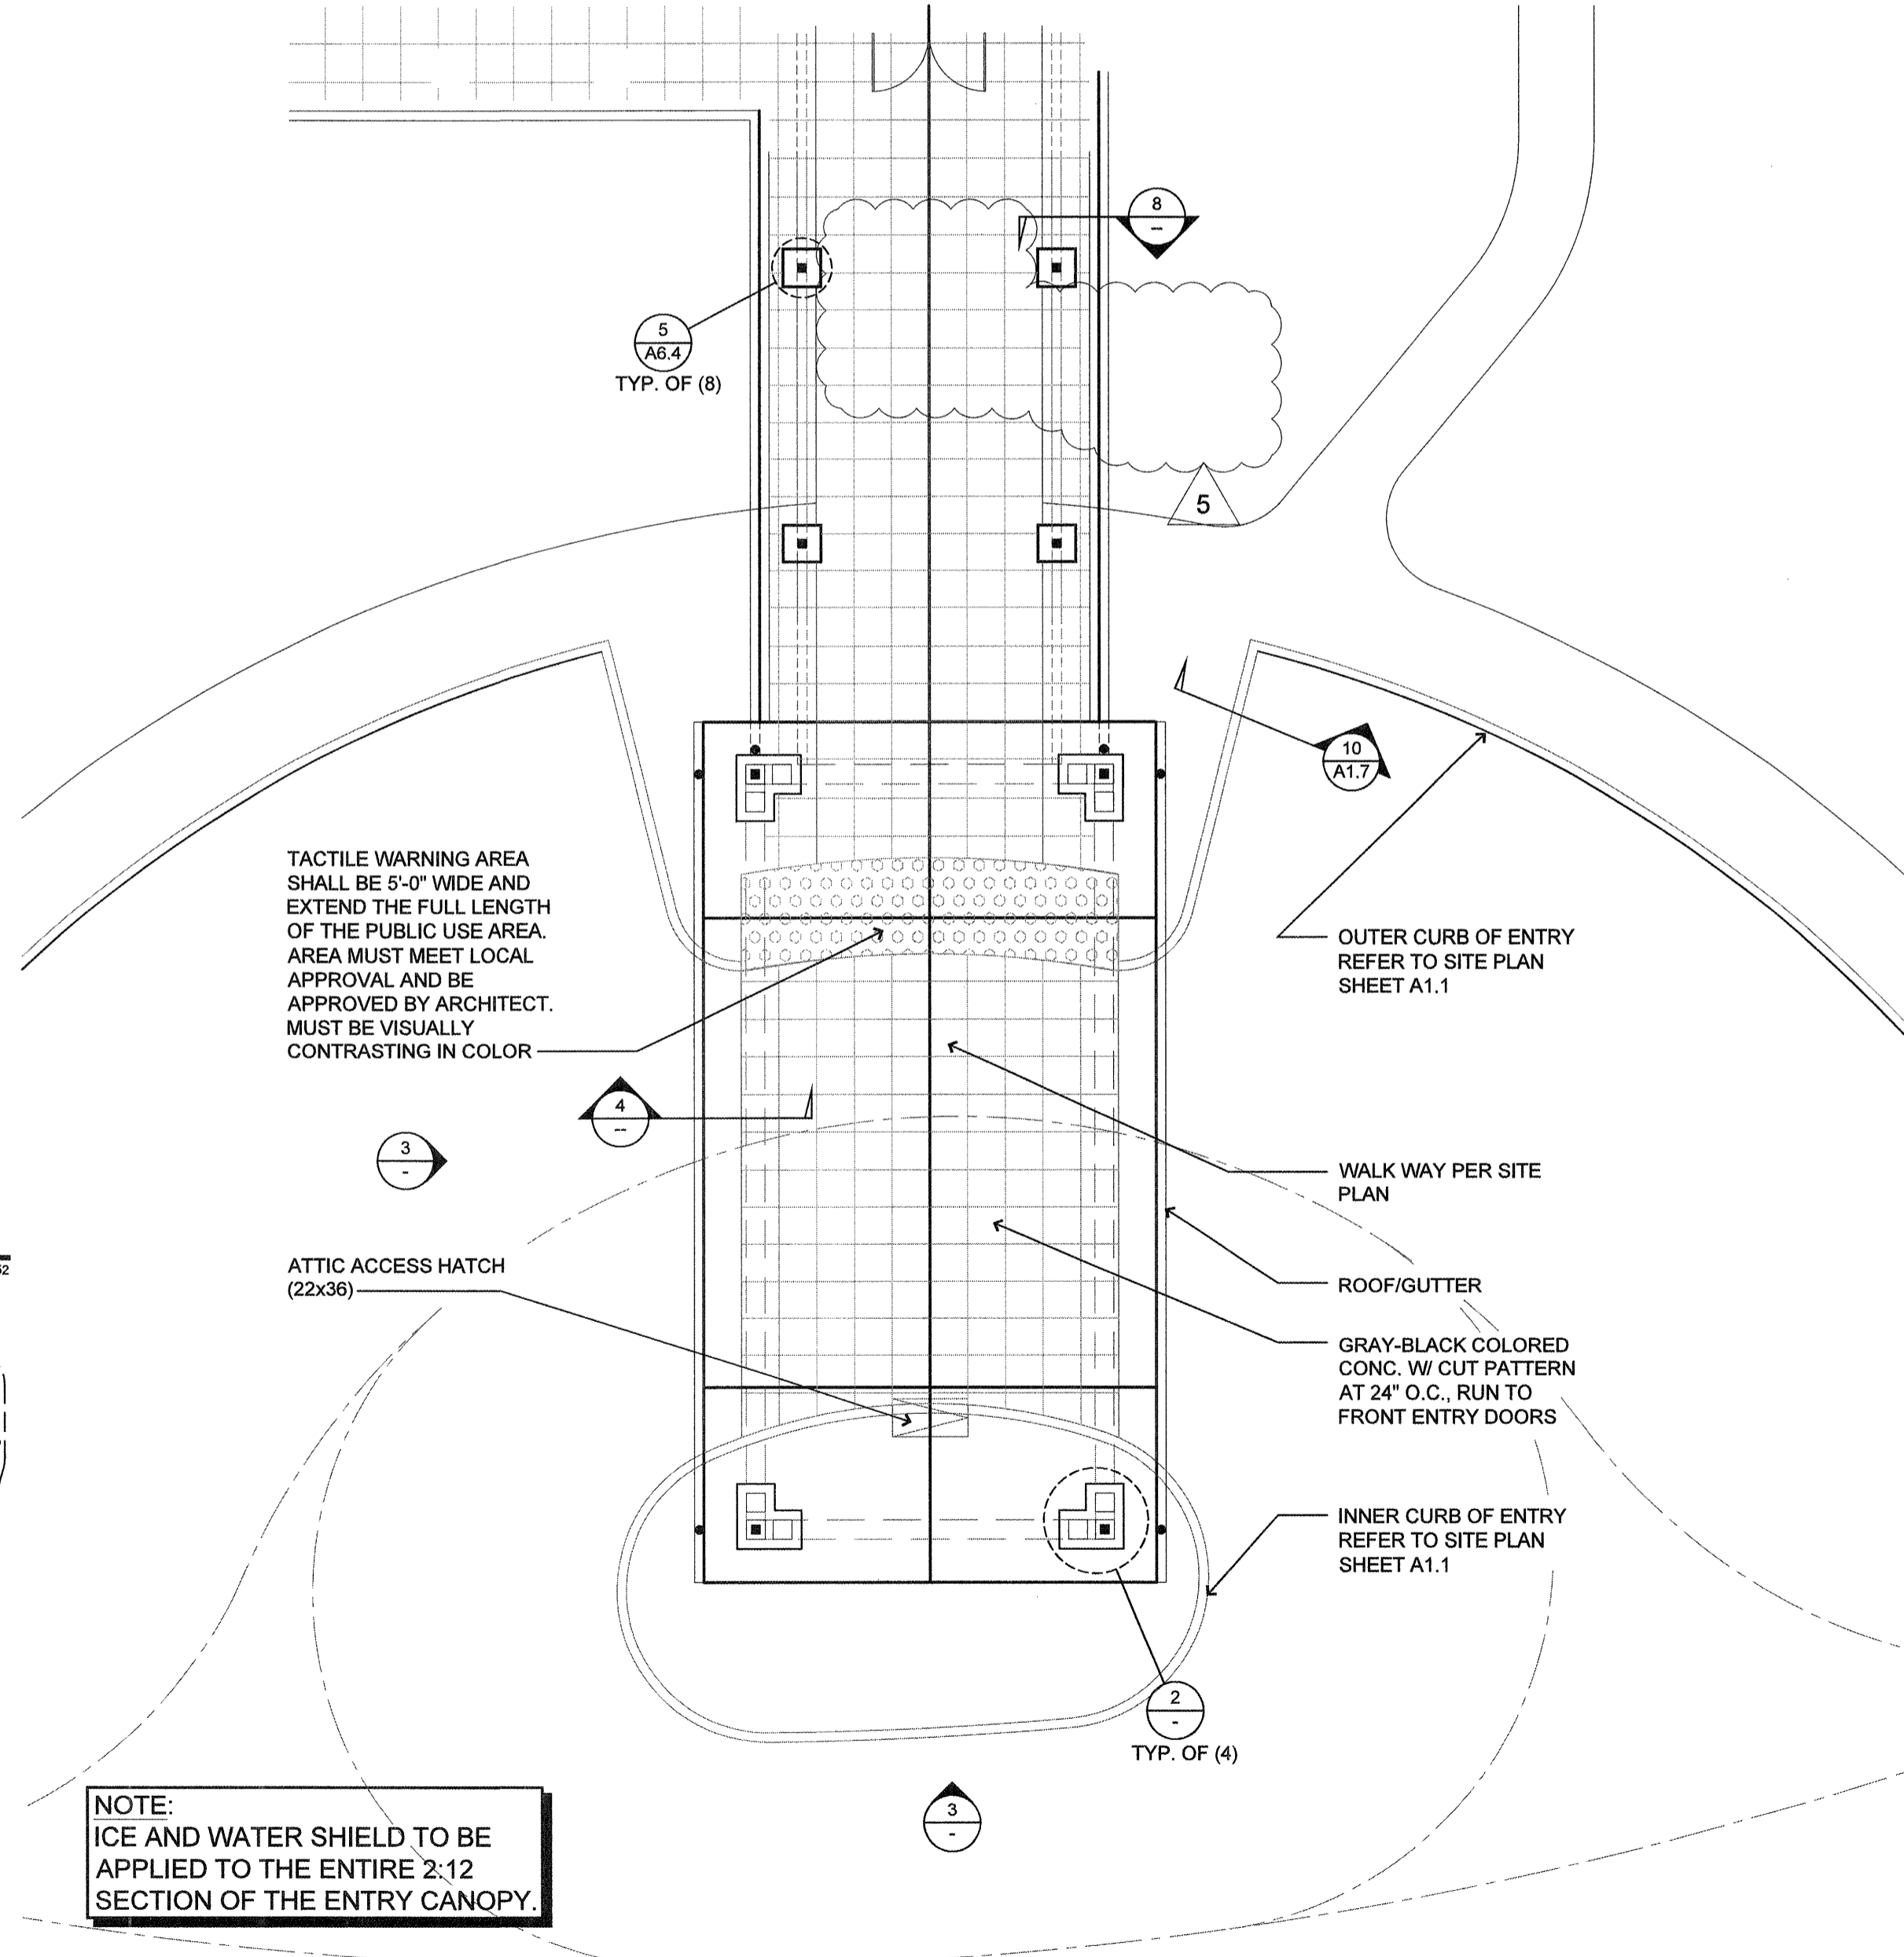

**lenity architecture**  
1850 Main Street, Suite 200  
Salem, Oregon 97302  
P: 503.399.1050 F: 503.399.0685  
www.lenityarchitecture.com

**COLSON AND COLSON**  
GENERAL CONTRACTOR, INC.  
2280 MCGILCHRIST STREET SE, SUITE 200  
SALEM, OREGON, 97302  
PHONE (503) 586-7401

**PORTLAND RETIREMENT RESIDENCE**  
802 OCEAN AVE. PORTLAND, MAINE 04103

**ENTRY CANOPY DETAILS**

DATE	8/28/2015
REVISED DATE	
SHEET	A4.0

DATE PLOTTED: 8/28/2015 10:13 AM PLOTTER: HP DesignJet T1100e