

**HVAC KEY NOTES:**

- 1 4" EXHAUST DUCT FROM BATHROOM EXHAUST FAN TO APPROVED DISCHARGE CAP WITH INTEGRAL BACK DRAFT DAMPER. MAINTAIN 3FT MIN. CLEARANCE TO BUILDING OPENINGS, AND 10' MIN. FROM MECHANICAL FRESH AIR INTAKES. SEE 3M4.0 FOR ROOF DISCHARGE DETAIL. SEE 13M4.0 FOR WALL DISCHARGE.
- 2 HOOD DRAWINGS (H-1 - H-5) FOR ADDITIONAL INFORMATION.
- 3 SEE SHEET M4.2 FOR KITCHEN HOOD SECTIONS
- 4 DISHWASHER: TYPE II HOOD AND EXHAUST SYSTEM. USE ALUMINUM DUCTWORK.
- 5 6" SHEET METAL EXHAUST DUCT IN SOFFIT TO APPROVED SOFFIT CAP WITH BACKDRAFT DAMPER.
- 6 6" EXHAUST DUCT TO APPROVED DISCHARGE CAP WITH INTEGRAL BACK DRAFT DAMPER. MAINTAIN 3FT MIN. CLEARANCE TO ALL OPENINGS. SEE 3M4.0 FOR ROOF DISCHARGE DETAIL. SEE 13M4.0 FOR WALL DISCHARGE.
- 7 7" RANGE EXHAUST DUCT TO APPROVED CAP. PROVIDE UL LISTED FIRE CAULKING AT RATED MEMBRANE PENETRATIONS.
- 8 OUTDOOR COOLER/ FREEZER UNITS. ROUTE REFRIGERATION LINES UNDER SLAB IN 6" CONDUIT WITH LONG SWEEPS.
- 9 INSTALL ATTIC FANS (EF-9) NEAR ROOF PEAK, OPPOSITE OF MAIN PARKING.
- 10 8" EXHAUST DUCT FROM EXHAUST FAN TO APPROVED DISCHARGE CAP WITH INTEGRAL BACK DRAFT DAMPER. MAINTAIN 3FT MIN. CLEARANCE TO ALL OPENINGS. SEE 3M4.0 FOR ROOF DISCHARGE DETAIL.
- 11 LOCATION OF FUTURE DOOR
- 12 MECHANICAL SHAFT COORDINATE WITH ARCHITECTURAL AND STRUCTURAL. SEE DETAILS 8/A3.8 AND 2/S2.5.
- 13 SPLIT SYSTEM EVAPORATORS, SEE MECH. SPECIFICATIONS
- 14 FILTER RETURN GRILLE FOR T-BAR INSTALLATION.
- 15 DUCT LOCATED IN ATTIC. INSULATE WITH EXTERIOR INSULATION MIN. 2"
- 16 ROUTE DRAIN OVER AND DOWN IN WALL. DAYLIGHT INTO JANITOR SINK.
- 17 EXHAUST DUCTS LOCATED IN THE ATTIC FROM BELOW 1" INSULATION.
- 18 8x8 EXHAUST DUCT TO APPROVED CAP.
- 19 ROUTE ALL DUCTWORK UNDER MECHANICAL WELL INTO ATTIC SPACE.
- 20 SEE SHEETS SMOKE CONTROL SHEETS SC1.1, 1.2, 1.3, 1.4 AND SC2.1 FOR ATRIUM SMOKE EXHAUST
- 21 COORDINATE DUCT ROUTING CLOSELY W/ STRUCTURAL. NOTIFY ARCHITECT IF CONFLICTS OCCUR. TYPICAL FOR ALL AREAS OF BUILDING.
- 22 W/ FSD AT TOP OF SHAFT
- 23 DRYER VENT, (4" MIN., MATCH DRYER DISCHARGE) EXHAUST DUCT TO APPROVED ROOF CAP WITH INTEGRAL BACK DRAFT DAMPER.
- 24 MOUNT PTAC UNIT 6" ABOVE OUTSIDE ROOF LINE. PROVIDE REMOTE THERMOSTAT OR REMOTE CONTROLLER WHERE MANUFACTURER EQUIPMENT HAS NO OPTION FOR REMOTE THERMOSTAT.
- 25 WATER HEATER VENTING UP. PROVIDE 3" PVC FOR VENT AND 3" PVC FOR COMBUSTION AIR. SEE DETAILS 1/M2.2 AND 14/M4.0.
- 26 DRYER VENT, 4" EXHAUST DUCT TO IN-VATE DRYER BOX AT WALL PENETRATION. PROVIDE UL LISTED RATED SEAL AT MEMBRANE PENETRATIONS. SEE SHEET M4.0 FOR DRYER DETAILS.
- 27 PROVIDE CONDENSATE LINE FOR FUTURE THRU-WALL PTAC UNITS IN "C" UNIT SPARE BEDROOMS.
- 28 SMOKE CONTROL DUCTS. SEE "SC" SHEETS FOR MORE INFORMATION.
- 29 TRANSFER AIR DUCT. TWO 12X12" PRICE PDDR DIFFUSER CONNECTED WITH A 8X4" DUCT. PROVIDE A FIRE SMOKE DAMPER WHERE DUCT CROSSES CORRIDOR WALL. MOTOR TO BE MOUNTED ON CORRIDOR SIDE OF WALL. SEE DETAIL 5/M4.0.
- 30 LOCATE IN VACANT SPACE ABOVE BUILT-IN FREEZER/REFRIGERATOR
- 31 INTERLOCK MOTORIZED DAMPER TO OPEN WHEN HP IS OPERATING. SEE MECHANICAL SCHEDULE (M4.2) FOR MINIMUM OUTSIDE AIR REQUIREMENT.


**DIFFUSER, REGISTER AND GRILLE SCHEDULE**

SYM	TYPE	FACE	FRAME	DAMPER	FINISH	MODEL NO.
CD-1	CEILING DIFFUSER	LOUVERED	T-SURFACE	MVD	WHITE	E.H. PRICE SMD
CD-2	CEILING DIFFUSER	LOUVERED	SURFACE	OBD	WHITE	E.H. PRICE SMD
CD-3	CEILING SUPPLY EXHAUST	LOUVERED	SURFACE	N/A	WHITE	ALDES "CAR"
CRG-1	CEILING GRILLE	PERFORATED	T-BAR	MVD	WHITE	E.H. PRICE PDR
CRG-2	CEILING GRILLE	PERFORATED	SURFACE	OBD	WHITE	E.H. PRICE PDR
CRG-3	CEILING FILTER GRILLE	PERFORATED	T-BAR	MVD	WHITE	E.H. PRICE 10FF
RG-1	SIDEWALL GRILL	FIXED BAR	1" BORDER	OBD	WHITE	E.H. PRICE S30
SR-1	SIDEWALL SUPPLY GRILL	DOUBLE DEFL.	1" BORDER	OBD	WHITE	E.H. PRICE S30
TO-1	TRANSFER GRILL	FIXED BAR	1" BORDER	OBD	WHITE	E.H. PRICE S30
CTG-1	CEILING GRILLE	FIXED BAR	SURFACE	OBD	WHITE	E.H. PRICE S30
WL-1	WALL LOUVER	FIXED BAR	6" DEEP	OBD	MILL.	RUSKIN ELF6375DX
WL-2	WALL LOUVER	FIXED BAR	DRAINABLE	2" DEEP	MILL.	GREENHECK EKH-201 SIZE: 22X10


OBD = OPPOSED BLADE DAMPER  
MVD = MANUAL VOLUME DAMPER

SEE DETAILS 8/M2.1, 9/M2.1, AND 9/M4.0 FOR ALLOWABLE BORING / NOTCHING OF MEMBERS.

PTAC CALLOUTS HAVE BEEN UPDATED

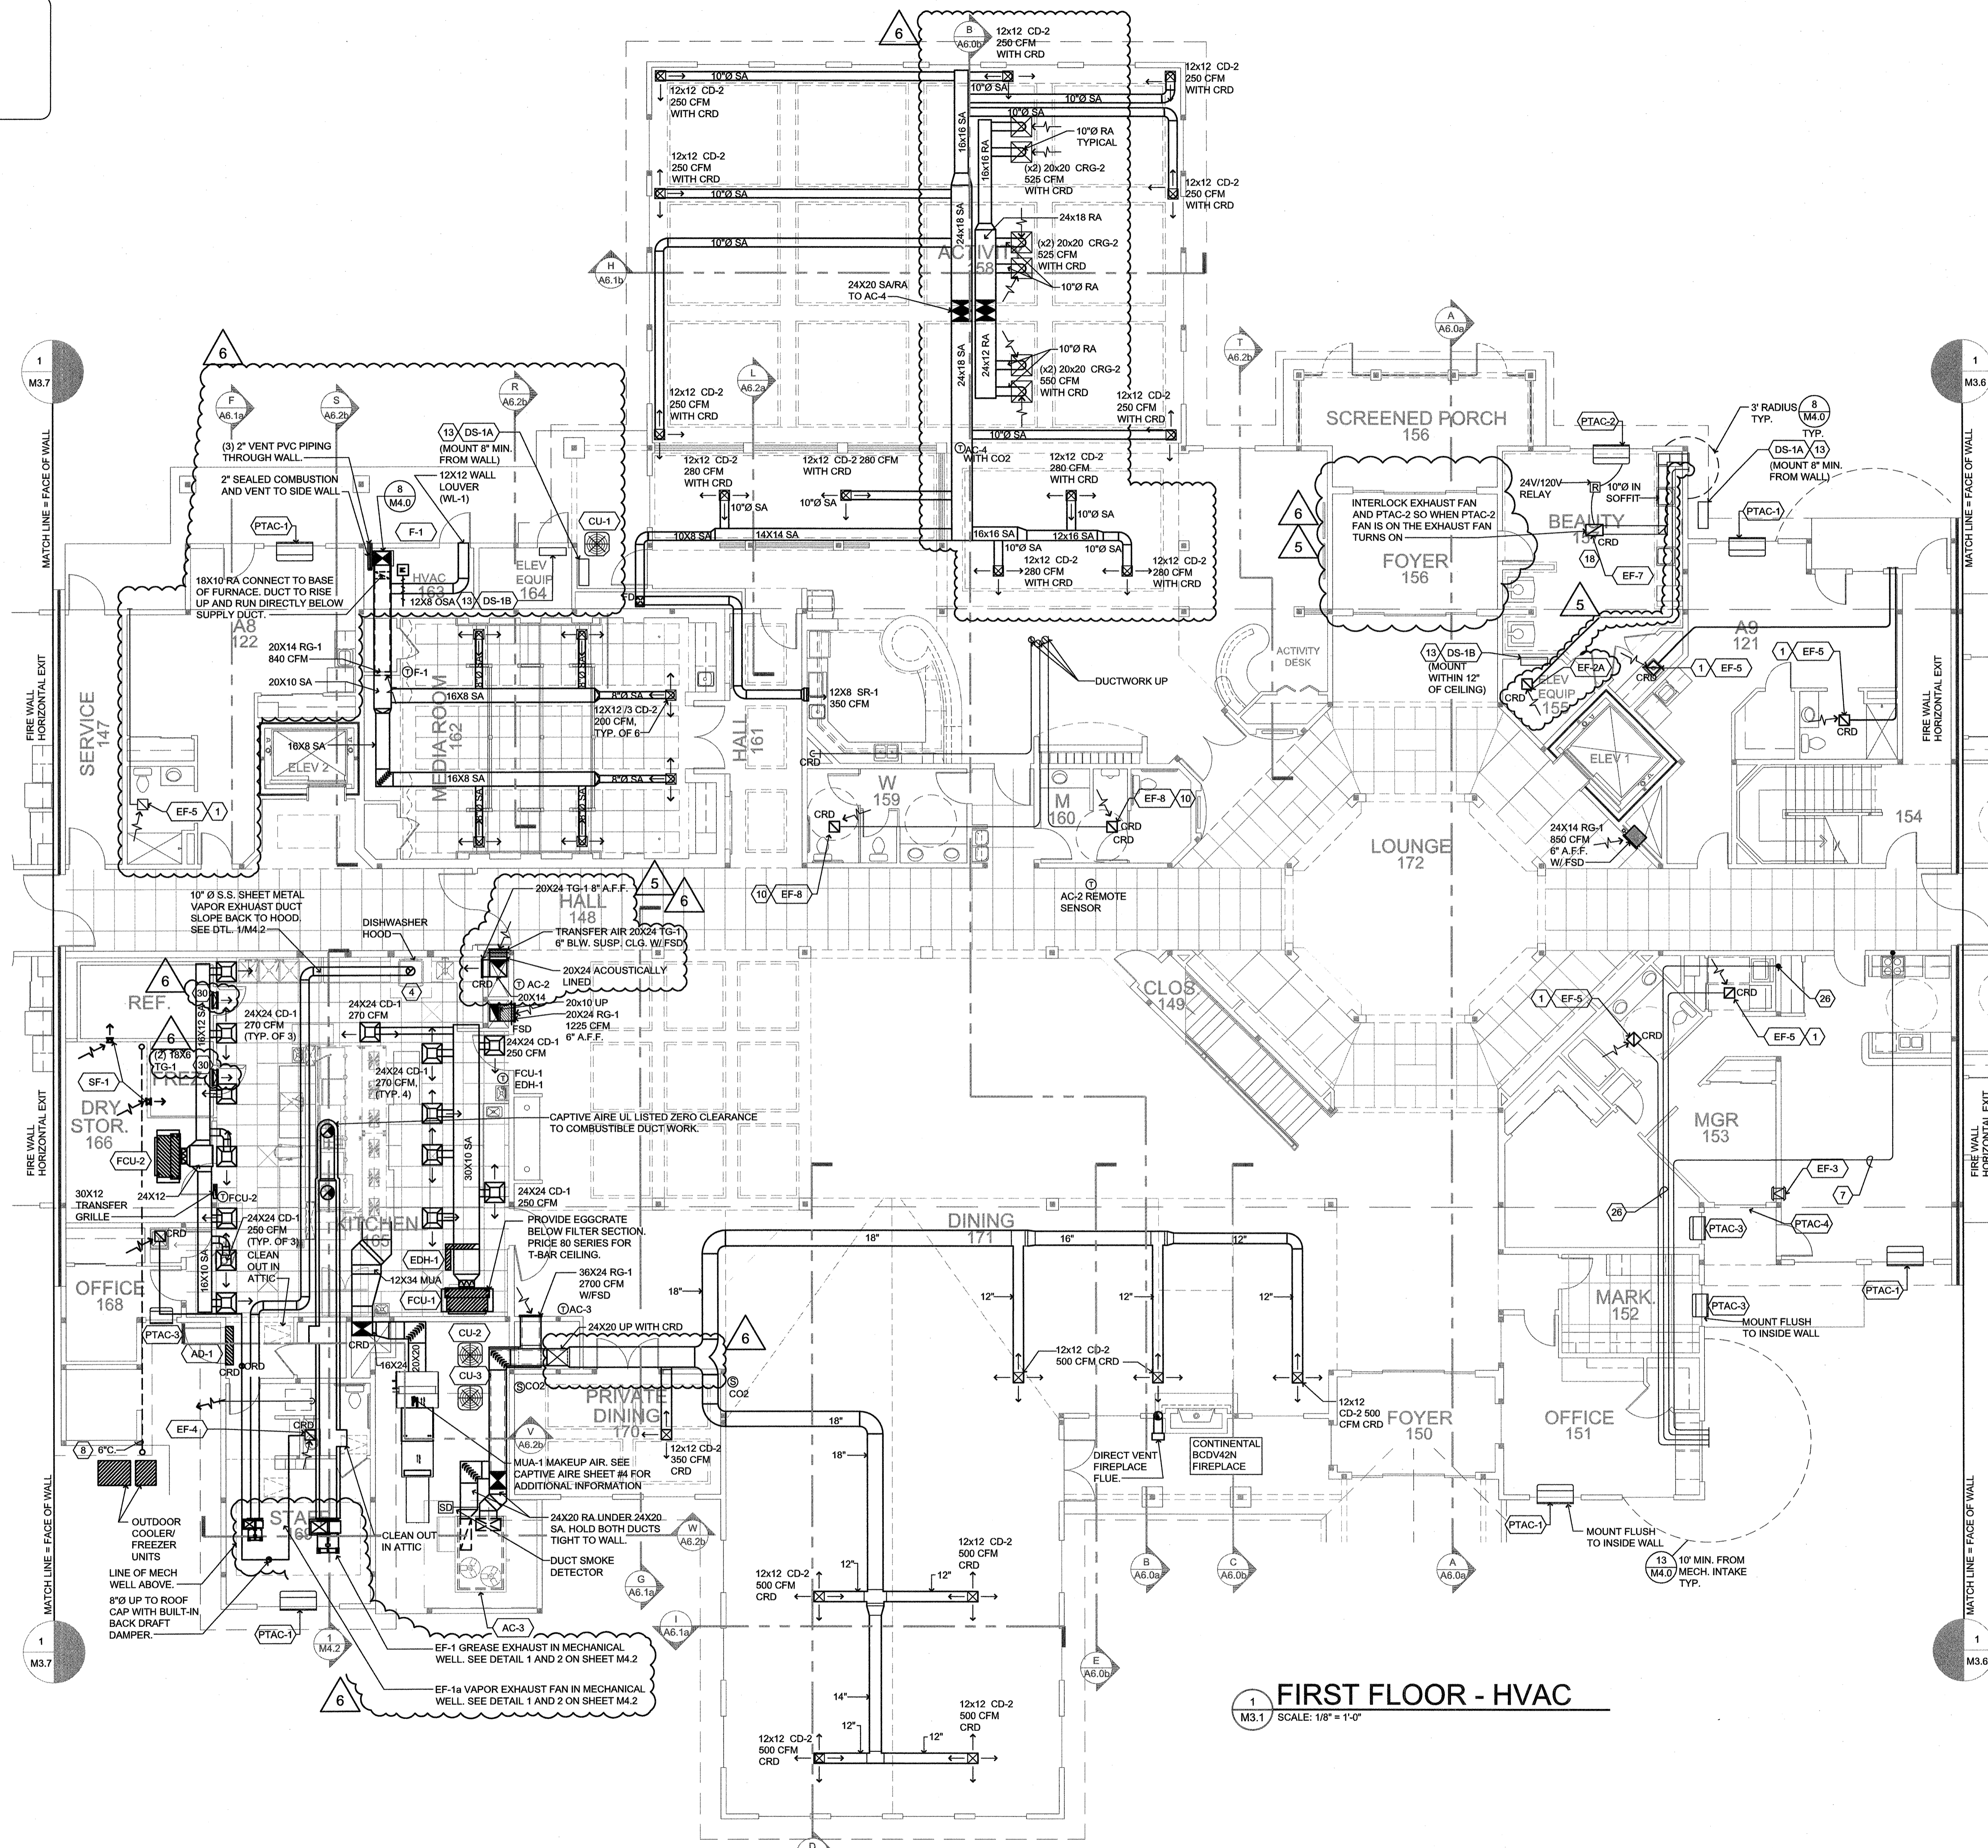

**FIRST FLOOR - HVAC**  
SCALE: 1/8" = 1'-0"

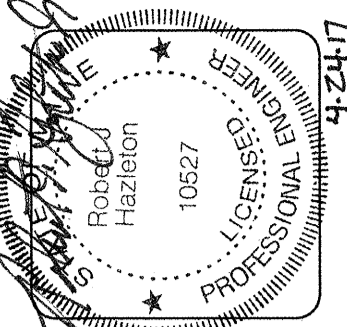

**lenity architecture**  
350 Kettle Court SE, Salem, Oregon 97301  
P: 503.399.0950 W: lenityarchitecture.com

**COLSON AND COLSON GENERAL CONTRACTOR, INC.**  
2280 McCall Street, Suite 200  
Salem, Oregon, 97302  
PHONE (503) 586-7401

**PORTLAND RETIREMENT RESIDENCE**  
802 OCEAN AVE., PORTLAND, MAINE 04103

**FIRST FLOOR CORE HVAC PLAN**

DATE: 8/28/2015  
REVISED DATE:  
SHEET M3.1

