


DIFFUSER, REGISTER AND GRILLE SCHEDULE						
SYM	TYPE	FACE	FRAME	DAMPER	FINISH	MODEL NO.
CD-1	CEILING DIFFUSER	LOUVERED	T-BAR	MVD	WHITE	E.H. PRICE SMD
CD-2	CEILING DIFFUSER	LOUVERED	SURFACE	OBD	WHITE	E.H. PRICE SMD
CD-3	CEILING SUPPLY/EXHAUST	LOUVERED	SURFACE	N/A	WHITE	ALDES 'CAR'
CRG-1	CEILING GRILLE	PERFORATED	T-BAR	MVD	WHITE	E.H. PRICE PDR
CRG-2	CEILING GRILLE	PERFORATED	SURFACE	OBD	WHITE	E.H. PRICE PDR
CRG-3	CEILING FILTER GRILLE	PERFORATED	T-BAR	MVD	WHITE	E.H. PRICE 10FF
RS-1	SIDEWALL GRILL	FIXED BAR	1" BORDER	OBD	WHITE	E.H. PRICE S33
SR-1	SIDEWALL SUPPLY GRILL	DOUBLE DEF.	1" BORDER	OBD	WHITE	E.H. PRICE R20
TG-1	TRANSFER GRILL	FIXED BAR	1" BORDER	OBD	WHITE	E.H. PRICE S30
CTG-1	CEILING GRILLE	FIXED BAR	SURFACE	OBD	WHITE	E.H. PRICE S30
WL-1	WALL LOUVER	FIXED BAR	6" DEEP	OBD	MILL	RUSKIN ELF6375DX
WL-2	WALL LOUVER	FIXED BAR	DRAINABLE	2" DEEP	MILL	GREENHECK EHM-201 SIZE: 22X10

SEE DETAILS 8/M2.1, 9/M2.1, AND 9/M4.0 FOR ALLOWABLE BORING / NOTCHING OF MEMBERS.

PTAC CALLOUTS HAVE BEEN UPDATED

SEE M3.7 FOR KEYED NOTES AND VENTILATION SCHEDULE

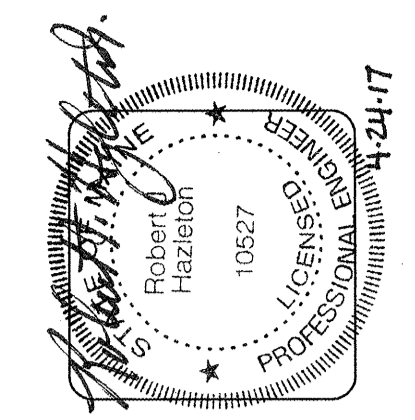


**lenity**  
architecture  
350 Kettie Court SE, Salem, Oregon 97302  
P: 503 399 1090 W: lenityarchitecture.com

**COLSON AND COLSON**  
GENERAL CONTRACTOR, INC.  
2260 MAGUIR CHRIST STREET SE, SUITE 200  
SALEM, OREGON, 97302  
PHONE (503) 586-7401


**PORTLAND RETIREMENT RESIDENCE**  
802 OCEAN AVE. PORTLAND, MAINE 04103

**WING 'B' HVAC PLAN**


DATE: 8/28/2015  
REVISED DATE:  
SHEET: M3.6

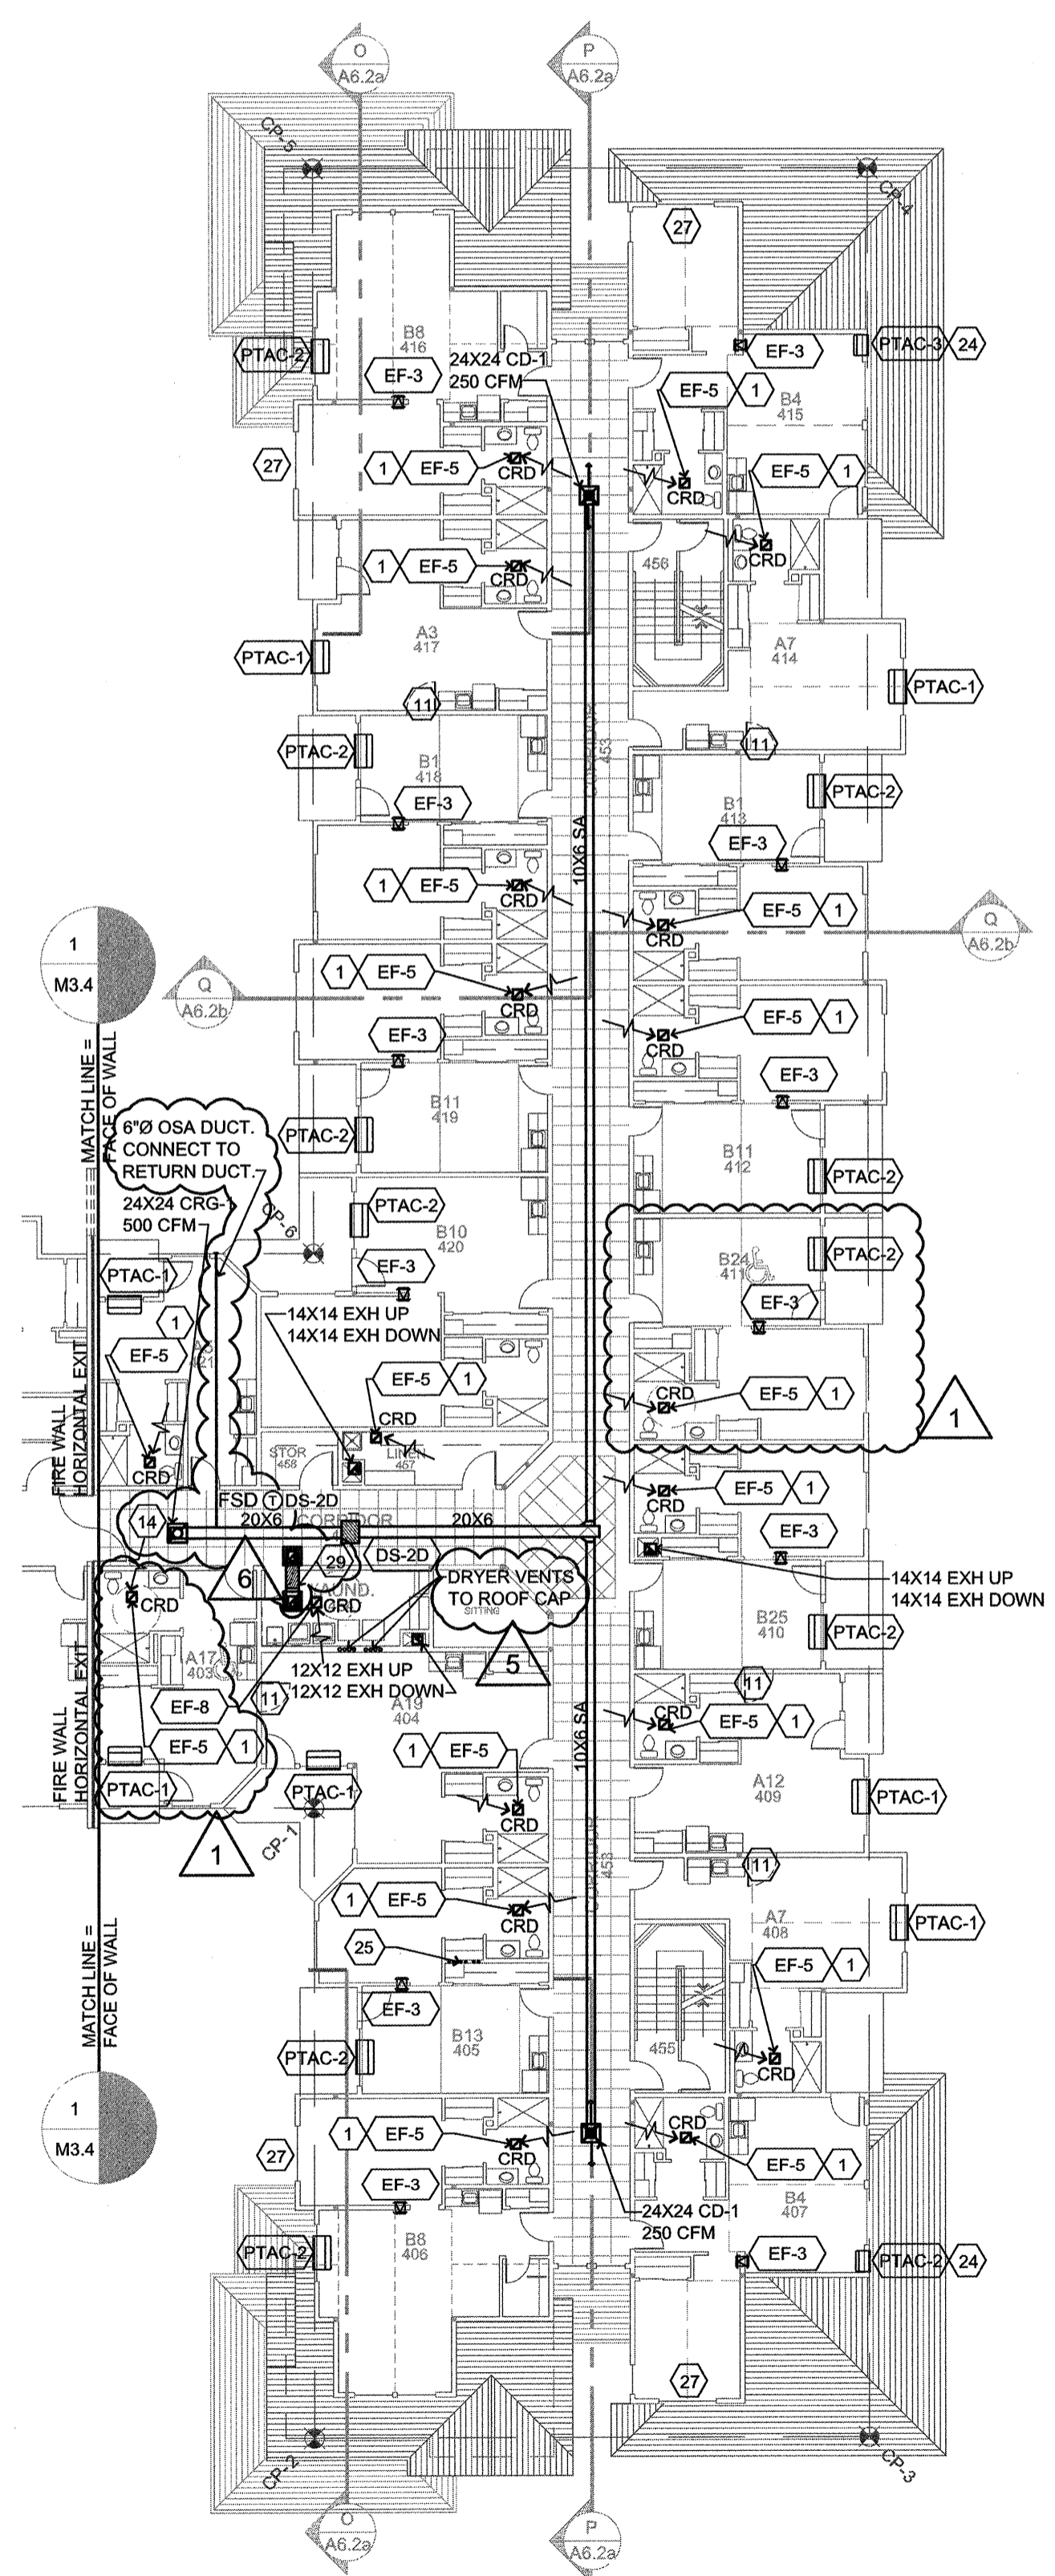


4 FOURTH FLOOR - HVAC  
SCALE: 1/16" = 1'-0"

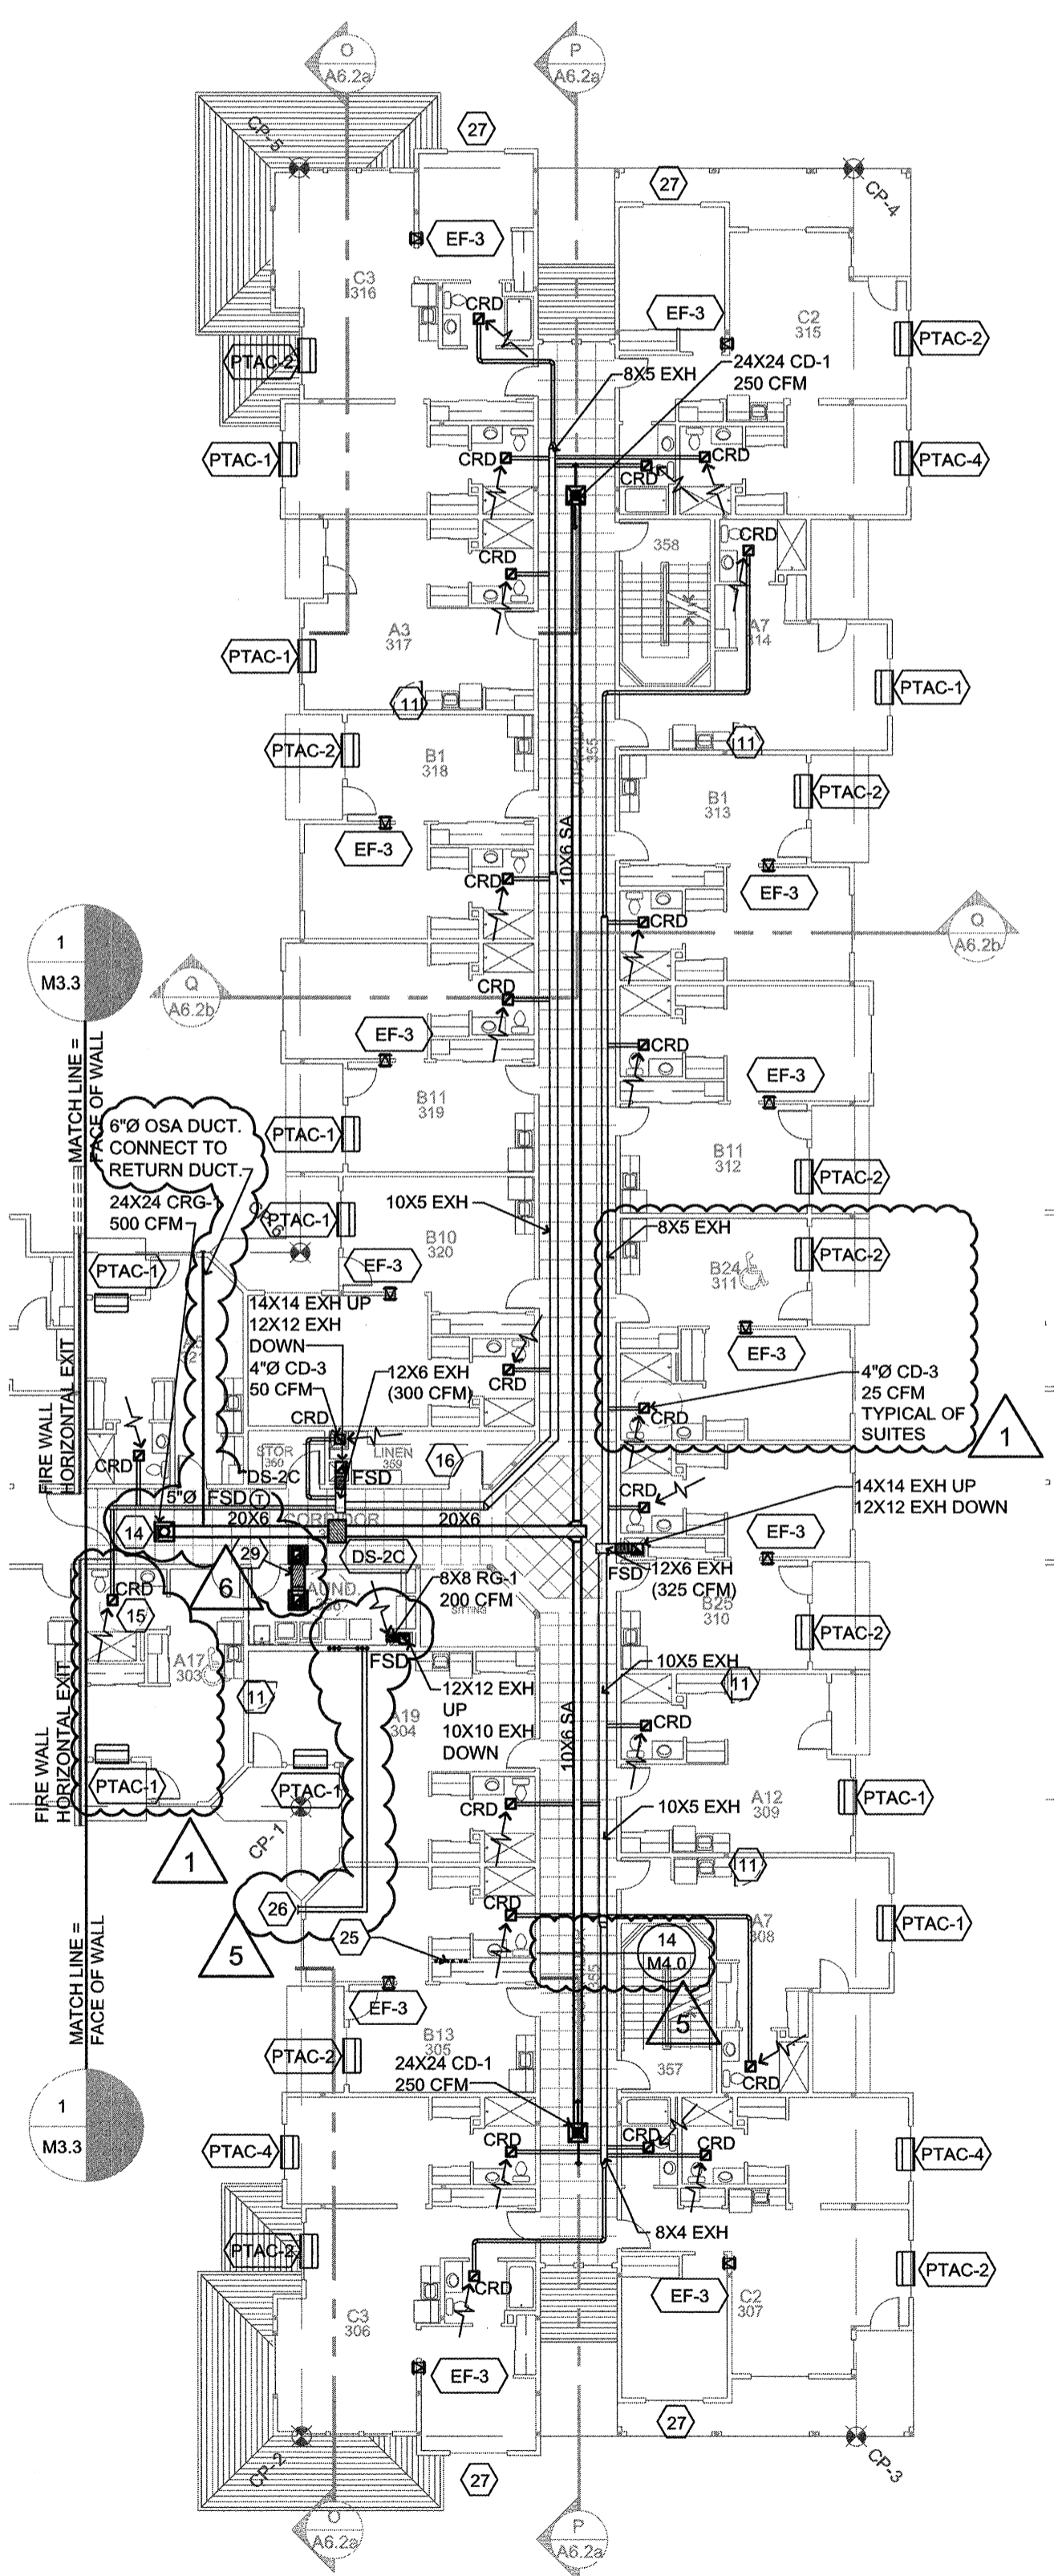

3 THIRD FLOOR - HVAC  
SCALE: 1/16" = 1'-0"

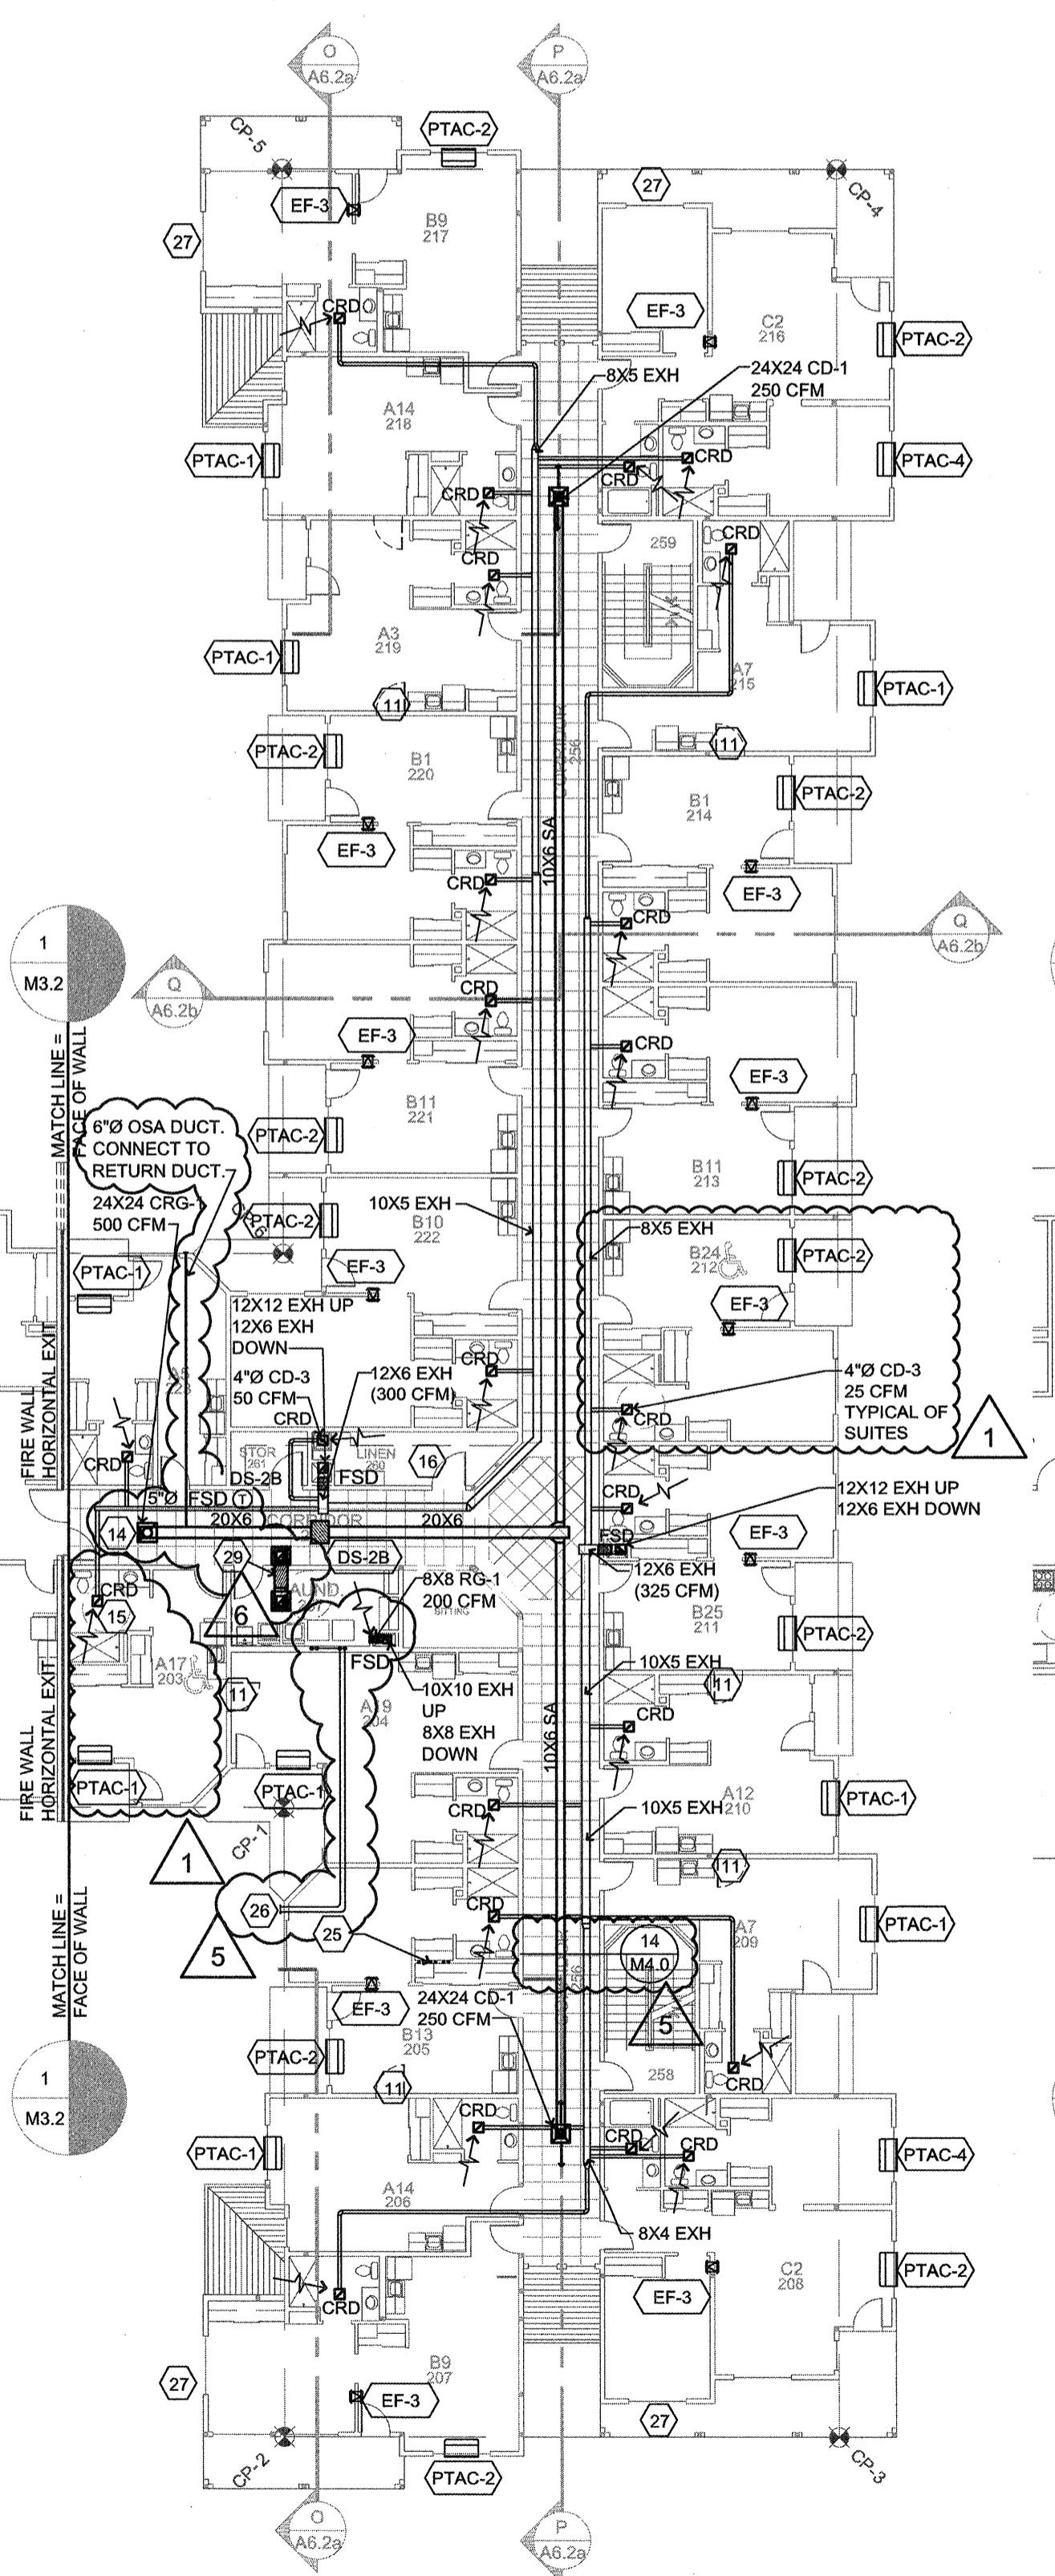


2 SECOND FLOOR - HVAC  
SCALE: 1/16" = 1'-0"

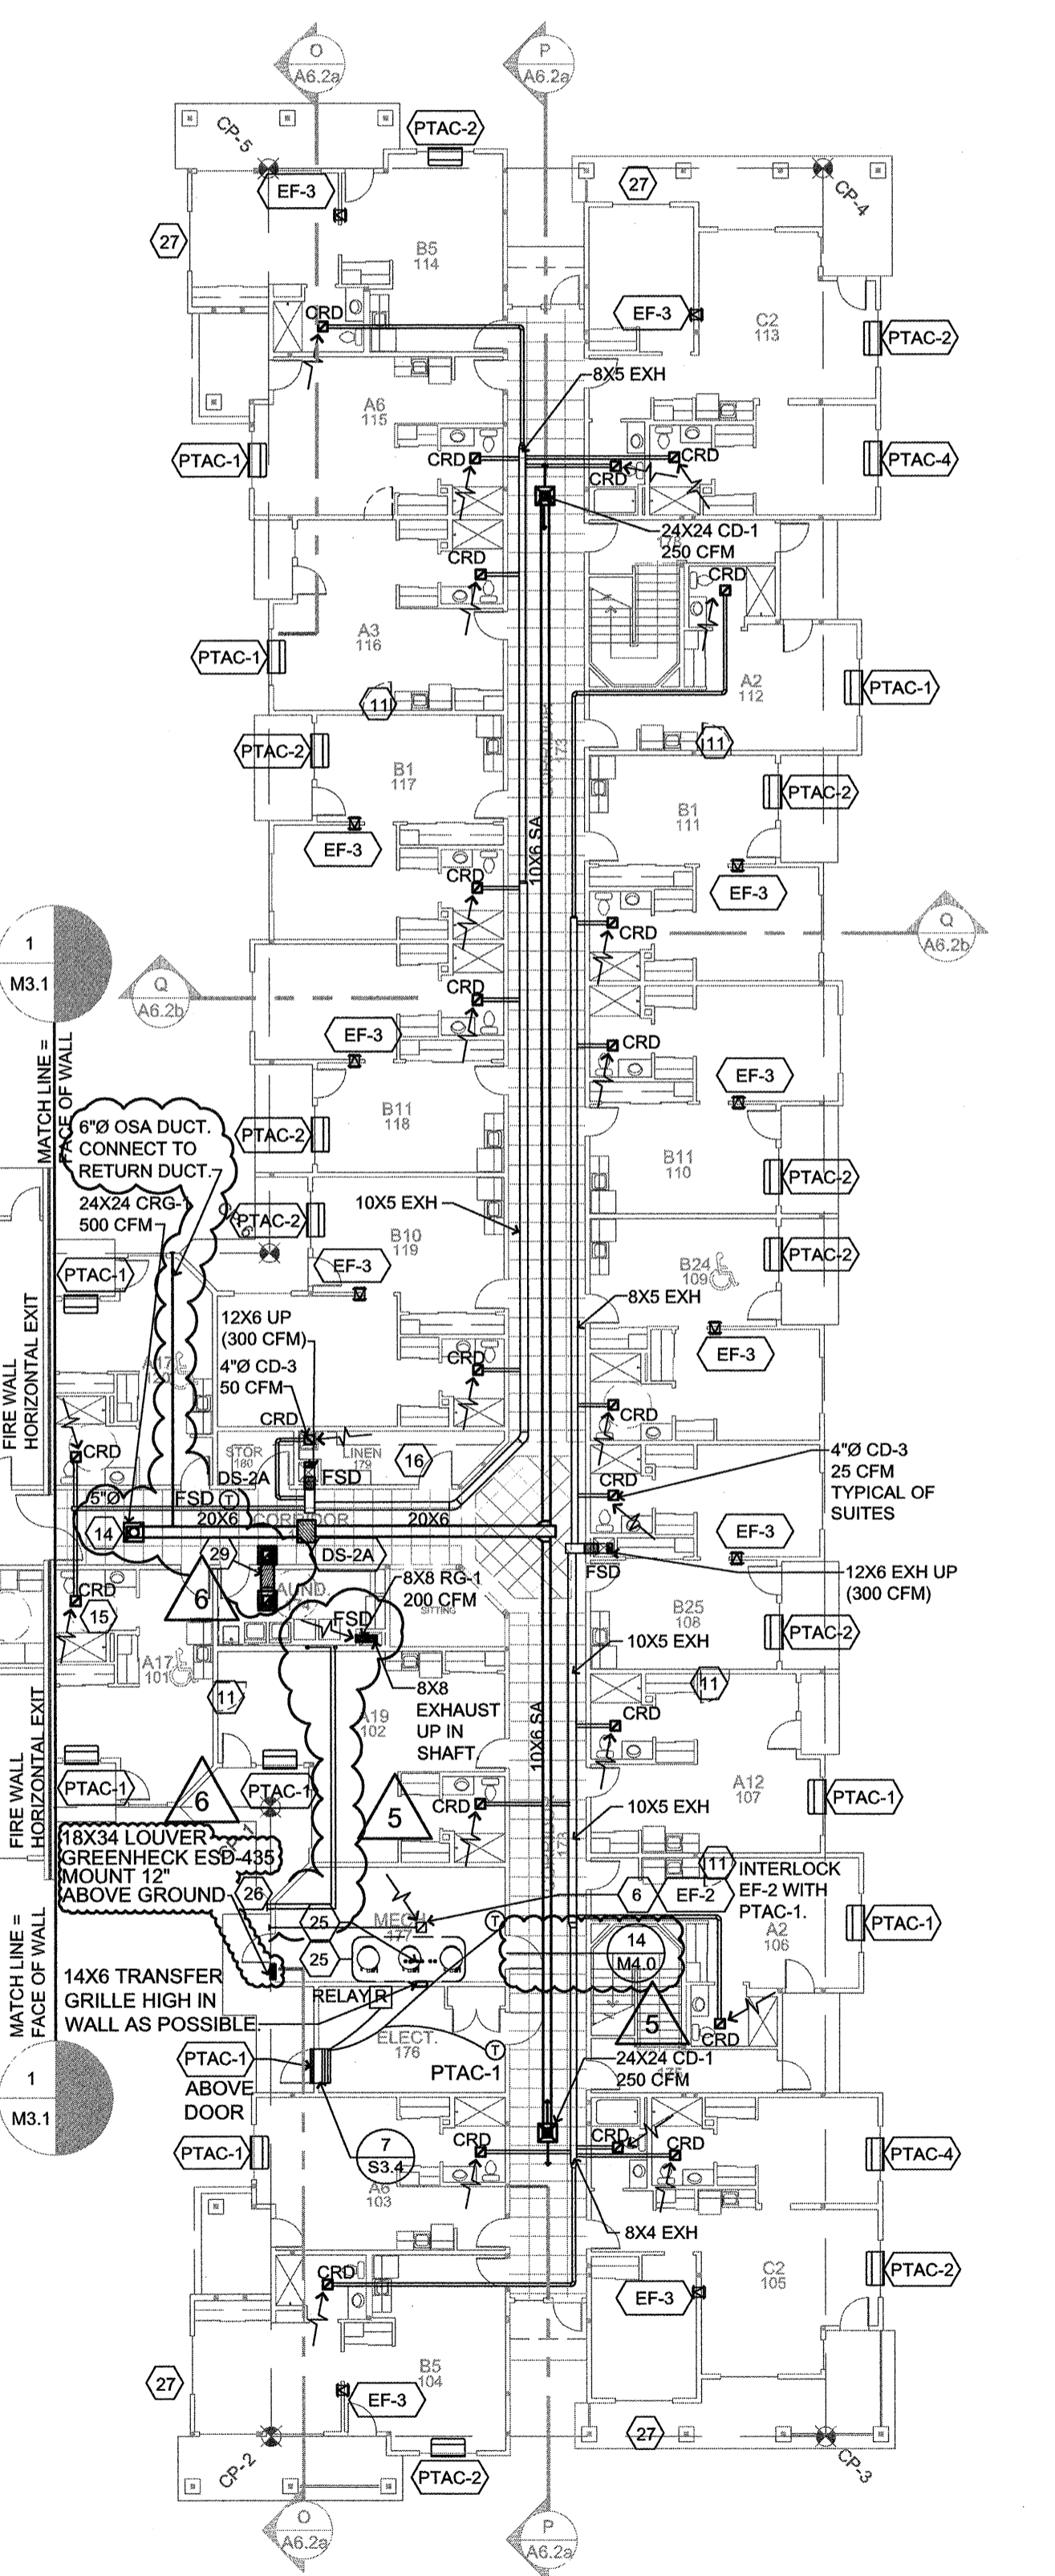

1 FIRST FLOOR - HVAC  
SCALE: 1/16" = 1'-0"

**WING 'B' HVAC PLAN**  
SCALE: 1/8" = 1'-0"

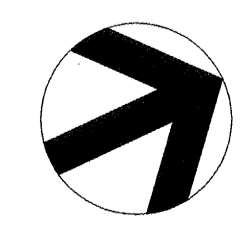

DATE: 8/28/2015  
REVISED DATE:  
SHEET: M3.6