

SYMBOL	SIZE	K/FAC	MAKE	PART#	RESPONSE	QTY
①	1/2"	4.9	TYCO	T12324	FAST RESP	244
②	1/2"	5.6	TYCO	T12331	QUICK RESPONSE	18
③	1/2"	5.6	RELIABLE	RA154	QUICK RESPONSE	20
④	1/2"	5.6	TYCO	T12337	QUICK RESPONSE	8
⑤	1/2"	5.6	TYCO	T12331	QUICK RESPONSE	7
⑥	1/2"	5.6	TYCO	T12335	QUICK RESPONSE	54
⑦	1/2"	5.6	OS-1	CHROME		
TOTAL HEADS REQUIRED ON THIS SHEET:						351

SPRINKLER SYMBOL DESCRIPTION

DATE	REV	DESCRIPTION
DEC 12 2016	0	ISSUED FOR APPROVAL

DATE	REV	DESCRIPTION

REVISION HISTORY

ENGINEER'S STAMP

Signature
02/13/17

NICET CERTIFIED
CLASSIFICATION: 125335

EDGE
7 MONROE DRIVE
FISHKILL, ALABAMA
PHONE: (205)692-2433
FAX: (205)692-3044


FIRE PROTECTION
FRONTLINE DEFENSE

PROJECT NAME:
PORTLAND RETIREMENT RESIDENCE
802 OCEAN AVE.
PORTLAND MAINE 04103


SHEET TITLE:
FIRE SPRINKLER PLAN
1ST & 2ND FLOOR EAST

DRAWN BY:
U.S.
DATE:
DEC 14 2016
SCALE:
AS SHOWN

JOB NUMBER:
MEC-16-001
SHEET NUMBER:
FP 3 OF 9

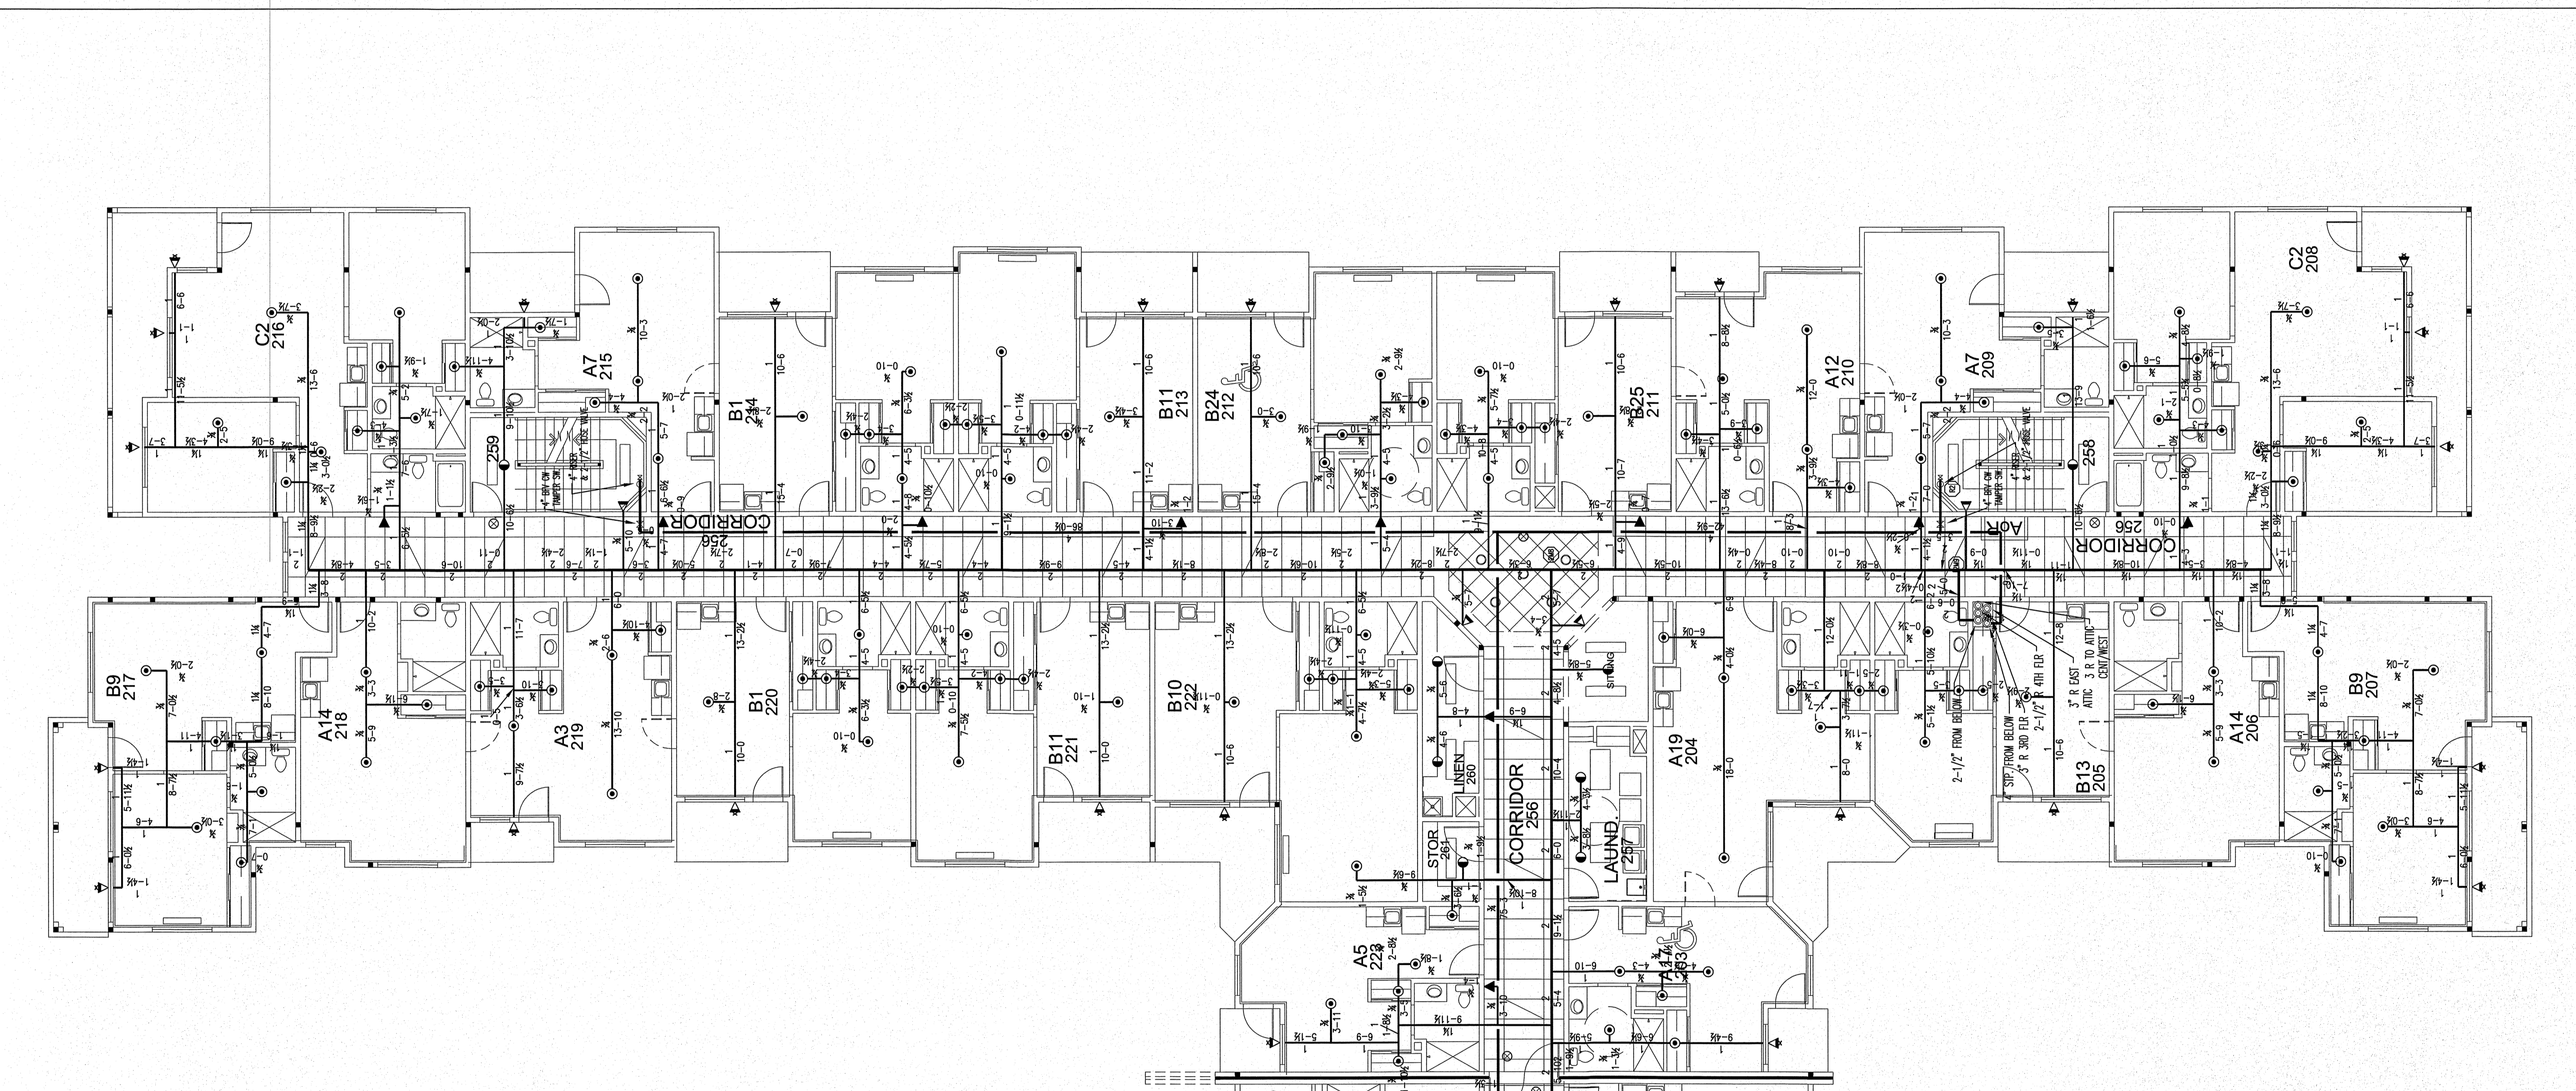

2nd FLOOR EAST PLAN
SCALE: 1/8" = 1'-0"

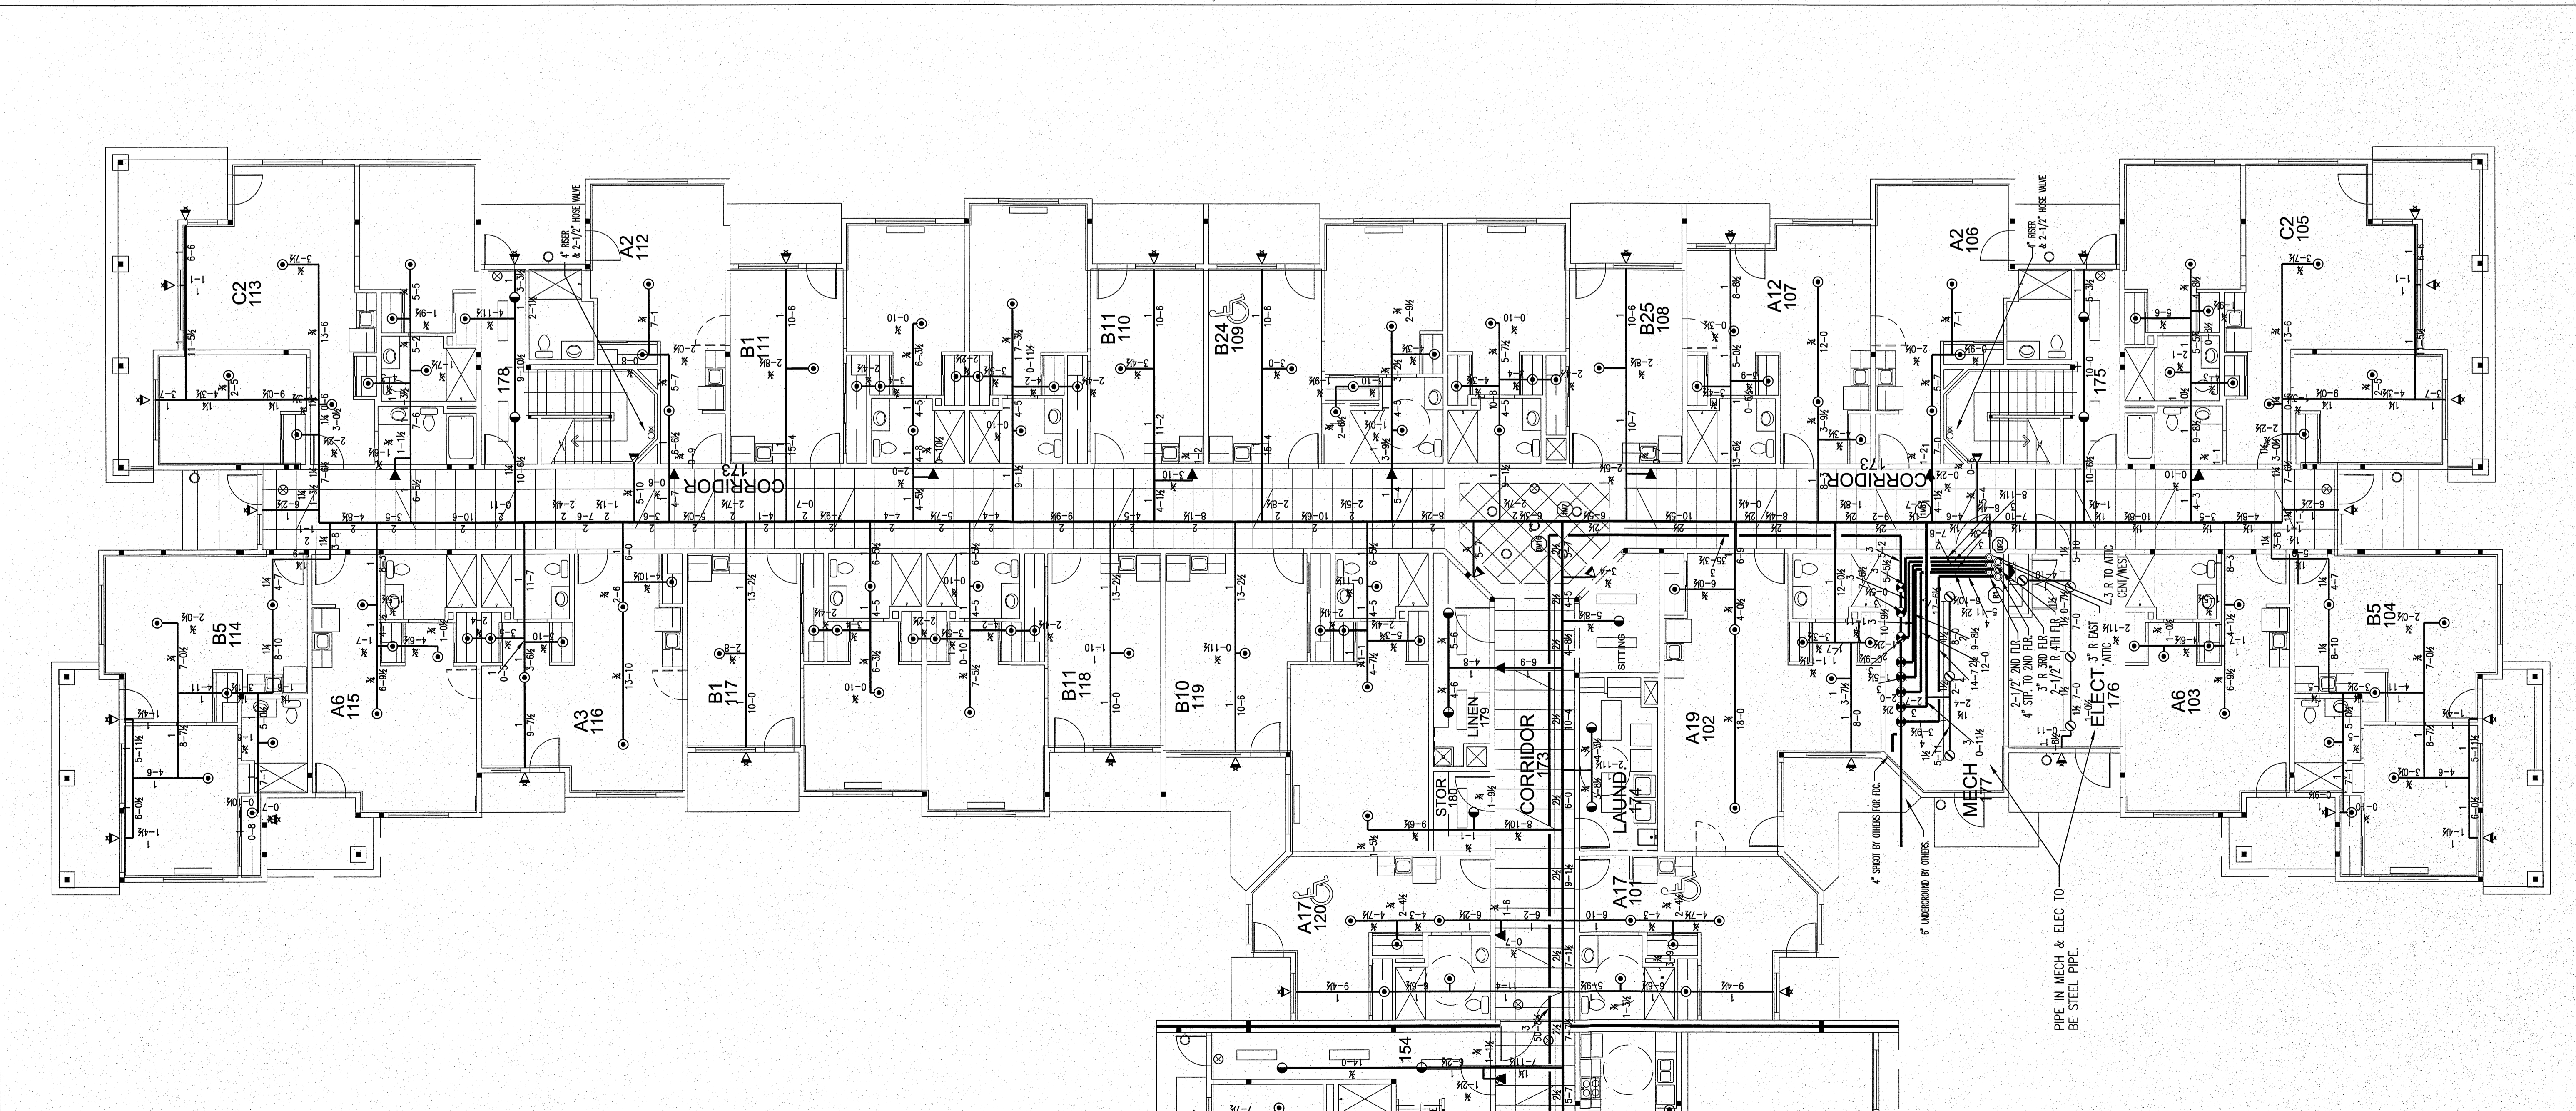

1st FLOOR EAST PLAN
SCALE: 1/8" = 1'-0"