



SPRINKLER SYMBOL DESCRIPTION						
SYMBOL	SIZE	K-FAC	MAKE	PART#	RESPONSE	QTY
①	1/2"	4.9	TYCO	TY2234	FAST RESP	125
②	1/2"	5.6	TYCO	TY2234	QUICK RESPONSE	8
③	1/2"	5.6	TYCO	TY2234	QUICK RESPONSE	20
④	1/2"	5.6	TYCO	TY2234	QUICK RESPONSE	17
⑤	1/2"	5.6	TYCO	TY2234	QUICK RESPONSE	21
⑥	1/2"	4.2	TYCO	TY1334	FAST RESP	151
⑦	1/2"	5.6	TYCO	TY2234	QUICK RESPONSE	17
⑧	1/2"	5.6	TYCO	TY2234	FAST RESP	4
⑨	1/2"	5.6	TYCO	TY2234	FAST RESP	4
⑩	1/2"	5.6	TYCO	TY2234	FAST RESP	4
⑪	1/2"	5.6	TYCO	TY2234	FAST RESP	4
⑫	1/2"	5.6	TYCO	TY2234	FAST RESP	4
⑬	1/2"	5.6	TYCO	TY2234	FAST RESP	4
⑭	1/2"	5.6	TYCO	TY2234	FAST RESP	4
⑮	1/2"	5.6	TYCO	TY2234	FAST RESP	4
⑯	1/2"	5.6	TYCO	TY2234	FAST RESP	4
⑰	1/2"	5.6	TYCO	TY2234	FAST RESP	4
⑱	1/2"	5.6	TYCO	TY2234	FAST RESP	4
⑲	1/2"	5.6	TYCO	TY2234	FAST RESP	4
⑳	1/2"	5.6	TYCO	TY2234	FAST RESP	4
㉑	1/2"	5.6	TYCO	TY2234	FAST RESP	4
㉒	1/2"	5.6	TYCO	TY2234	FAST RESP	4
㉓	1/2"	5.6	TYCO	TY2234	FAST RESP	4
㉔	1/2"	5.6	TYCO	TY2234	FAST RESP	4
㉕	1/2"	5.6	TYCO	TY2234	FAST RESP	4
㉖	1/2"	5.6	TYCO	TY2234	FAST RESP	4
㉗	1/2"	5.6	TYCO	TY2234	FAST RESP	4
㉘	1/2"	5.6	TYCO	TY2234	FAST RESP	4
㉙	1/2"	5.6	TYCO	TY2234	FAST RESP	4
㉚	1/2"	5.6	TYCO	TY2234	FAST RESP	4
㉛	1/2"	5.6	TYCO	TY2234	FAST RESP	4
㉜	1/2"	5.6	TYCO	TY2234	FAST RESP	4
㉝	1/2"	5.6	TYCO	TY2234	FAST RESP	4
㉞	1/2"	5.6	TYCO	TY2234	FAST RESP	4
㉟	1/2"	5.6	TYCO	TY2234	FAST RESP	4
㊱	1/2"	5.6	TYCO	TY2234	FAST RESP	4
㊲	1/2"	5.6	TYCO	TY2234	FAST RESP	4
㊳	1/2"	5.6	TYCO	TY2234	FAST RESP	4
㊴	1/2"	5.6	TYCO	TY2234	FAST RESP	4
㊵	1/2"	5.6	TYCO	TY2234	FAST RESP	4
㊶	1/2"	5.6	TYCO	TY2234	FAST RESP	4
㊷	1/2"	5.6	TYCO	TY2234	FAST RESP	4
㊸	1/2"	5.6	TYCO	TY2234	FAST RESP	4
㊹	1/2"	5.6	TYCO	TY2234	FAST RESP	4
㊺	1/2"	5.6	TYCO	TY2234	FAST RESP	4
㊻	1/2"	5.6	TYCO	TY2234	FAST RESP	4
㊼	1/2"	5.6	TYCO	TY2234	FAST RESP	4
㊽	1/2"	5.6	TYCO	TY2234	FAST RESP	4
㊾	1/2"	5.6	TYCO	TY2234	FAST RESP	4
㊿	1/2"	5.6	TYCO	TY2234	FAST RESP	4


TOTAL MESSAGE REQUIRED ON THIS SHEET: 363

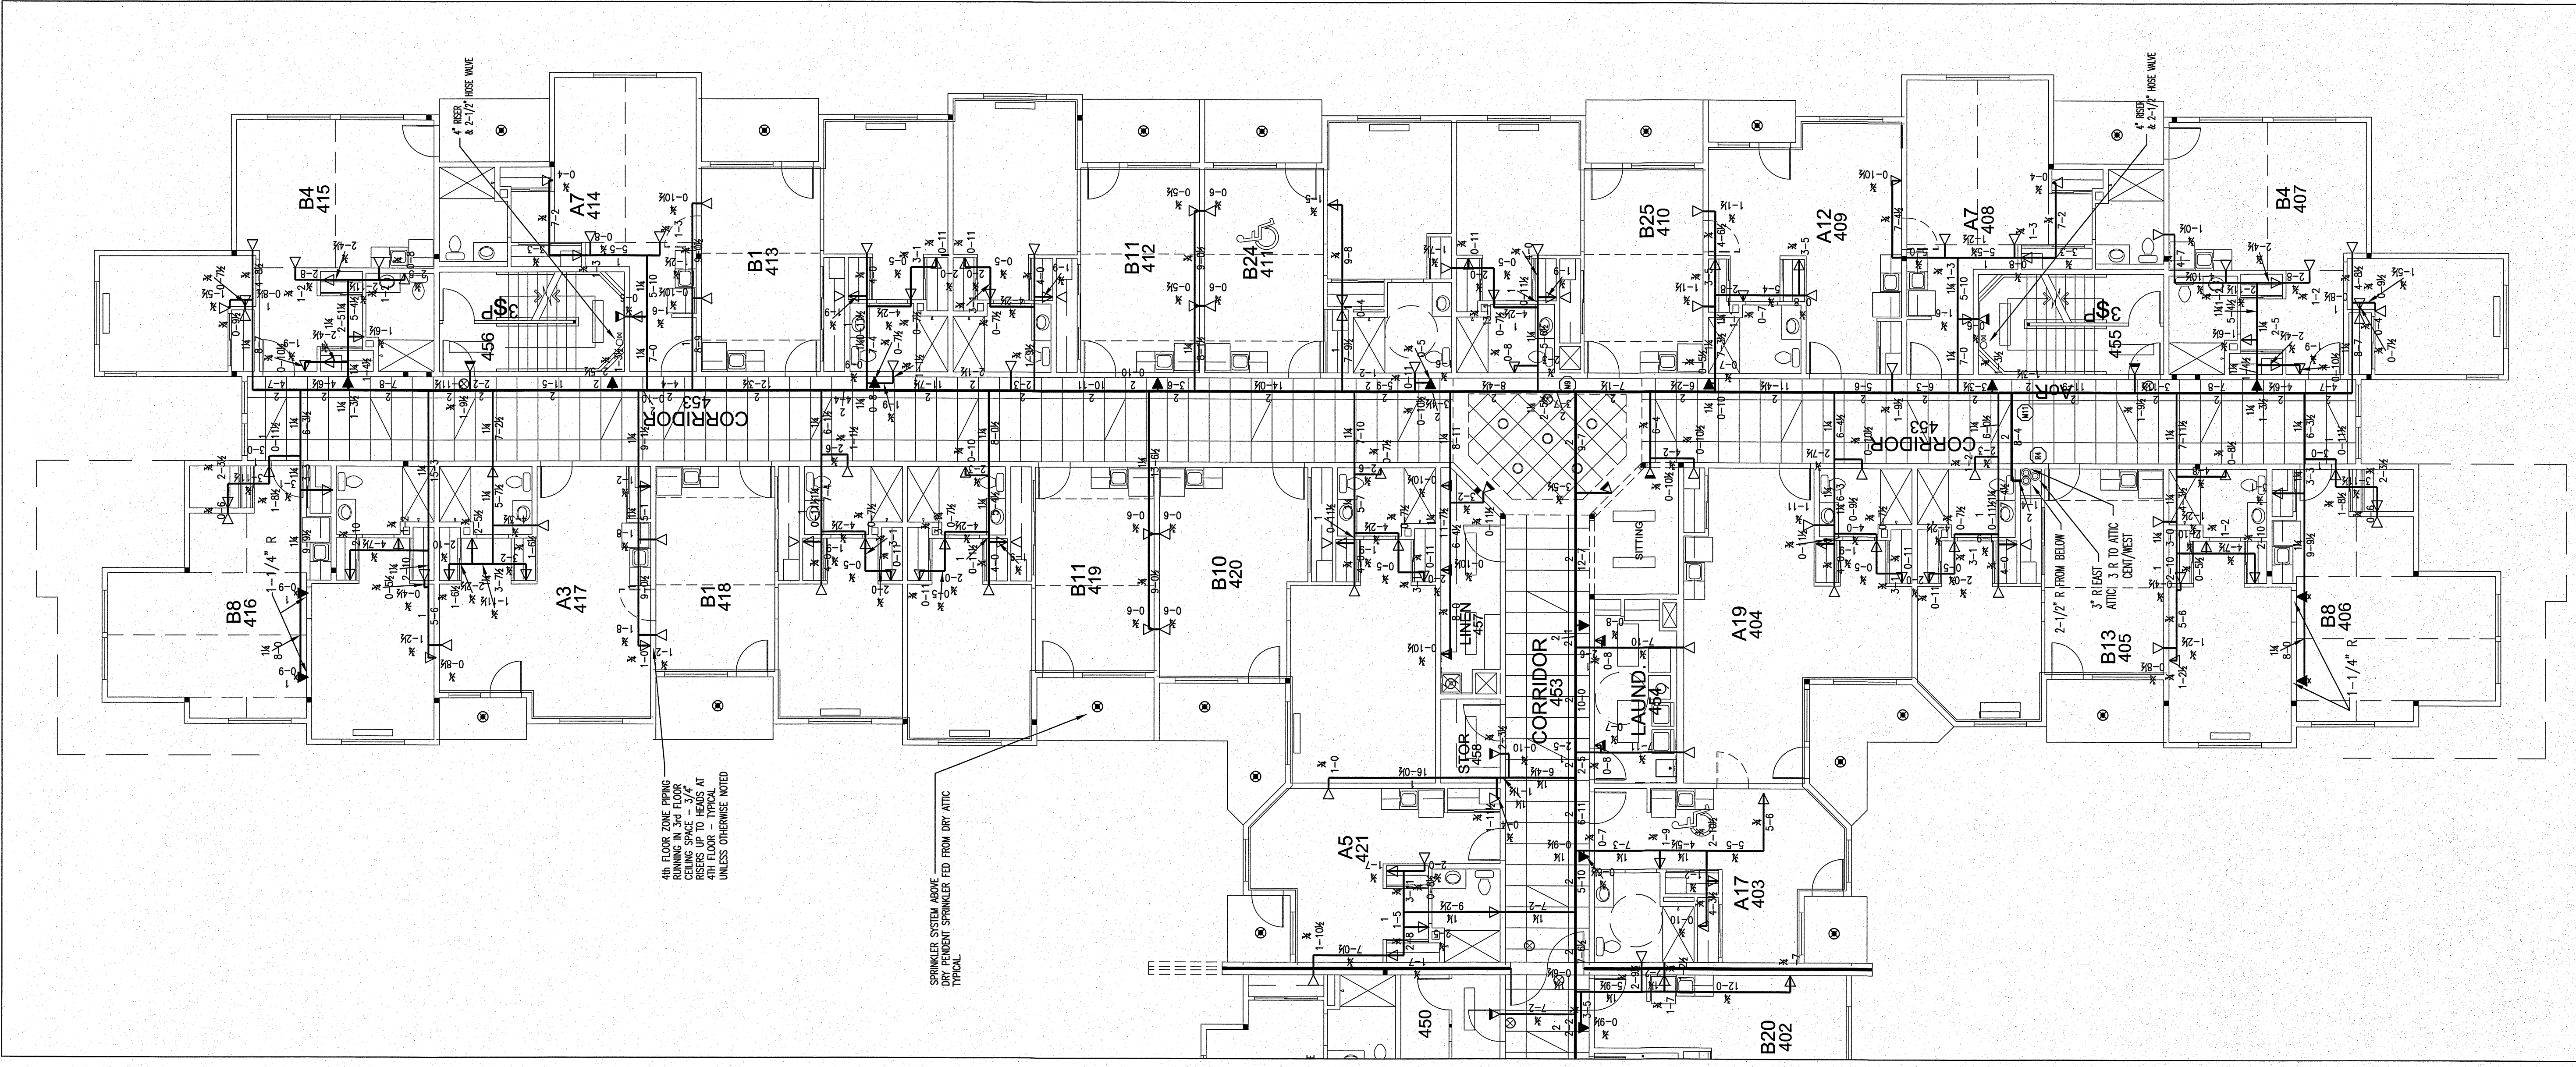


4th FLOOR EAST PLAN
SCALE: 1/8" = 1'-0"

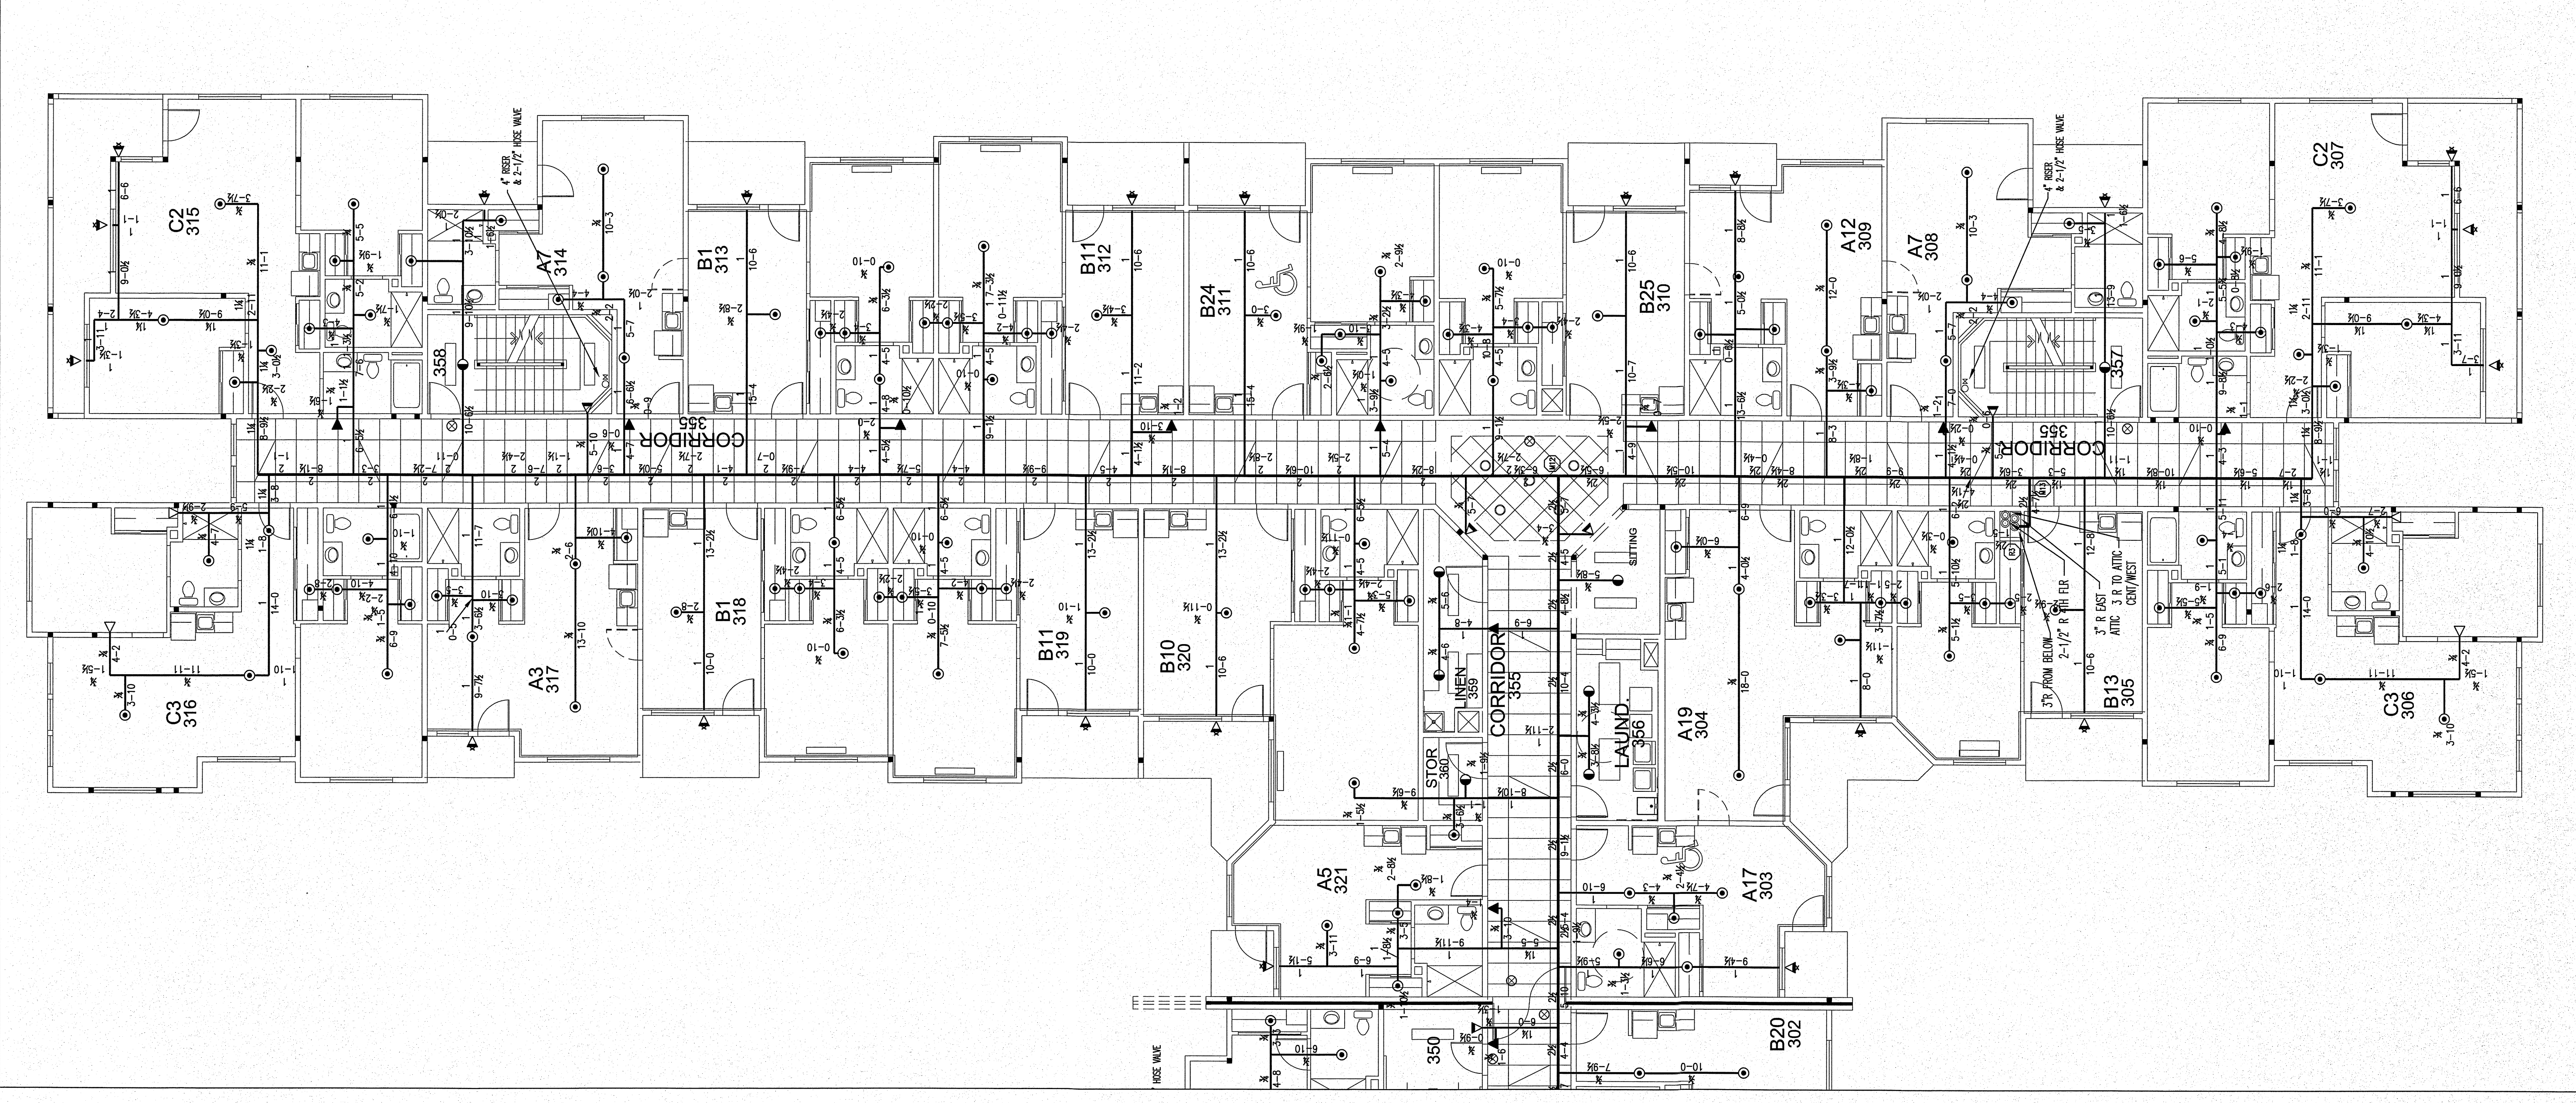

3rd FLOOR EAST PLAN
SCALE: 1/8" = 1'-0"

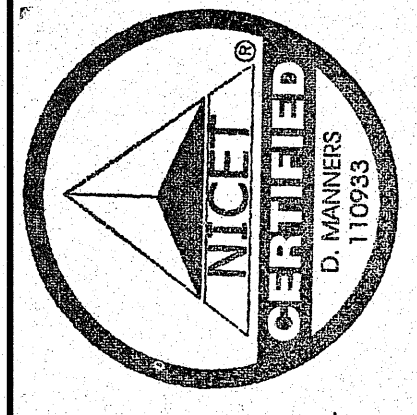

 ENGINEER'S STAMP
 02/13/17


 PROJECT NAME:
 PORTLAND RETIREMENT RESIDENCE
 802 OCEAN AVE.
 PORTLAND MAINE 04103
 SHEET TITLE:
 FIRE SPRINKLER PLAN
 3rd & 4th FLOOR EAST
 DRAWN BY:
 D.S.
 DATE:
 DEC 14, 2016
 SCALE:
 AS SHOWN
 JOB NUMBER:
 MEC-16-001
 SHEET NUMBER:
 FP 6 OF 9