


SPRINKLER SYMBOL DESCRIPTION					QTY	
SYMBOL	SIZE	K/FAC	MAKE	PART#	RESPONSE	COMMENTS
⊙	1/2"	8.0	TYCO	TY168	FAST RESP	21
⊙	1/2"	5.6	TYCO	TY168	FAST RESP	61
⊙	1/2"	5.6	TYCO	TY168	FAST RESP	67
⊙	1/2"	5.6	TYCO	TY168	FAST RESP	2
⊙	1/2"	5.6	TYCO	TY168	FAST RESP	24
TOTAL HEADS REQUIRED ON THIS SHEET:						175

DATE	REV	DESCRIPTION
DEC 15 2016	0	ISSUED FOR APPROVAL

ENGINEERS STAMP

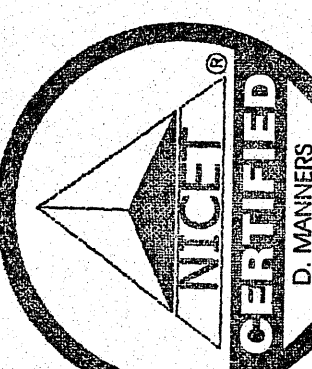

02/13/17


EDGE

FIRE PROTECTION
FRONTLINE DEFENSE

PROJECT NAME:
 PORTLAND RETIREMENT RESIDENCE
 802 OCEAN AVE.
 PORTLAND MAINE 04103

SHEET TITLE:
 FIRE SPRINKLER PLAN
 ATTIC CENTER & WEST

DRAWN BY: D.S.	SCALE: AS SHOWN
DATE: DEC 14 2016	JOB NUMBER: MEC-16-001
SHEET NUMBER: FP 8 OF 9	

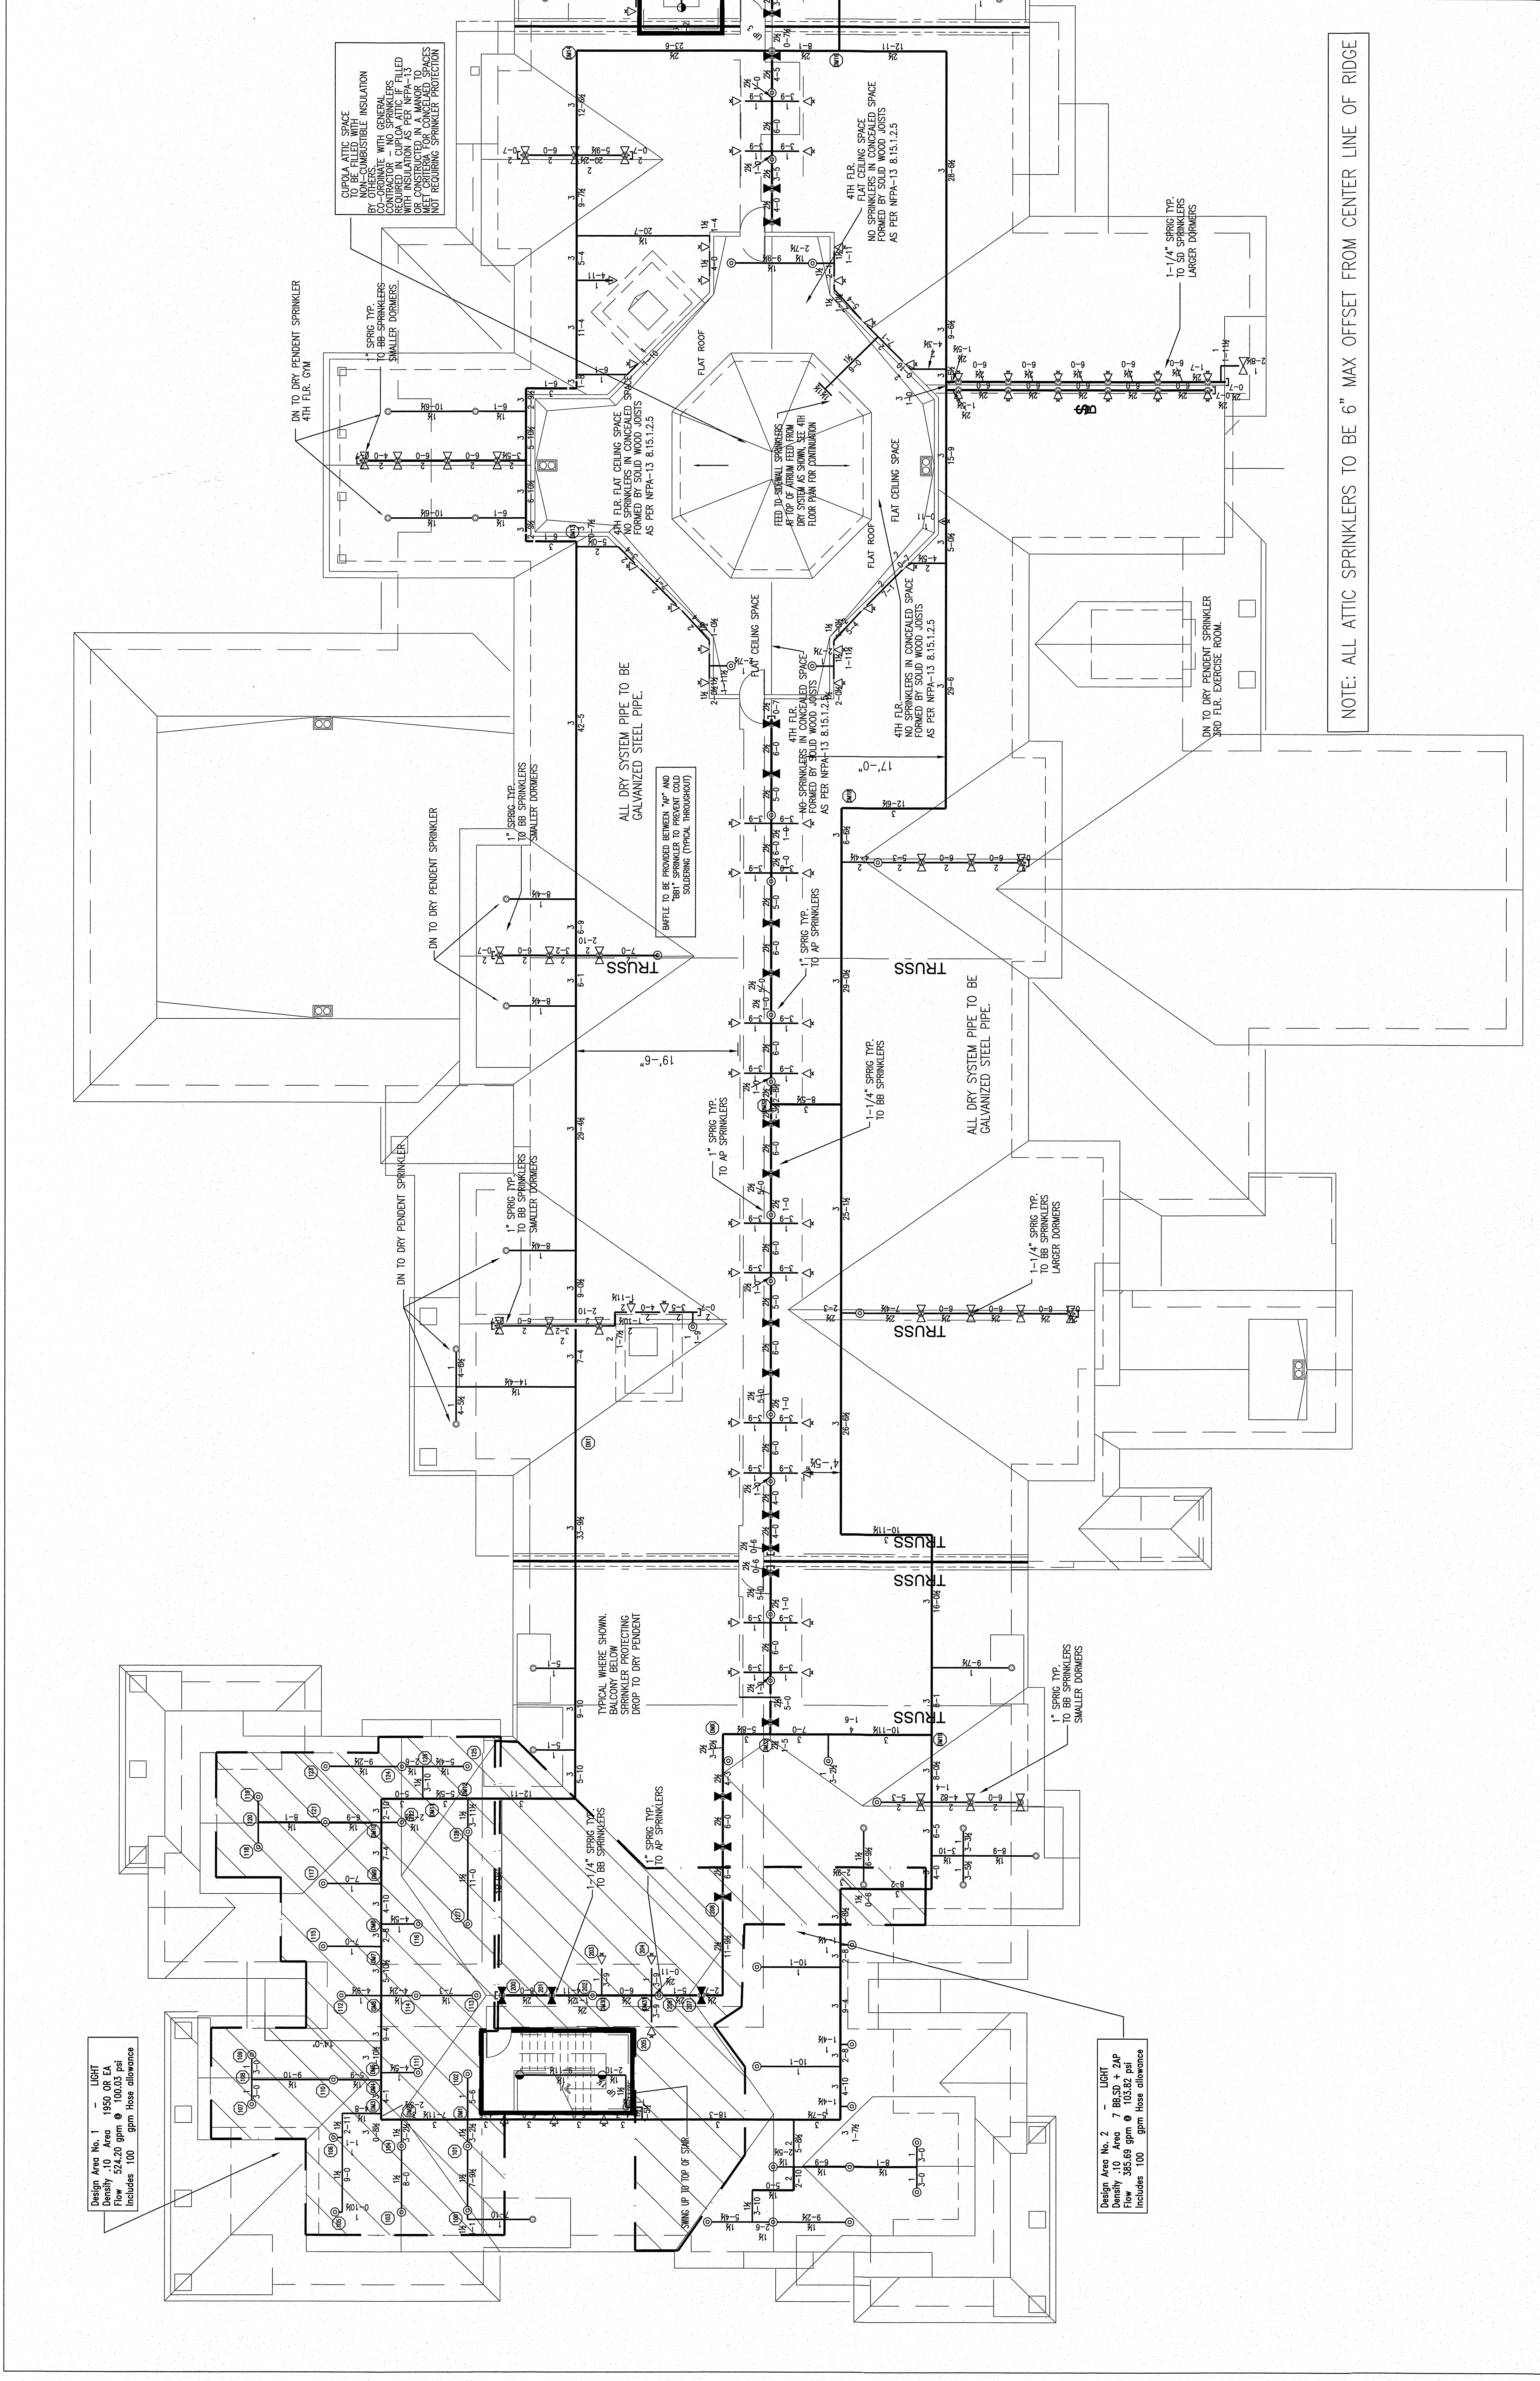

ATTIC CENTER & WEST PLAN

SCALE: 1/8" = 1'-0"

Design Area No. 1 - LIGHT
 Area = 1050.00 sq ft
 Flow = 514.47 gpm @ 103.32 psi
 Includes 100' gpm hose allowance

Design Area No. 2 - LIGHT
 Area = 1050.00 sq ft
 Flow = 514.47 gpm @ 103.32 psi
 Includes 100' gpm hose allowance