



NOTE: NFPA #130 WET PIPE SPRINKLER SYSTEM

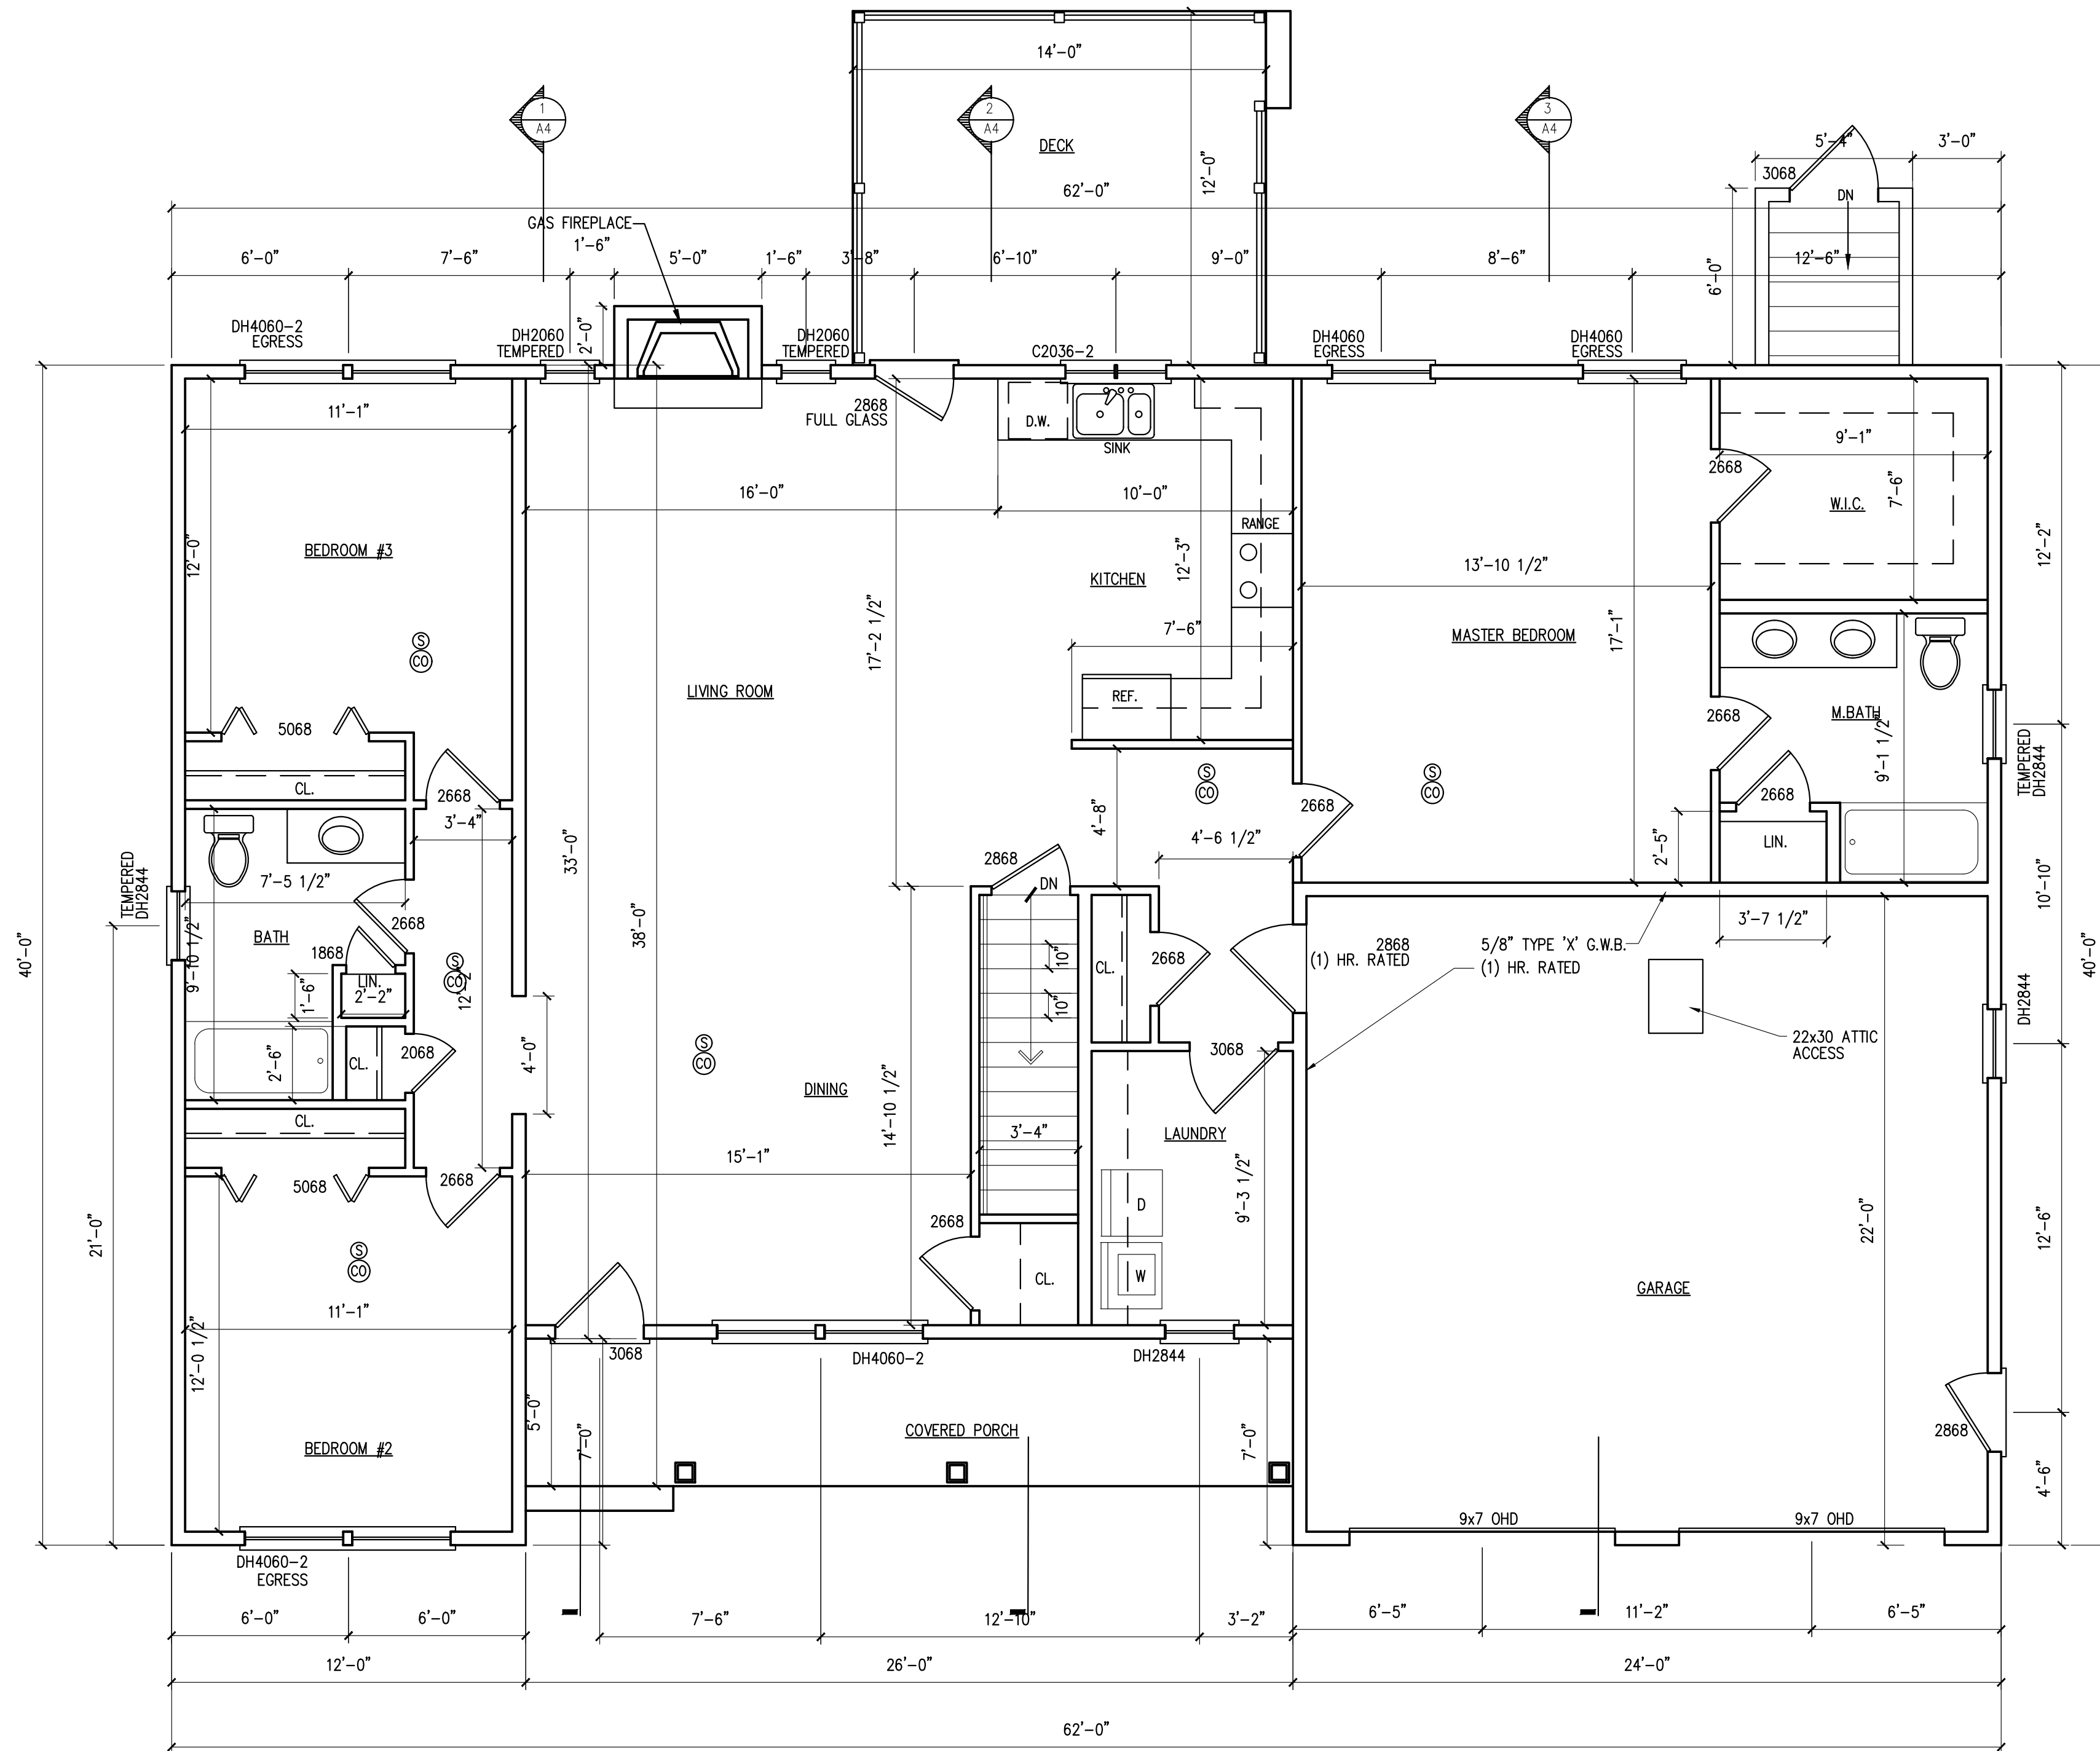

**FIRST FLOOR**  
 HOUSE: 1,756 S.F. 1/4" = 1'-0"  
 GARAGE: 539 S.F.

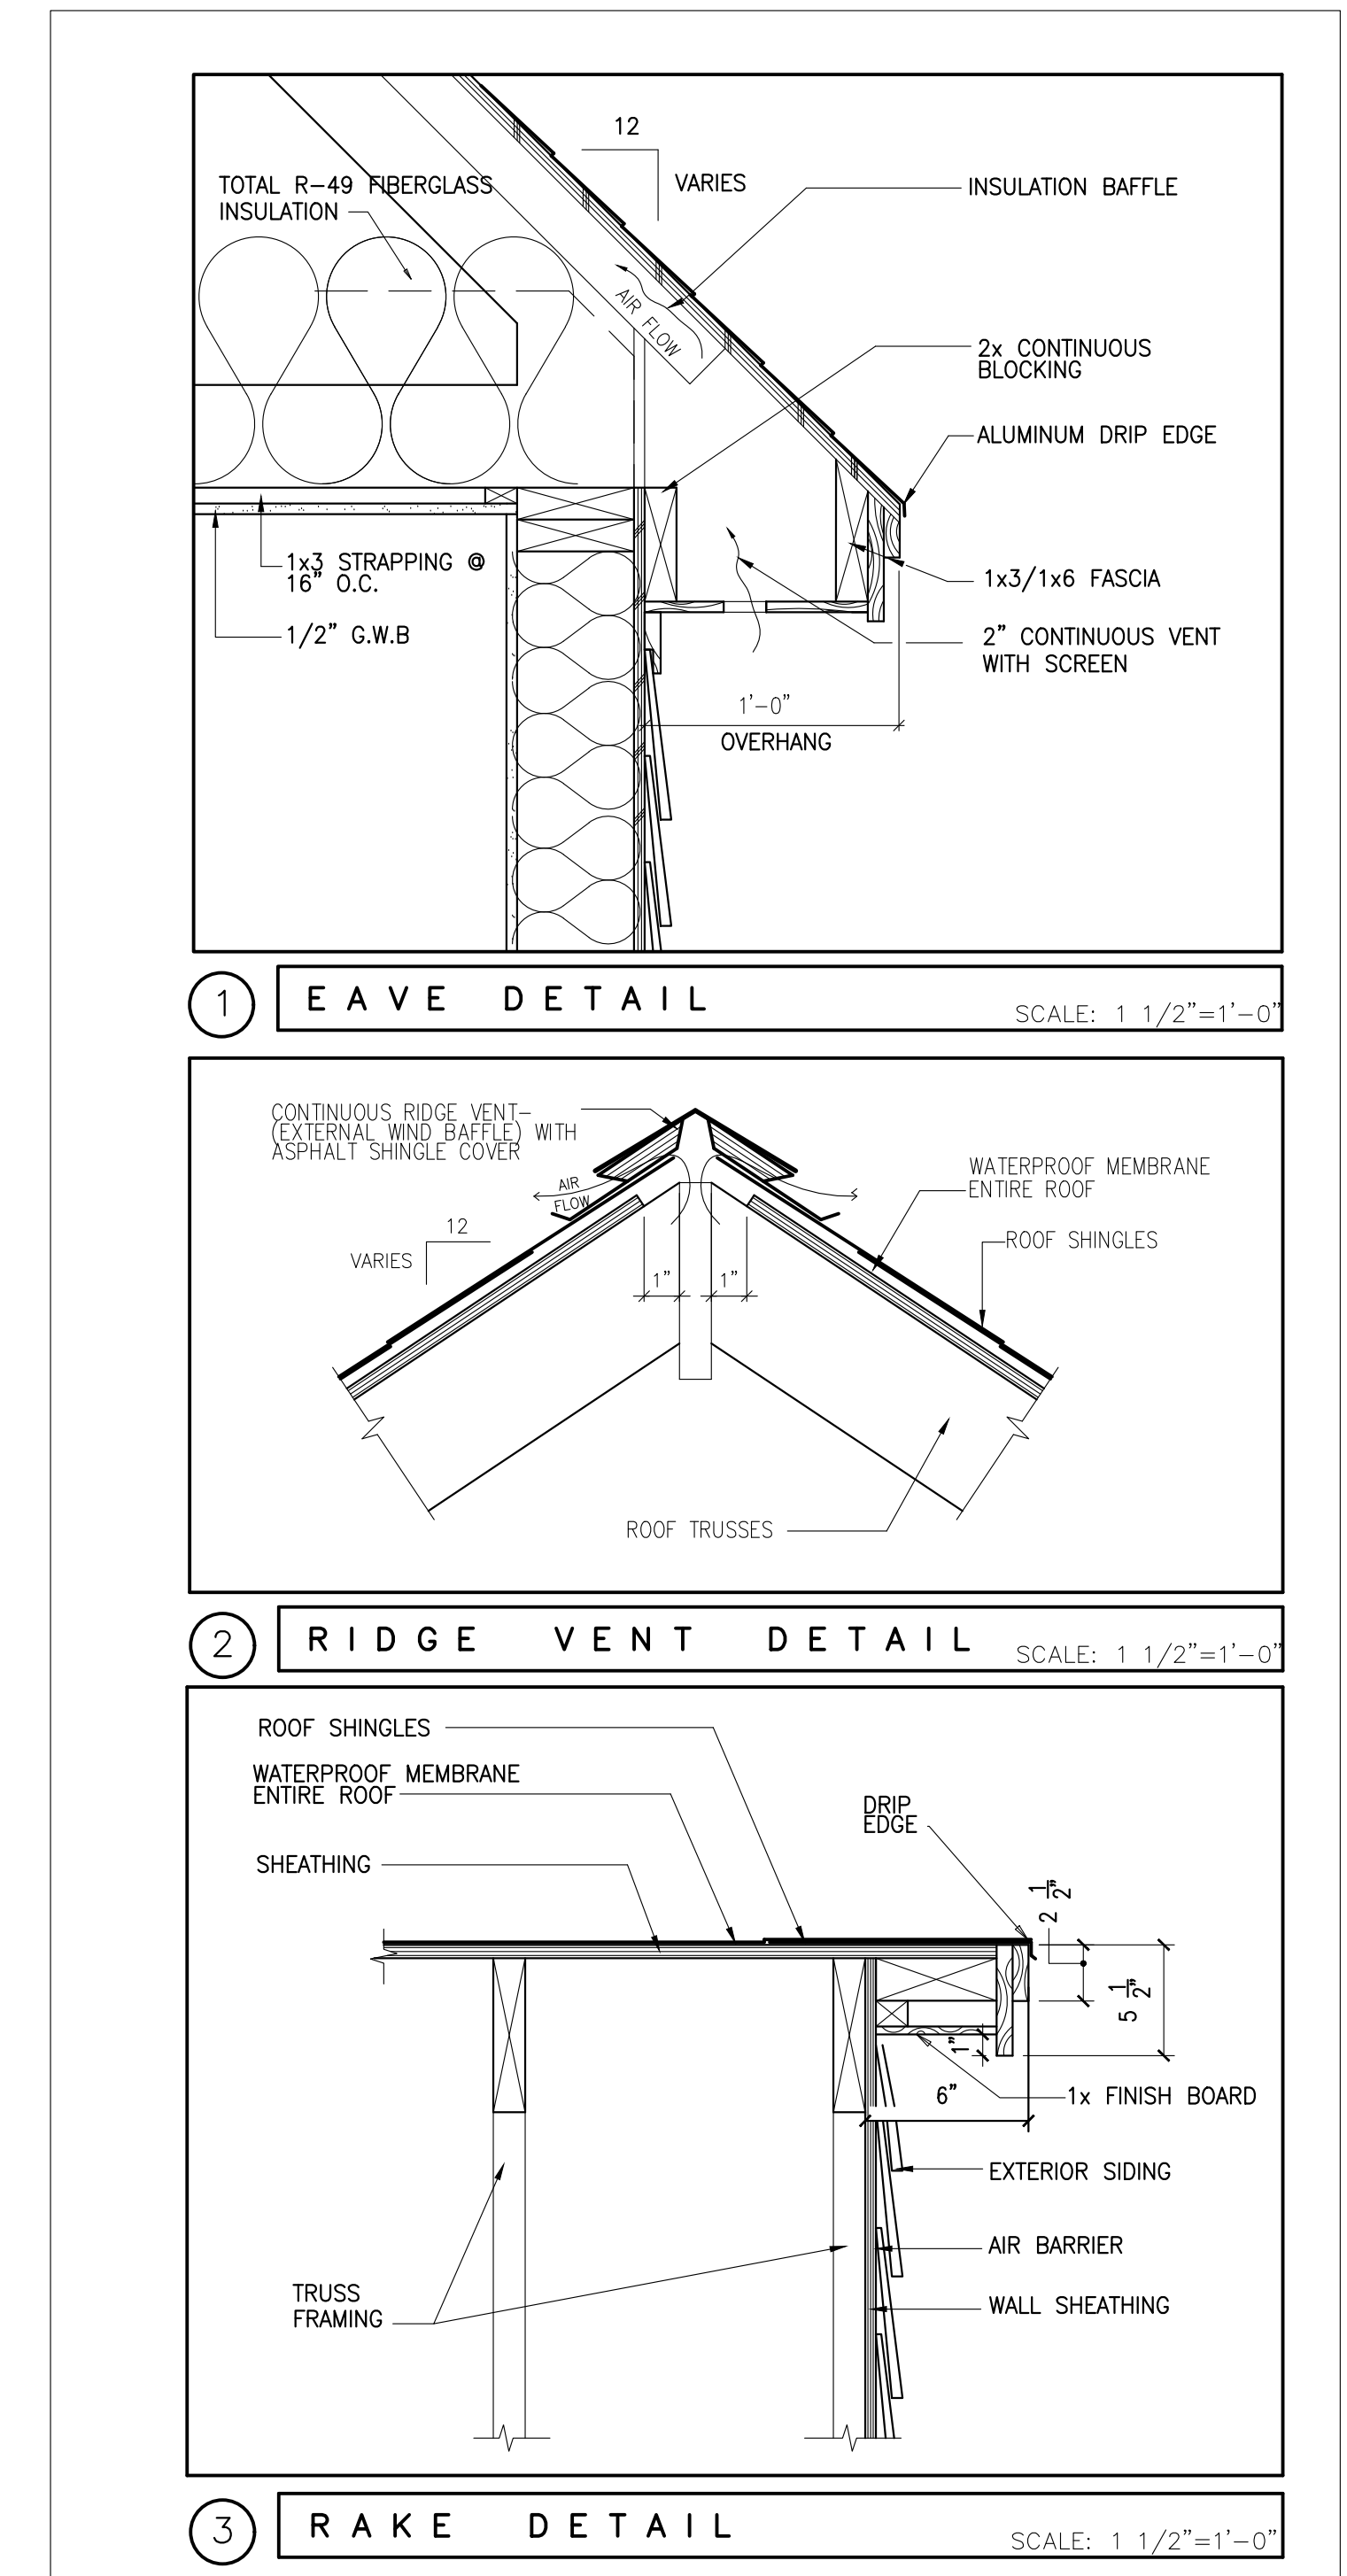

**RANCH DESIGN**

PORTLAND, MAINE

FLOOR PLAN  
 DETAILS

REVISIONS

DRAWN BY:	DLP
CHECKED BY:	DLP
DATE:	12-22-17
ISSUED:	

**A1**

SCALE: AS NOTED