




NOTE: NFPA #13D WET PIPE SPRINKLER SYSTEM
SMOKE AND CO'S TO BE HARD WIRED

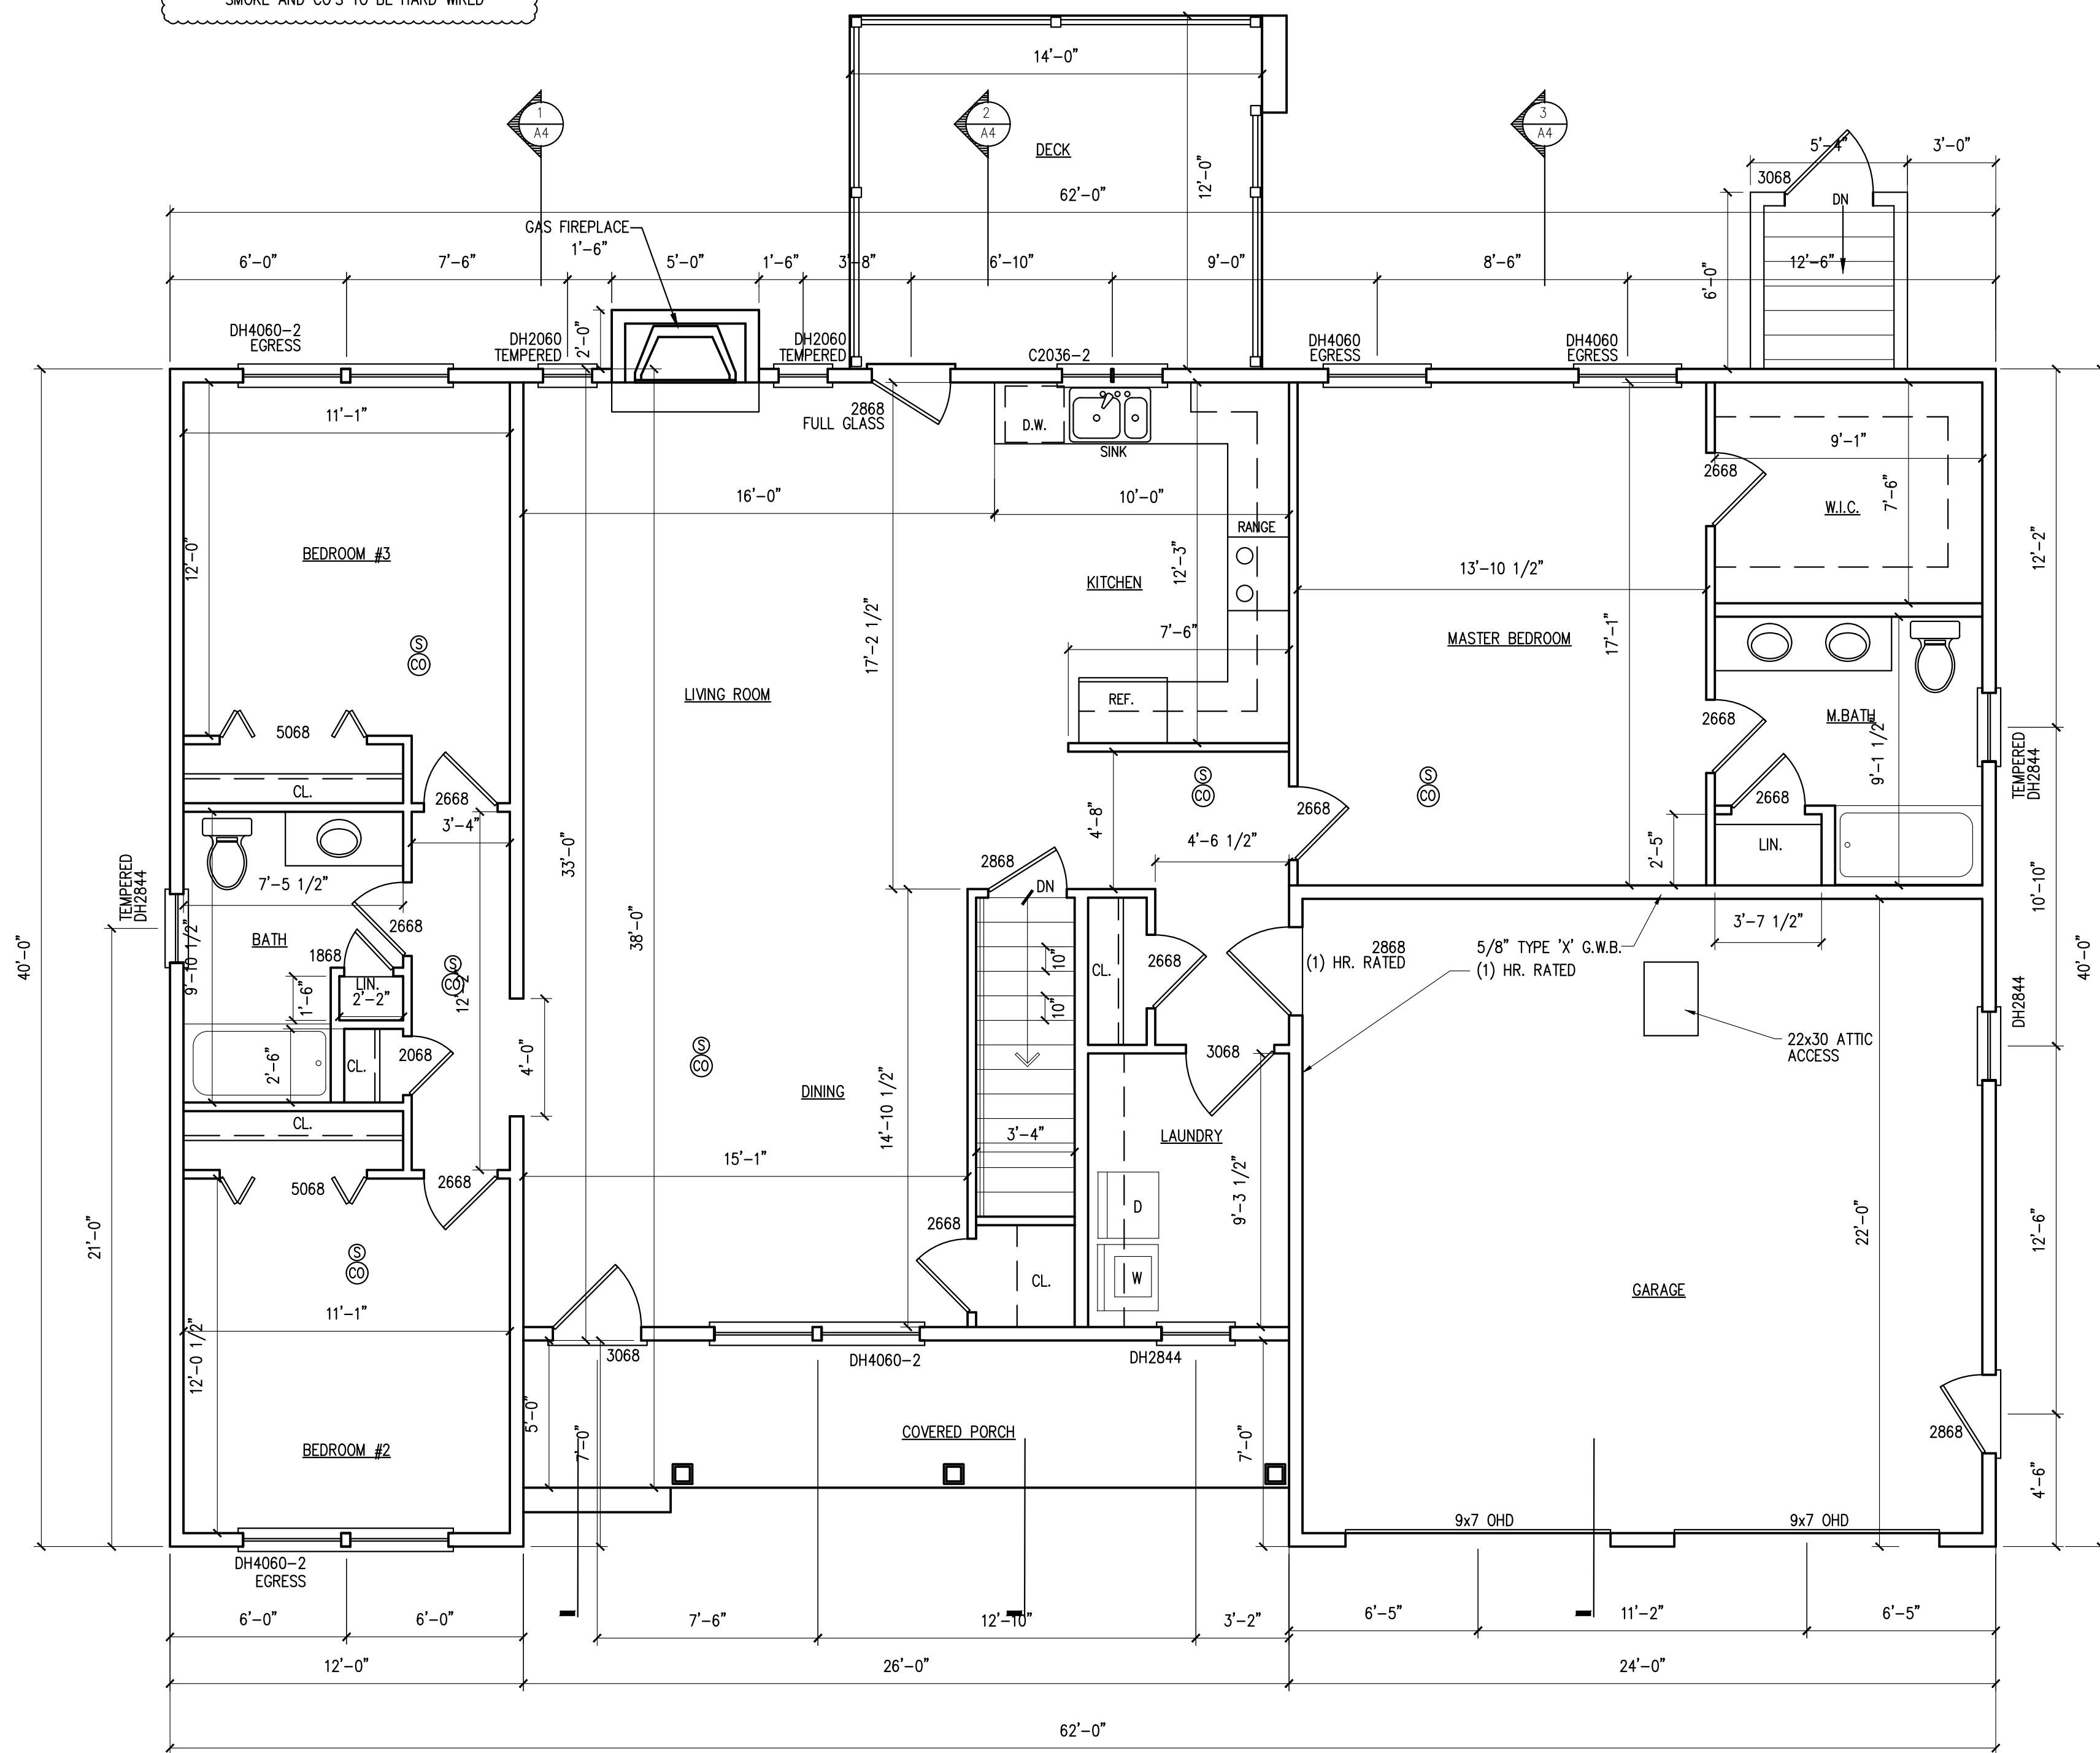


FIRST FLOOR
HOUSE: 1,756 S.F. 1/4" = 1'-0"
GARAGE: 539 S.F.

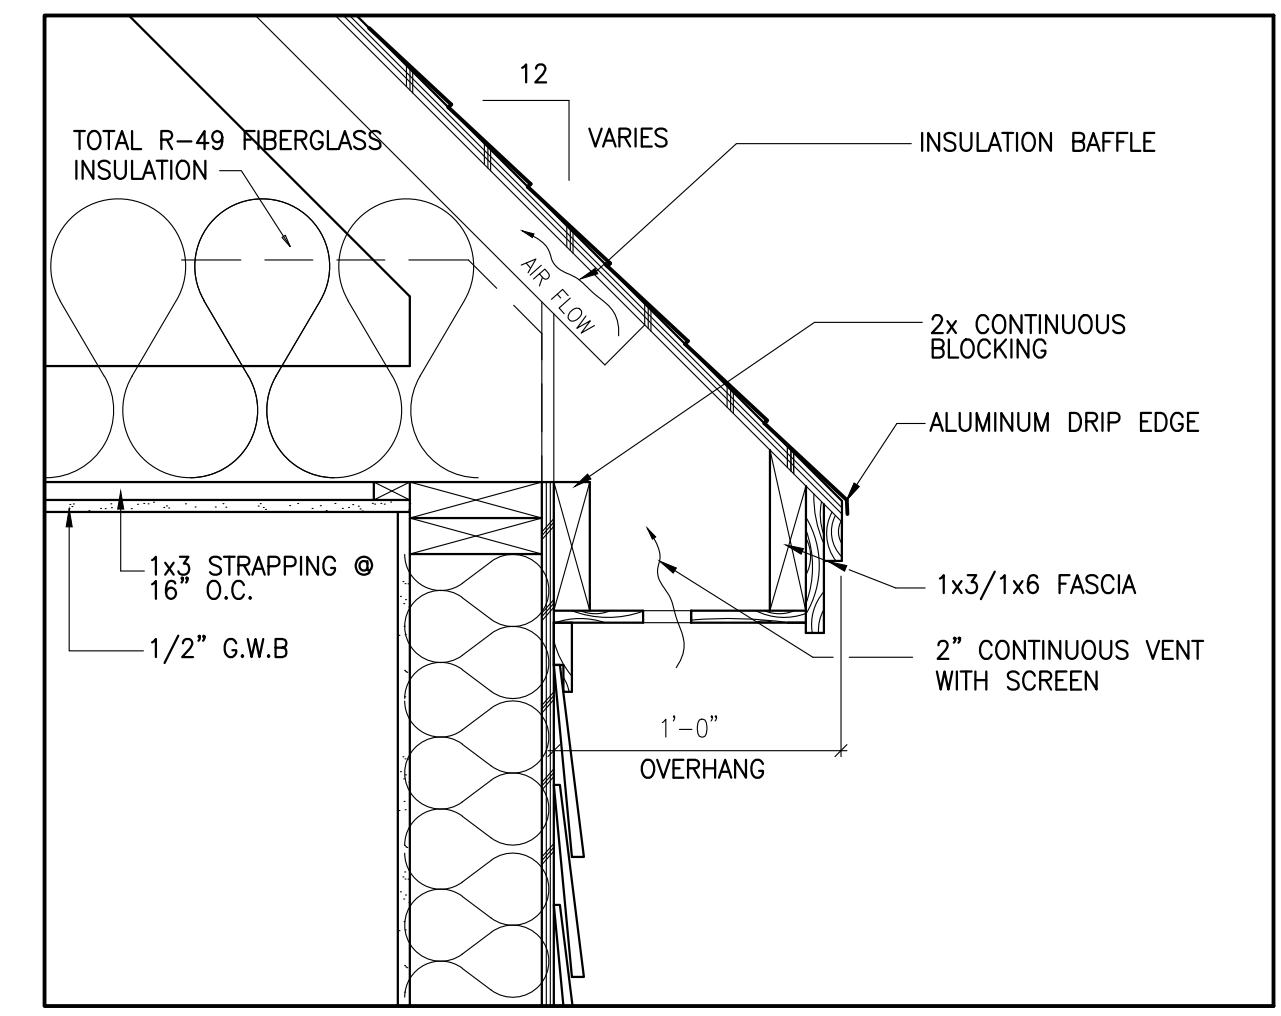

1 EAVE DETAIL SCALE: 1 1/2" = 1'-0"

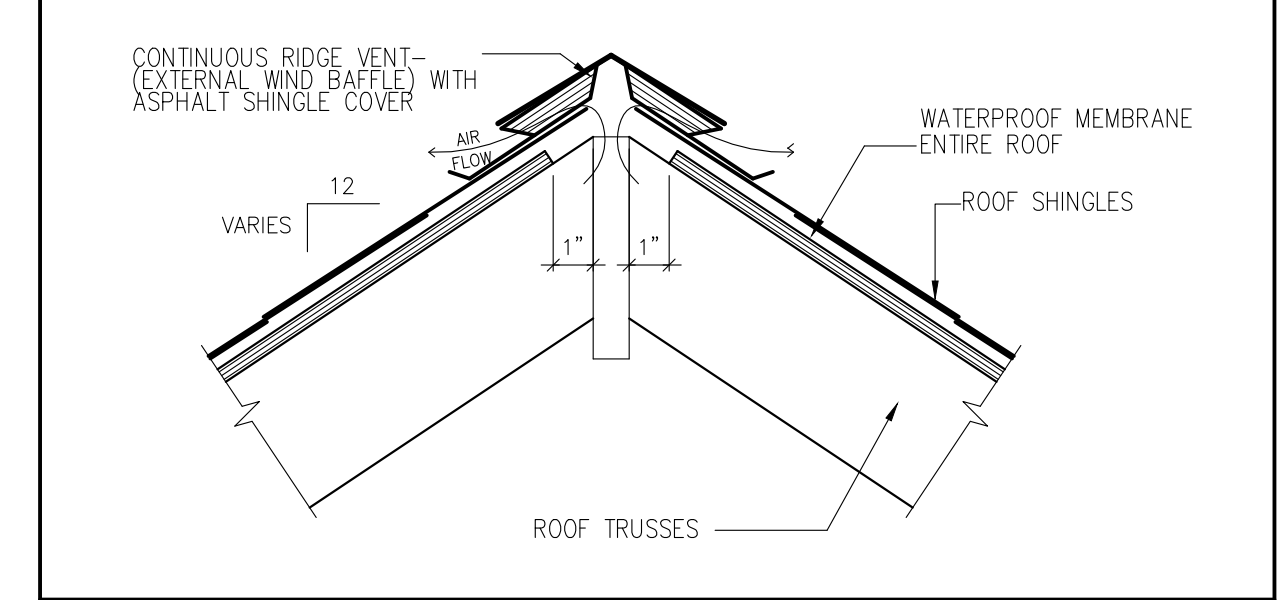

2 RIDGE VENT DETAIL SCALE: 1 1/2" = 1'-0"

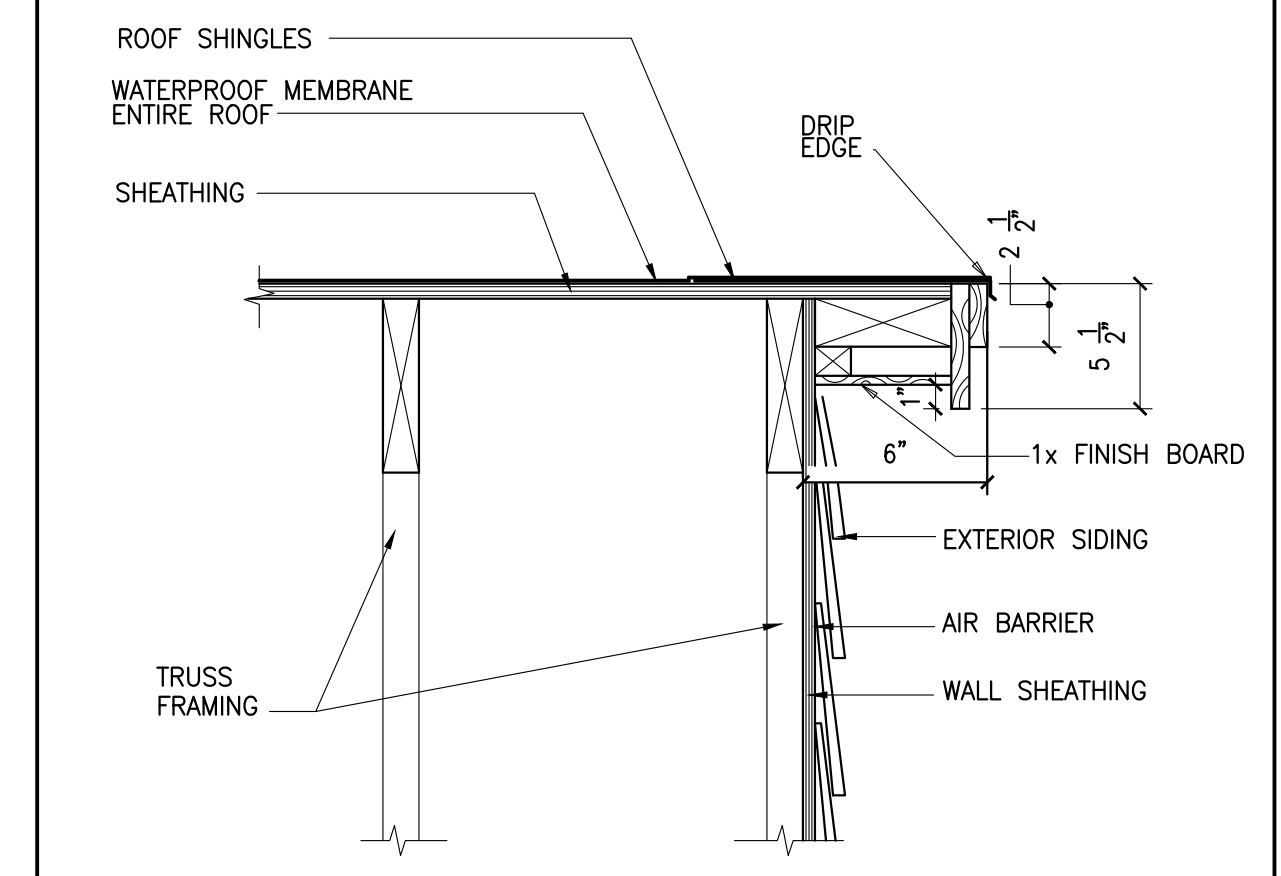

3 RAKE DETAIL SCALE: 1 1/2" = 1'-0"

RANCH DESIGN

PORTLAND, MAINE

FLOOR PLAN
DETAILS

REVISIONS	REVISIONS
DLP 1	01-30-18
DLP 1	12-22-17

A1

SCALE: AS NOTED