

TYPE S3.a NON-RATED


(STC 45) ONE LAYER 5/8\"/>

TYPE X6.1 1 HR FIRE RATED

(STC 45) ONE LAYER 5/8\"/>

2 INTERIOR ELEVATION @ BATHROOM & STORAGE

1/2" = 1'-0"

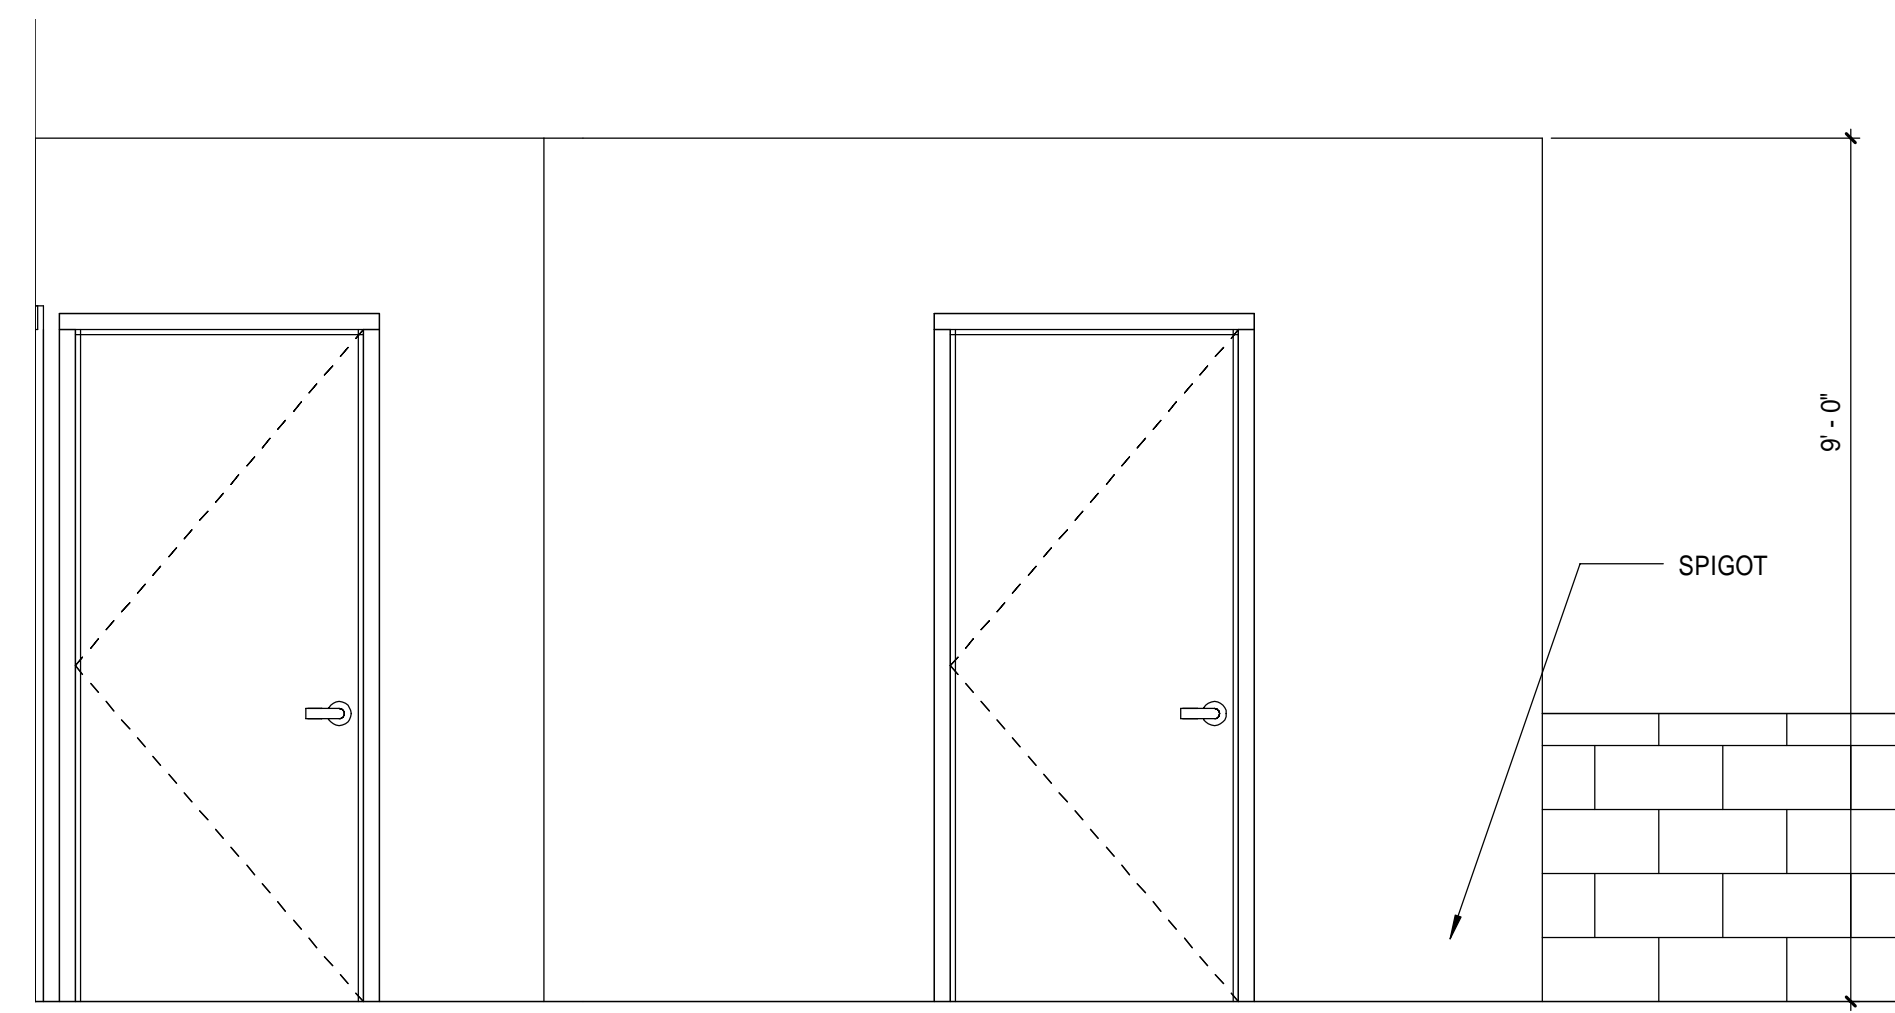

LIFE SAFETY LEGEND


- F1 — 1 HOUR RATED FIRE BARRIER
- FE FIRE EXTINGUISHER WALL HUNG
- EXIT SIGN

1. FIRE ALARM SYSTEM WILL BE ZONED FOR SEPARATE TENANTS
2. BUILDING IS FULLY SPRINKLERED

144 Fore Street P.O. Box #18
Portland, Maine 04104
tel. (207) 772-3846
fax. (207) 772-1070
www.smrtninc.com


SMRTI

ARCHITECTURE
ENGINEERING
PLANNING
INTERIORS
ENERGY

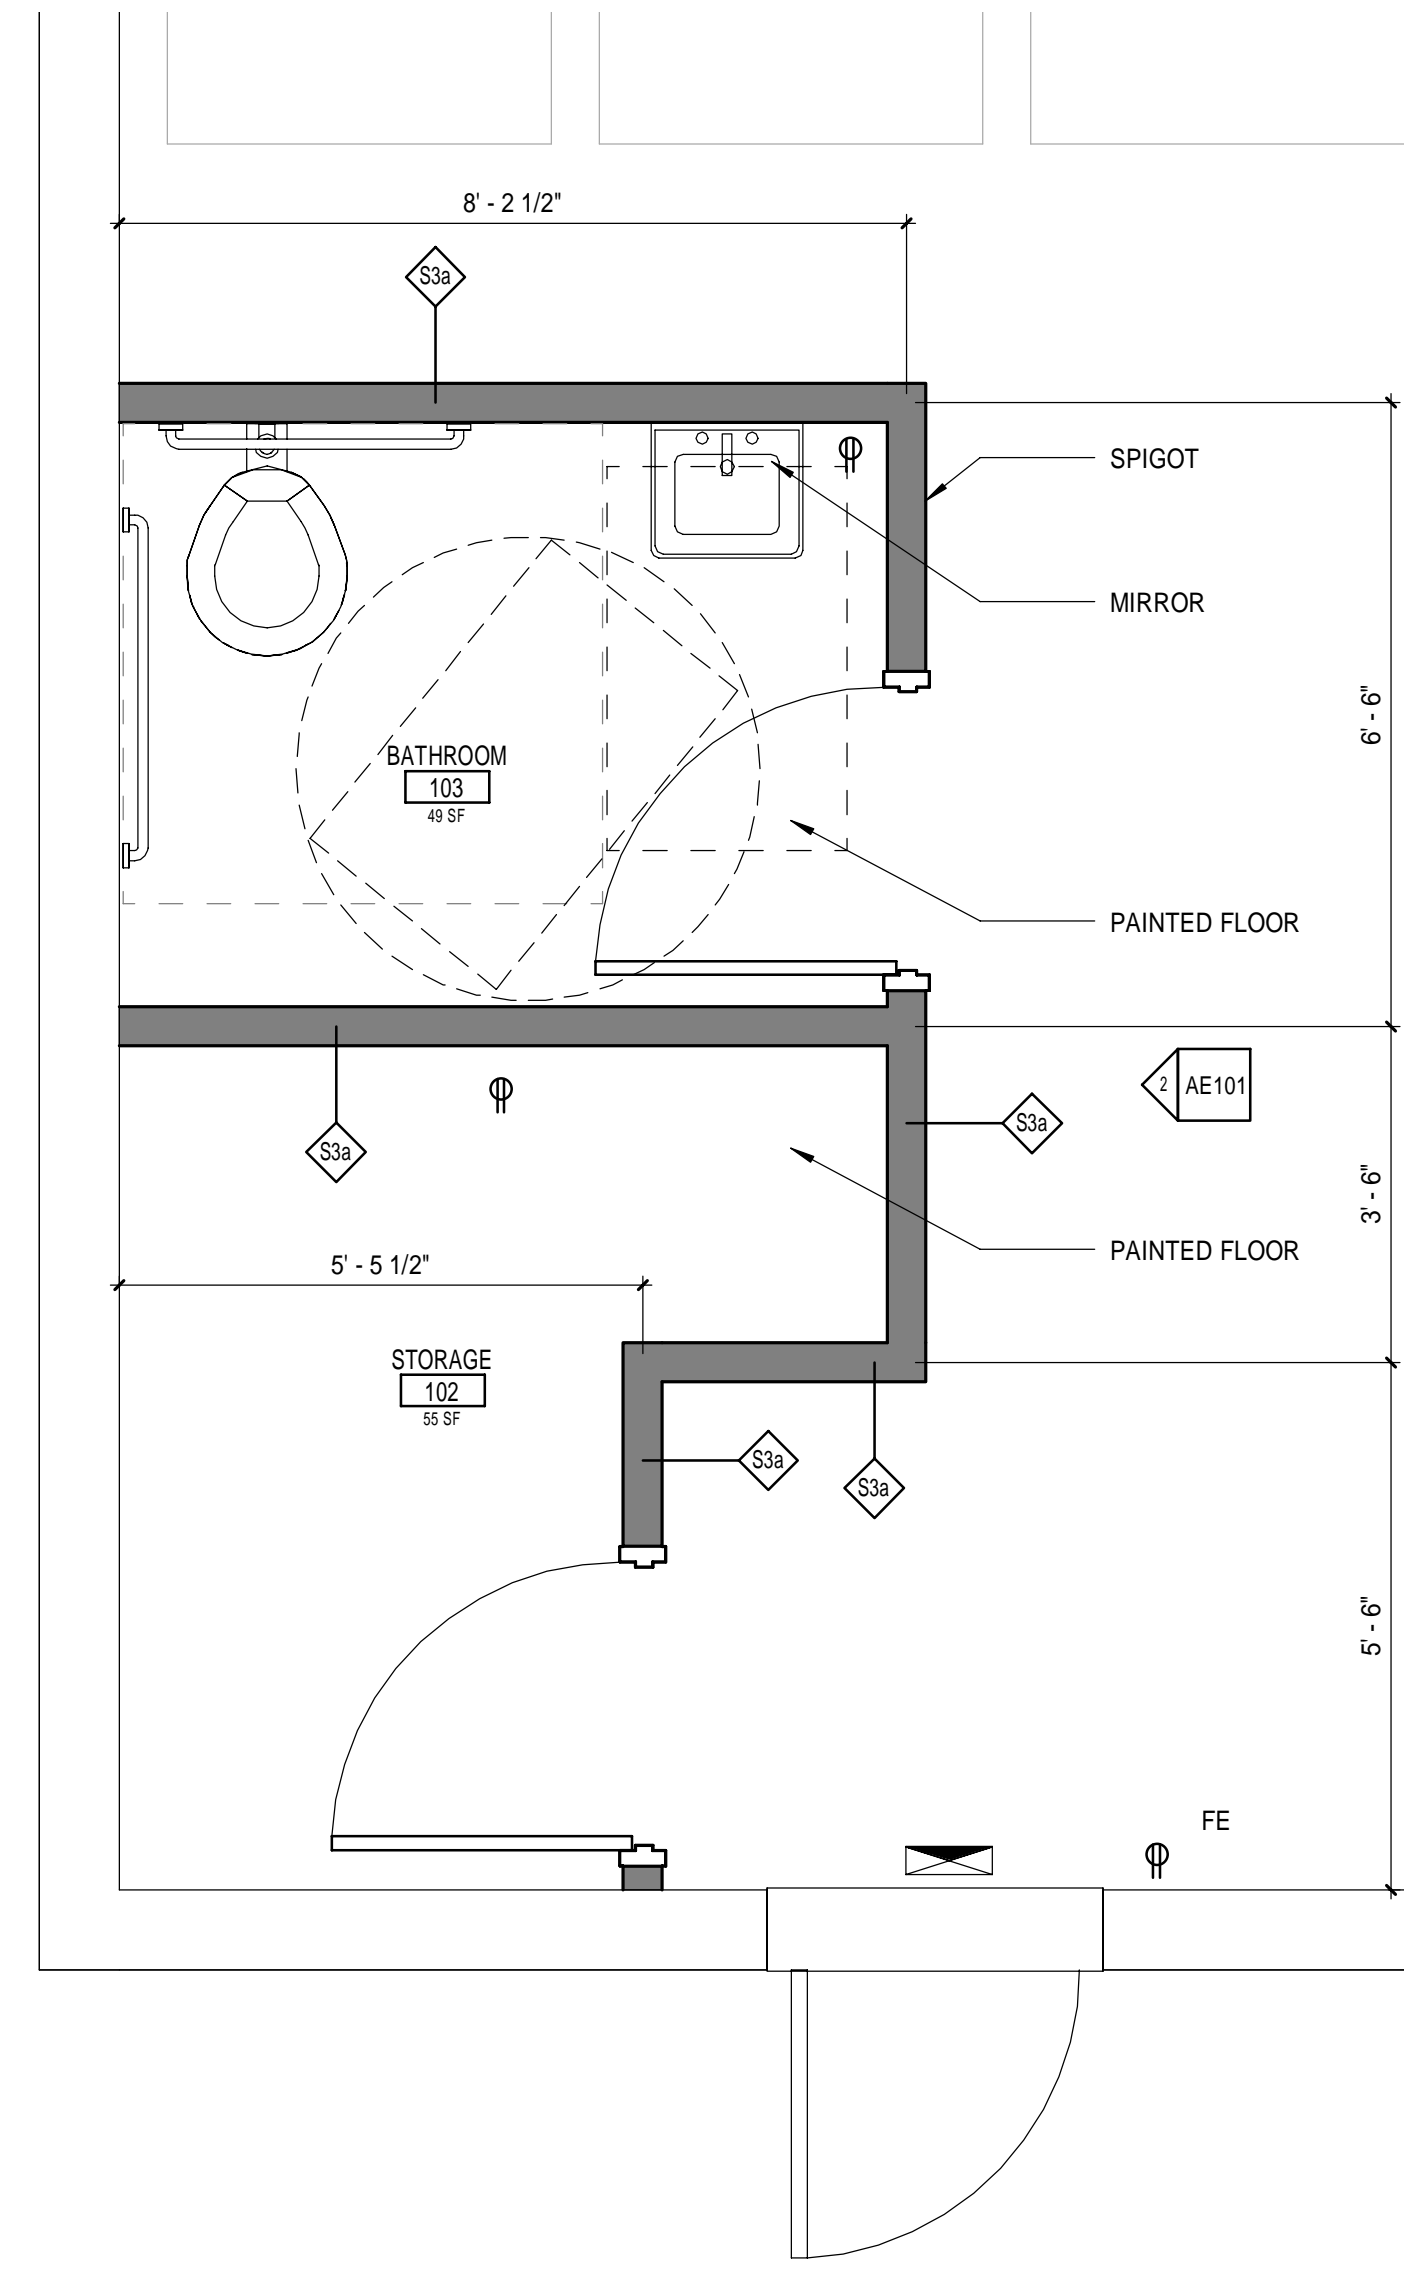

A1 ENLARGED PLAN @ BATHROOM

1/2" = 1'-0"

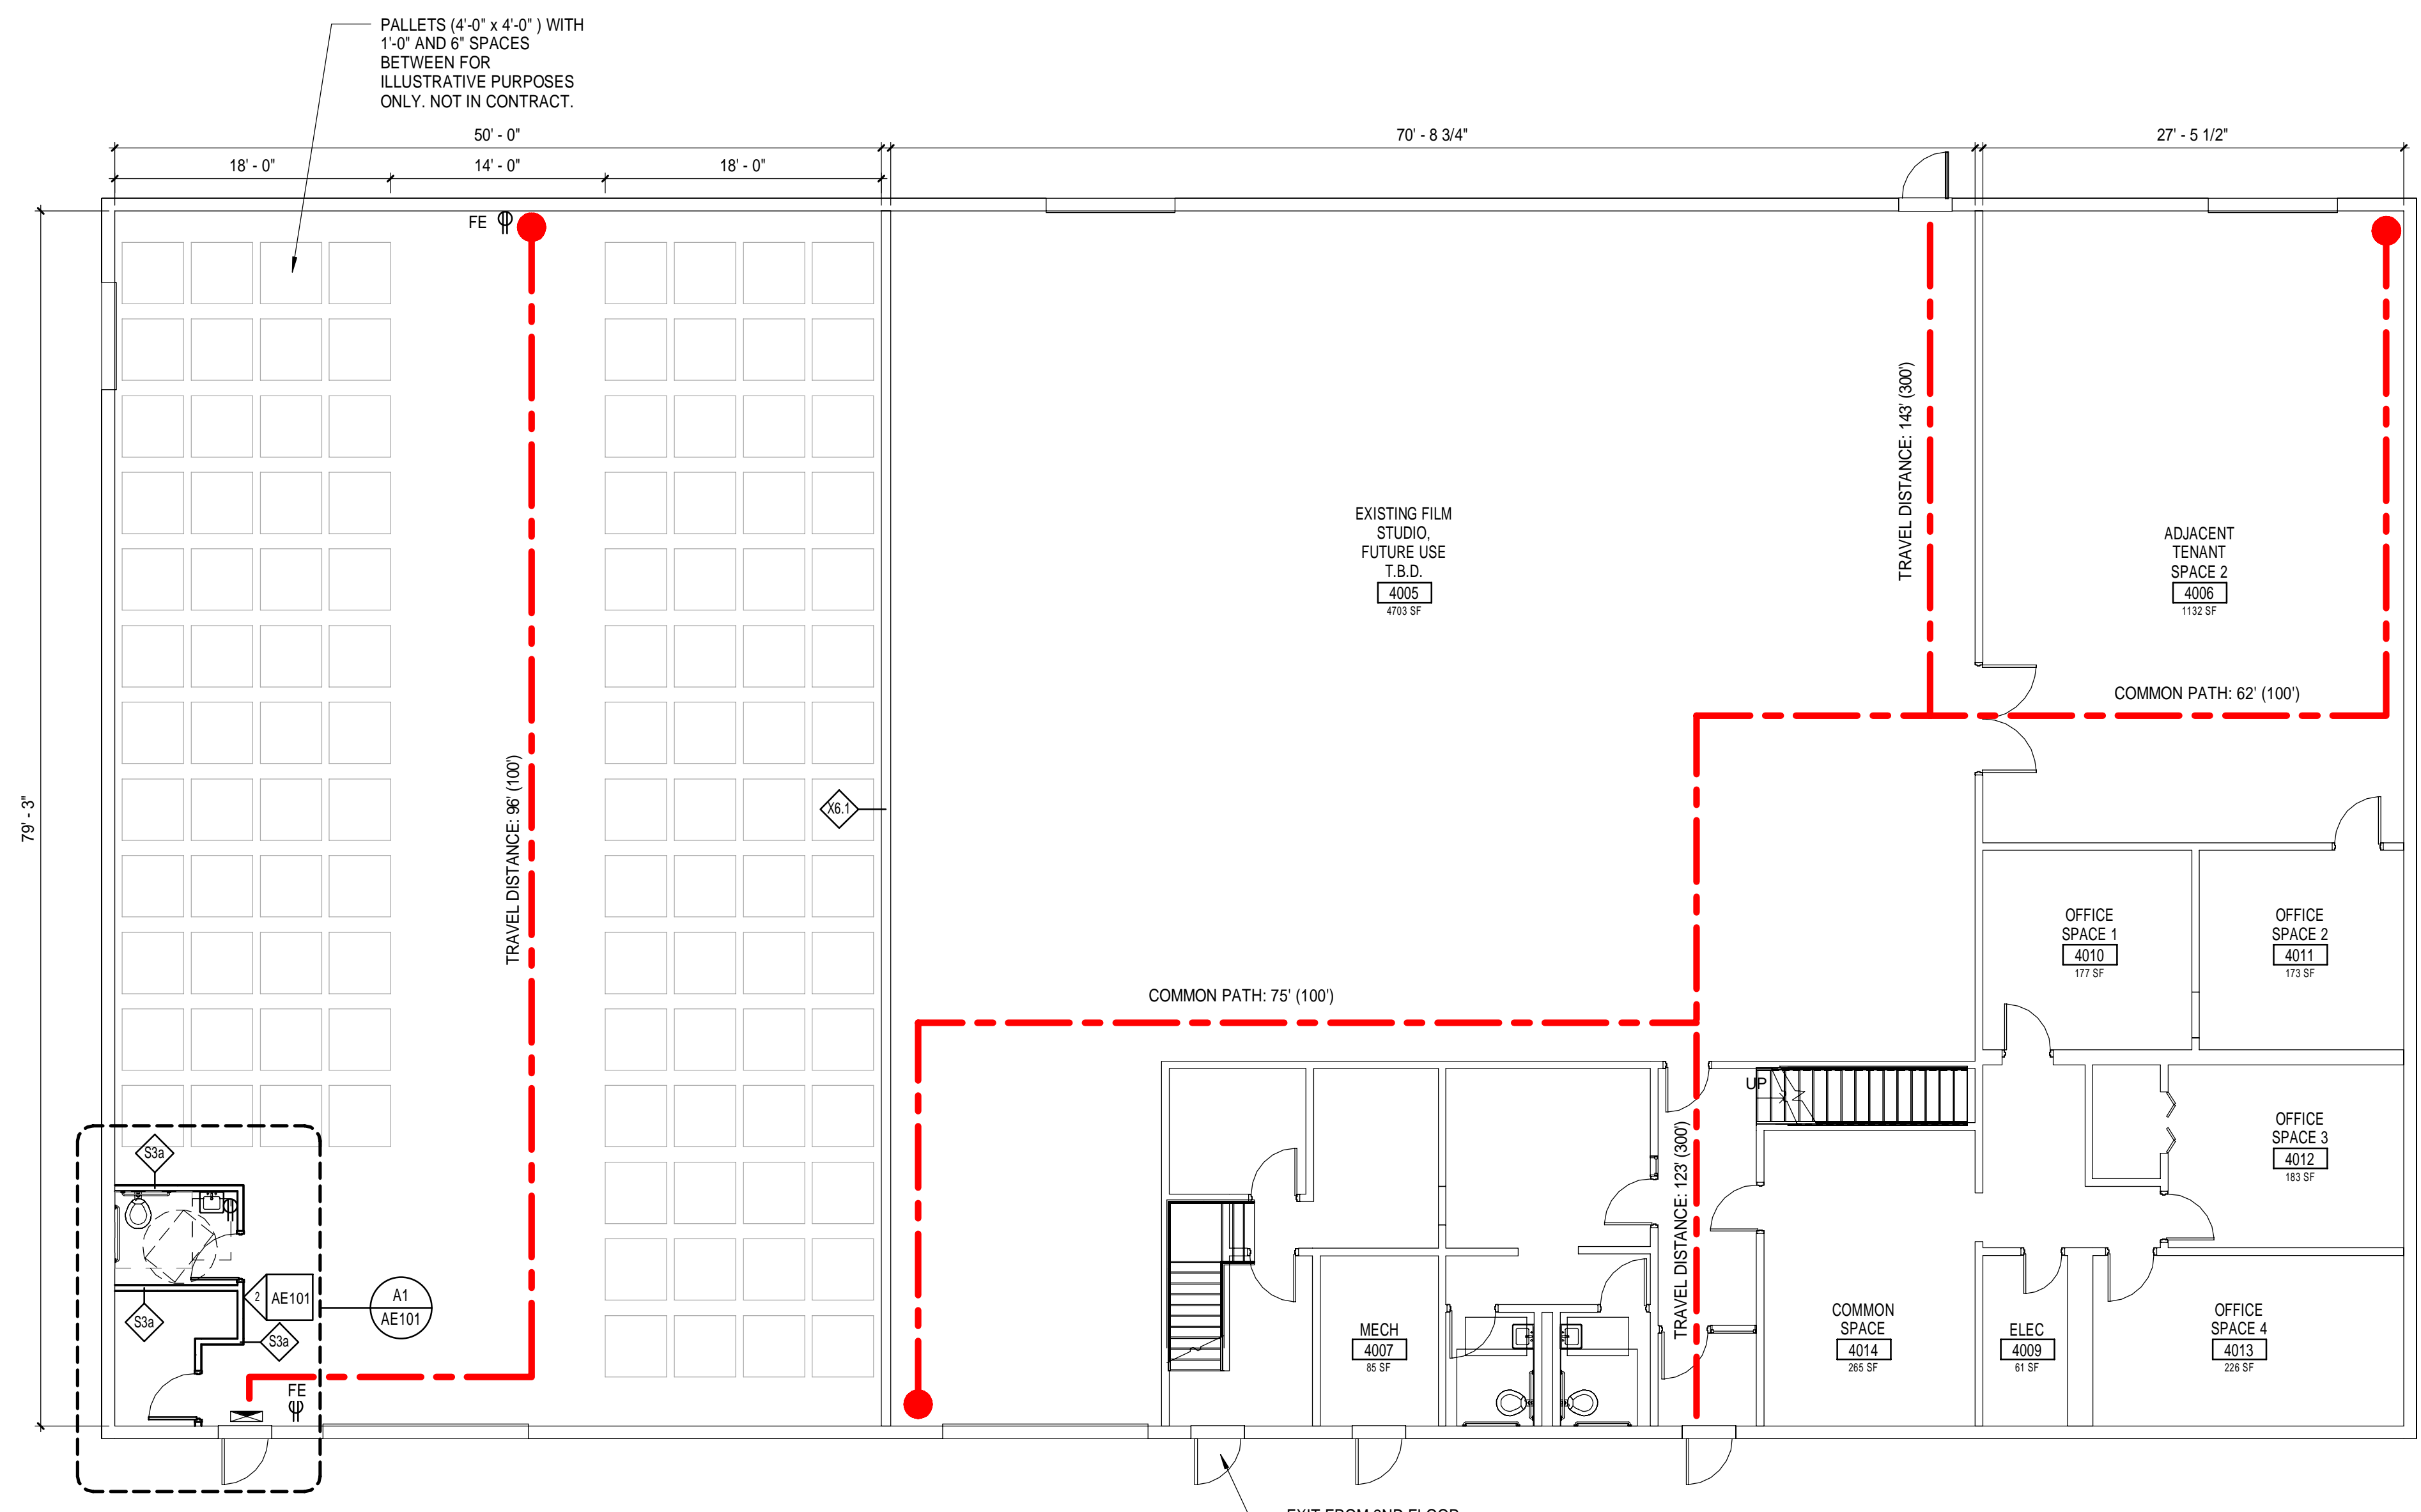

A5 FIRST FLOOR

1/8" = 1'-0"

235 PRESUMPCOT
235 PRESUMPCOT ST. PORTLAND, MAINE

ISSUED FOR CONSTRUCTION
2-24-16

CURRENT ISSUE STATUS:

REV	DESCRIPTION	DATE

GRAPHIC SCALE:
0' 1'

SCALE: As indicated
PROJECT MANAGER: JLH
JC/DRAWN BY: SHK
A/E OF RECORD: PSS
PROJECT NO: 15105
SMRT FILE: AE101-15105
DATE: 2-24-2016

SHEET TITLE:
FIRST FLOOR

SHEET No.
AE101