

**B.H. MILLIKEN - TENANT FIT-UP  
AT 235 PRESUMPCOT STREET, PORTLAND, ME 04101**

144 Foss Street P.O. Box 818  
Portland, Maine 04104  
tel. (207) 772-3846  
fax. (207) 772-1070  
www.smrtninc.com

ARCHITECTURE  
ENGINEERING  
PLANNING  
INTERIORS  
ENERGY



B.H. MILLIKEN TENANT FIT-UP

235 PRESUMPCOT STREET, PORTLAND, ME

PERMIT SET  
4-1-16

CURRENT ISSUE STATUS:

REV	DESCRIPTION	DATE

GRAPHIC SCALE:  
0" 1"


SCALE: As indicated  
PROJECT MANAGER: JLH  
JC/DRAWN BY: SHK  
A/E OF RECORD: JLH  
PROJECT NO: 16030  
SMRT FILE: G1001-16030  
DATE:

SHEET TITLE:  
**COVER SHEET,  
LEGEND AND  
ABBREVIATIONS**

SHEET No.  
**G1001**  
©COPYRIGHT 2014 SMRT INC

**ABBREVIATIONS:**

AB ANCHOR BOLT	L ANGLE / LENGTH
A/C AIR CONDITIONING	LF LEFT
ACCU AIR CONDITIONING CONDENSER UNIT	LINO SHEET LINOLEUM
ACPLAS ACCOUSTICAL PLASTER	LL LIVE LOAD
ACT ACOUSTIC CEILING TILE	LLH LONG LEG HORIZONTAL
AFF ABOVE FINISH FLOOR	LLV LONG LEG VERTICAL
AGG AGGREGATE	LP LIGHTING PANEL / LIQUIFIED PROPANE
ALT ALTERNATE	
AP ACCESS PANEL	MAX MAXIMUM
APROX APPROXIMATE	MB MARKER BOARD
ARCH ARCHITECTURAL	MDO MEDIUM DENSITY OVERLAY
	MECH MECHANICAL
BCX BOTTOM CORD EXTENSION	MFR MANUFACTURER
BD BOARD	MIN MINIMUM
BIT BITUMINOUS	MISC MISCELLANEOUS
BLDG BUILDING	MO MASONRY OPENING
BLP BORROWED LIGHT PANEL	MIR MOISTURE-RESISTANT
BO BOTTOM OF	MUA MAKE-UP AIR
BOF BOTTOM OF FOOTING	
BOS BOTTOM OF STEEL	N NOSING
BOT BOTTOM	NCB NEW CATCH BASIN
BRDG BRIDGING	NDMH NEW DRAIN MANHOLE
BRG BEARING	NFM NEW FORCE MAIN
BTS BOTH SIDES	NIC NOT IN CONTRACT
BSE BRICK SHELF ELEVATION	NS NEAR SIDE
	NSD NEW STORM DRAIN LINE
C CHANNEL	NSS NEW SANITARY SEWER LINE
CB CATCH BASIN / CHALKBOARD	NTS NOT TO SCALE
CEM BD CEMENTITIOUS BACKER BOARD	NW NEW WATER LINE
CFM CUBIC FEET PER MINUTE	
CIP CAST IN PLACE	OC ON CENTER
CJ CONTROL JOINT / CONSTRUCTION JOINT	OF OUTSIDE FACE
CL CENTER LINE	OH OVERHEAD
CLL CONTRACT LIMIT LINE	
CLR CLEAR	PA PUBLIC ADDRESS
CMU CONCRETE MASONRY UNIT	PAF POWER-ACTUATED FASTENER
COL COLUMN	PDU POOL DEHUMIDIFICATION UNIT
CONC CONCRETE	PL PLATE / PROPERTY LINE
CONT CONTINUOUS	PLAM PLASTIC LAMINATE
CT CERAMIC TILE	PLF POUNDS PER LINEAR FOOT
CUH CABINET UNIT HEATER	PP POWER PANEL
	PSF POUNDS PER SQUARE FOOT
D DIAMETER	PSI POUNDS PER SQUARE INCH
DBL DOUBLE	PT PRESSURE-TREATED
DF DRINKING FOUNTAIN	PVC POLYVINYL CHLORIDE
DL DEAD LOAD	PVMT PAVEMENT
DR DISPLAY RAIL	
DTL DETAIL	R RISER / RADIUS
DW DISHWASHER	RB RESILIENT BASE
DWG DRAWING	RD ROOF DRAIN
	REINF REINFORCED
EA EACH	REQD REQUIRED
EF EXHAUST FAN / EACH FACE	RT RIGHT
EJ EXPANSION JOINT	RO ROUGH OPENING
EL ELEVATION	ROW RIGHT OF WAY
ELEC ELECTRICAL	RR RUB-RAIL
EOP EDGE OF PAVEMENT	RTU ROOF TOP UNIT (HVAC)
EPDM ETHYLENE PROPYLENE DIENE MONOMER	
EQ EQUAL	SACT SUSPENDED ACOUSTIC TILE CEILING
EW EACH WAY	SC SOLID CORE
EWC ELECTRIC WATER COOLER	SF SQUARE FOOT / SUPPLY FAN
EXIST EXISTING	SFRM SPRAYED FIRE-RESISTIVE MATERIAL
EXP EXPANSION	SHT SHEET
EXT EXTERIOR	SIM SIMILAR
	SK SKR KEY
FB FLAT BAR	SN SANITARY NAPKIN (DISPENSER)
FBO FURNISHED BY OTHERS	SP SPECIAL
FCO FLOOR CLEA-OUT	SS STAINLESS STEEL
FD FLOOR DRAIN	STA STATION
FE FIRE EXTINGUISHER	STL STEEL
FEC FIRE EXTINGUISHER CABINET	STRUC STRUCTURAL
FF FINISH FLOOR / FAR FACE	
FFO FINISH FLOOR ELEVATION	T TREAD
FRP FRAMED OPENING	TB TACKBOARD
FRP FIBER REINFORCED PLASTIC	T&B TOP AND BOTTOM
FS FAR SIDE	TBM TEMPORARY BENCHMARK
FTG FOOTING	TCE TOP CHORD EXTENSION
	TJ TIE JOIST
GA GAUGE	TO TOP OF
GALV GALVANIZED	TOC TOP OF CONCRETE
GB GRAB BAR	TOF TOP OF FOOTING
GC GENERAL CONTRACTOR	TOM TOP OF MASONRY
GDT GYPSUM DROP-IN TILE	TOP TOP OF PIER
GV GRAVITY VENT	TOS TOP OF STEEL
GWB GYPSUM WALL BOARD	TOW TOP OF WALL
	TP TOILET PAPER (DISPENSER) / TEST PIT
H HORIZONTAL	TS TUBE STEEL
HC HORIZONTAL	TYP TYPICAL
HORIZ HORIZONTAL	
HM HOLLOW METAL	UH UNIT HEATER
HRU HEAT RECOVERY UNIT	UNO UNLESS NOTED OTHERWISE
H&V HEATING AND VENTILATING	
HVAC HEATING, VENTILATING AND AIR CONDITIONING	V VENT PIPE / VERTICAL
	VB VAPOR BARRIER
I INCLUDED ANGLE	VCT VINYL COMPOSITION TILE
ID INSIDE DIAMETER	VERT VERTICAL
IF INSIDE FACE	VP VISION PANEL
IJ ISOLATION JOINT	VTR VENT THROUGH THE ROOF
IMP IMPACT RESISTANT	
INS INSULATED	W/ WITH
INV INVERT	WC WATER CLOSET
	WD WOOD
JS JOINT SUBSTITUTE	WF WIDE FLANGE
K KIPS	WH WATER HEATER
	W/O WITH OUT
	WP WORKING POINT
	WS WEB STIFFENER
	WWF WELDED WIRE FABRIC

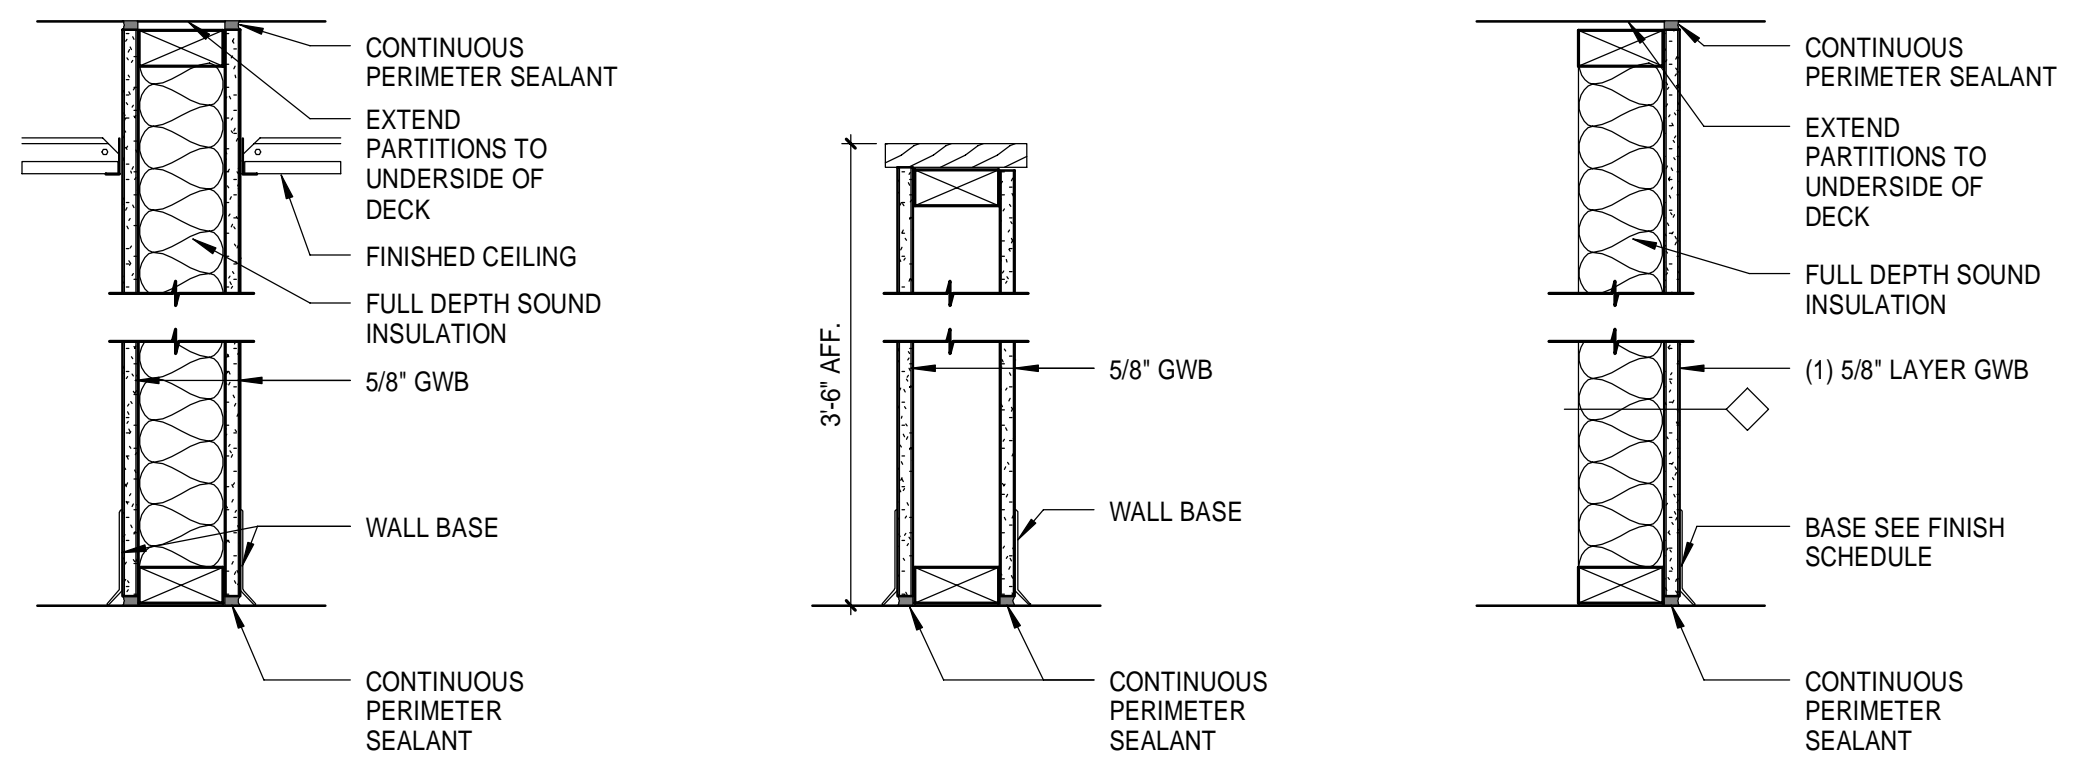


**TYPE W4 NON-RATED**  
ONE LAYER 5/8" GWB EACH SIDE OF 2"x4" NOMINAL WOOD STUDS.

**TYPE P4 NON-RATED**  
ONE LAYER 5/8" GWB EACH SIDE OF 2"x4" NOMINAL WOOD STUDS.

**TYPE F4 NON-RATED**  
ONE LAYER 5/8" GWB ON TAGGED SIZE 2"x4" NOMINAL WOOD FURRING STUDS.

**TYPE E**  
INFILL/PATCH WALL TO MATCH EXISTING ADJACENT CONSTRUCTION

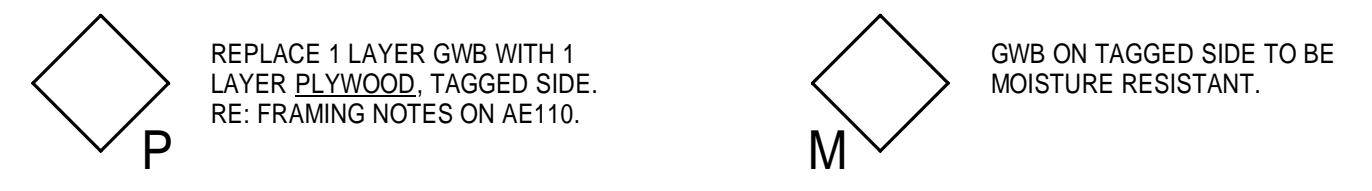

**F5 PARTITION TYPES**  
1/12" = 1'-0"

**SYMBOL LEGEND:**

	BUILDING SECTION
	WALL SECTION
	DETAIL
	EXTERIOR ELEVATION
	INTERIOR ELEVATION
	LEVEL LINE
	KEY NOTE
	EQUIPMENT/ACCESSORY TAG
	WINDOW TAG
	PARTITION TAG
	DOOR TAG
	ROOM NAME ROOM NUMBER
	COLUMN BUBBLE AND CENTER LINE
	BACKER ROD AND SEALANT
	WALL MOUNTED EXIT SIGN

**DRAWING LIST:**

**GENERAL**

G1001 COVER SHEET, LEGEND AND ABBREVIATIONS

**ARCHITECTURAL**

A-001 CODE COMPLIANCE PLAN

AD100 DEMOLITION PLAN

AE100 FLOOR PLANS

AE110 LAYOUT & FRAMING PLANS

AE201 EXT. ELEVS, SCHEDULES, & DETAILS

**INTERIORS**

ID100 FLOOR FINISH PLAN

**PLUMBING**

PL001 PLUMBING LEGEND AND ABBREVIATIONS

PL100 LEVEL 1 PLUMBING PLAN

PL501 PLUMBING DETAILS & SCHEDULE

**LOCATION MAP:**

