

WALL LEGEND	
	EXISTING WALL
	NEW WALL


 Reviewed for Code Compliance
 Permitting and Inspections Department
 Approved with Conditions
 05/20/2020

REGISTERED ARCHITECT
 RYAN J. SENATORE
 No. 3372
 STATE OF MAINE
 © 2019 RYAN SENATORE ARCHITECTURE

LEGEND

- PULL STATION
- HORN STROBE
- FIRE ALARM PANEL
- E = Existing
- REMOTE ANNUNCIATOR
- KNOX BOX



ADDITION TO LIFE STORAGE
 235 PRESUMPCOT STREET
 PORTLAND, MAINE

RSA
 RYAN SENATORE ARCHITECTURE
 500 CONGRESS STREET
 PORTLAND, MAINE 04111
 207-555-6414
 rsasentorearchitecture.com

CONSULTANTS:

REVISIONS:

DATE: MARCH 20, 2019

PROJECT No. 1866

DRAWN BY: JPF

 
 
CHECKED BY: RJS

SCALE: AS NOTED

SHEET TITLE:
FIRST FLOOR PLAN

1 FIRST FLOOR PLAN
1/8" = 1'-0"

A1-0

 

WALL LEGEND	
	EXISTING WALL
	NEW WALL



Reviewed for Code Compliance
 Permitting and Inspections Department
 Approved with Conditions
 05/20/2020



© 2019 RYAN SENATORE ARCHITECTURE

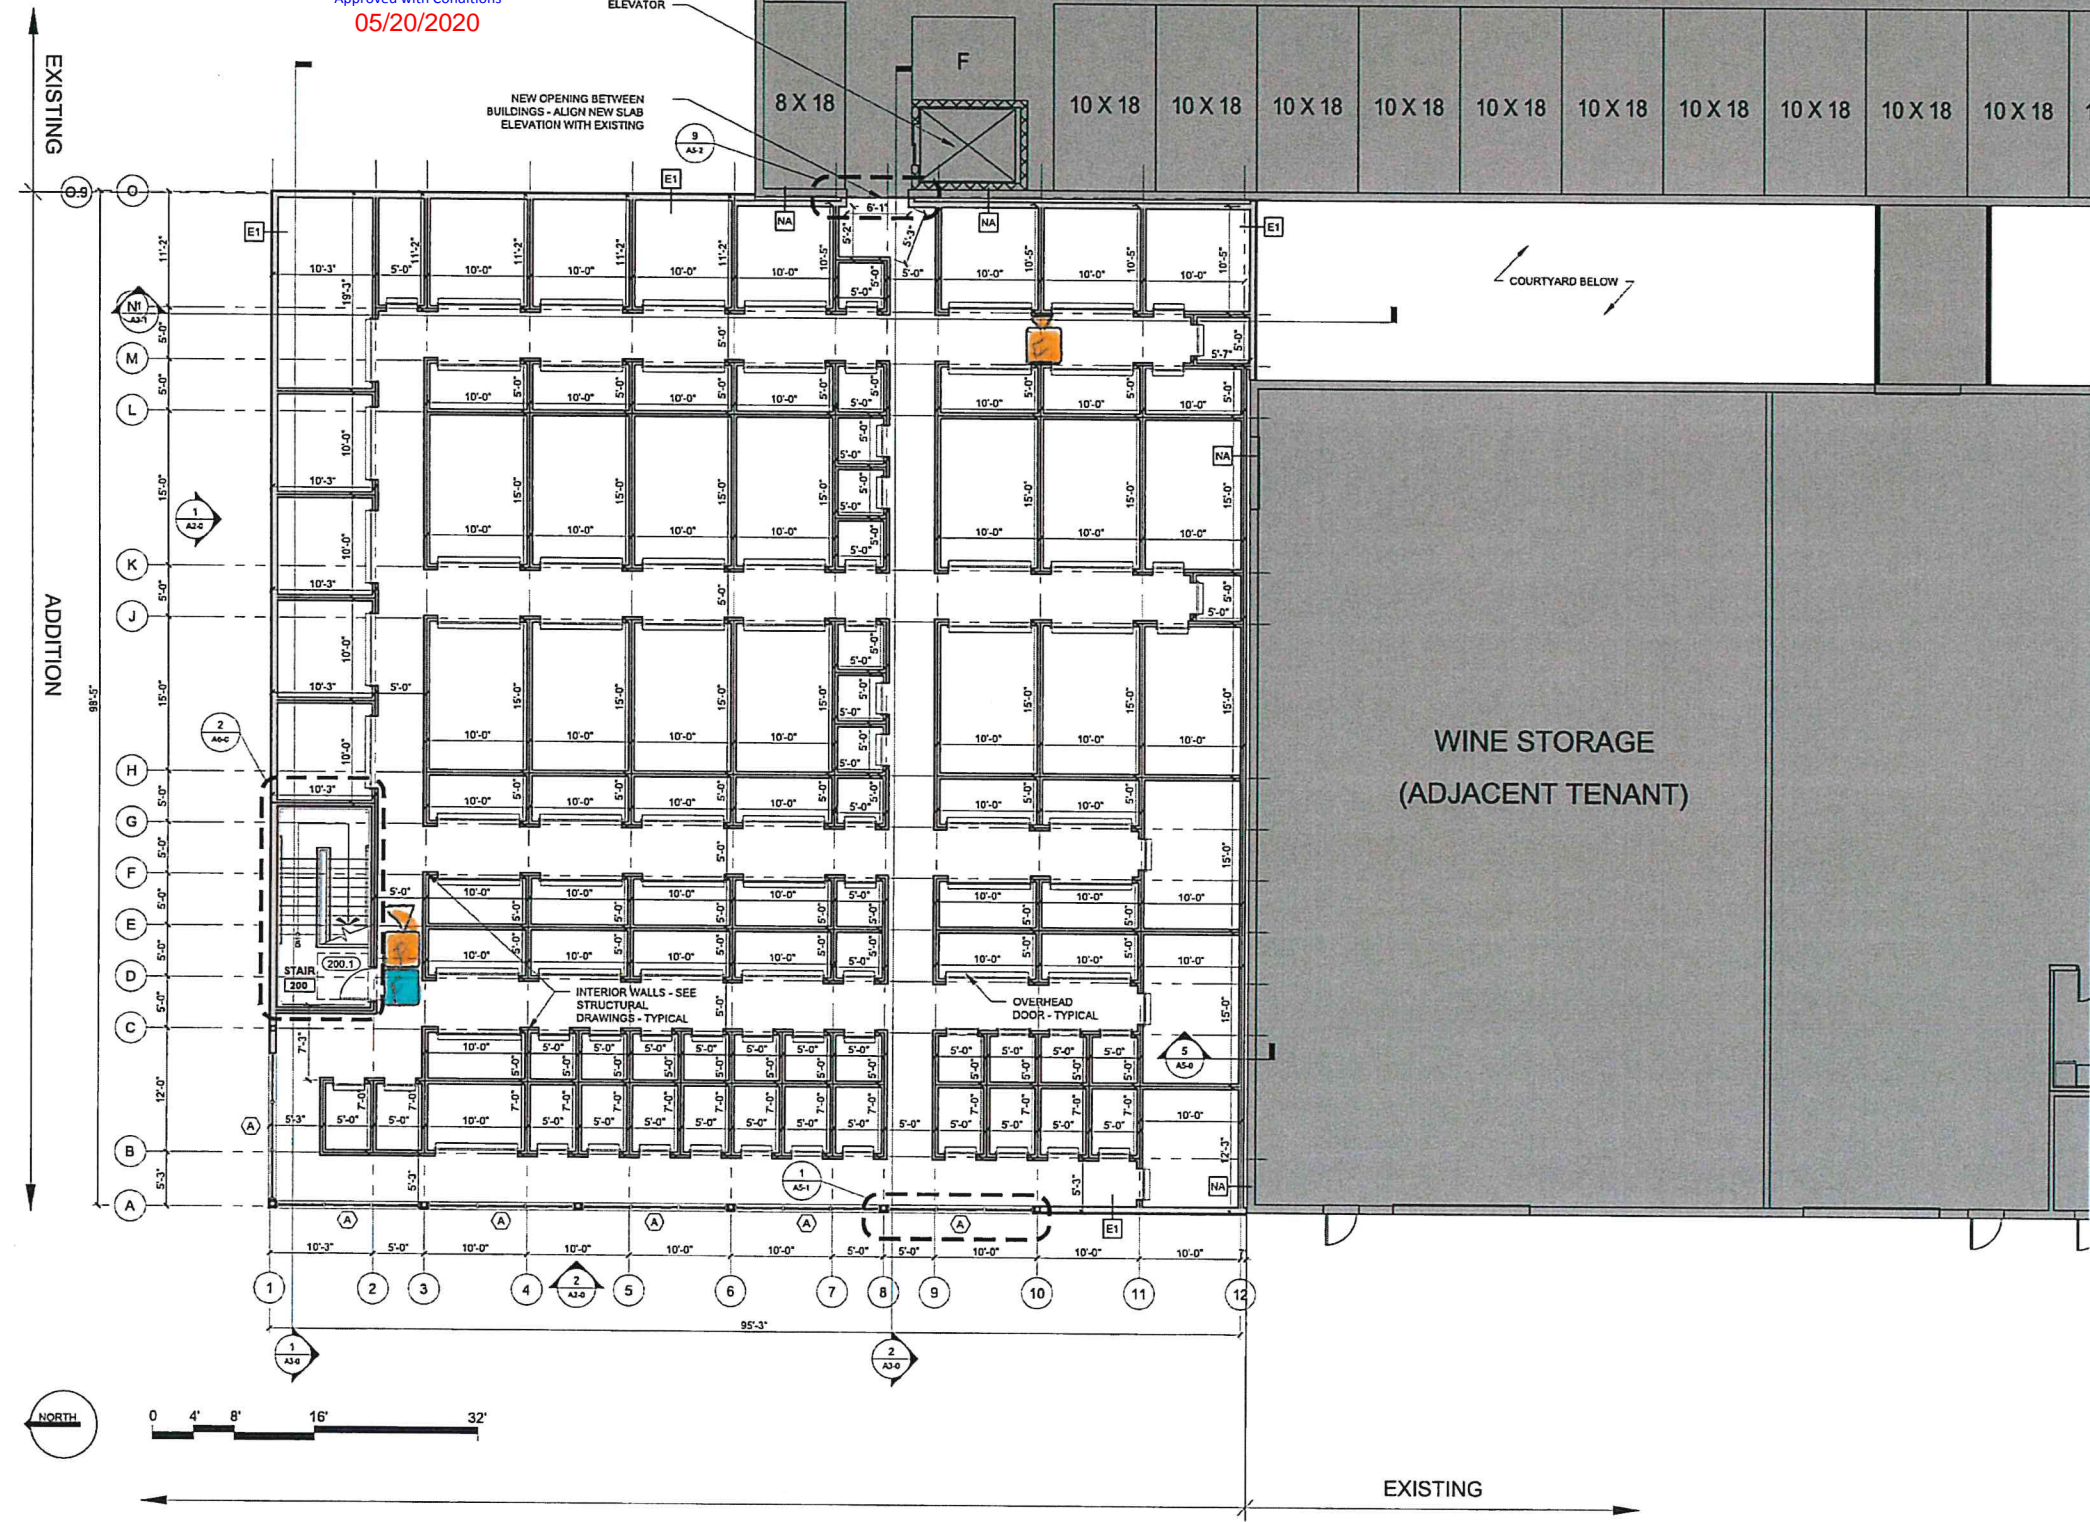

ADDITION TO LIFE STORAGE
 235 PRESUMPCOT STREET
 PORTLAND, MAINE



CONSULTANTS:

REVISIONS:

DATE: MARCH 20, 2019
 PROJECT No.: 1666
 DRAWN BY: JPF
 CHECKED BY: RJS
 SCALE: AS NOTED
 SHEET TITLE:
 SECOND FLOOR PLAN

1 SECOND FLOOR PLAN
 1/8" = 1'-0"

A1-1