
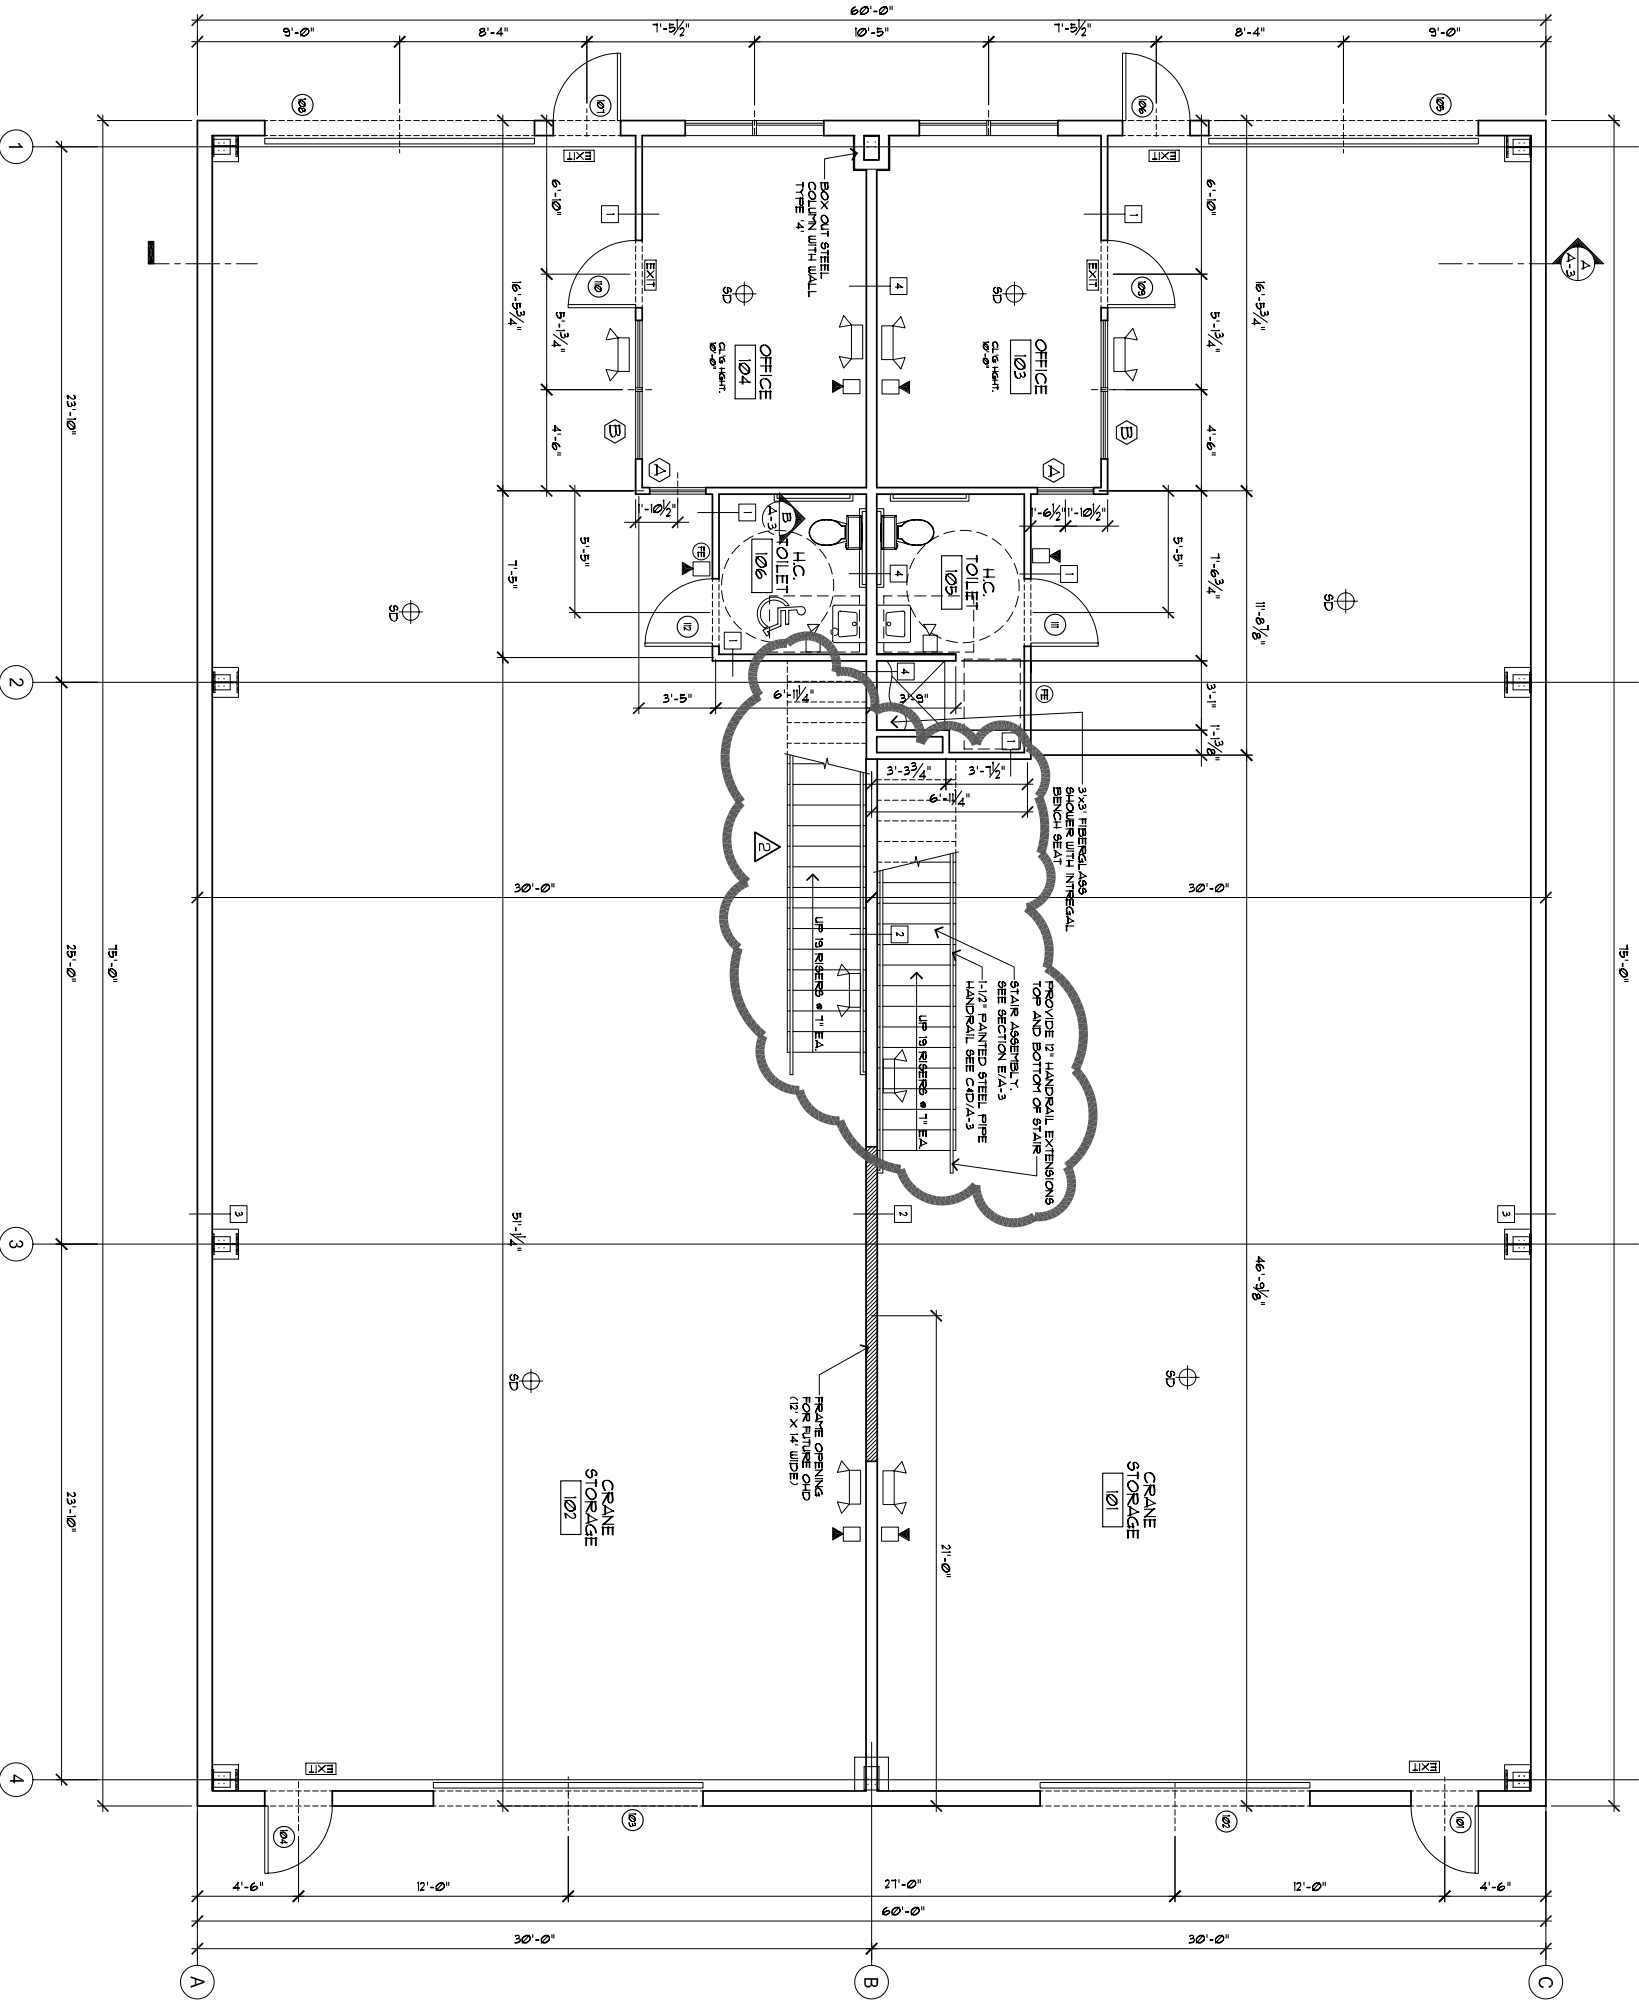


LIFE SAFETY LEGEND	
	EMERGENCY BACKUP LIGHT
	EXIT LIGHT
	SMOKE DETECTOR
	HEAT DETECTOR
	HORN/STROBE
	STROBE
	FIRE EXTINGUISHER

- NOTES:
1. USE GROUP 6-1 & B
 2. THE PROPOSED BUILDING IS DESIGNED AS: CONSTRUCTION TYPE IIB
 3. MECHANICAL SYSTEMS SHALL BE DESIGNED BY A LICENSED ENGINEER IN THE STATE OF MAINE
 4. ELECTRICAL SYSTEM SHALL BE DESIGNED BY A LICENSED ENGINEER IN THE STATE OF MAINE
 5. FIRE ALARM SHALL MEET NFPA 72 AND SHALL MEET THE MOST RESTRICTIVE REQUIREMENTS FOR USE GROUP B AND S-1
 6. METAL BUILDING MANUFACTURER: OKLAHOMA CITY, OKLAHOMA

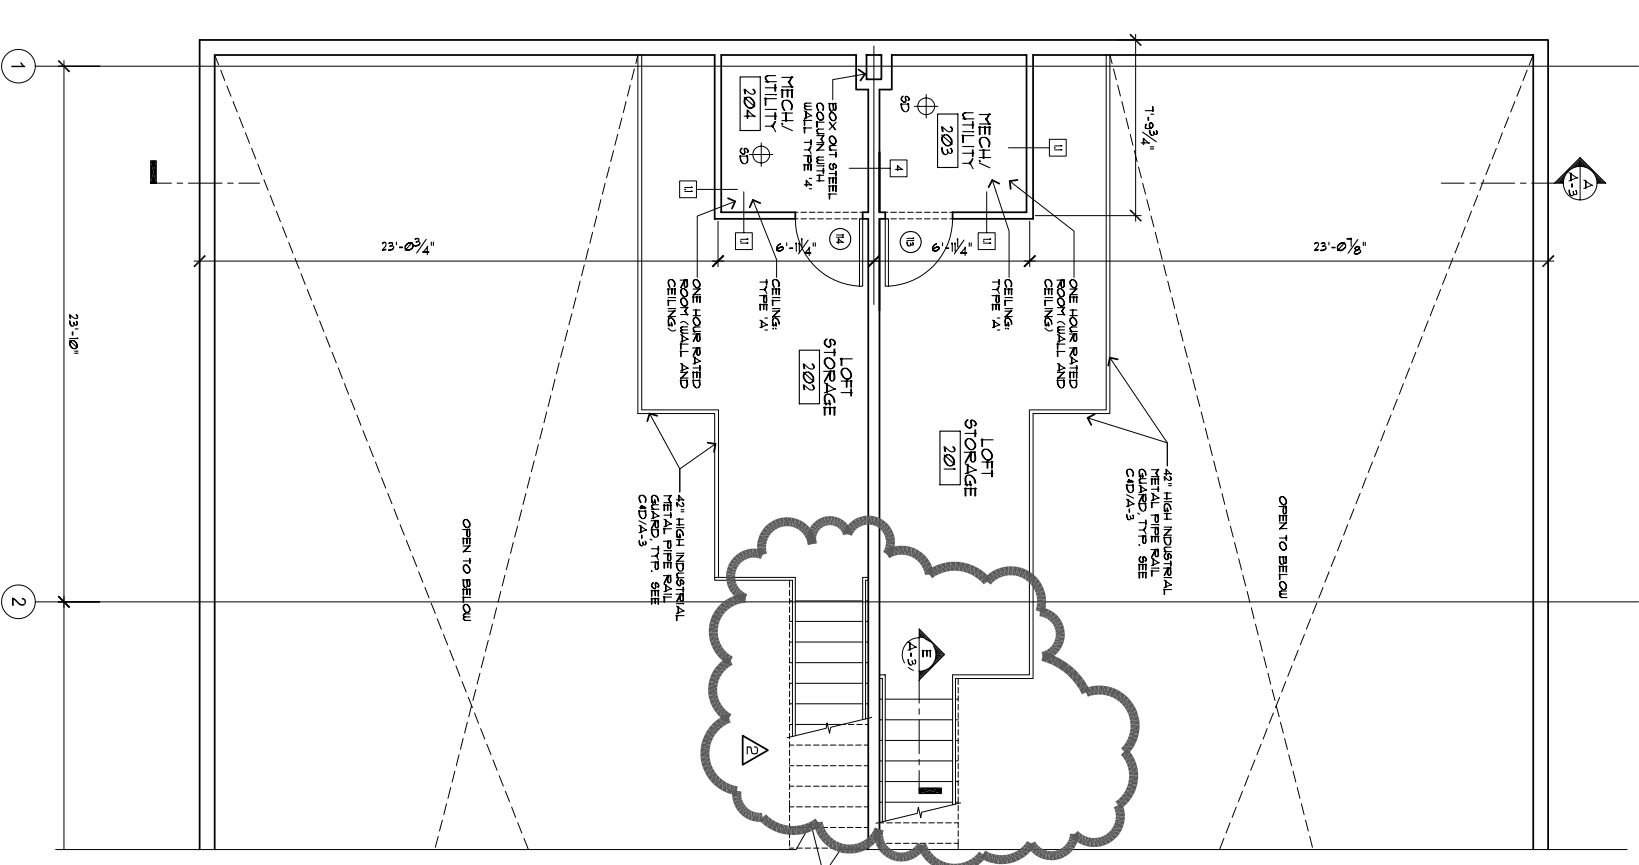

M A R K MUELLER ARCHITECTS
A.I.A.

100 Commercial Street
Portland, Maine 04101
Phone 503.774.9857
Fax 503.774.9858
Email: mark@markmullerarchitects.com
Web: www.markmullerarchitects.com

© 2017 M A R K MUELLER ARCHITECTS

HARKIN / QUALITY CRANE
31 BATES ROAD
PORTLAND, MAINE

FLOOR PLANS

DATE	REVISION
05/11/2016	1 - INITIAL
05/11/2016	2 - REVISION

PROJECT: QUALITY CRANE
DRAWN BY: FGA
CHECKED BY: MAM

