

# PACK EDGE

## 352 PRESUMPCOTT ST.

### PORTLAND, ME 04103

#### DESIGN PROFESSIONALS

##### CIVIL ENGINEER

SHAWN H. FRANK, P.E.  
SEBAGO TECHNICS  
ONE CHABOT STREET  
WESTBROOK, ME 04098-1394  
207-856-0277

##### ARCHITECTURAL

JOHN EINSIEDLER, R.A.  
148 SEA RD.  
KENNEBUNK, ME 04043  
207-985-9760

##### STRUCTURAL ENGINEER

STEVE GRANT, P.E.  
SRG ENGINEERING  
PO BOX 426  
GRANT, ME 04039  
207-657-7523

##### STRUCTURAL ENGINEER (METAL BUILDING)

CARL WALKER, P.E.  
VP BUILDINGS  
273 WATER ST.  
EVANVILLE, MI 49836  
608-882-5000

##### MECHANICAL ENGINEER


ARTHUR STROTSBERG, P.E.  
MEP ENGINEERING  
HARPSWELL, ME 04079  
207-833-2921

##### SPRINKLER SYSTEM

STAN CANNIC,  
RESIDENTIAL FIRE PROTECTION  
64 DAGGETT HILL RD.  
GREENE, ME 04236

##### ELECTRICAL ENGINEER

HAROLD THOMAS  
THOMAS ENGINEERING  
175 CARLSON ST  
WESTBROOK, ME 04092  
207-878-4407

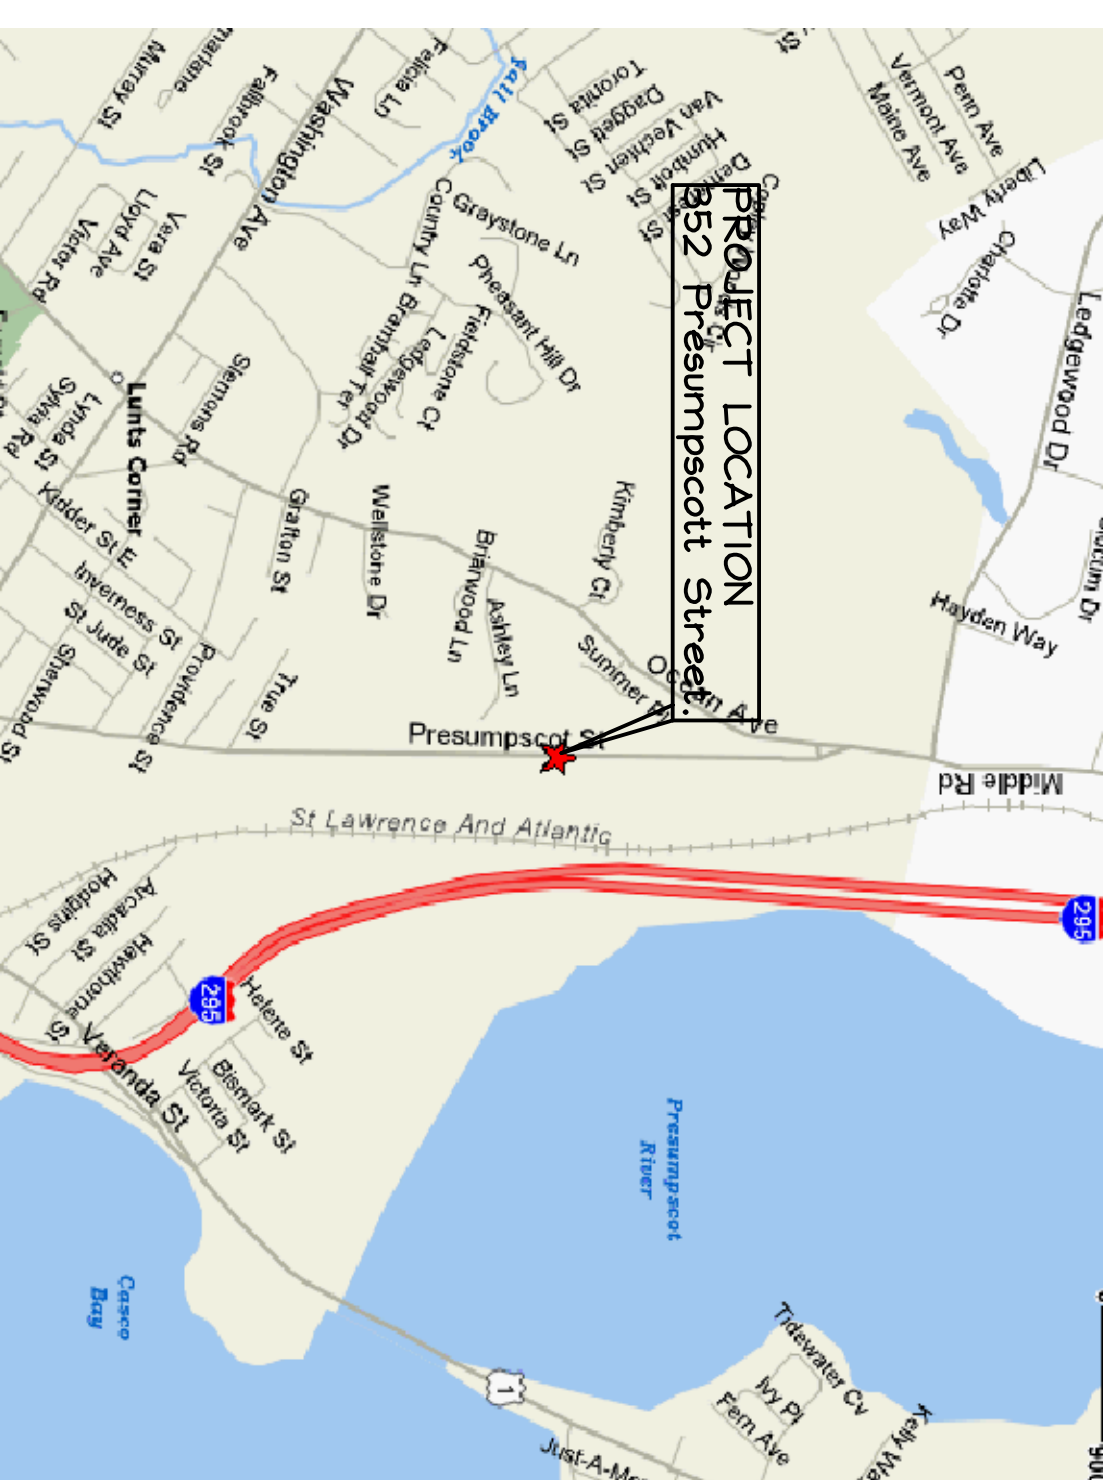

GEOGRAPHICAL LOCATION

#### INDEX

##### SITE PLANS

- SHEET 1 COVER
- SHEET 2 GENERAL NOTES & LEGEND
- SHEET 3 EXISTING CONDITIONS
- SHEET 4 SITE LAYOUT
- SHEET 5 GRADING, DRAINAGE, & EROSION
- SHEET 6 UTILITY
- SHEET 7 SITE DETAILS
- SHEET 8 UTILITY DETAILS
- SHEET 9 UTILITY DETAILS CONTINUED
- SHEET 10 EROSION CONTROL DETAILS
- SHEET 11 EROSION CONTROL NOTES

##### ARCHITECTURAL PLANS

- A1 FLOOR PLAN
- A2 ELEVATIONS
- A3 ADA DETAILS
- A4 BUILDING CROSS SECTIONS
- A5 WALL CROSS SECTIONS/SCHEDULES
- A6 ROOF PLAN

##### FOUNDATION PLANS

- S1 FOUNDATION PLAN & DETAIL
- S2 FOUNDATION DETAIL & SECTION
- S3 REINFORCING DETAIL

##### STRUCTURAL PLANS

- VP1 COVER
- VP2 ERECTION NOTES
- VP3 ANCHOR BOLT PLAN
- VP4 ANCHOR BOLT PLAN DETAILS
- VP5 PRIMARY & ROOF BRACING PLAN
- VP6 FRAME CROSS SECTION LINE 1
- VP7 FRAME CROSS SECTION LINE 2
- VP8 FRAME CROSS SECTION LINE 3
- VP9 FRAME CROSS SECTION LINE 4
- VP10 FRAME CROSS SECTION LINE 5
- VP11 FRAME CROSS SECTION LINE 6
- VP12 PORTAL FRAME ELEVATIONS
- VP13 ROOF SECONDARY PLAN
- VP14 SECONDARY ELEVATION A
- VP15 SECONDARY ELEVATION M
- VP16 SECONDARY ELEVATION I
- VP17 SECONDARY ELEVATION 6
- VP18 ROOF COVERING PLAN
- VP19 COVERING ELEVATION AT A
- VP20 COVERING ELEVATION AT M
- VP21 COVERING ELEVATION AT I
- VP22 COVERING ELEVATION AT 5
- VP23 COVERING ELEVATION AT 6

##### MECHANICAL PLANS

- P1 PLUMBING PLAN
- P2 PLUMBING DETAIL
- M1 MECHANICAL PLAN
- M2 MECHANICAL DETAIL

##### SPRINKLER PLANS

- SP1 SPRINKLER PLAN
- SP2 SPRINKLER DETAIL

##### ELECTRICAL PLANS

- E1 POWER PLAN
- E2 LIGHTING PLAN
- E3 DETAIL & SCHEDULE

| REV. | DESCRIPTION | DATE | BY |
|------|-------------|------|----|
|      |             |      |    |
|      |             |      |    |
|      |             |      |    |
|      |             |      |    |
|      |             |      |    |
|      |             |      |    |
|      |             |      |    |

**John W. Einsiedler, R.A.**  
Architecture  
148 Sea Road Kennebunk, Maine 04043  
Phone 207-985-9760 Facsimile 207-985-9818  
Internet: www.johnw-einsiedler.com e-mail: john@jweinc.com  
Architecture • Interior Design • Universal Design

**PATCO**  
CONSTRUCTION INC  
1293 MAIN STREET SANFORD, ME 04073  
TEL: (207)324-5574 FAX: (207)324-1643  
www.patco-construction.com  
Copyright © 2004 Patco Construction, Inc. All Rights Reserved.

PROPOSED BUILDING FOR:  
**PACK EDGE**  
352 PRESUMPCOTT STREET  
PORTLAND, ME  
**COVER SHEET**

|            |          |
|------------|----------|
| DATE       | 11/23/06 |
| SCALE      | AS SHOWN |
| DRAWN BY   | ANNY/JLG |
| CHECKED BY | MGR      |
| JOB NUMBER | 2705     |
| SHEET      |          |

C-1