

BISKUP CONSTRUCTION, INC.
 16 DANIELLE DRIVE
 WINDHAM, MAINE 04062
 TEL. (207) 892-9800
 FAX. (207) 892-9895

WWW.BISKUPCONSTRUCTION.COM

STAMP

PROJECT:
 CONCEPT PLAN
 CASCO BAY ELECTRIC
 316 PRESUMPCOTT STREET
 PORTLAND, MAINE

REVISIONS

DATE	DESCRIPTION

DATE: 11/15/2011
 SCALE: 3/16" = 1'-0"
 DESIGNER: JB
 CHECKED BY: JB

© COPYRIGHT
 BISKUP CONSTRUCTION, INC.


SHEET TITLE

FLOOR PLAN


SHEET NUMBER

A-1

SHEET 1 OF 2

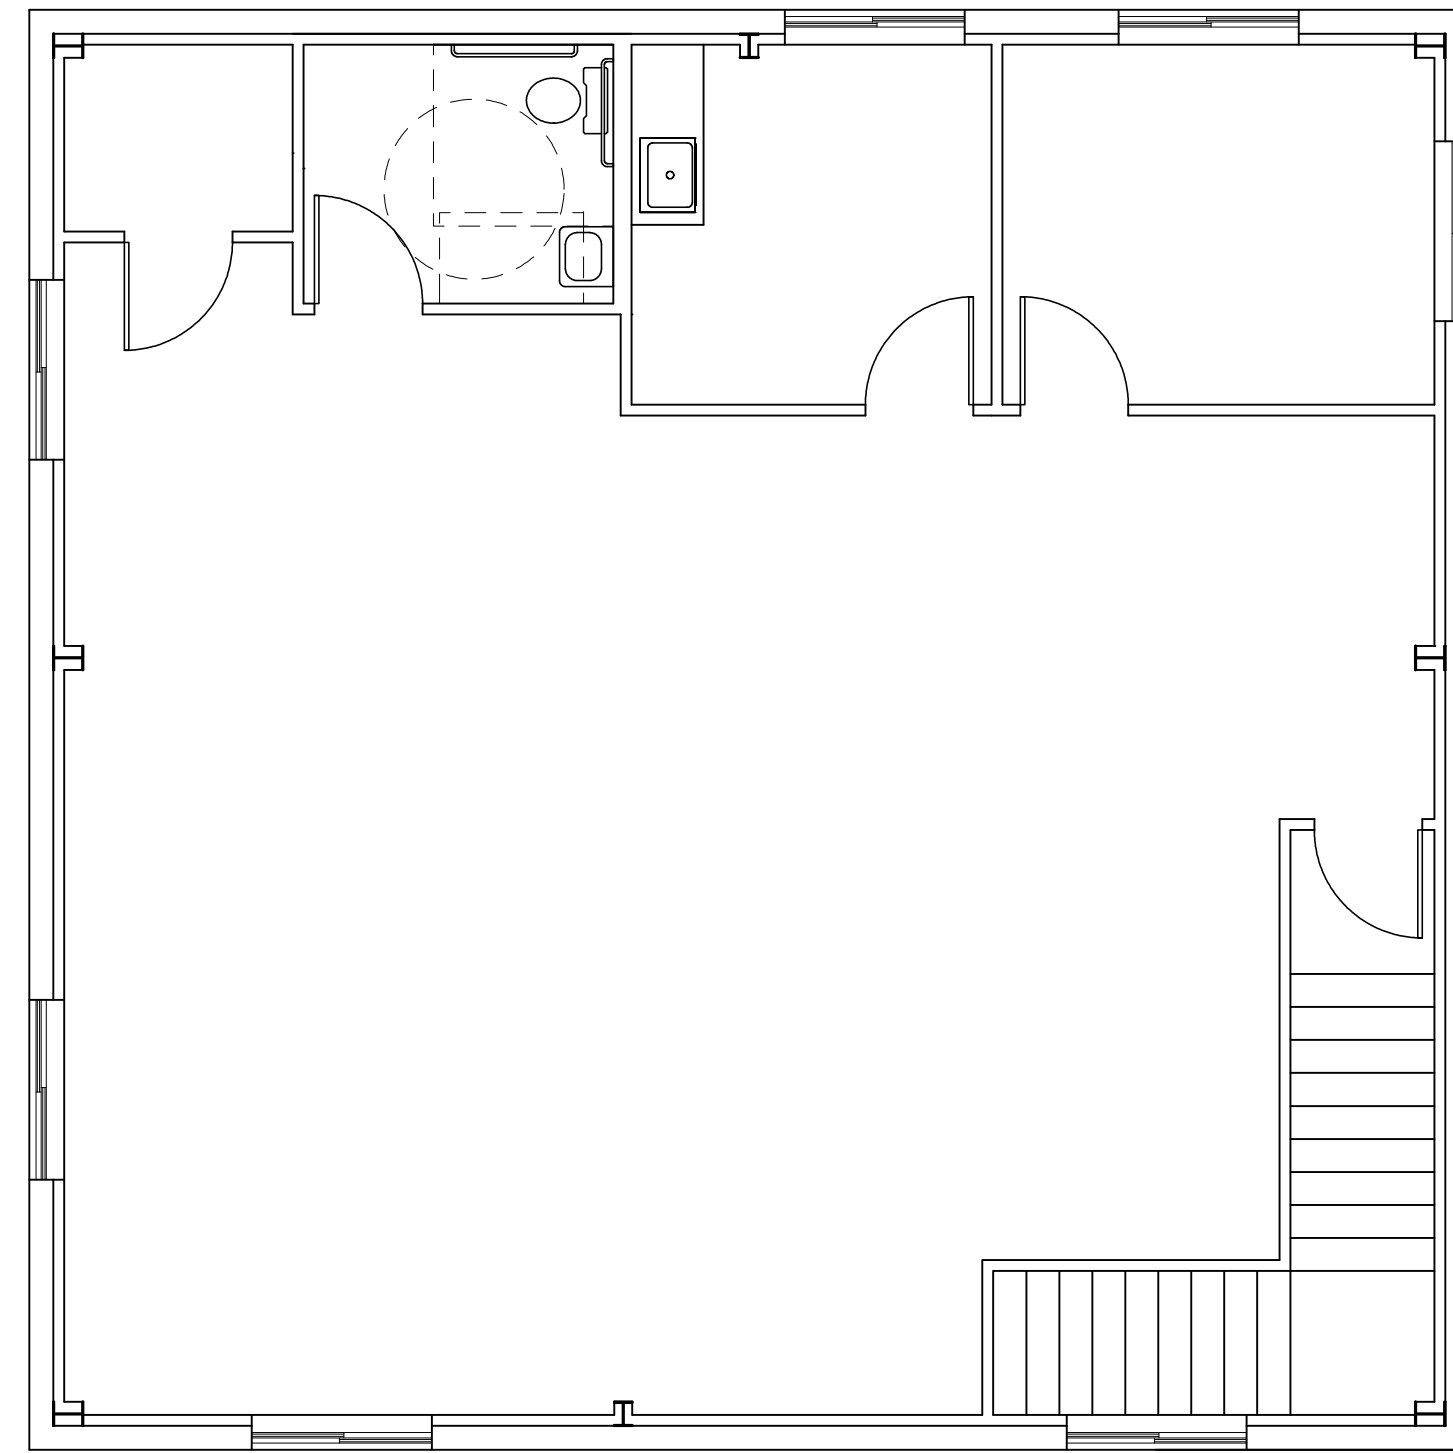

SECOND FLOOR

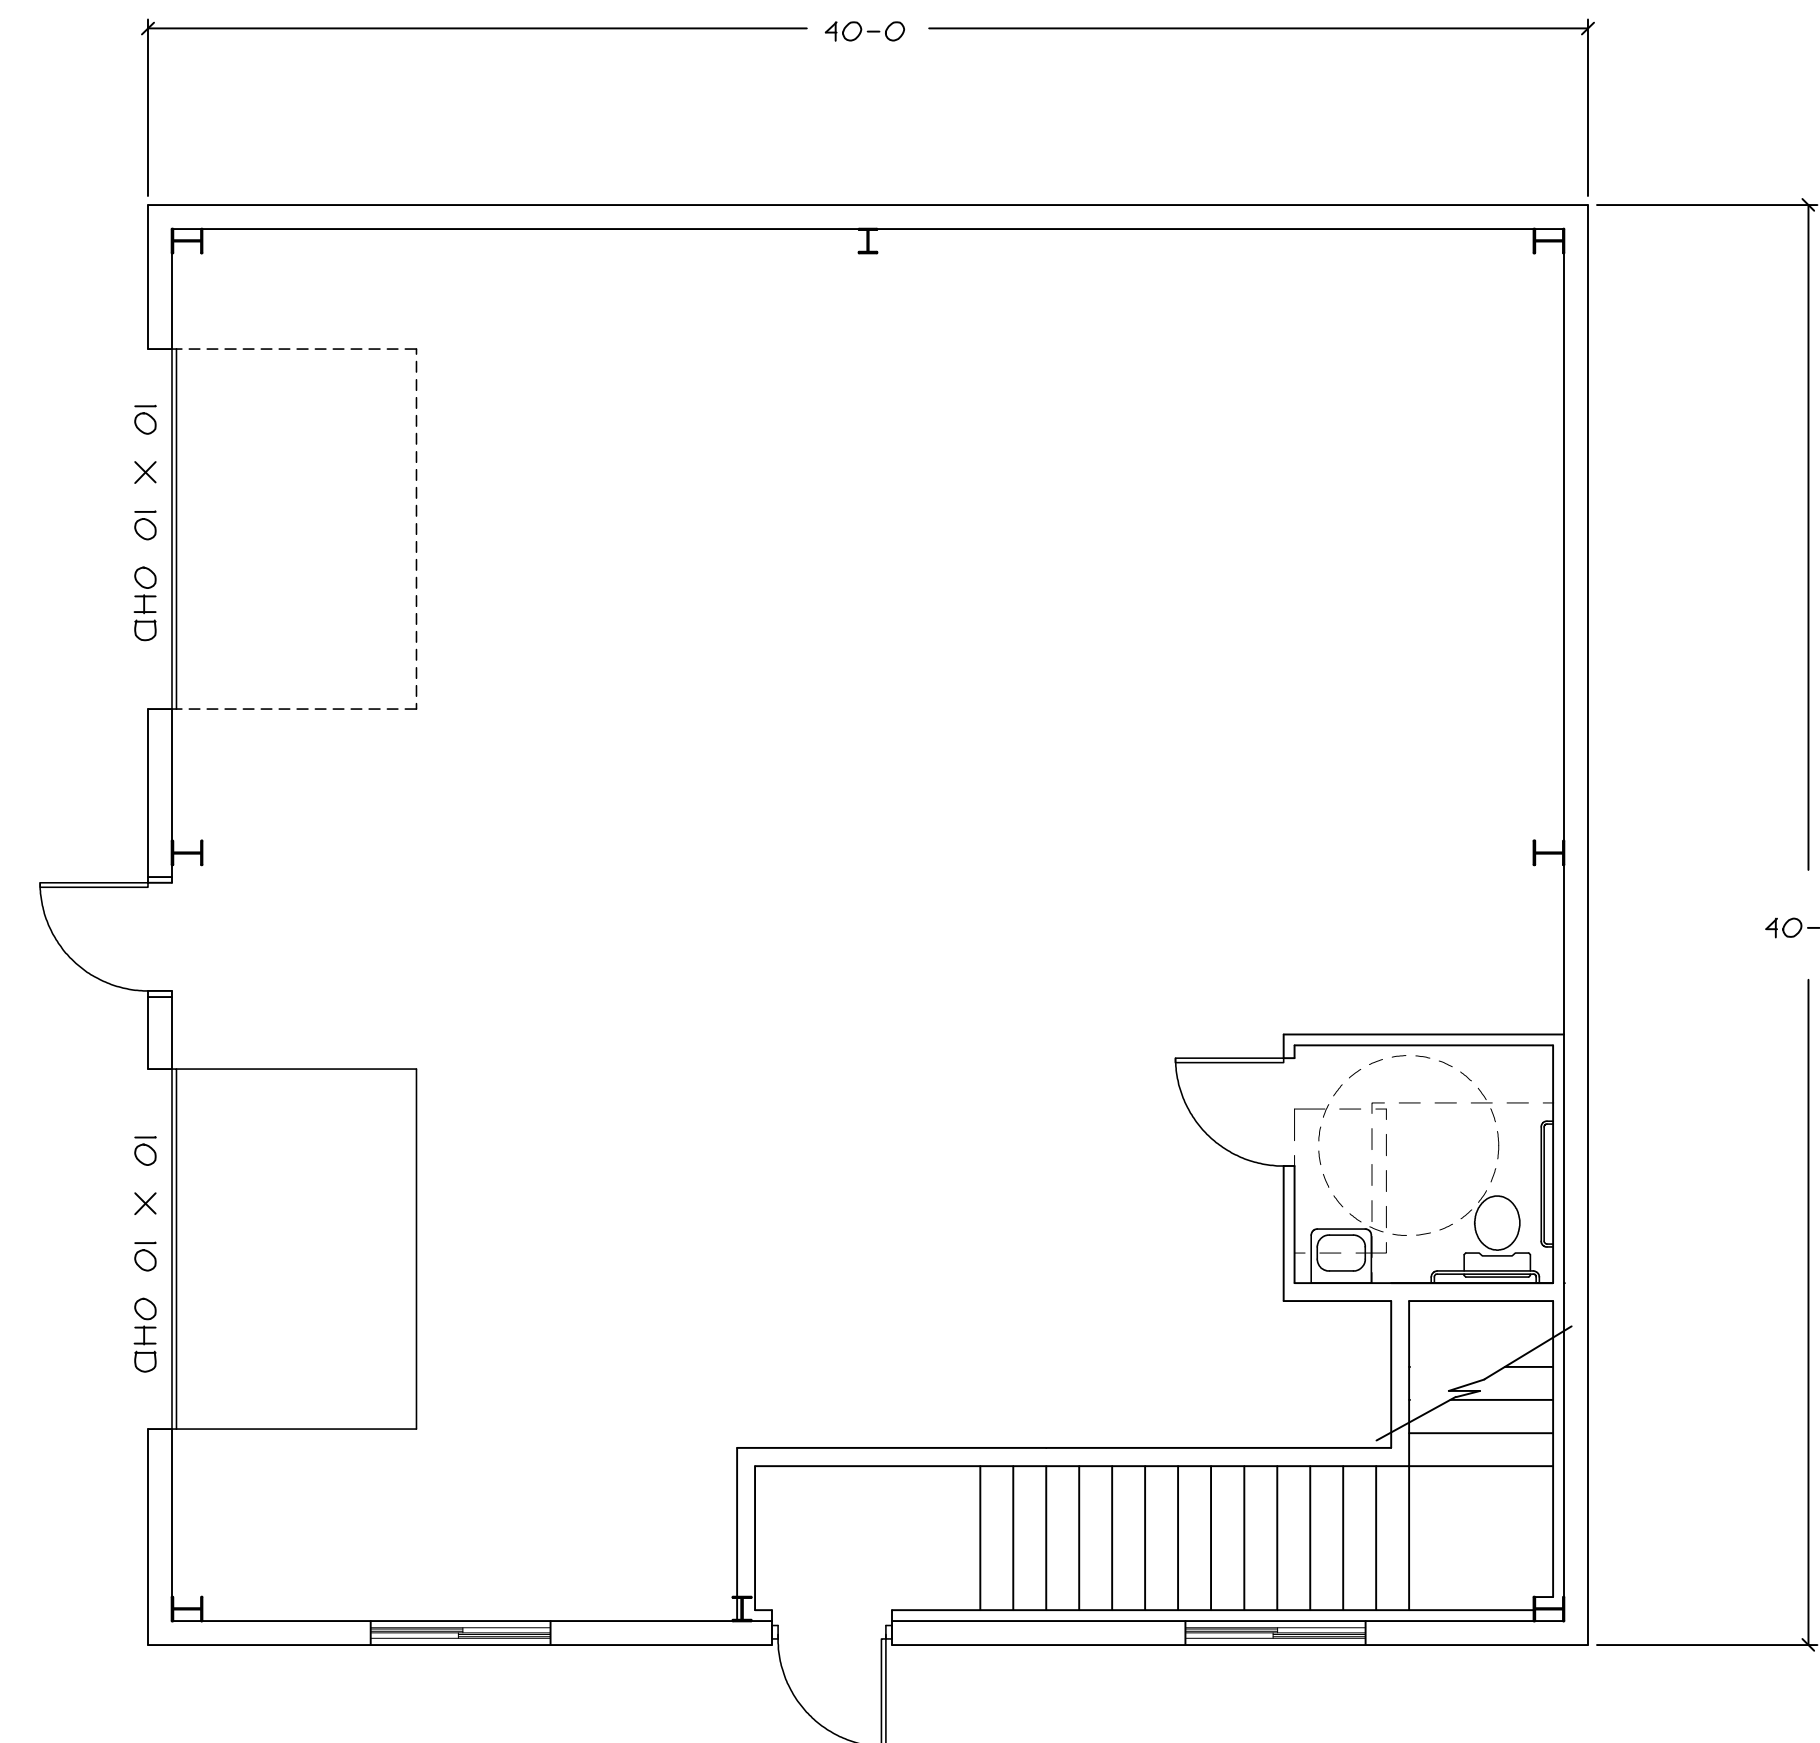

FIRST FLOOR