

BISKUP CONSTRUCTION, INC.
 16 DANIELLE DRIVE
 WINDHAM, MAINE 04042
 TEL. (207) 892-9800
 FAX. (207) 892-9895

WWW.BISKUPCONSTRUCTION.COM

STAMP

PROJECT:
 CONCEPT PLAN
 CASCO BAY ELECTRIC
 316 PRESUMPSCOTT STREET
 PORTLAND, MAINE


REVISIONS	
DATE	DESCRIPTION

DATE: 11/15/2011
 SCALE: 3/16" = 1'-0"
 DESIGNER: JB
 CHECKED BY: JB


© COPYRIGHT
 BISKUP CONSTRUCTION, INC.

SHEET TITLE
 ELEVATIONS

SHEET NUMBER
 A-2
 SHEET 2 OF 2

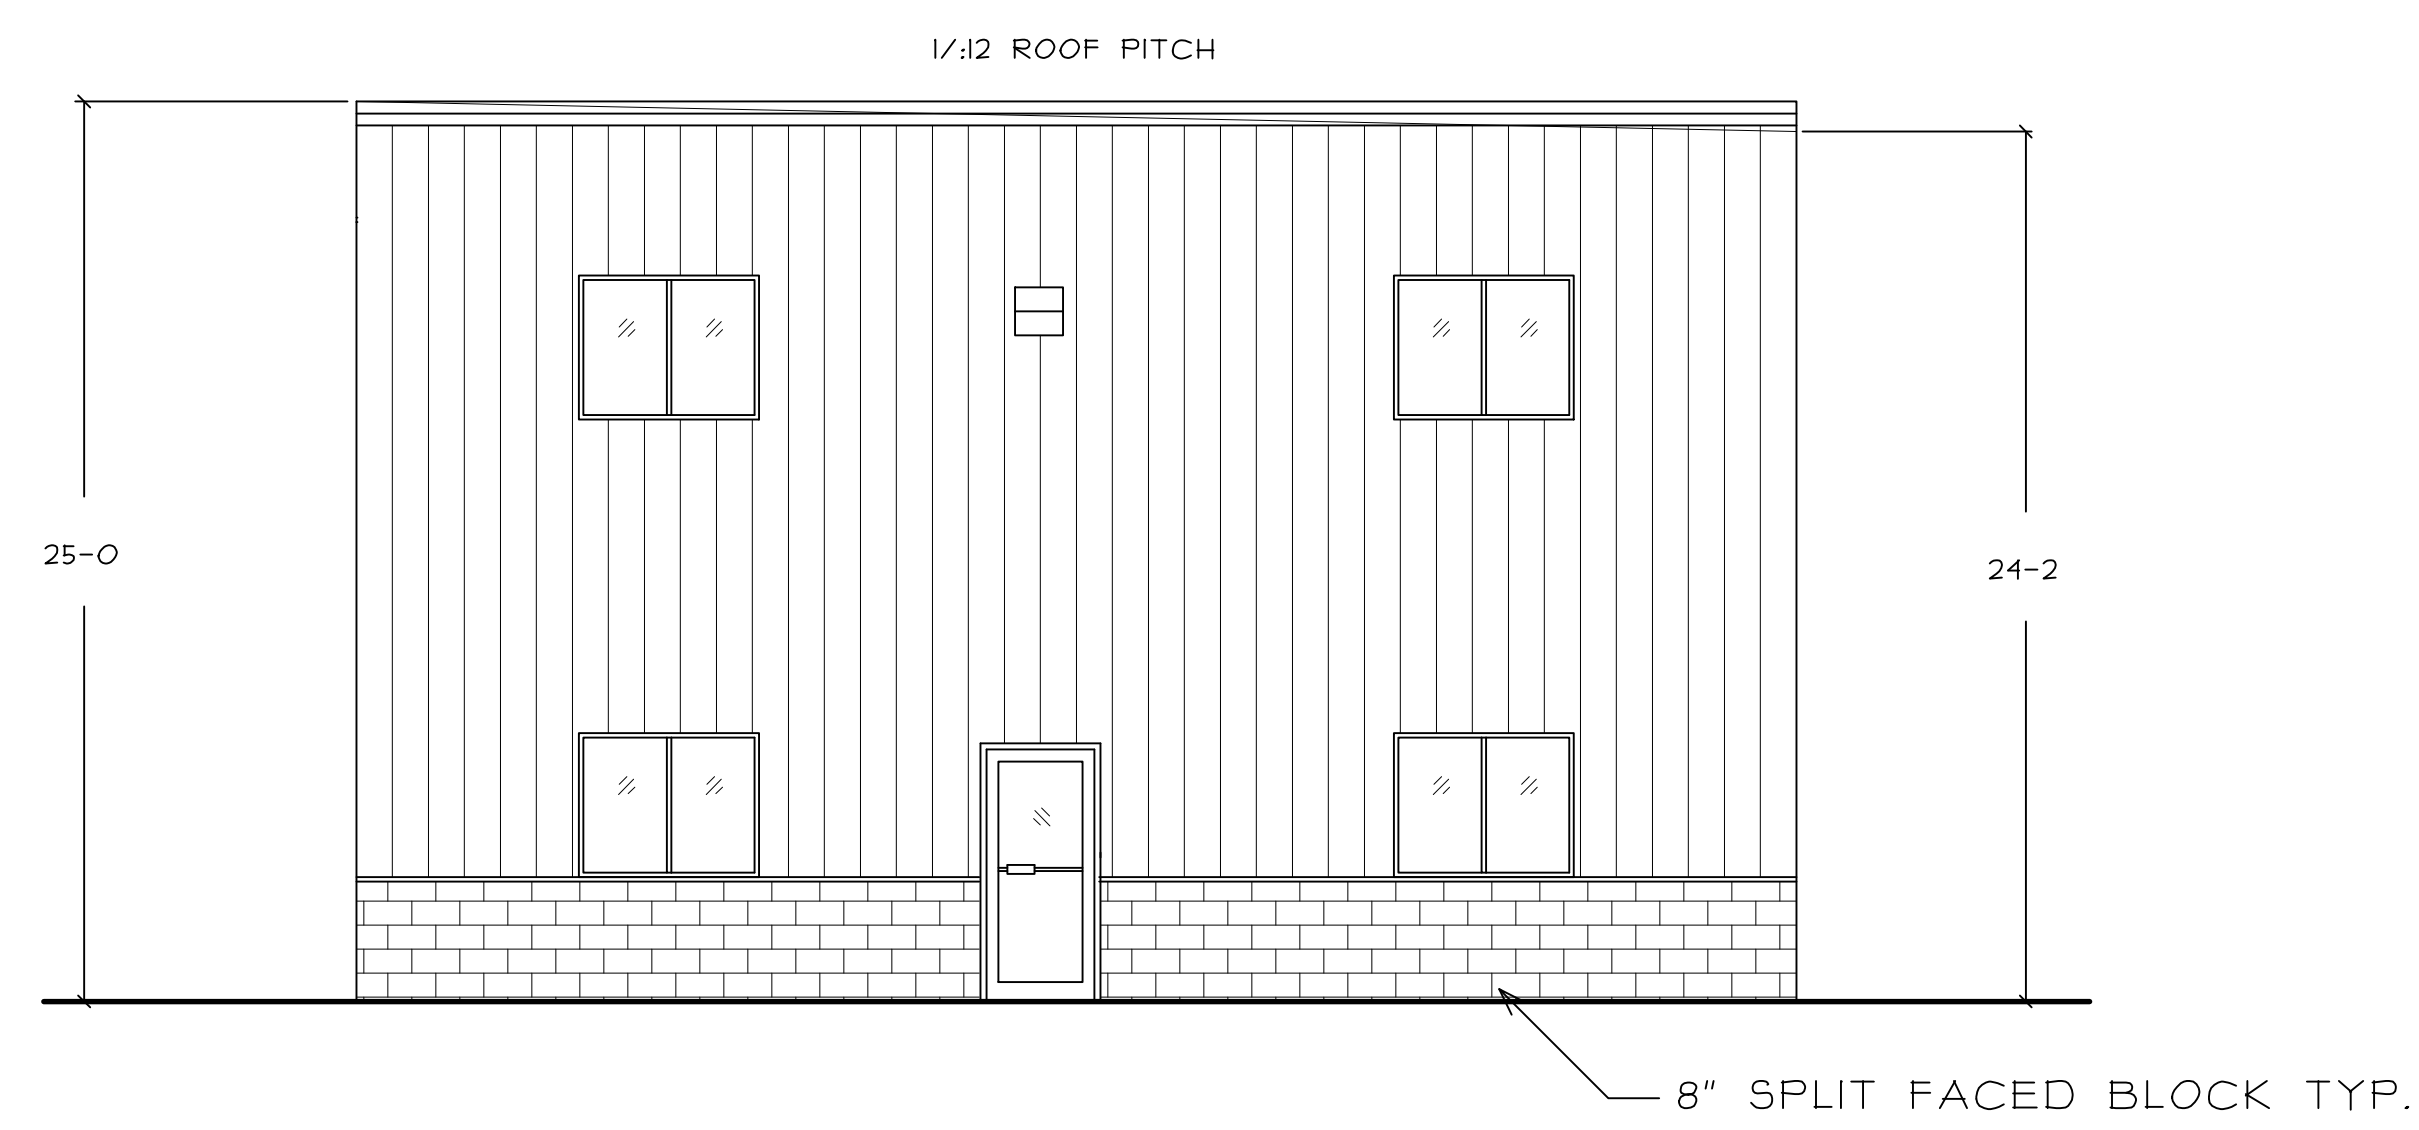

FRONT ELEVATION

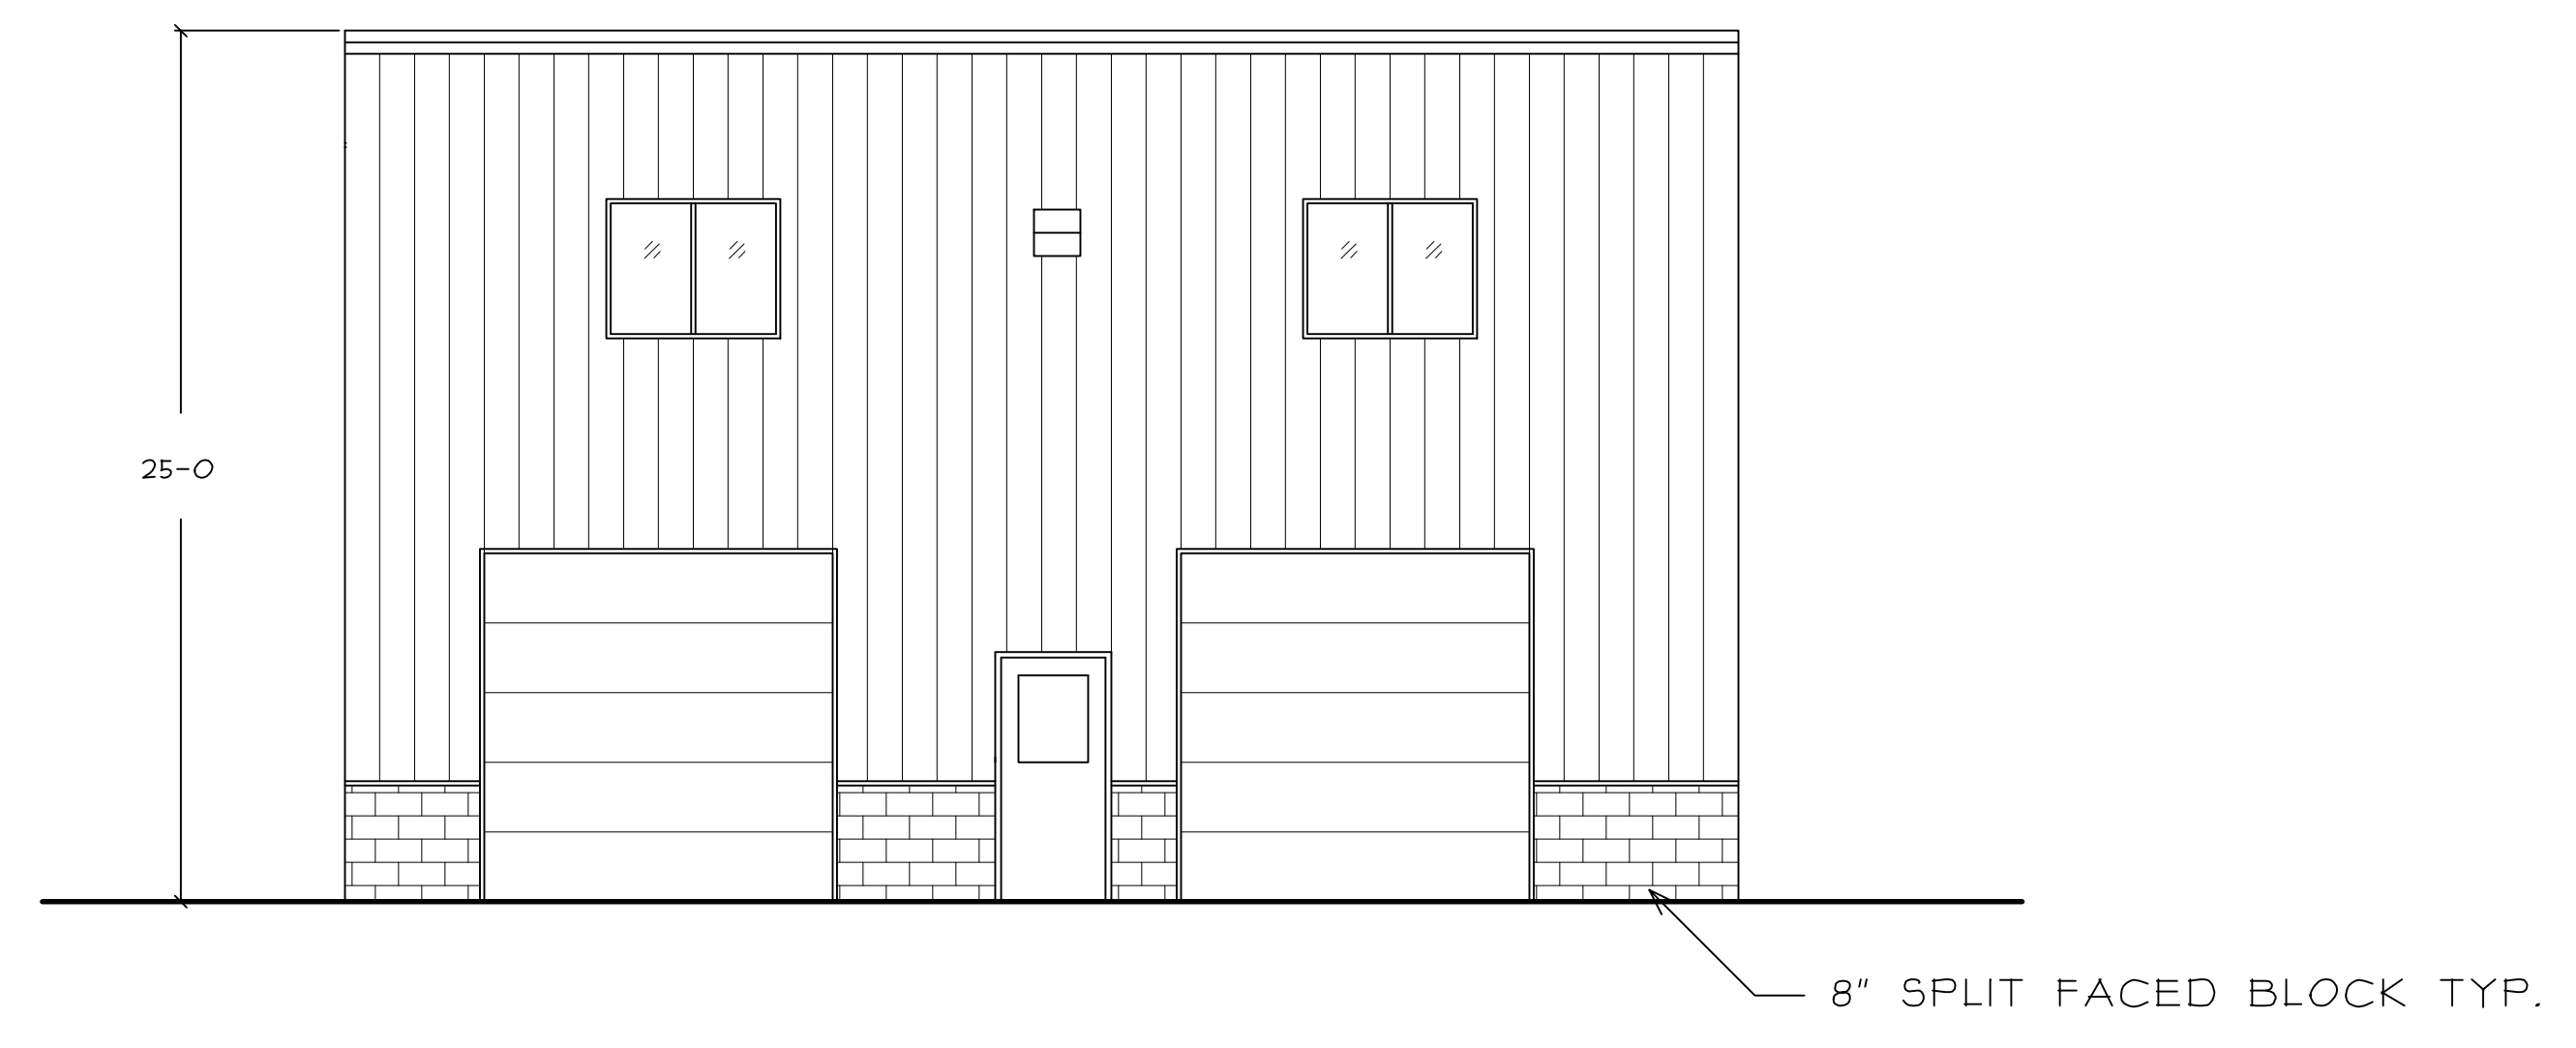

RIGHT ELEVATION