




BISKUP CONSTRUCTION, INC.
 16 DANIELLE DRIVE
 WINDHAM, MAINE 04062
 TEL. (207) 892-9800
 FAX. (207) 892-9895

WWW.BISKUPCONSTRUCTION.COM

STAMP

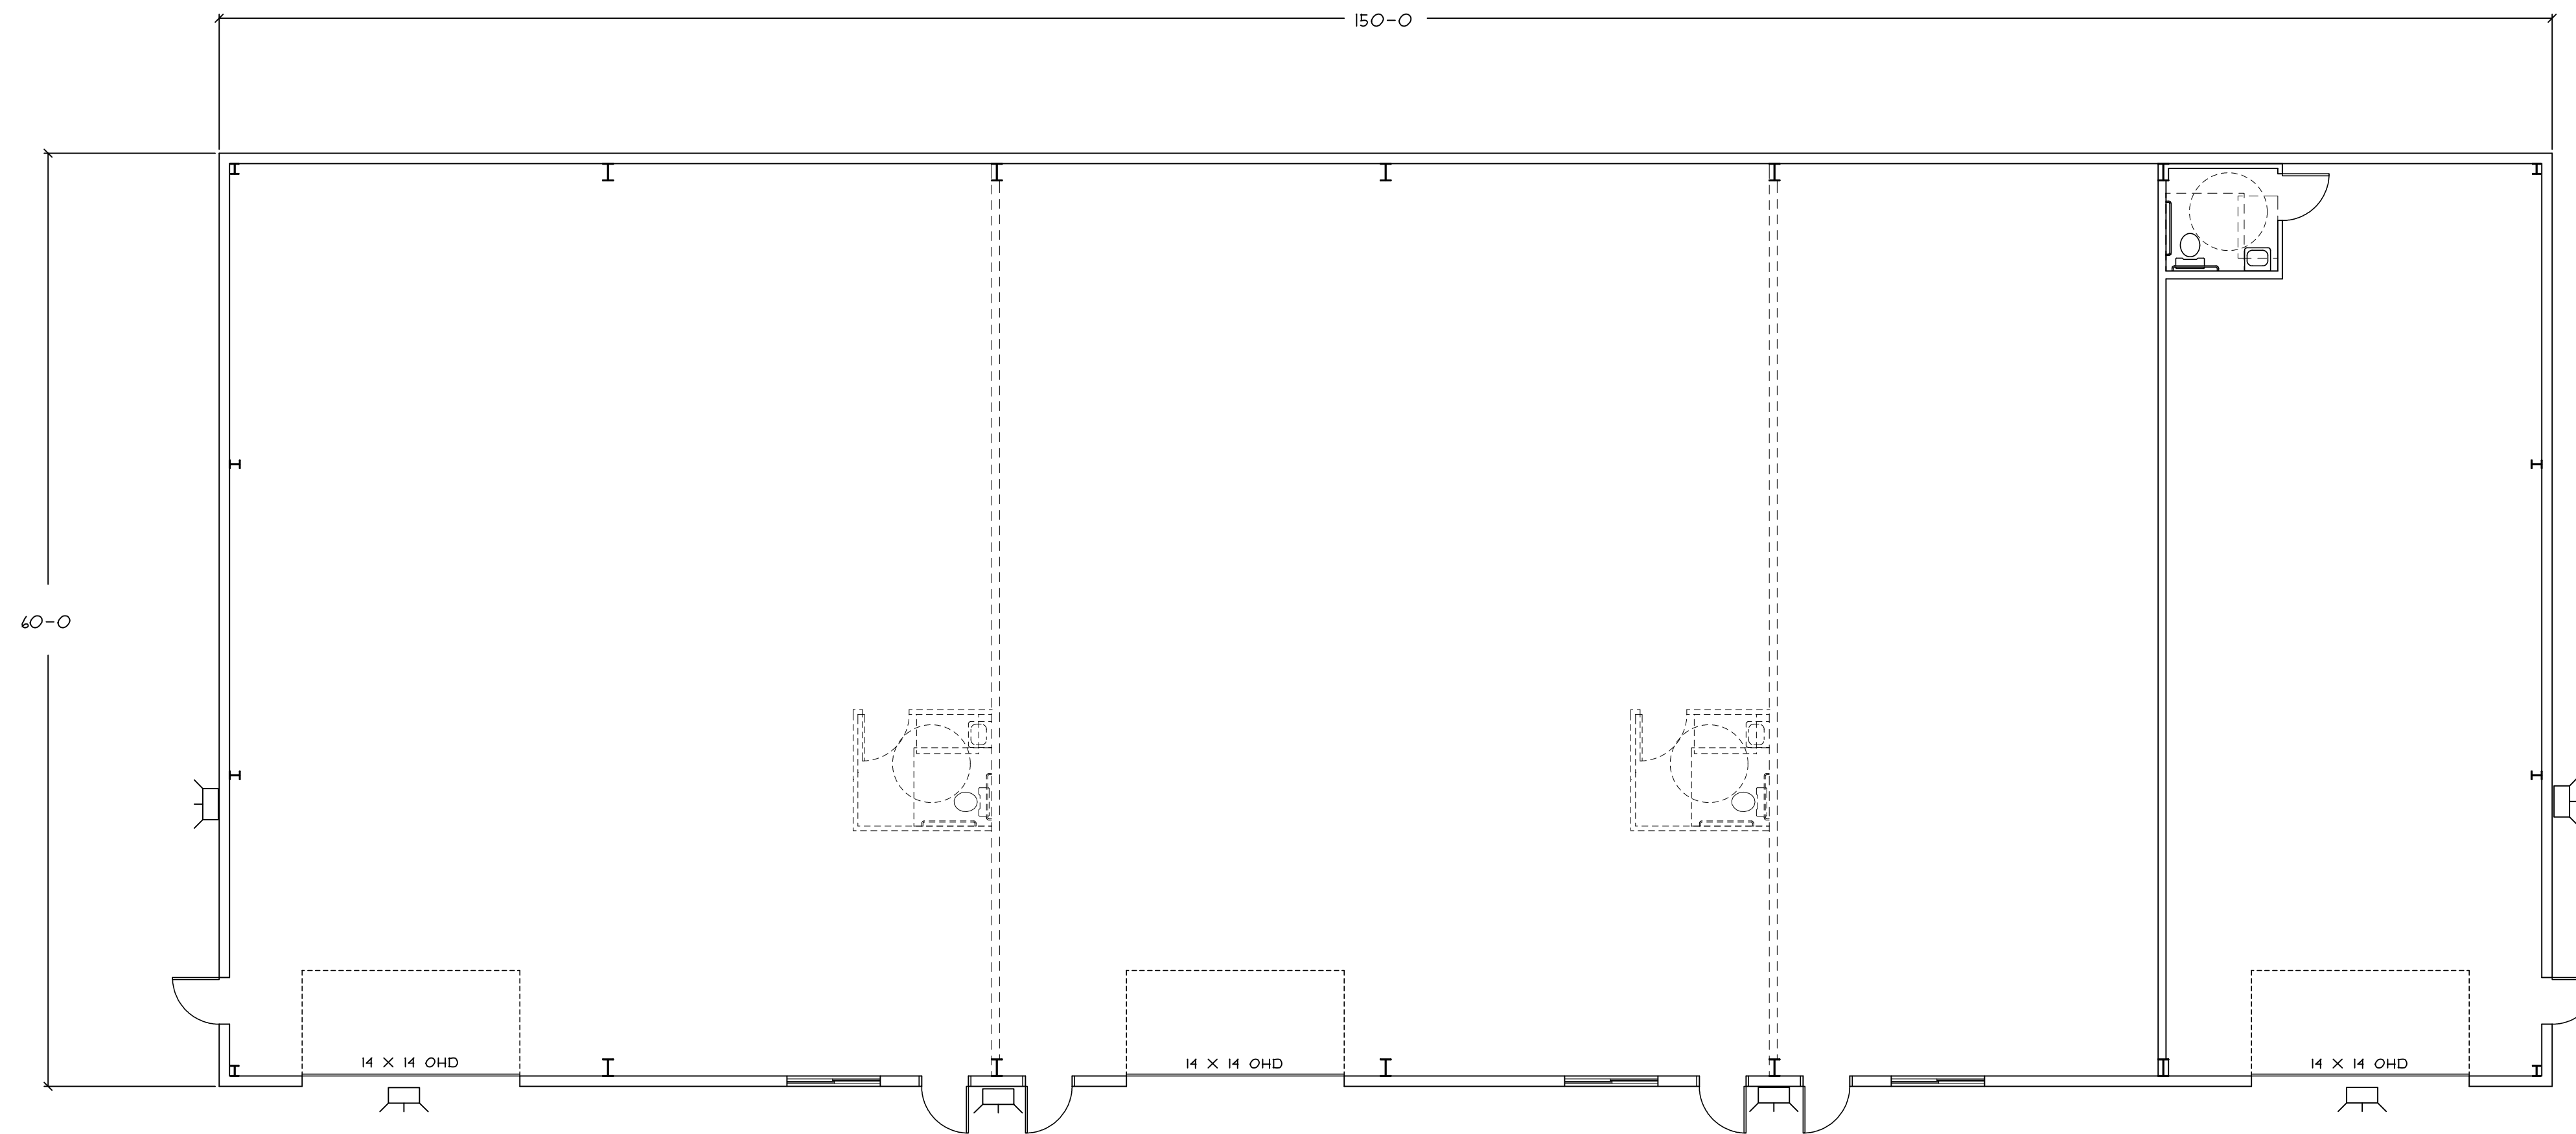

PROJECT:
 CONCEPT PLAN
 CASCO BAY ELECTRIC
 316 PRESUMPCOTT STREET
 PORTLAND, MAINE

REVISIONS	
DATE	DESCRIPTION

DATE: 11/15/2011
 SCALE: 1/8" = 1'-0"
 DESIGNER: JB
 CHECKED BY: JB

© COPYRIGHT
 BISKUP CONSTRUCTION, INC.

SHEET TITLE
 FLOOR PLAN

SHEET NUMBER
 A-1
 SHEET 1 OF 2