



**Hemesphere
DESIGN**
Architecture

58 Fore Street
Portland, ME 04101
207.232.6079
joe@hemespheredesign.com
www.hemespheredesign.com


**PROSPECT
DESIGN**
58 FORE ST. PORTLAND, ME
www.prospectdesign.me
T: 207-749-7400

MITA
MAINE YACHT CENTER,
100 KENSINGTON
STREET, PORTLAND
MAINE

SHEET TITLE
**SECOND FLOOR LIGHTING
AND POWER PLAN**
REVISION
PERMIT SET

DRAWN BY
DATE: January 12, 2017

E1

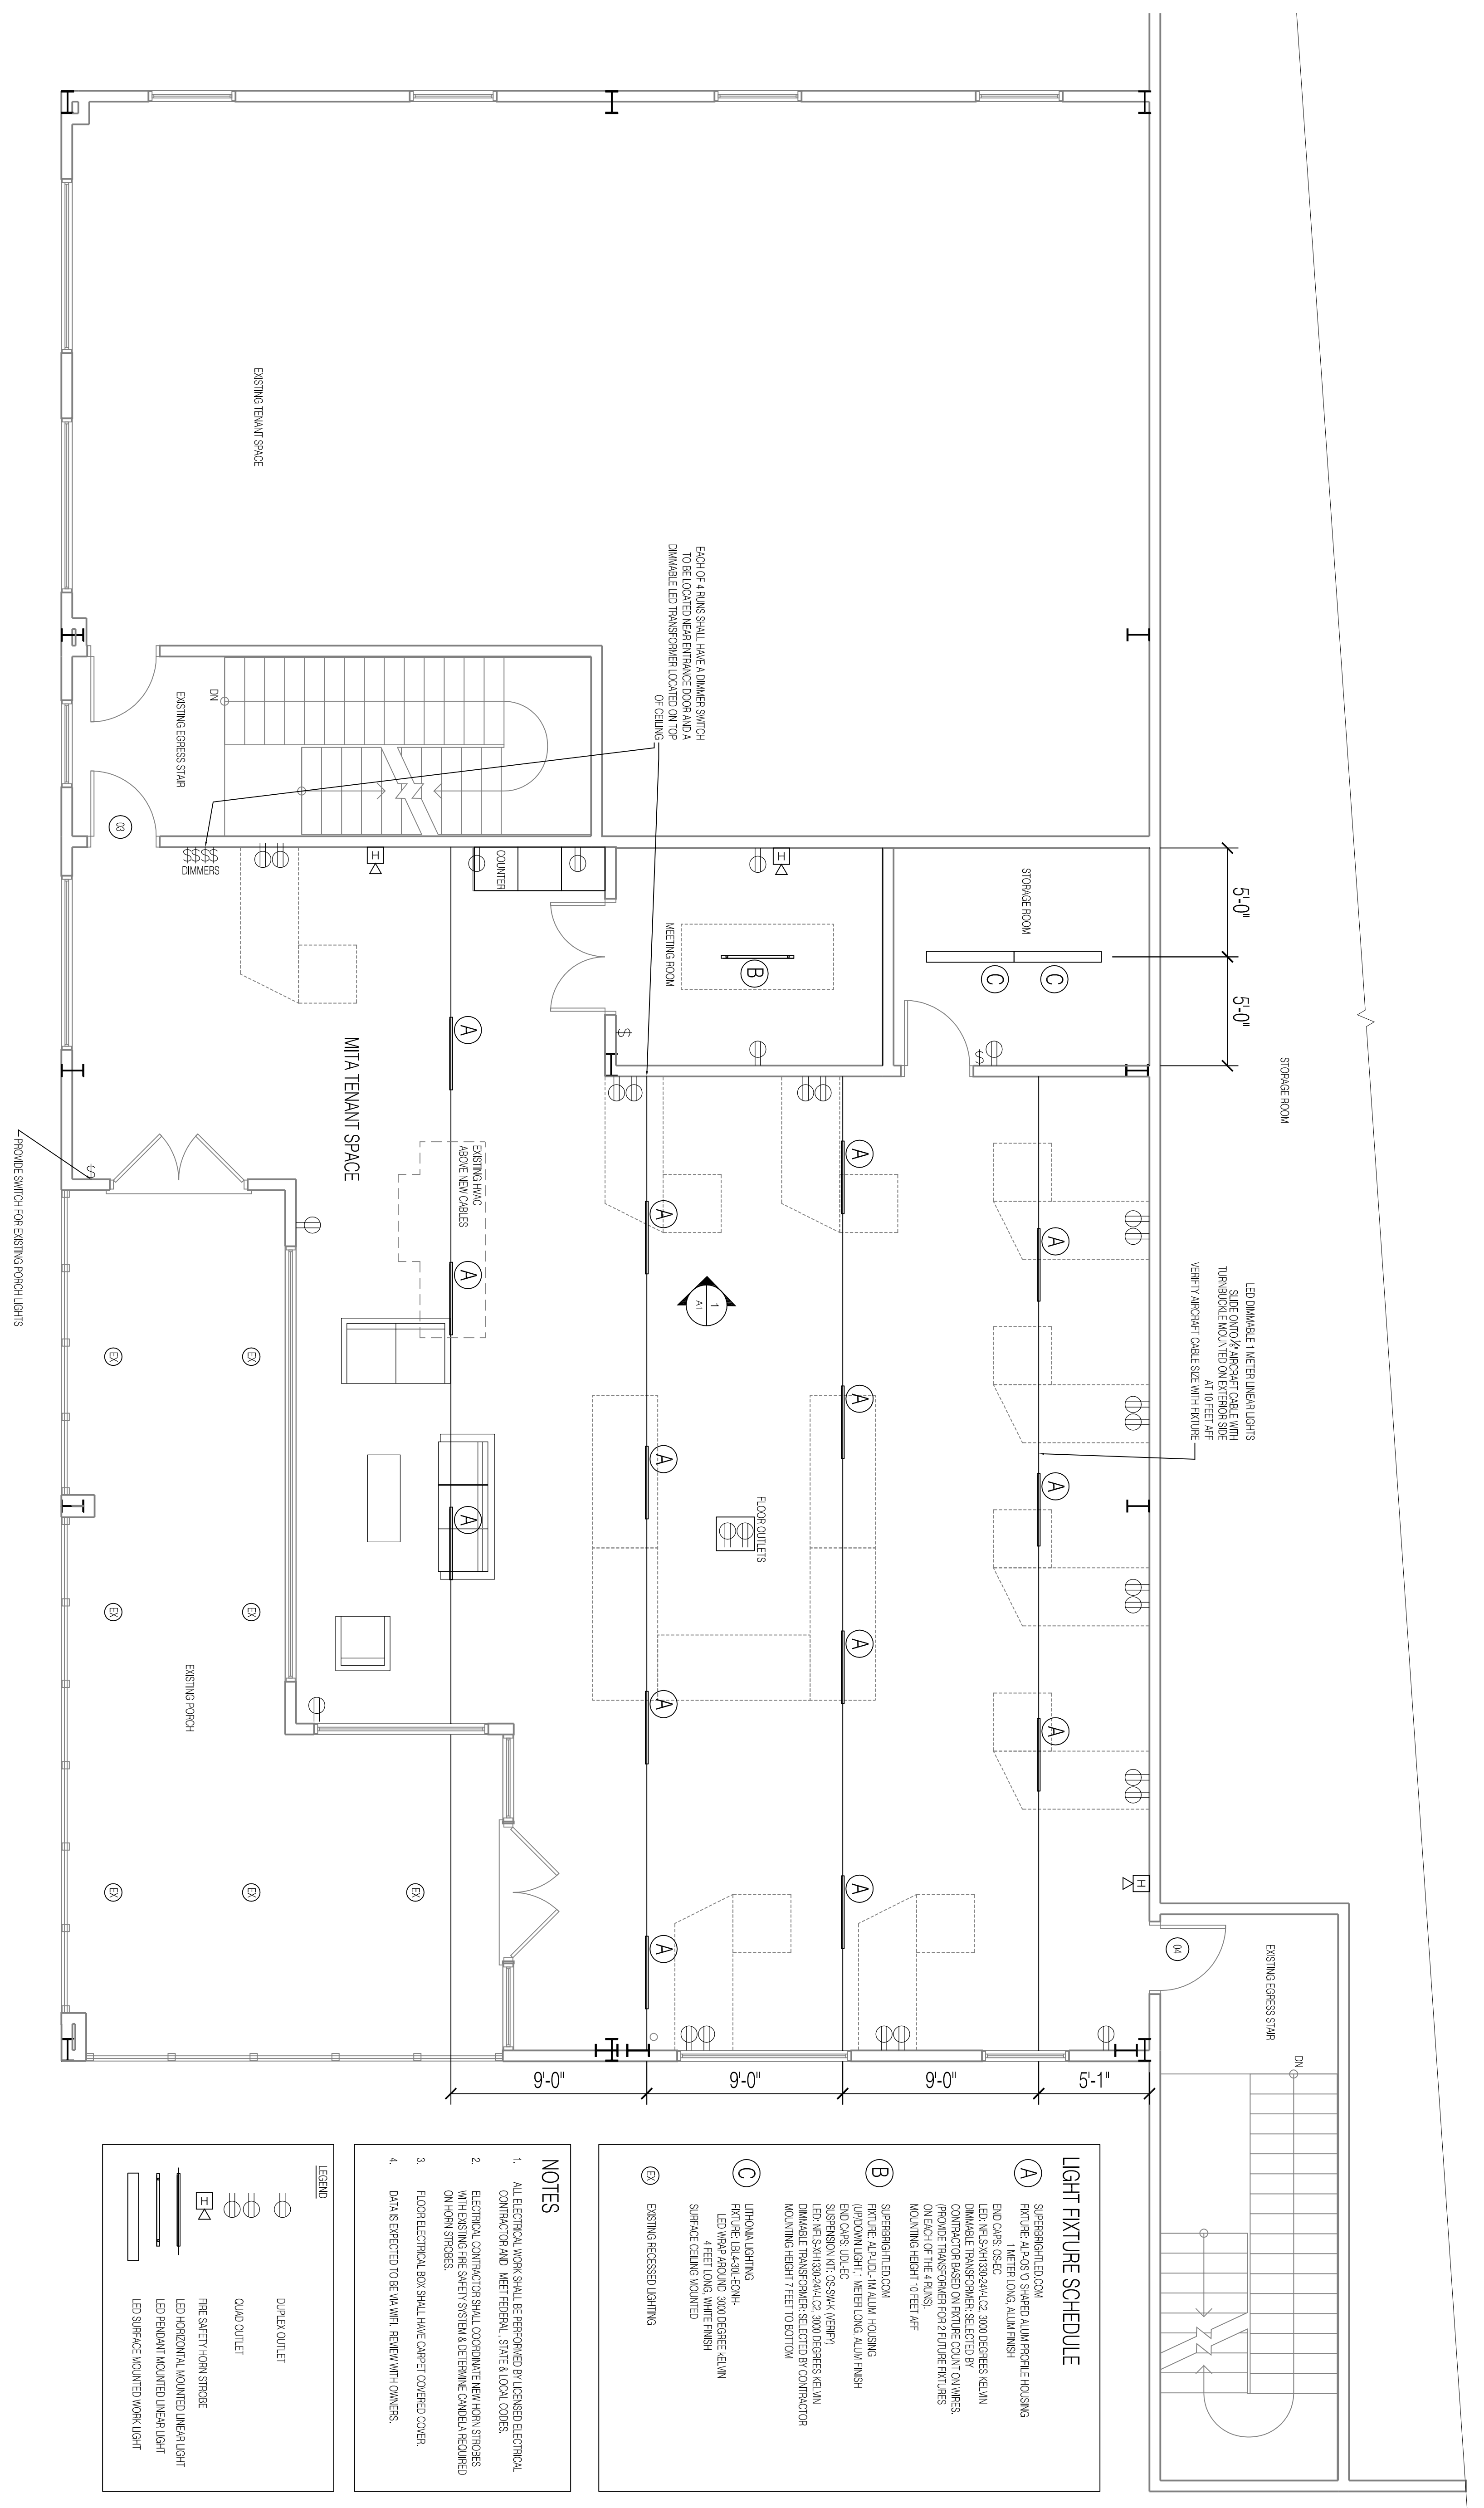

1
1/8" = 1'-0"
PROPOSED SECOND FLOOR LIGHTING AND POWER PLAN