


 




WASHINGTON AVENUE →

← VERANDA STREET ↓

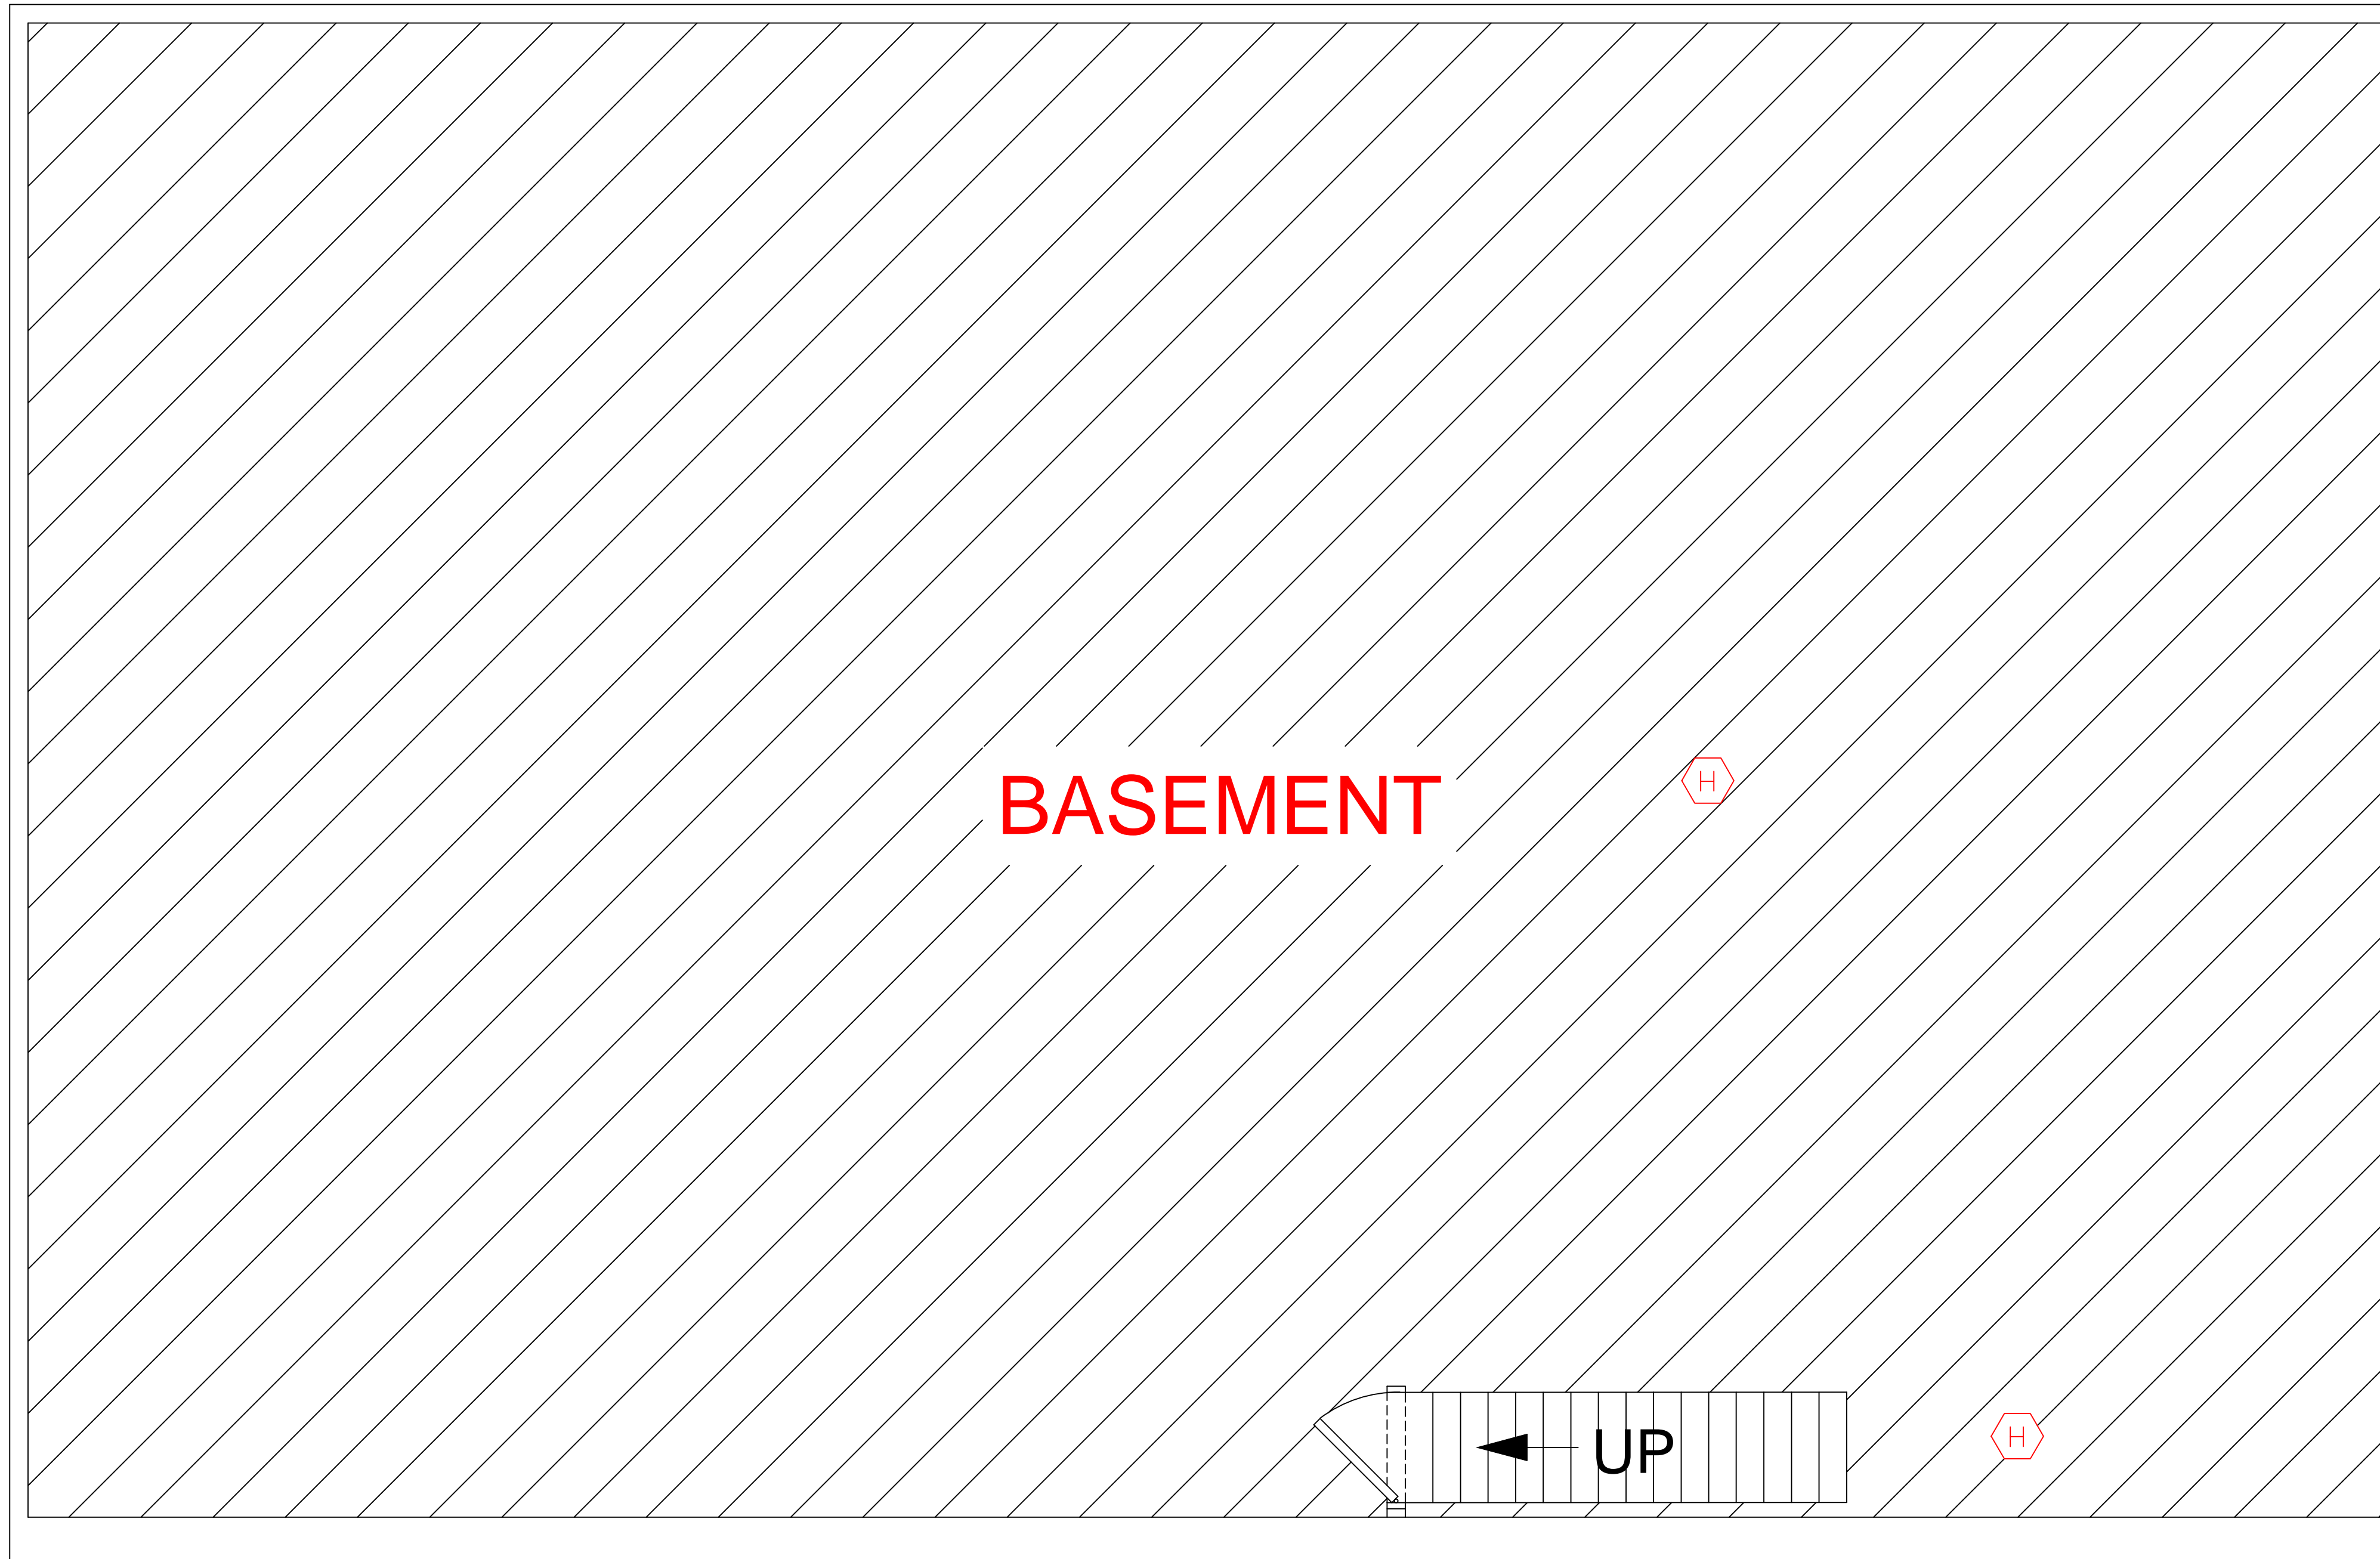


LEGEND

-  PULL STATION
-  SMOKE DETECTOR
-  HEAT DETECTOR
-  HORN/STROBE (XX NOTES CANDELA)
-  FIRE ALARM CONTROL PANEL

REVISION 2	DATE:
REVISION 1	DATE:
REVISION 0 SUBMITTAL	DATE: 11/03/2014

FIRE ALARM LAYOUT BASEMENT

PROJECT NAME 505 WASHINGTON AVE APARTMENTS PORTLAND, ME	SCALE NTS
	BY: JRS


Prepared For Tomorrow, Delivered Today
2257 BROADWAY, SO. PORTLAND, MAINE

FA-1