


WASHINGTON AVENUE →

← VERANDA STREET

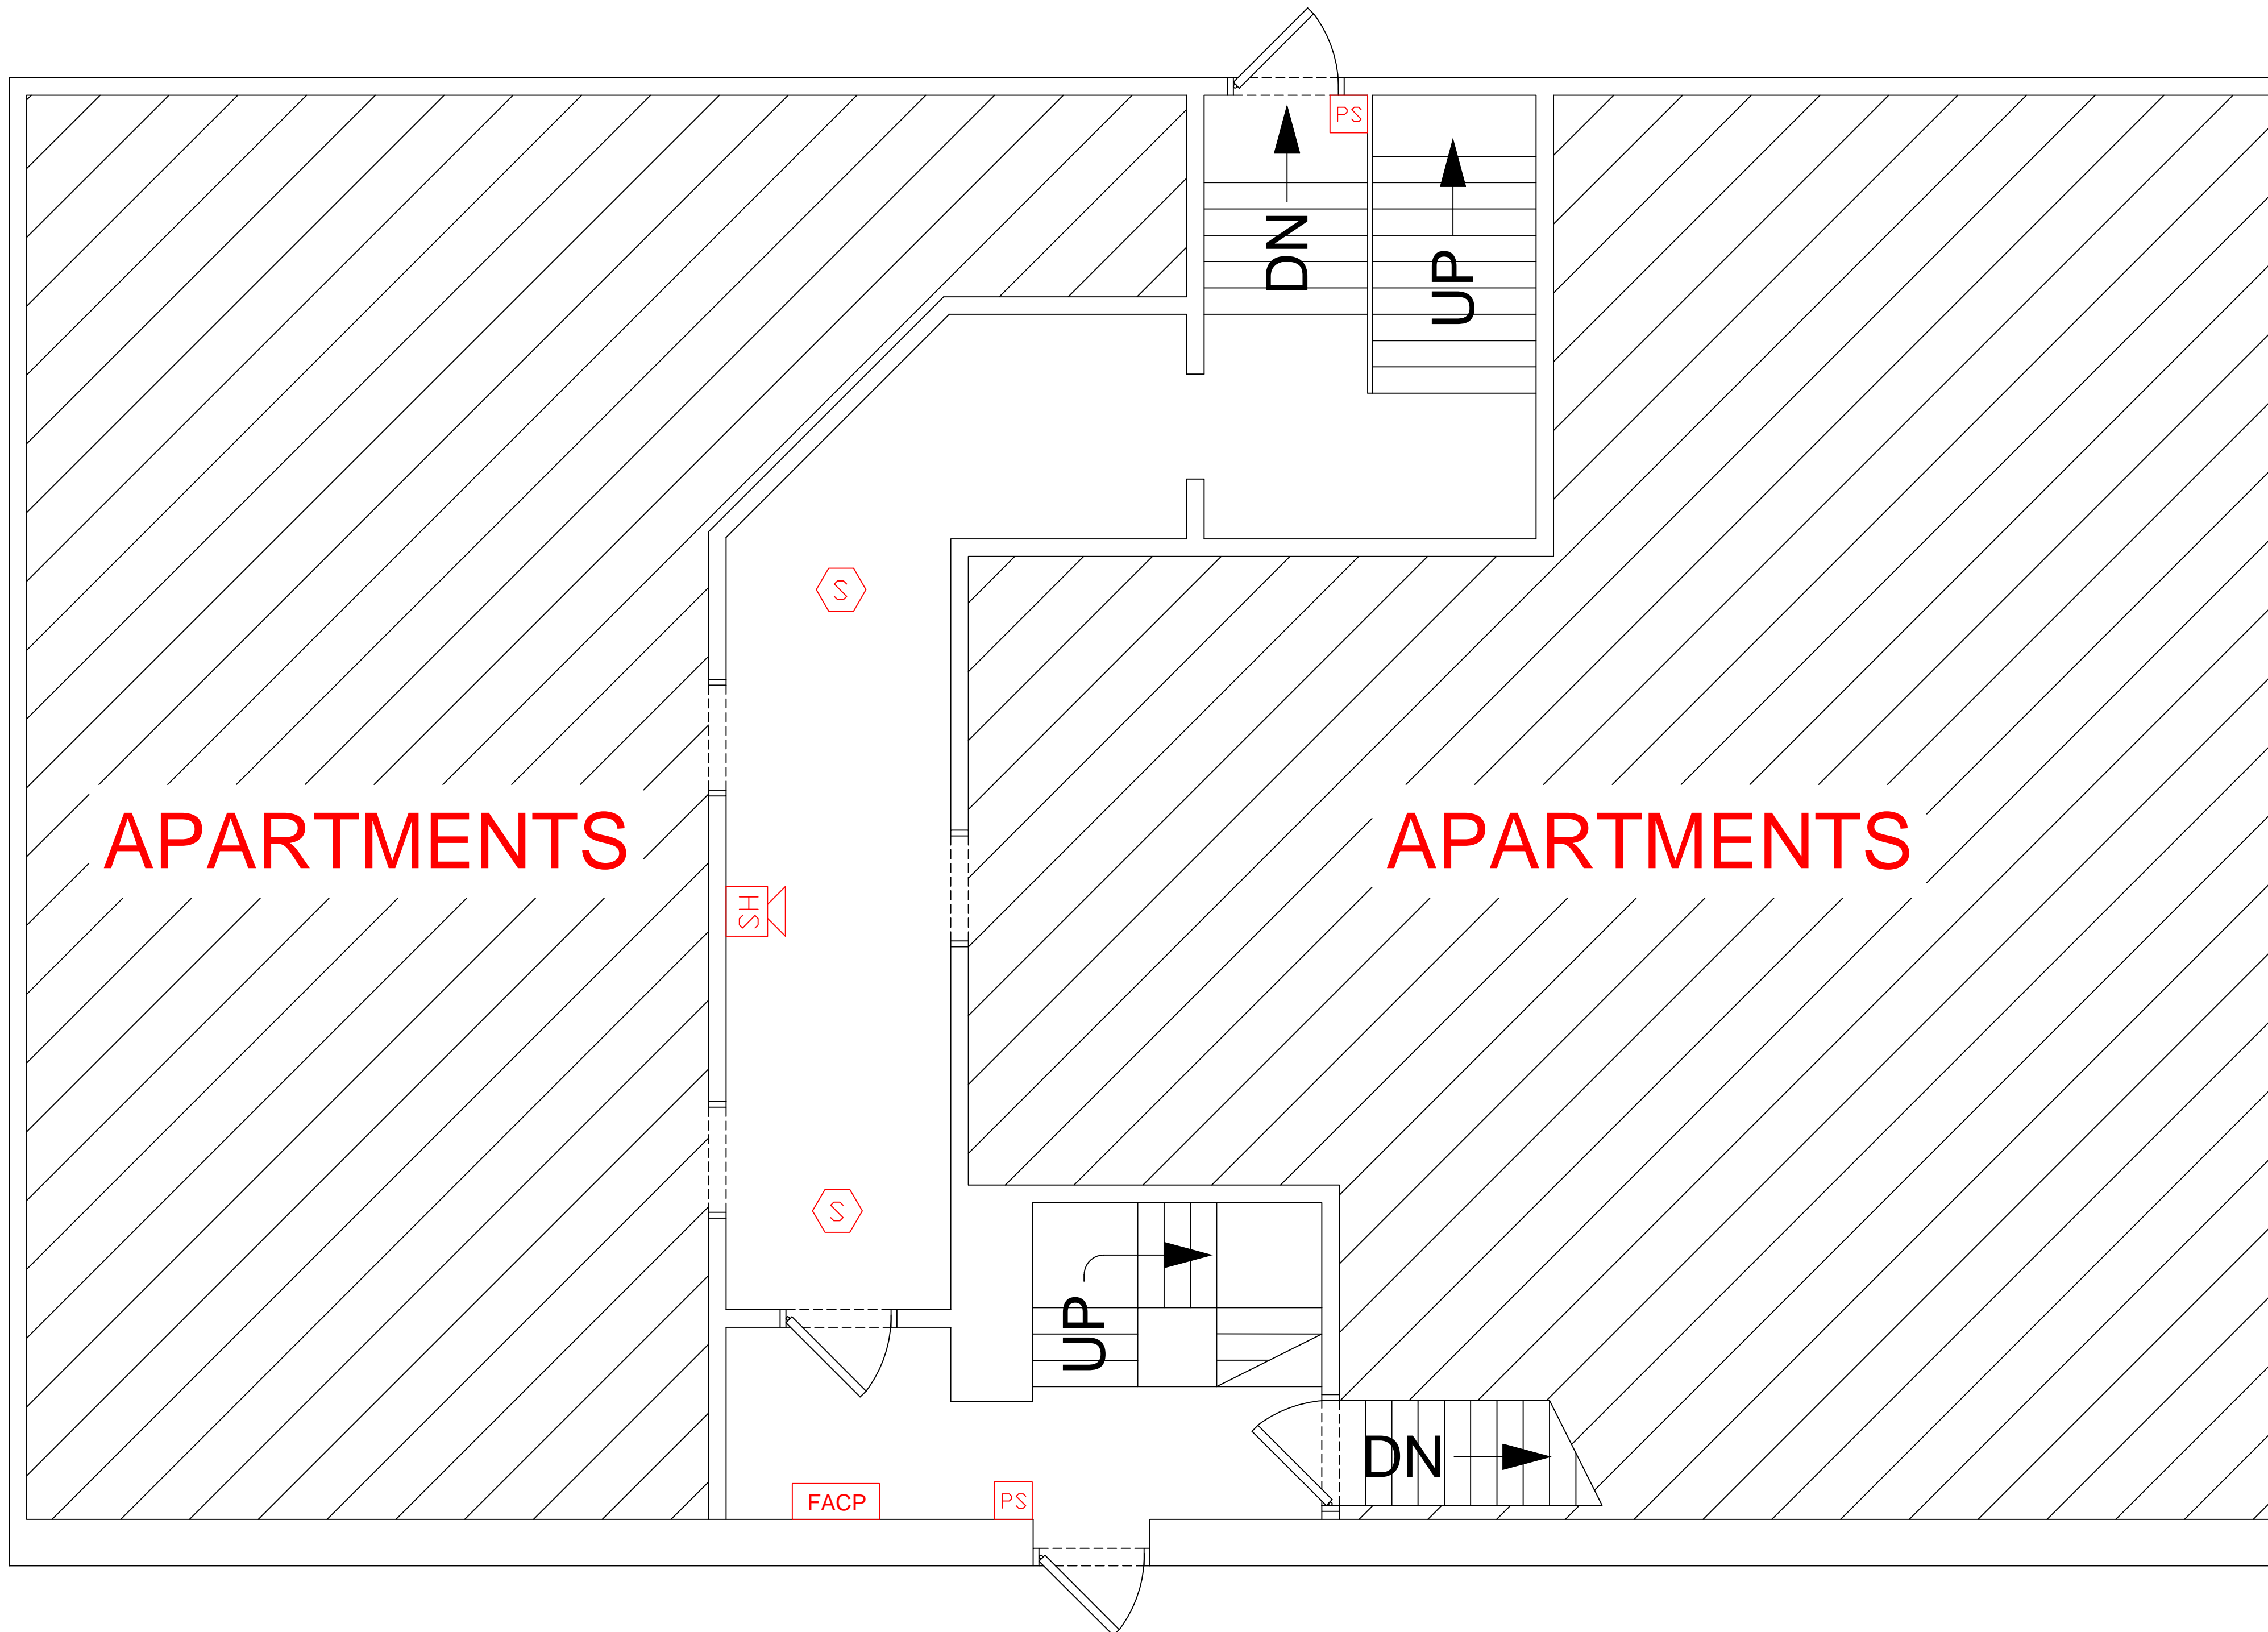

LEGEND

- PS PULL STATION
- S SMOKE DETECTOR
- H HEAT DETECTOR
- HS
XX HORN/STROBE
(XX NOTES CANDELA)
- FACP FIRE ALARM CONTROL PANEL

REVISION 2	DATE:
REVISION 1	DATE:
REVISION 0 SUBMITTAL	DATE: 11/03/2014

FIRE ALARM LAYOUT FIRST FLOOR

505 WASHINGTON AVE APARTMENTS
PORTLAND, ME

SCALE NTS

BY: JRS

NORRIS INC
Prepared For Tomorrow, Delivered Today
2257 BROADWAY, SO. PORTLAND, MAINE

FA-2