


WASHINGTON AVENUE →

← VERANDA STREET ↓

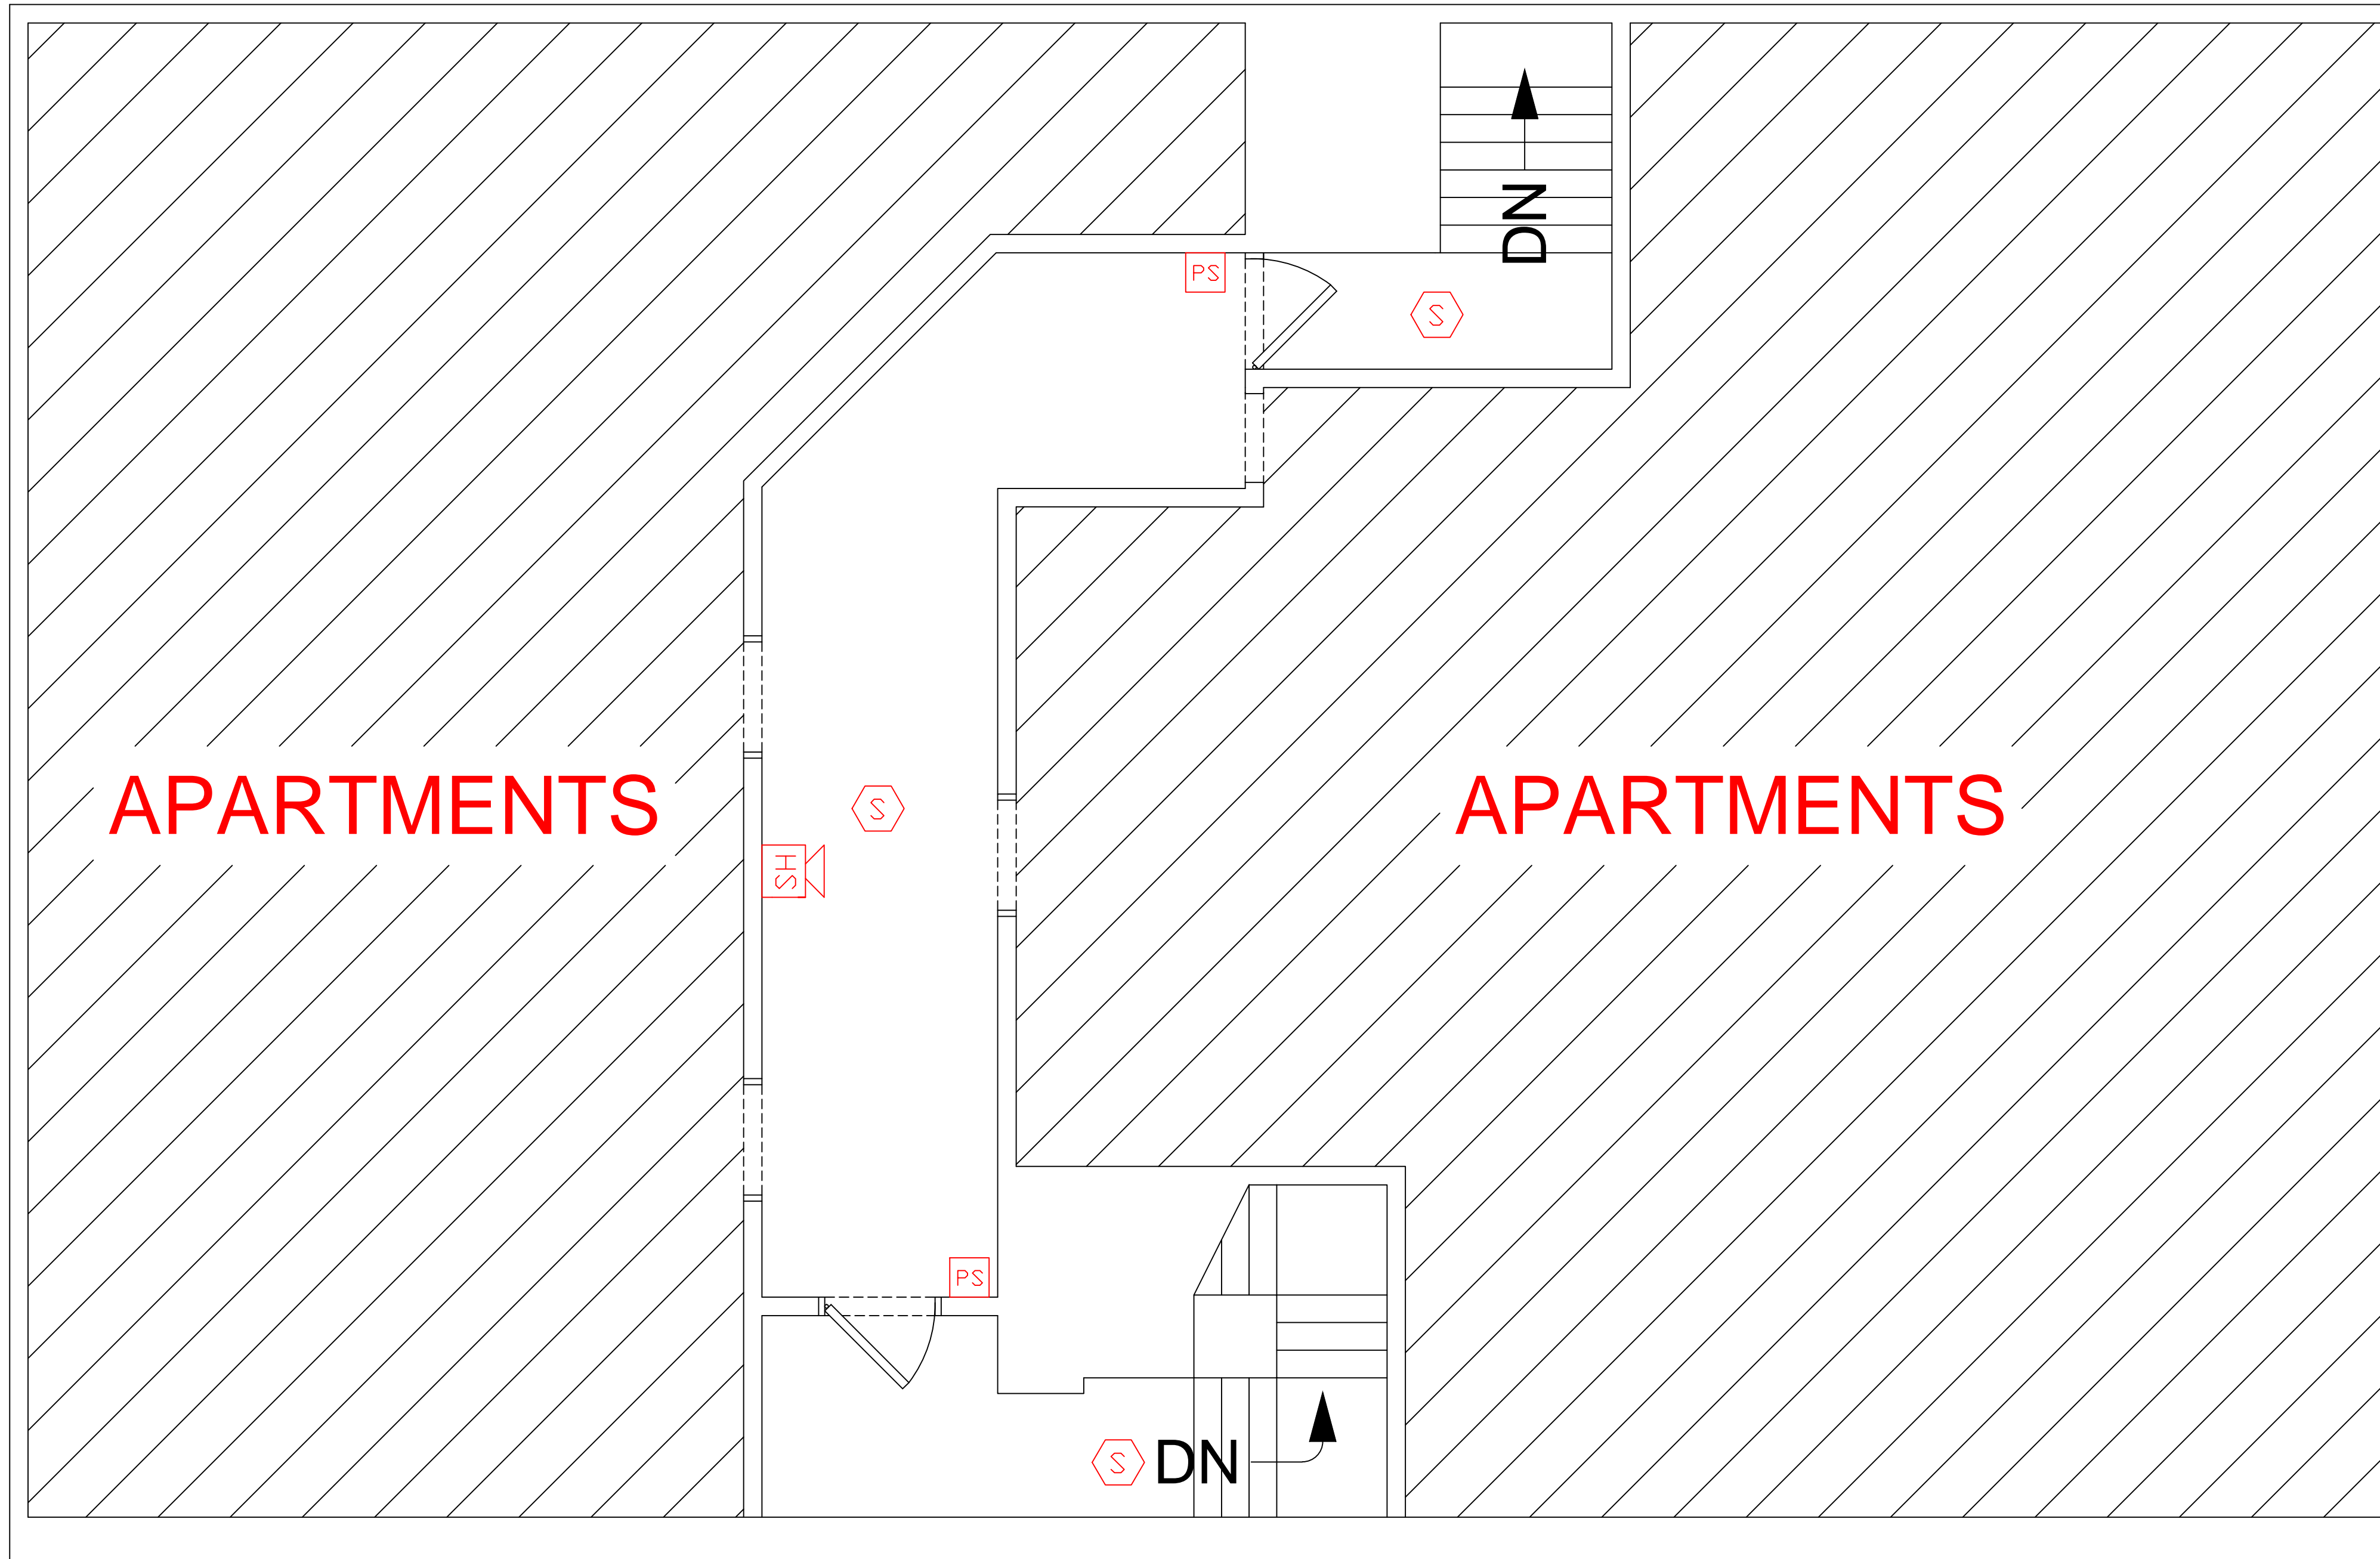

LEGEND

- PS PULL STATION
- S SMOKE DETECTOR
- H HEAT DETECTOR
- HS  
XX HORN/STROBE  
(XX NOTES CANDELA)
- FACP FIRE ALARM CONTROL PANEL

REVISION 2	DATE:
REVISION 1	DATE:
REVISION 0 SUBMITTAL	DATE: 11/03/2014

FIRE ALARM LAYOUT THIRD FLOOR

505 WASHINGTON AVE APARTMENTS PORTLAND, ME	SCALE NTS
	BY: JRS

 <b>NORRIS INC</b> <small>Prepared For Tomorrow, Delivered Today</small> 2257 BROADWAY, SO. PORTLAND, MAINE	FA-4
---	------