 


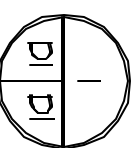


NOTE: WHERE DEMOLITION IS INDICATED, REMOVE ALL ASSOCIATED ELECTRICAL, MECHANICAL & PLUMBING FIXTURES

# FIRST FLOOR DEMO PLAN

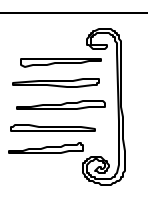

SCALE: 1/4" = 1'-0"

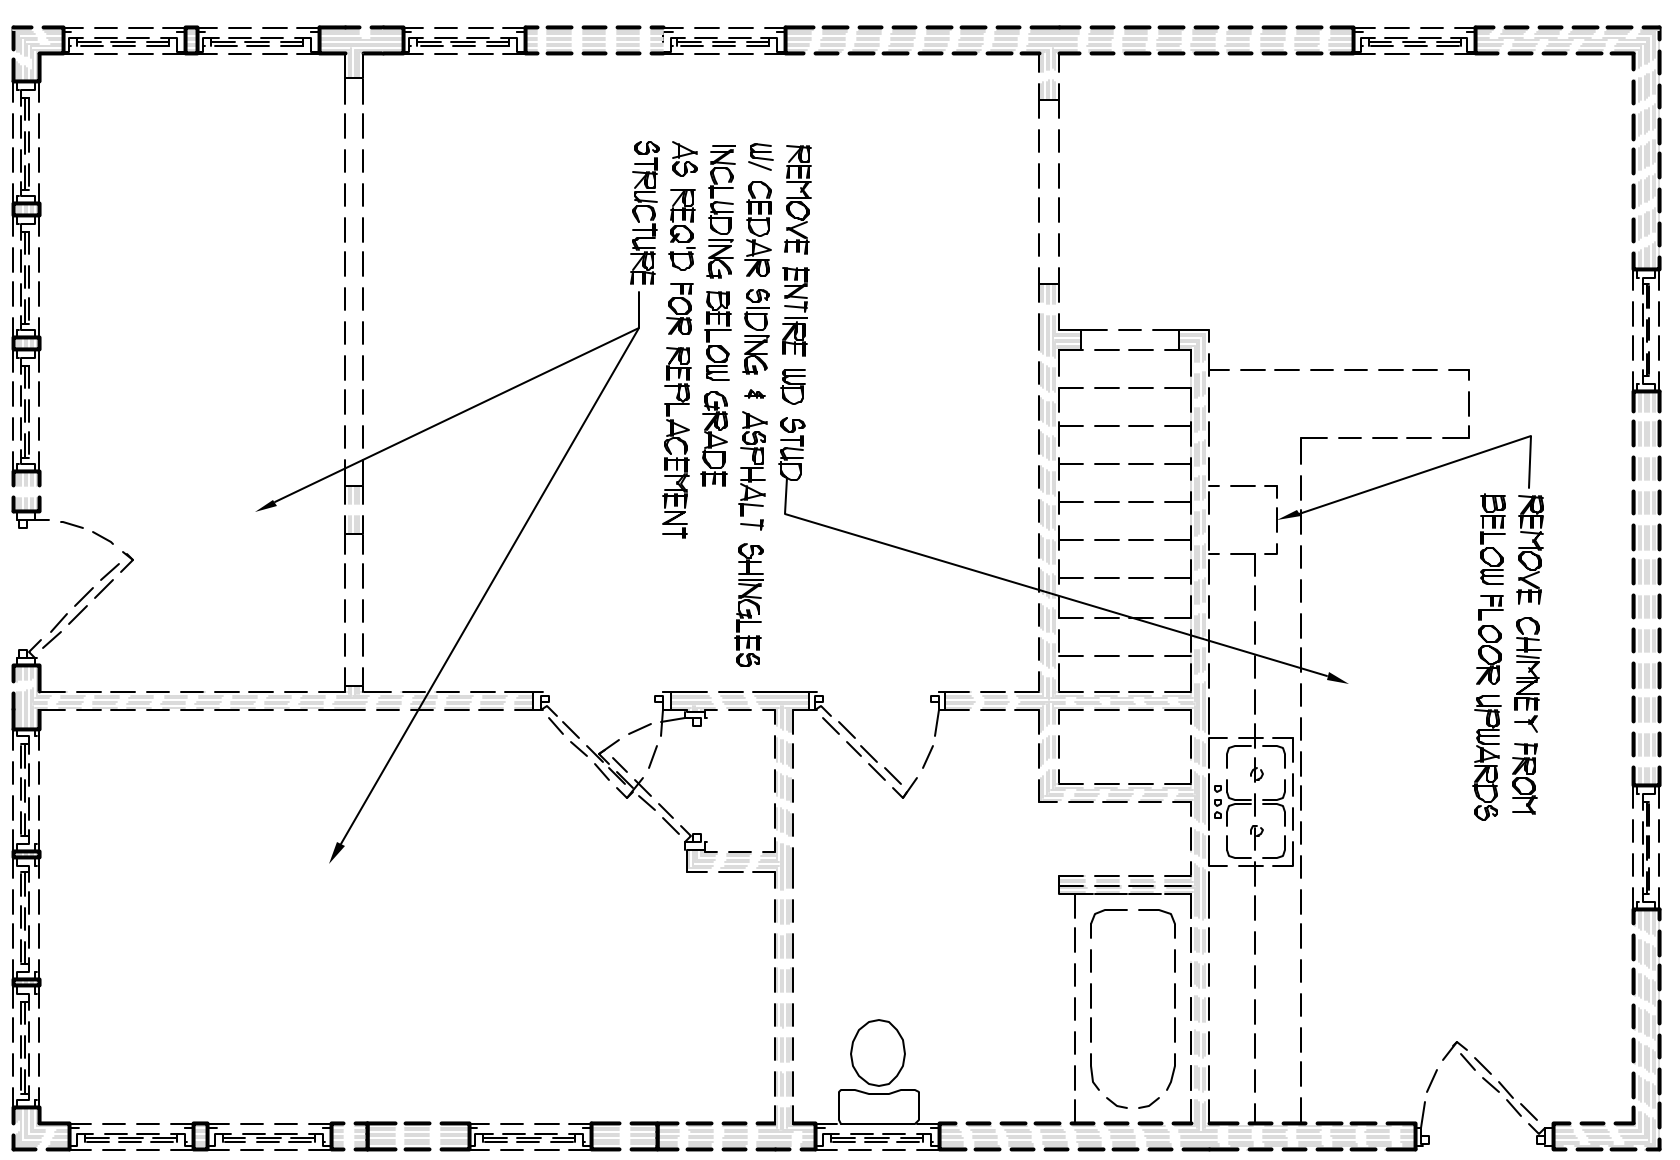

**PORT & GUTZ**  
ARCHITECTURE  
55 NEWBURY STREET  
PORTLAND, ME 04101  
fax 207.751.9000  
info@portandgutz.com

CONSULTANTS

**Zukowski & Espino**  
Residence  
52 Berwick  
Portland, Maine

NO.	DATE	DESCRIPTION	REVISIONS
1		Design Review	
2		DATE	
3		DATE	
4		DATE	
5		DATE	
6		DATE	
7		DATE	
8		DATE	
9		DATE	
10		DATE	

**DEMO PLAN FOR**  
FIRST FLOOR

D1