

DESIGNER

CWS ARCHITECTS  
ARCHITECTURE | INTERIOR DESIGN  
434 CUMBERLAND AVENUE  
PORTLAND, MAINE 04101  
T: 207.774.4441  
F: 207.774.4016  
WWW.CWSARCH.COM

OWNER

NORTHFIELD GREEN  
HOUSING PARTNERS LP.

ONE CITY CENTER, 4TH FLOOR  
PORTLAND, MAINE 04101

PROJECT

NORTHFIELD GREEN

147 - 151 ALLEN AVENUE  
PORTLAND, MAINE 04101

DRAWING

BUILDING NO. 149  
FIRST FLOOR FINISHES  
PLAN

CWS PROJECT NUMBER: 16.010

REVISIONS

NO.	DESCRIPTION

DRAWING NUMBER

A9.21



SCALE: AS NOTED  
DATE: 11/22/2017

**FLOOR FINISH LEGEND**

	ENTRY MAT		CARPET BROADLOOM, CPT3
	RESILIENT PLANK		CARPET TILE, CPT4
	RESILIENT FLOORING		CARPET TILE, CPT5
	CARPET BROADLOOM, CPT1		CARPET PLANK, CPT6
	CARPET BROADLOOM, CPT2		

**GENERAL FLOOR FINISH NOTES**

1. REFERENCE FLOOR FINISH LEGEND & SCHEDULE FOR MATERIALS AND LOCATIONS.
2. EXTEND FLOOR FINISHES UNDER WALL BASE, CASEWORK, COUNTERTOPS AND ALL PLUMBING FIXTURES. TYPICAL ALL SPACES.
3. PREPARE EXISTING SLAB AND UNDERLAYMENT AS REQUIRED PER FLOORING MANUFACTURER'S REQUIREMENTS PRIOR TO FLOOR FINISH INSTALLATIONS.
4. HATCH PATTERNS ARE A GRAPHICAL REPRESENTATION OF THE FLOORING PATTERNS. REFERENCE INTERIOR FINISH LEGEND AND SPECIFICATIONS, TBD.

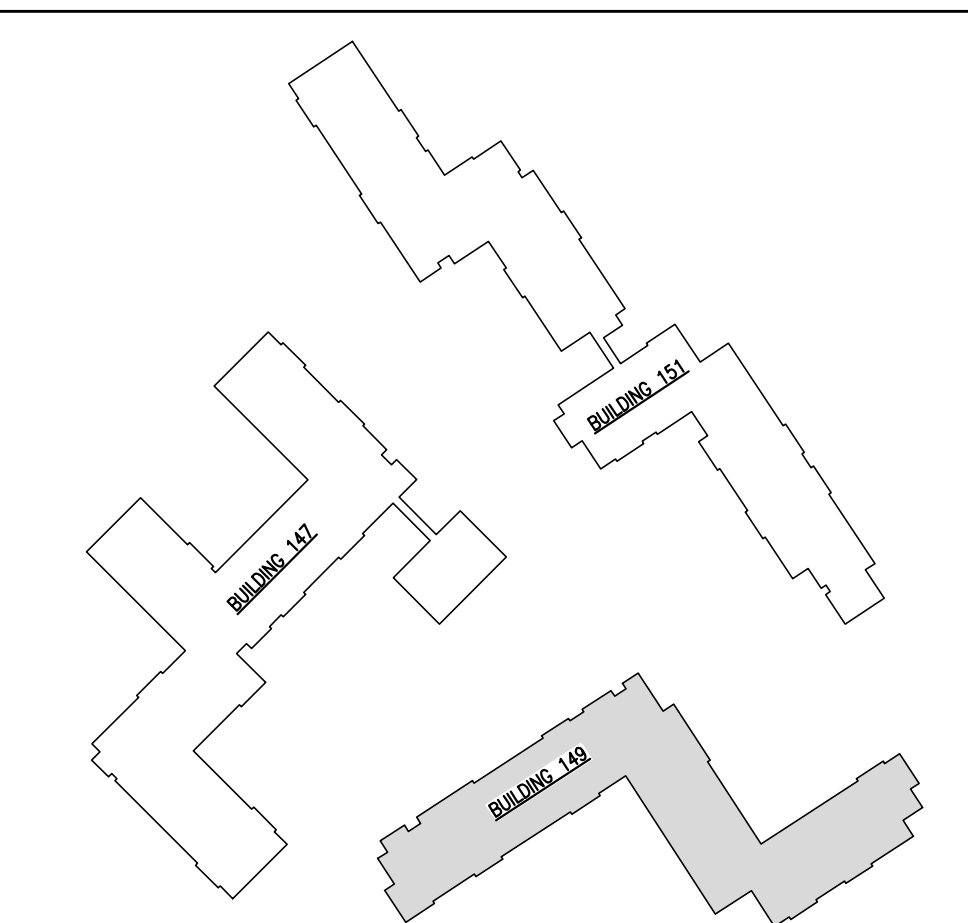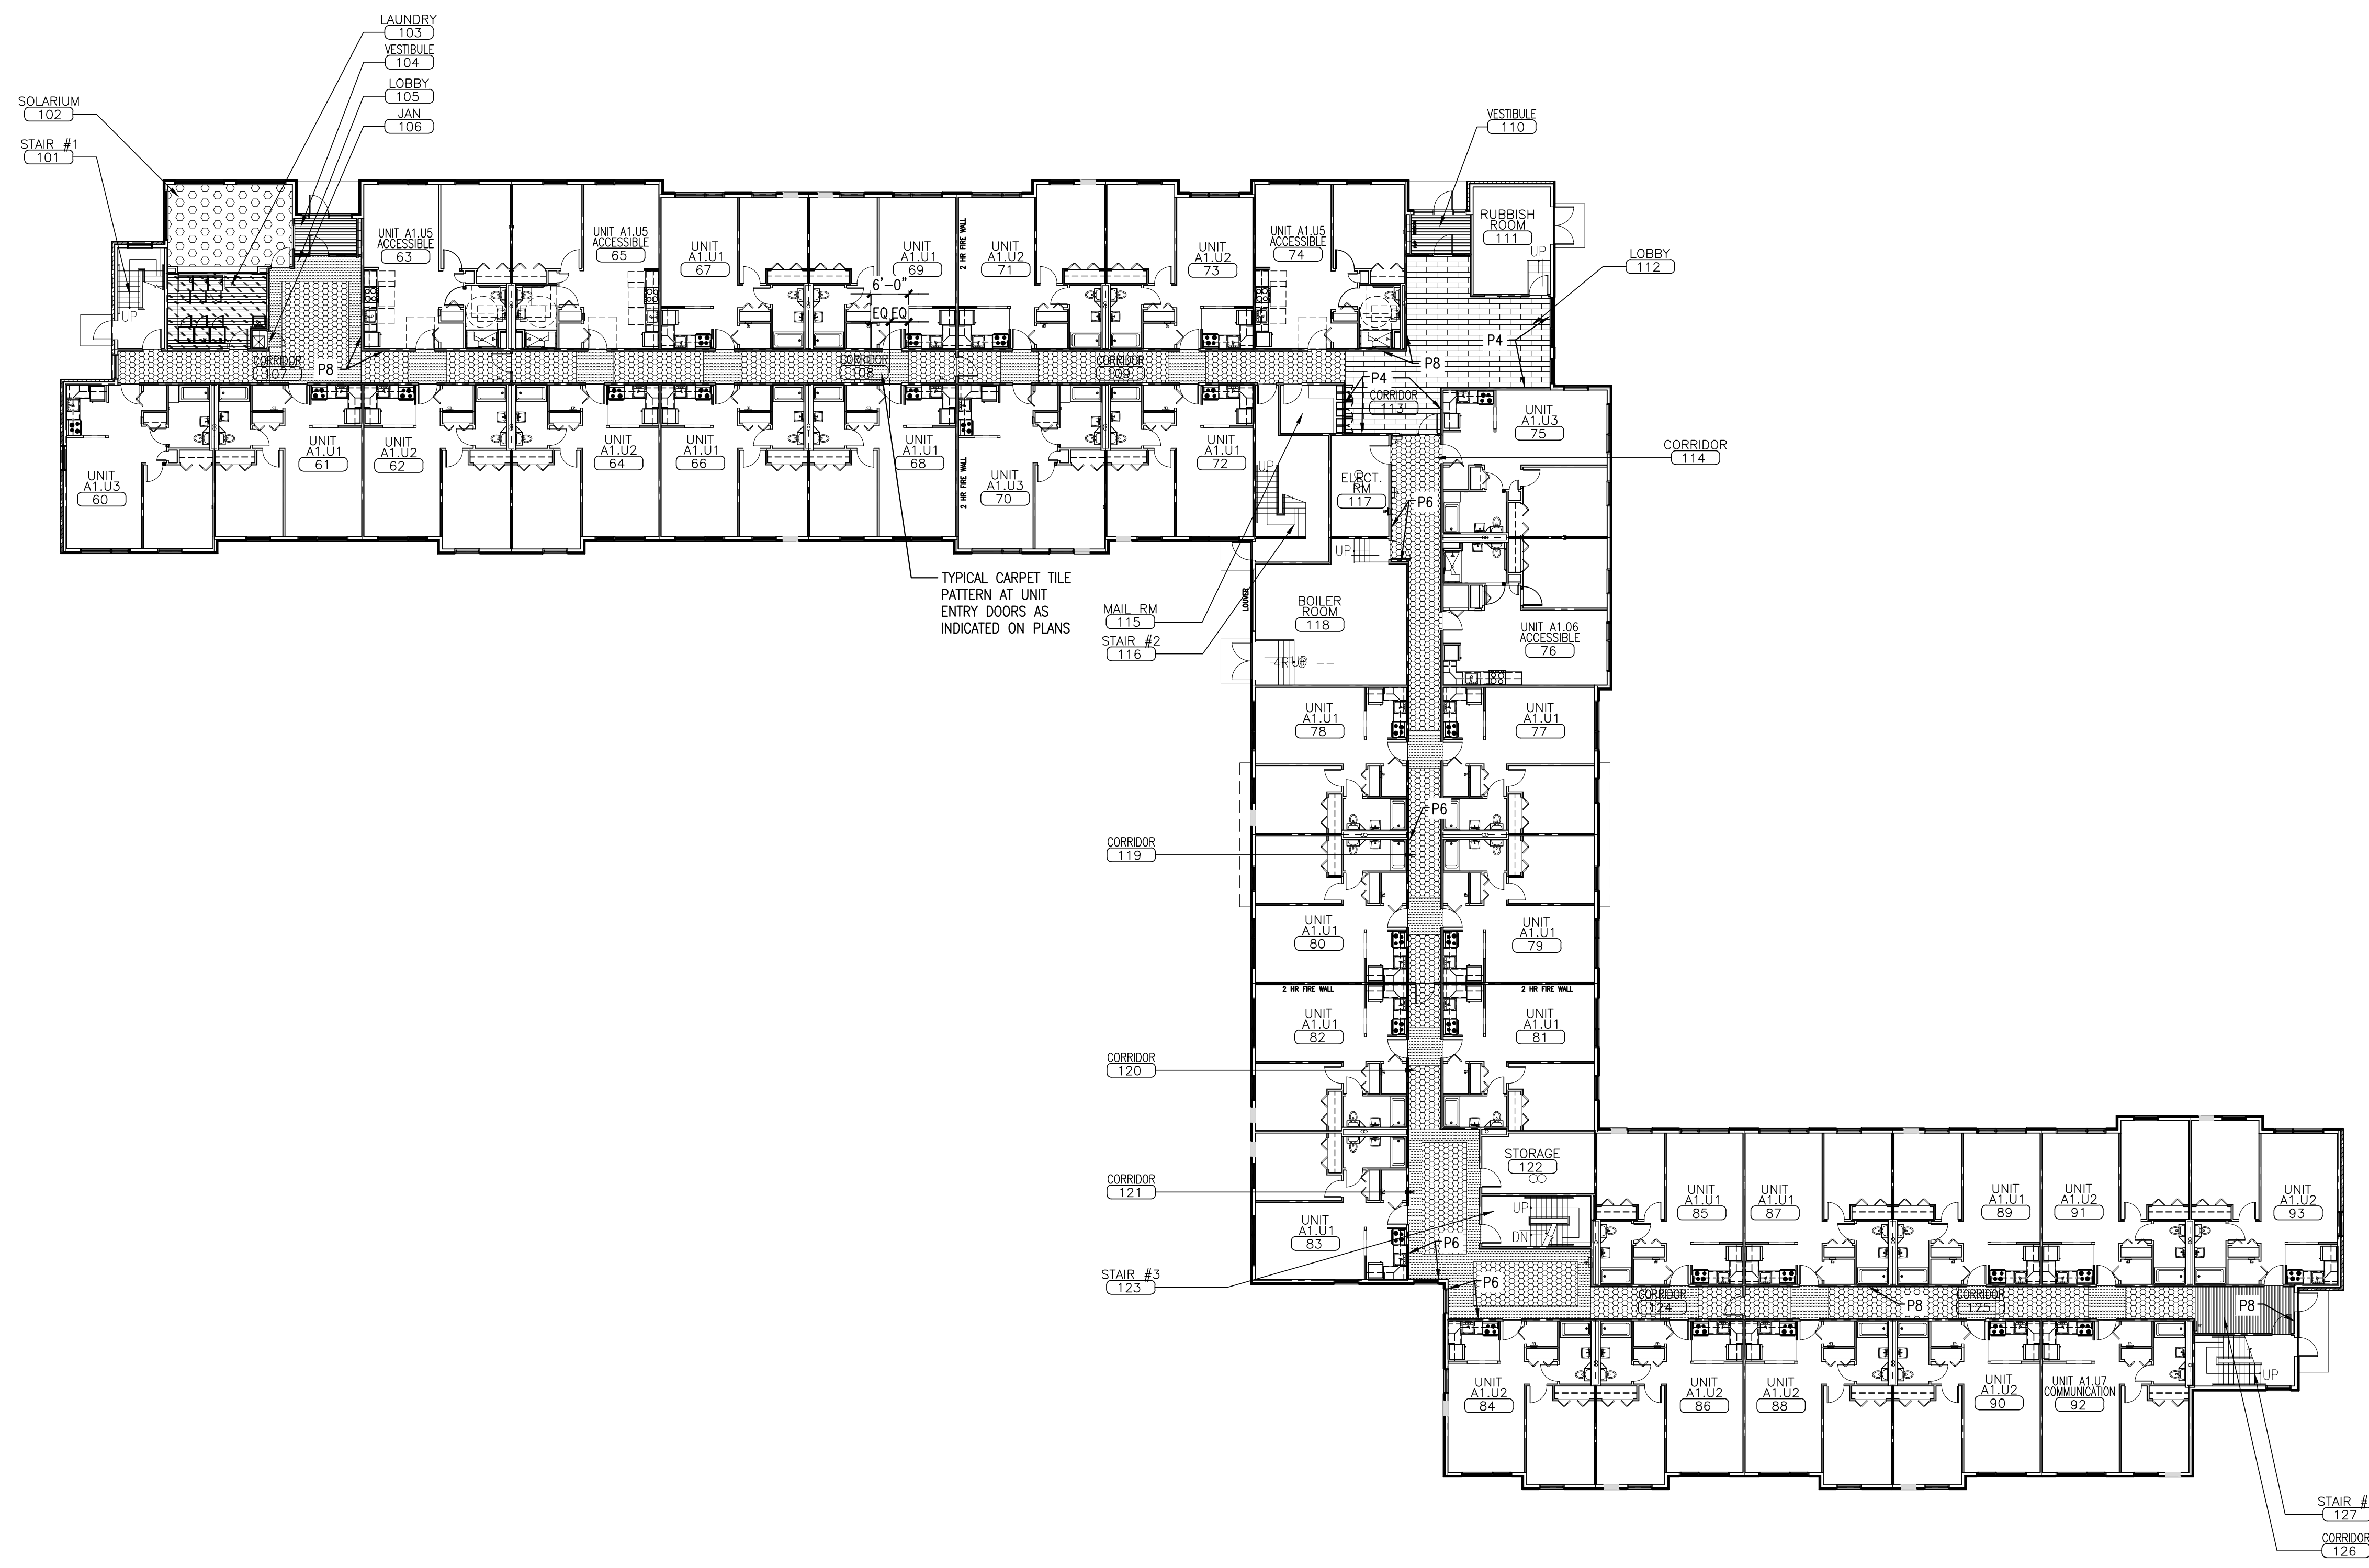

**A5** BUILDING NO. 149 - FIRST FLOOR FINISHES PLAN  
REFERENCED FROM: TP2 SCALE: 1/16" = 1'-0"

**G5** KEY PLAN AND FINISH LEGEND  
REFERENCED FROM: PLANS SCALE: NTS