

- ① REMOVE EXISTING WATER CLOSET, INSTALL PROPOSED WATER CLOSET (P-1) IN THE SAME LOCATION
- ② REPLACE LAVATORY FAUCET AERATOR (ONLY) WITH 0.5GPM AERATOR
- ③ REPLACE SHOWER VALVE CARTRIDGE (SYMONS), REPLACE HAND-HELD SHOWER HEAD (2.0 GPM), SHOWER ARM MOUNT AND HOSE (P-3)


- ④ REMOVE AND REINSTALL KITCHEN SINK, REPLACE KITCHEN SINK FAUCET AERATOR (ONLY) WITH 1.5GPM AERATOR
- ⑤ REMOVE EXISTING WATER CLOSET, INSTALL PROPOSED ADA WATER CLOSET (P-1A) IN THE PROPOSED LOCATION, EXTEND CW, SAN AND VENT AS NECESSARY

- ⑥ RELOCATE EXISTING LAVATORY TO PROPOSED LOCATION, REPLACE LAVATORY FAUCET AERATOR (ONLY) WITH 0.5GPM AERATOR, EXTEND HW, CW, SAN AND VENT AS NECESSARY
- ⑦ REMOVE EXISTING TUB/SHOWER, INSTALL PROPOSED ADA ROLL-IN SHOWER (P-3A) IN THE PROPOSED LOCATION, EXTEND HW, CW, SAN AND VENT AS NECESSARY

- ⑧ RELOCATE REINSTALL KITCHEN SINK TO PROPOSED LOCATION, REPLACE KITCHEN SINK FAUCET AERATOR (ONLY) WITH 1.5GPM AERATOR
- ⑨ REMOVE EXISTING THERMOSTATIC RADIATOR VALVE, INSTALL ELECTRIC CONTROL VALVE AND THERMOSTAT, NOTE - EXACT FINITUBE CONFIGURATION MAY VARY FROM UNIT TO UNIT DEPENDING ON PLACEMENT WITHIN THE BUILDING AND EXTERIOR EXPOSURE.

- ⑩ REPLACE EXHAUST FAN WITH 8x8 METALAIRE SRH STEEL EXHAUST GRILLE WITH CRD, CONNECT TO EXISTING DUCT AND BALANCE TO 50 CFM, CLEAN DUCT BETWEEN GRILLE AND ATTIC (TYP OF ALL UNITS)
- ⑪ REMOVE EXISTING FAN, INSTALL METALAIRE SRH EXHAUST GRILLE, CONNECT TO EXISTING DUCT TO ATTIC (TYP FOR ALL UNITS) CLEAN DUCT FROM UNIT TO ATTIC.

DESIGNER

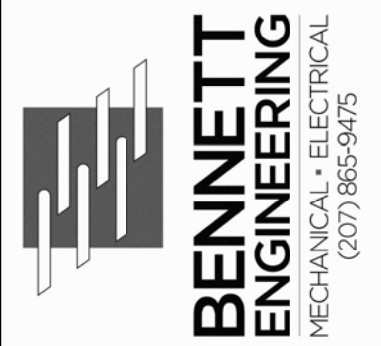

OWNER

NORTHFIELD GREEN HOUSING PARTNERS LP.
307 CUMBERLAND AVE
PORTLAND, MAINE 04101

PROJECT

NORTHFIELD GREEN
ALLEN AVENUE
PORTLAND, MAINE 04101


DRAWING

TYPICAL UNIT MECHANICAL AND PLUMBING PLANS
CWS PROJECT NUMBER: 16.010


REVISIONS

PROGRESS PRINT NOT FOR CONSTRUCTION
--


DRAWING NUMBER
M2.01
SCALE: 1/4" = 1'-0"
DATE: 11/21/2017

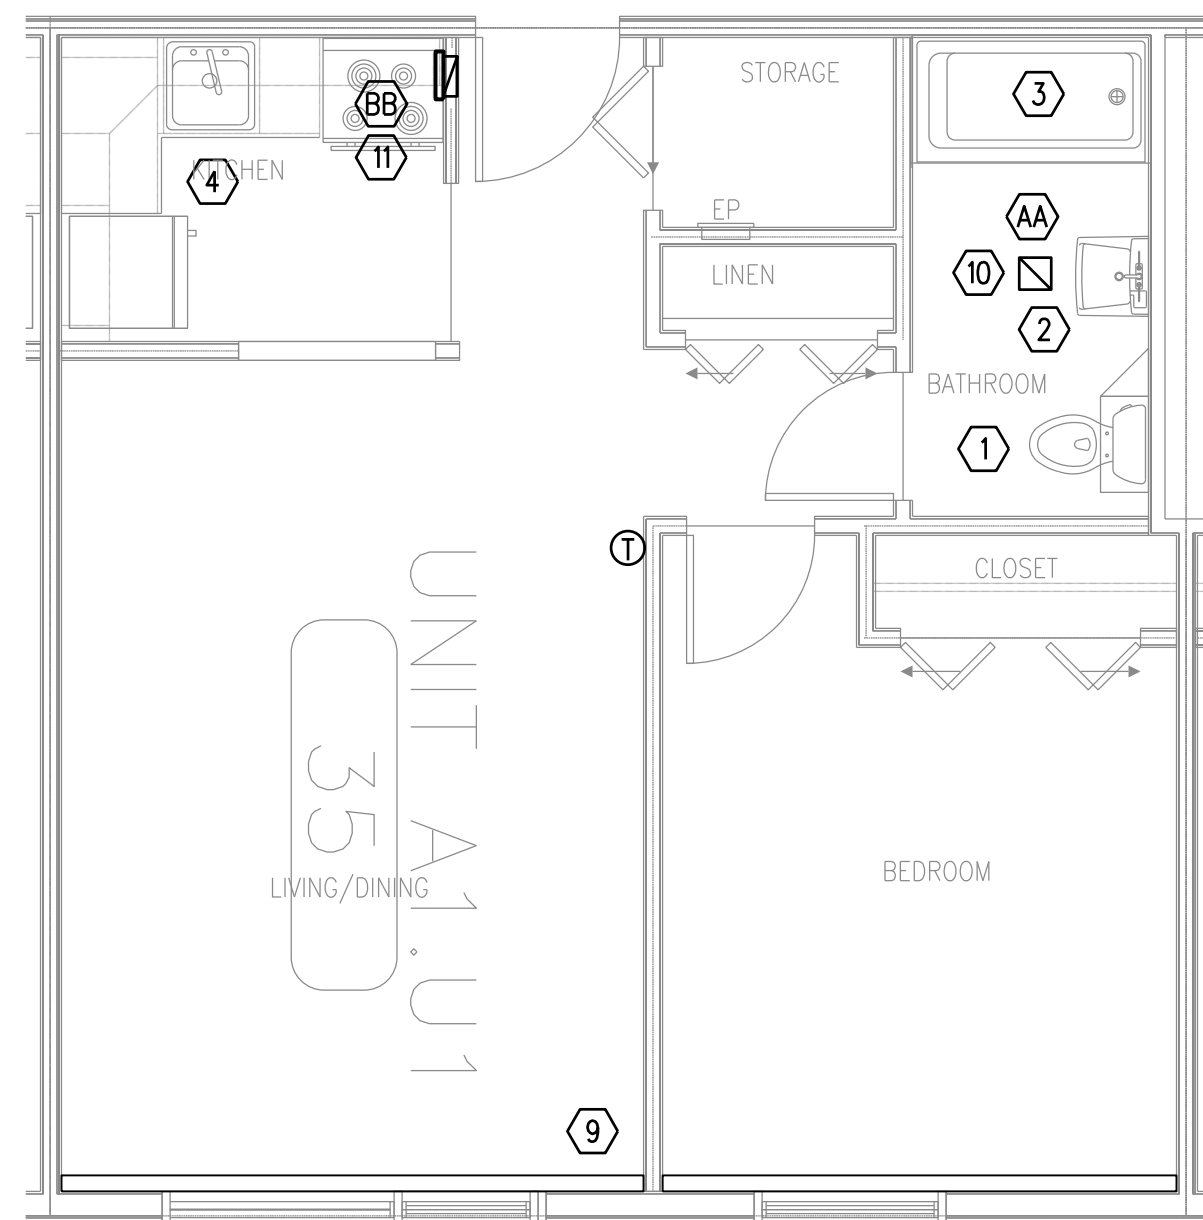


UNIT TYPE A1.U1 MECHANICAL AND PLUMBING PLAN
SCALE - 1/4" = 1'-0"

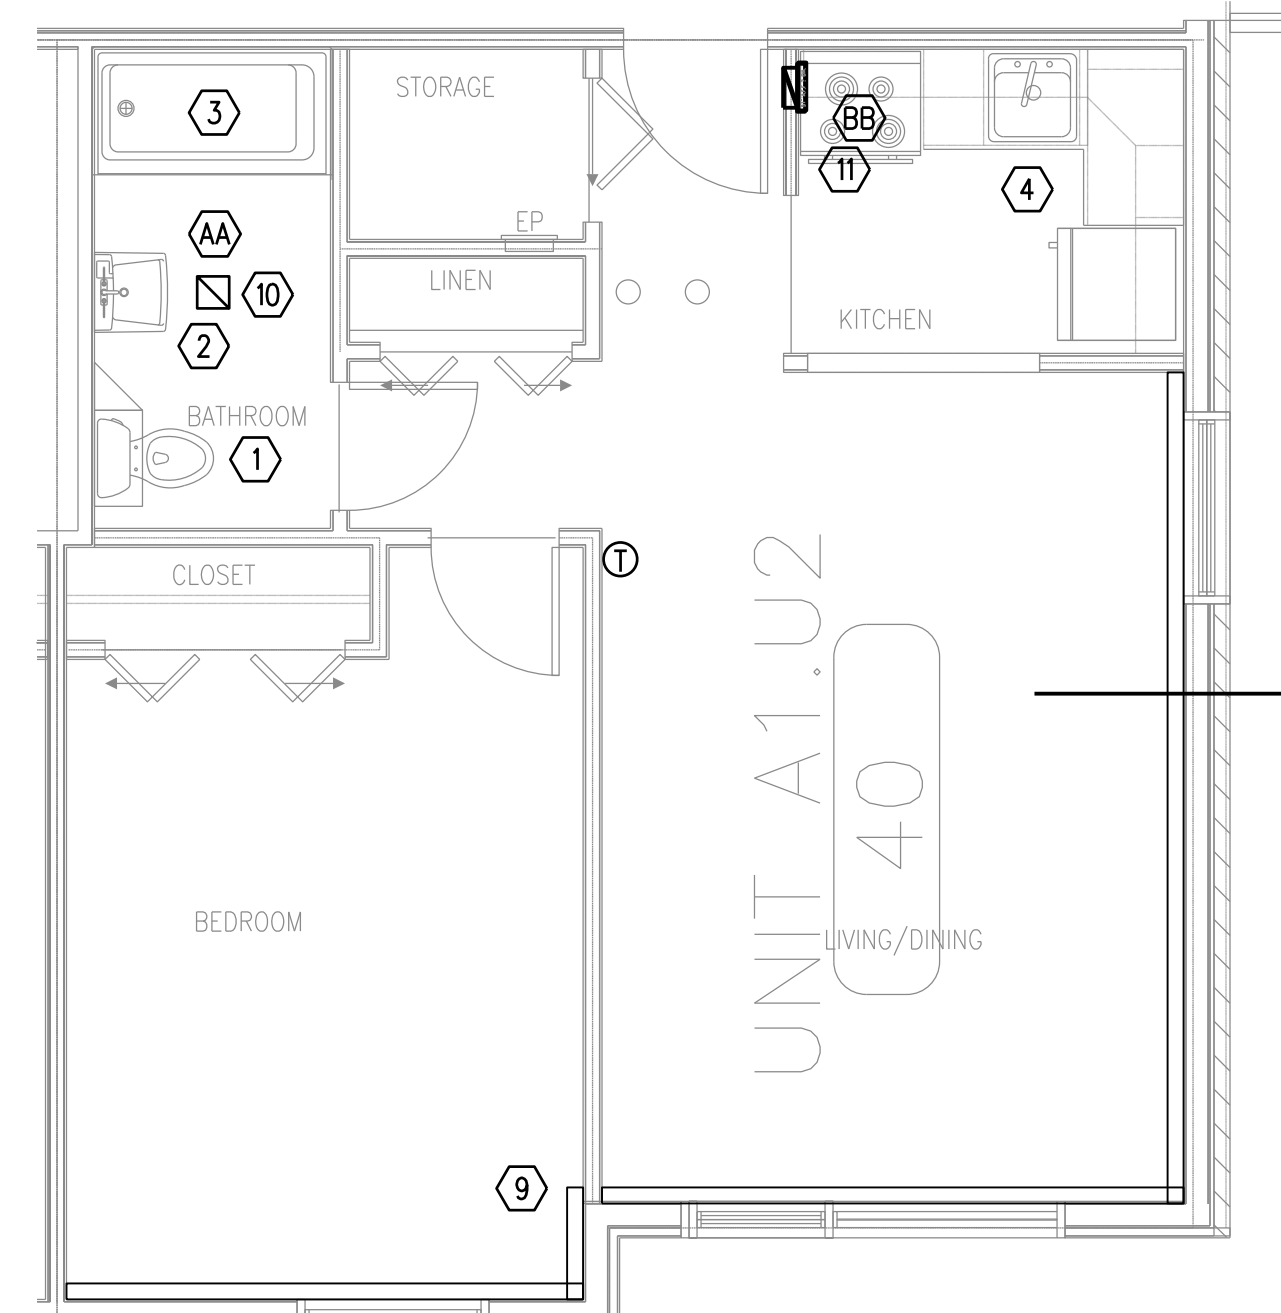


UNIT TYPE A1.U2 MECHANICAL AND PLUMBING PLAN
SCALE - 1/4" = 1'-0"

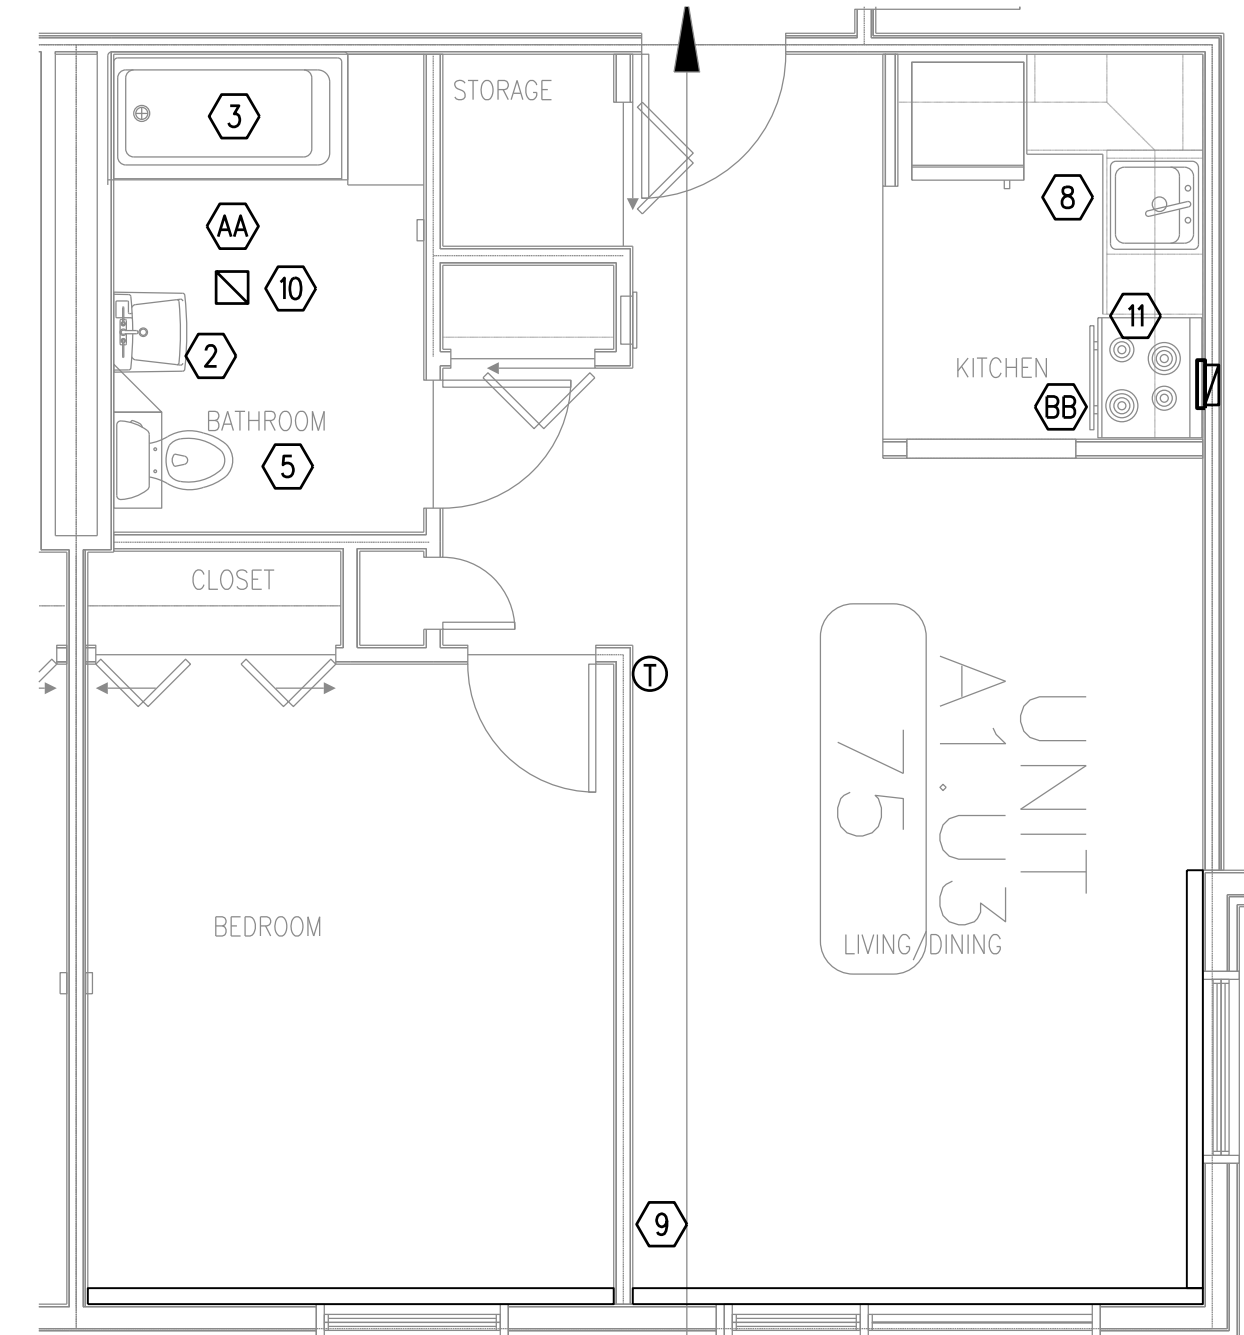


UNIT TYPE A1.U3 MECHANICAL AND PLUMBING PLAN
SCALE - 1/4" = 1'-0"

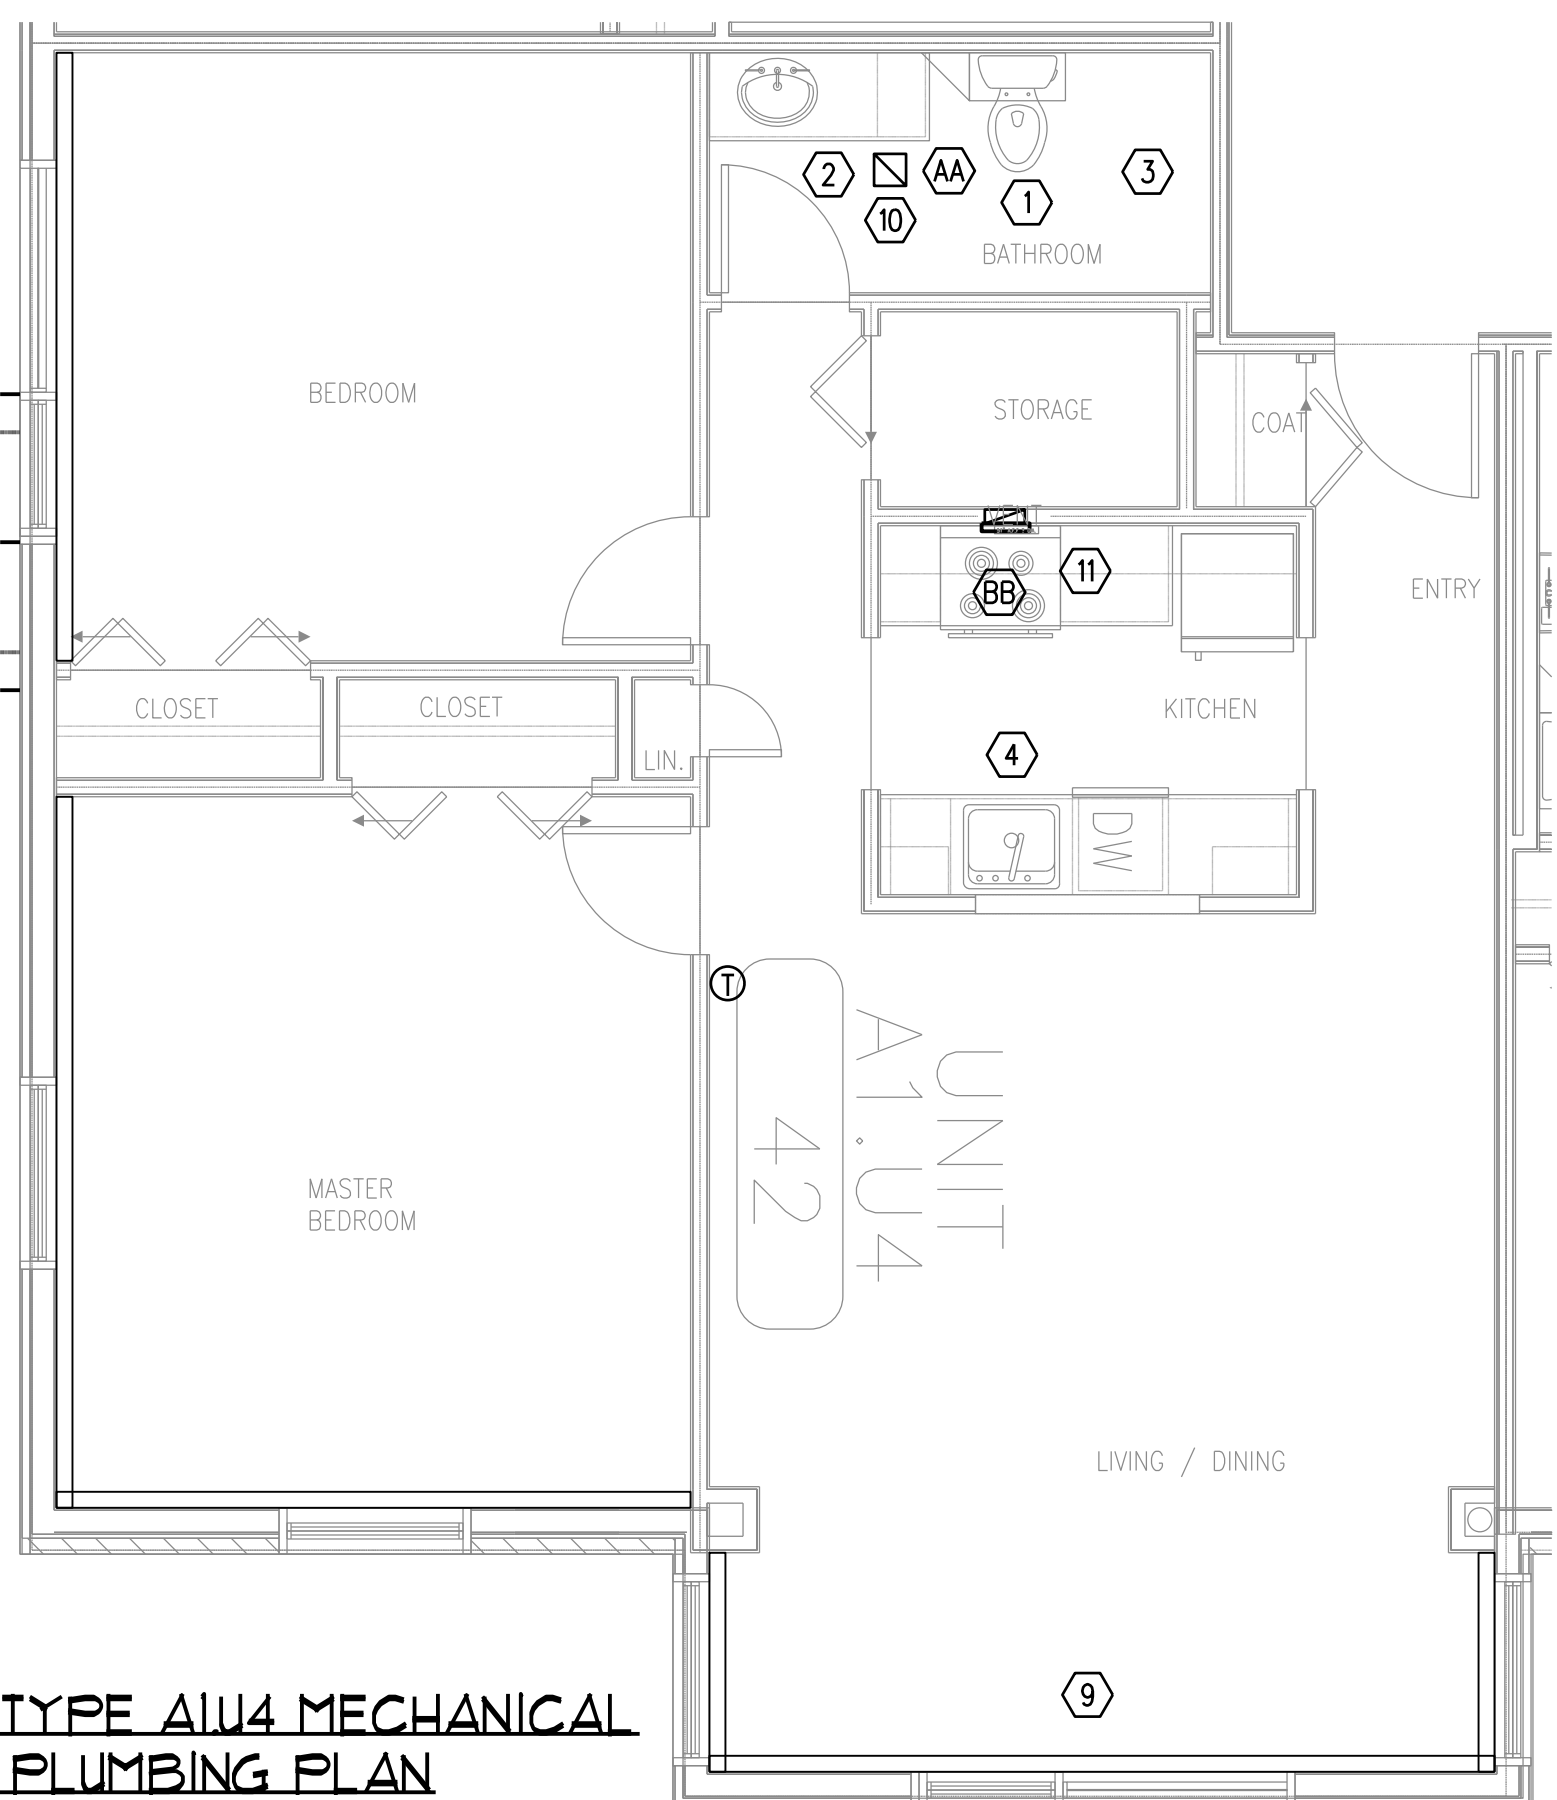

UNIT TYPE A1.U4 MECHANICAL AND PLUMBING PLAN
SCALE - 1/4" = 1'-0"

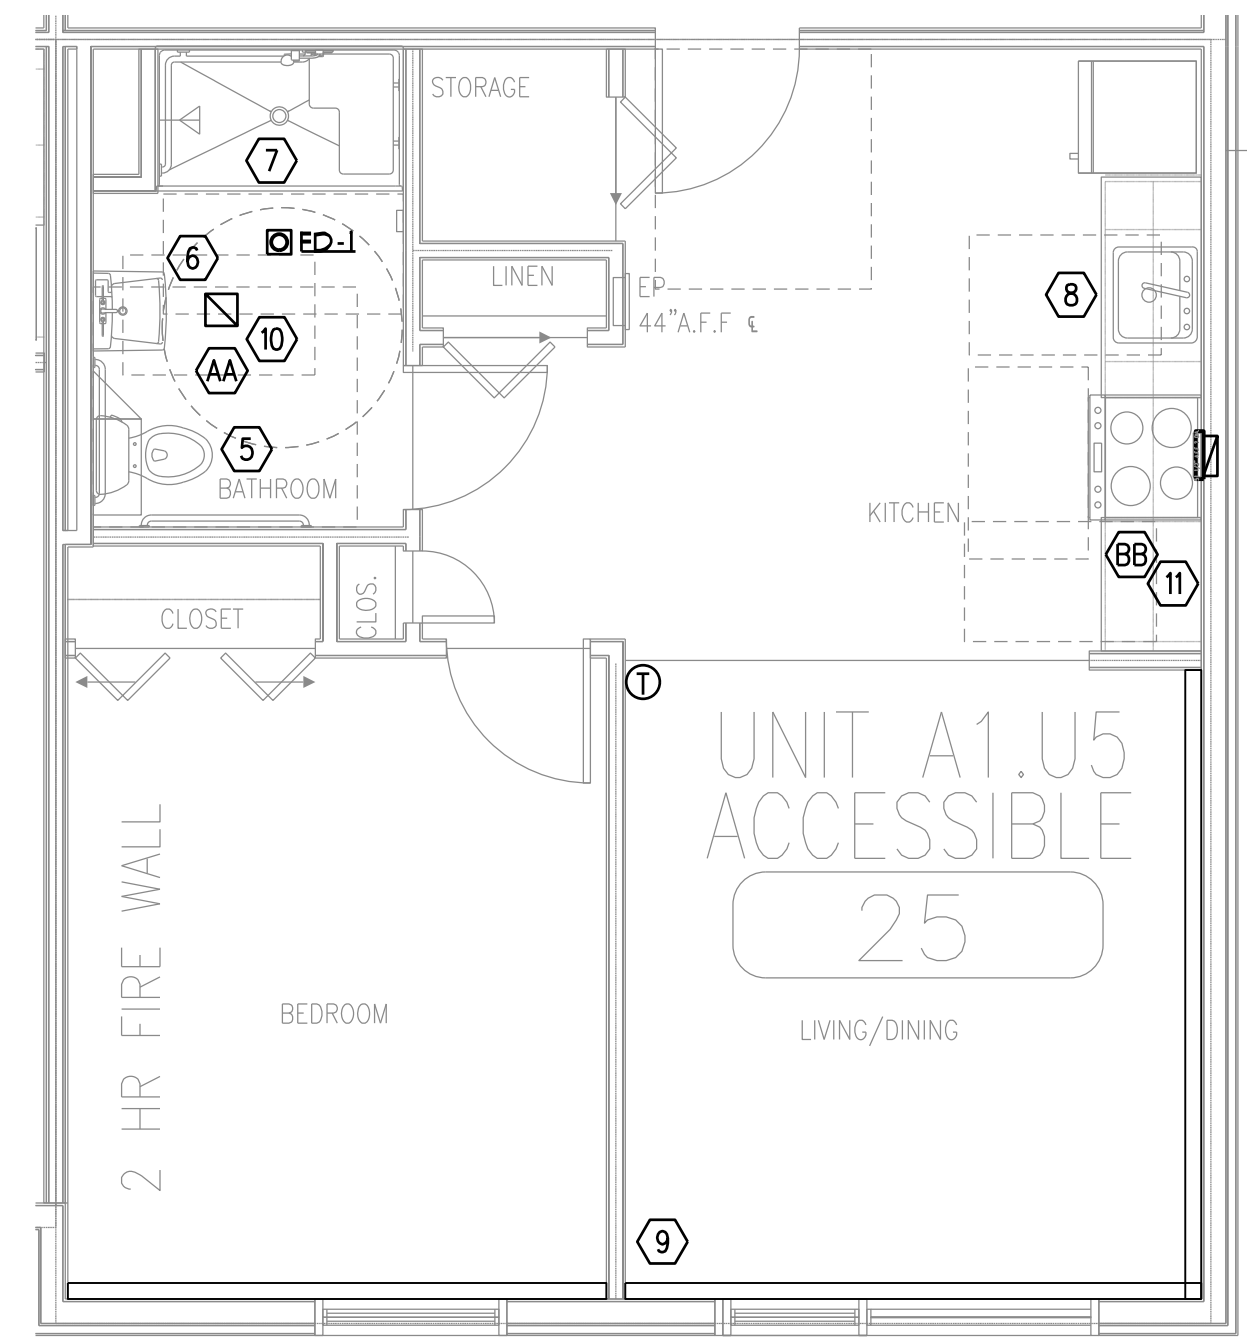

UNIT TYPE A1.U5 MECHANICAL AND PLUMBING PLAN
SCALE - 1/4" = 1'-0"

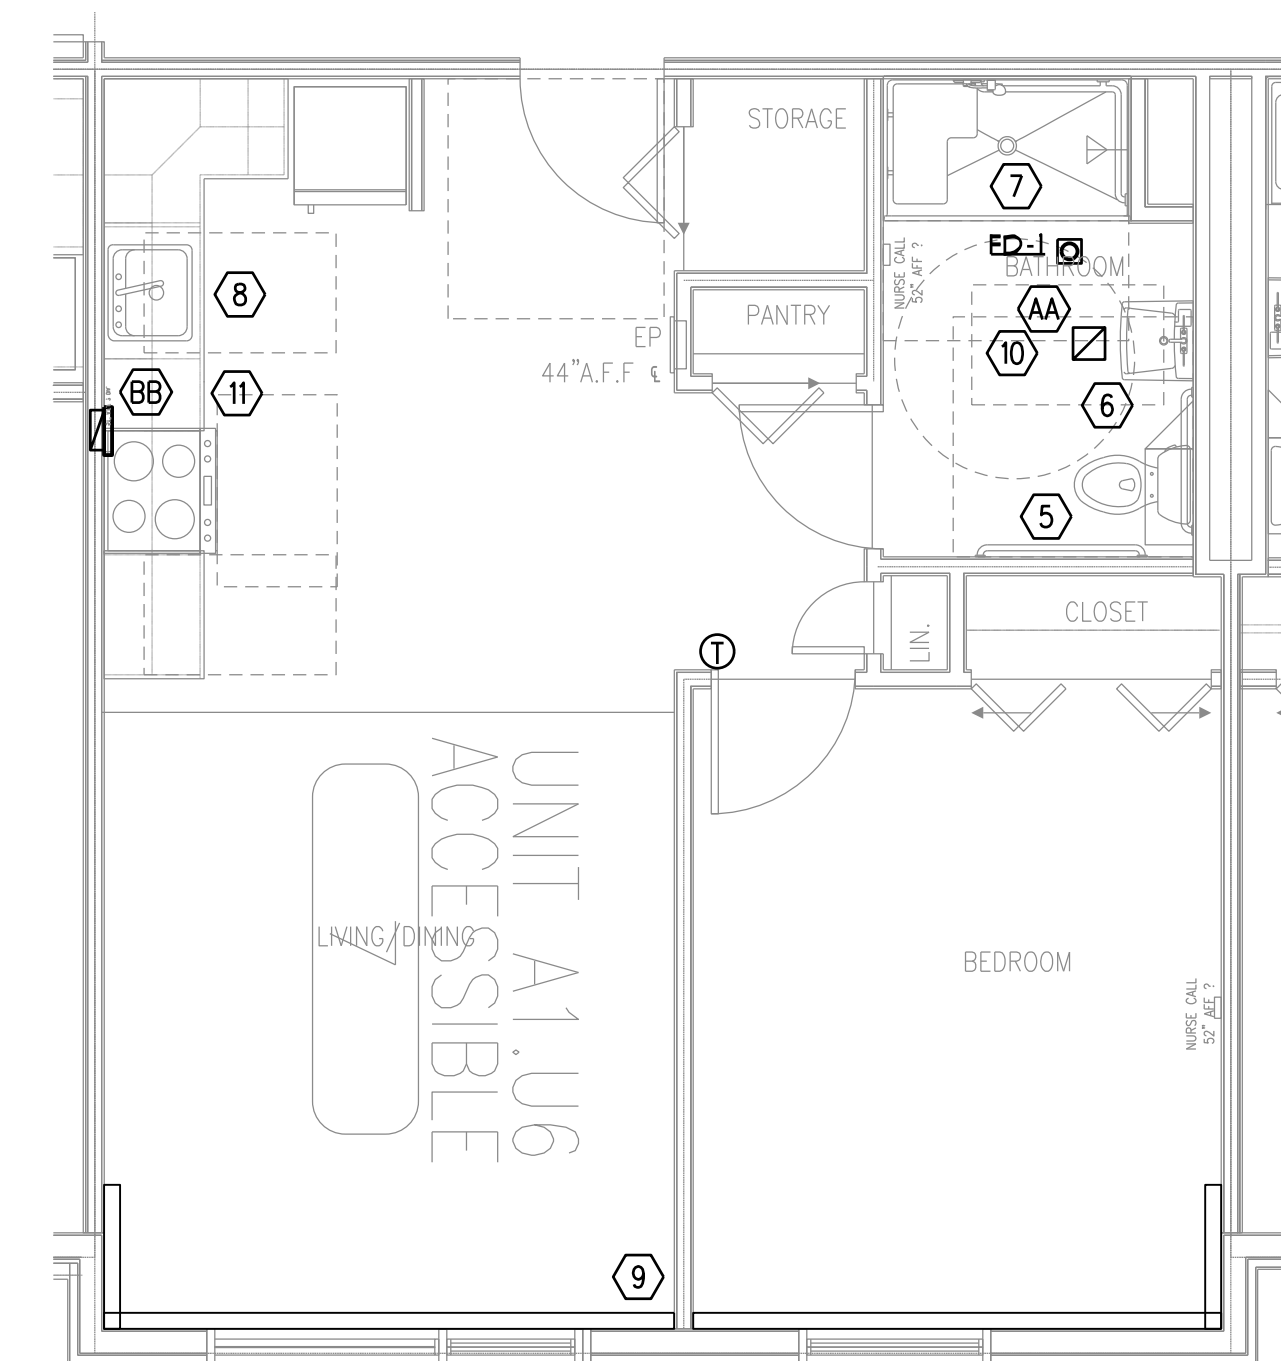

UNIT TYPE A1.U6 MECHANICAL AND PLUMBING PLAN
SCALE - 1/4" = 1'-0"