




1 PROPOSED LAYOUT
SCALE: 1/4" = 1'-0"

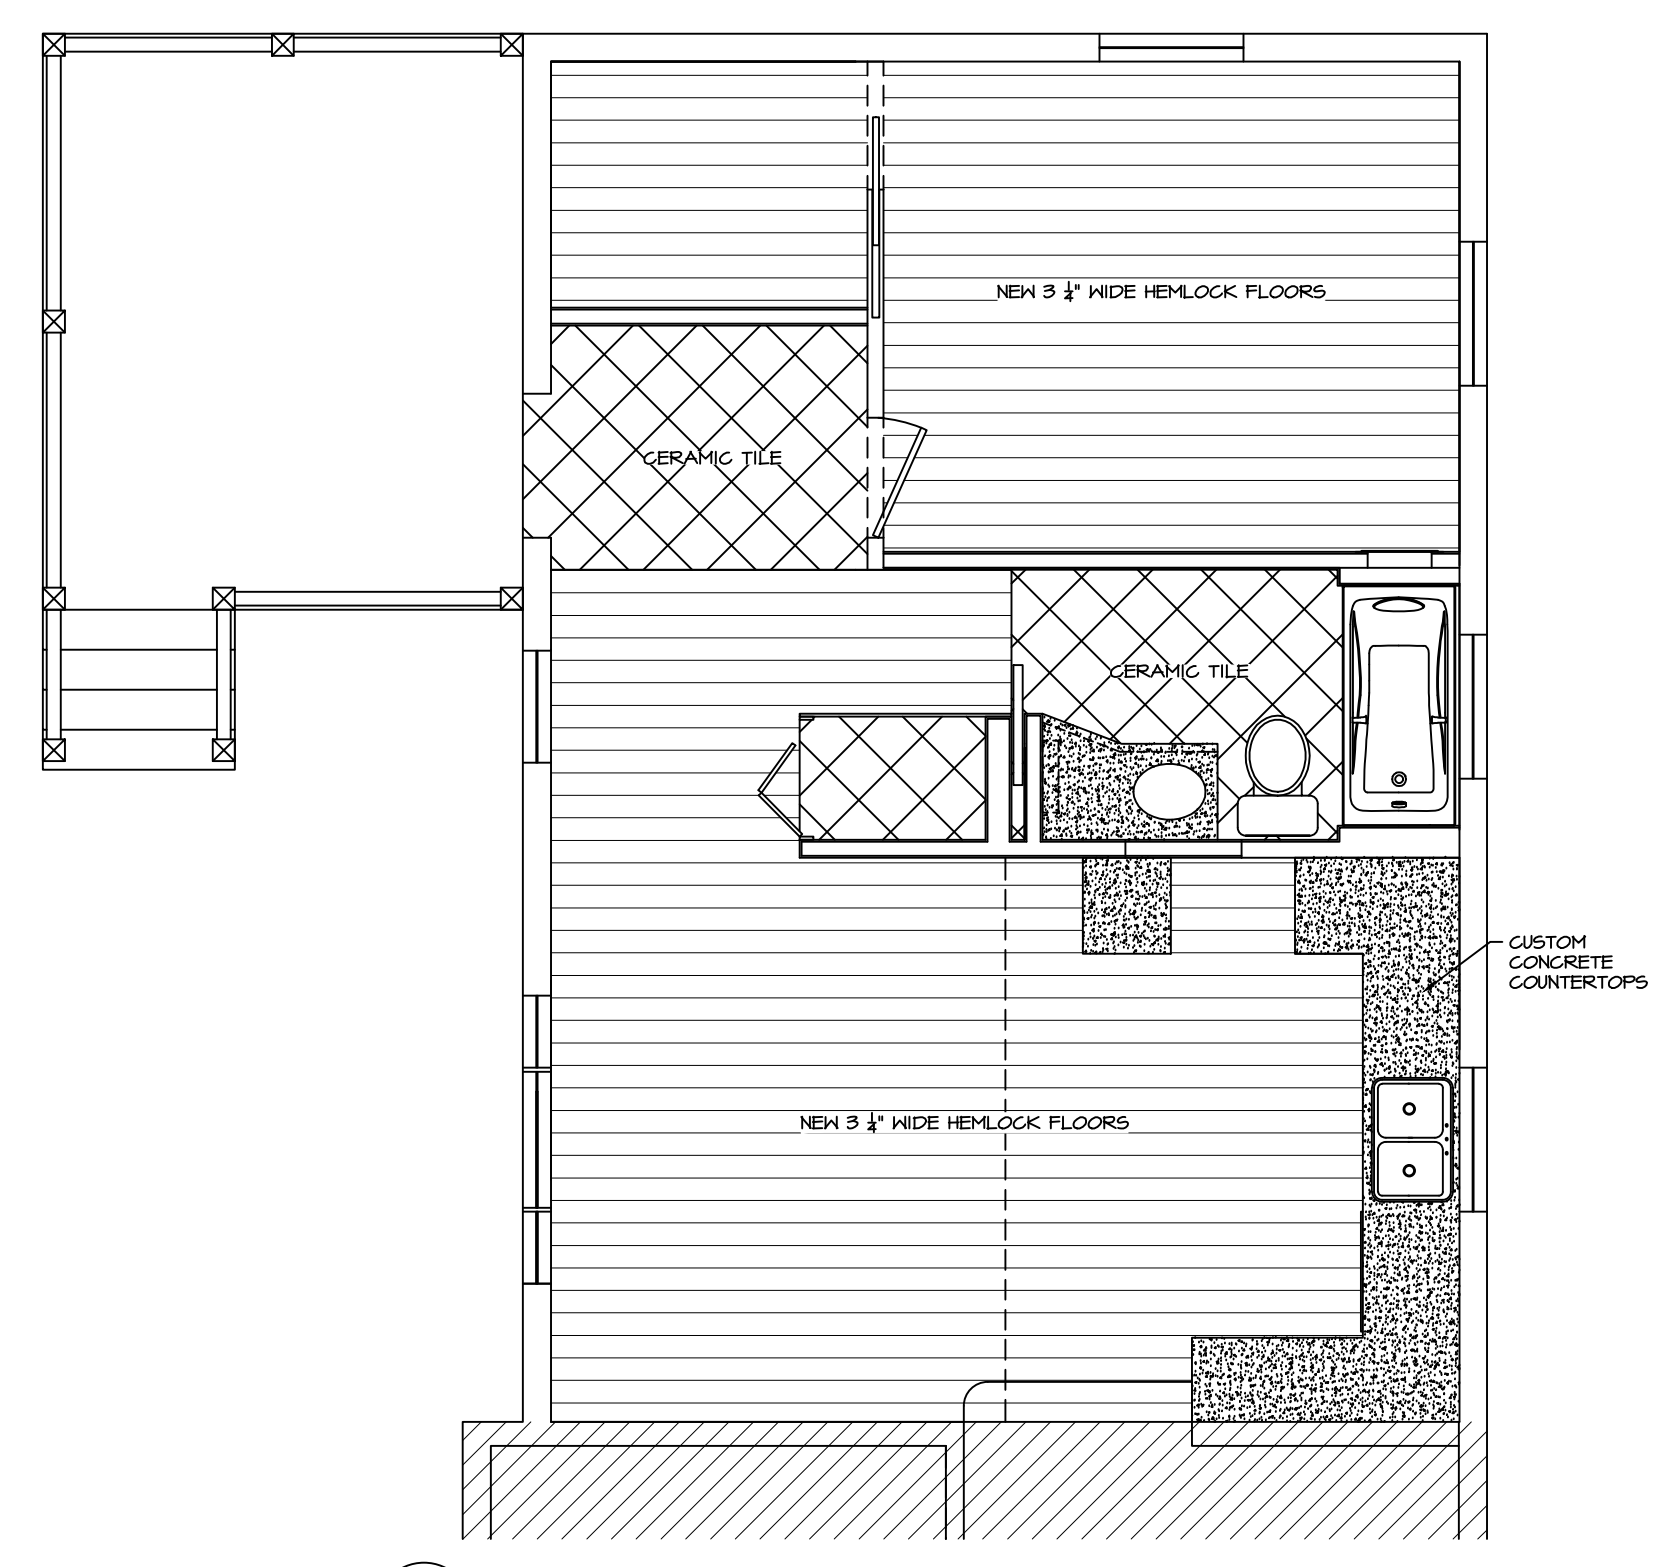


2 FINISH SCHEDULE
SCALE: 1/4" = 1'-0"

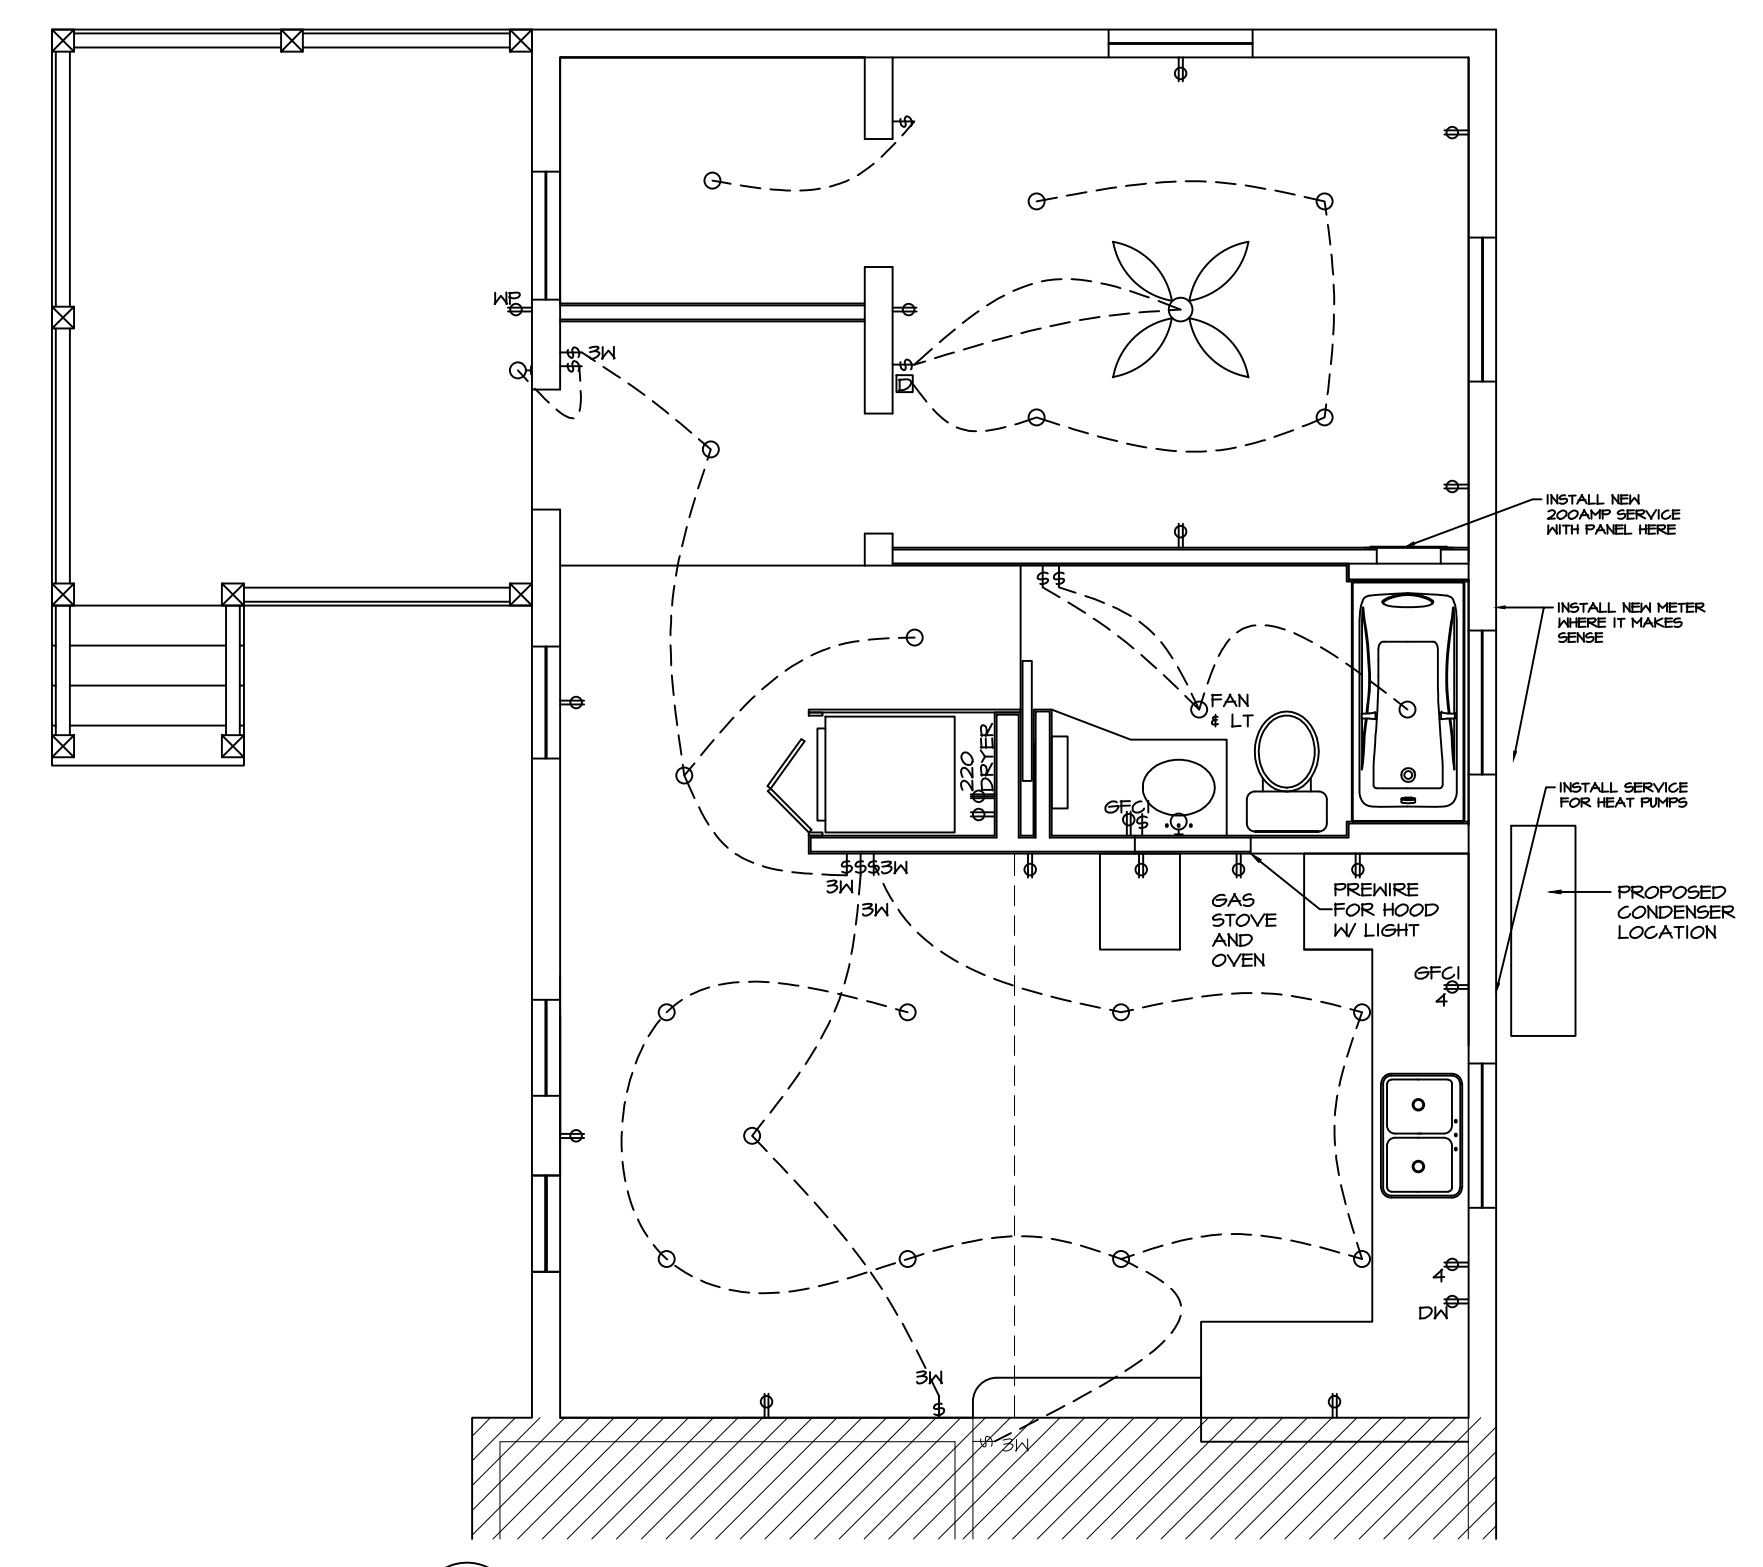


3 PROPOSED ELECTRICAL LAYOUT
SCALE: 1/4" = 1'-0"

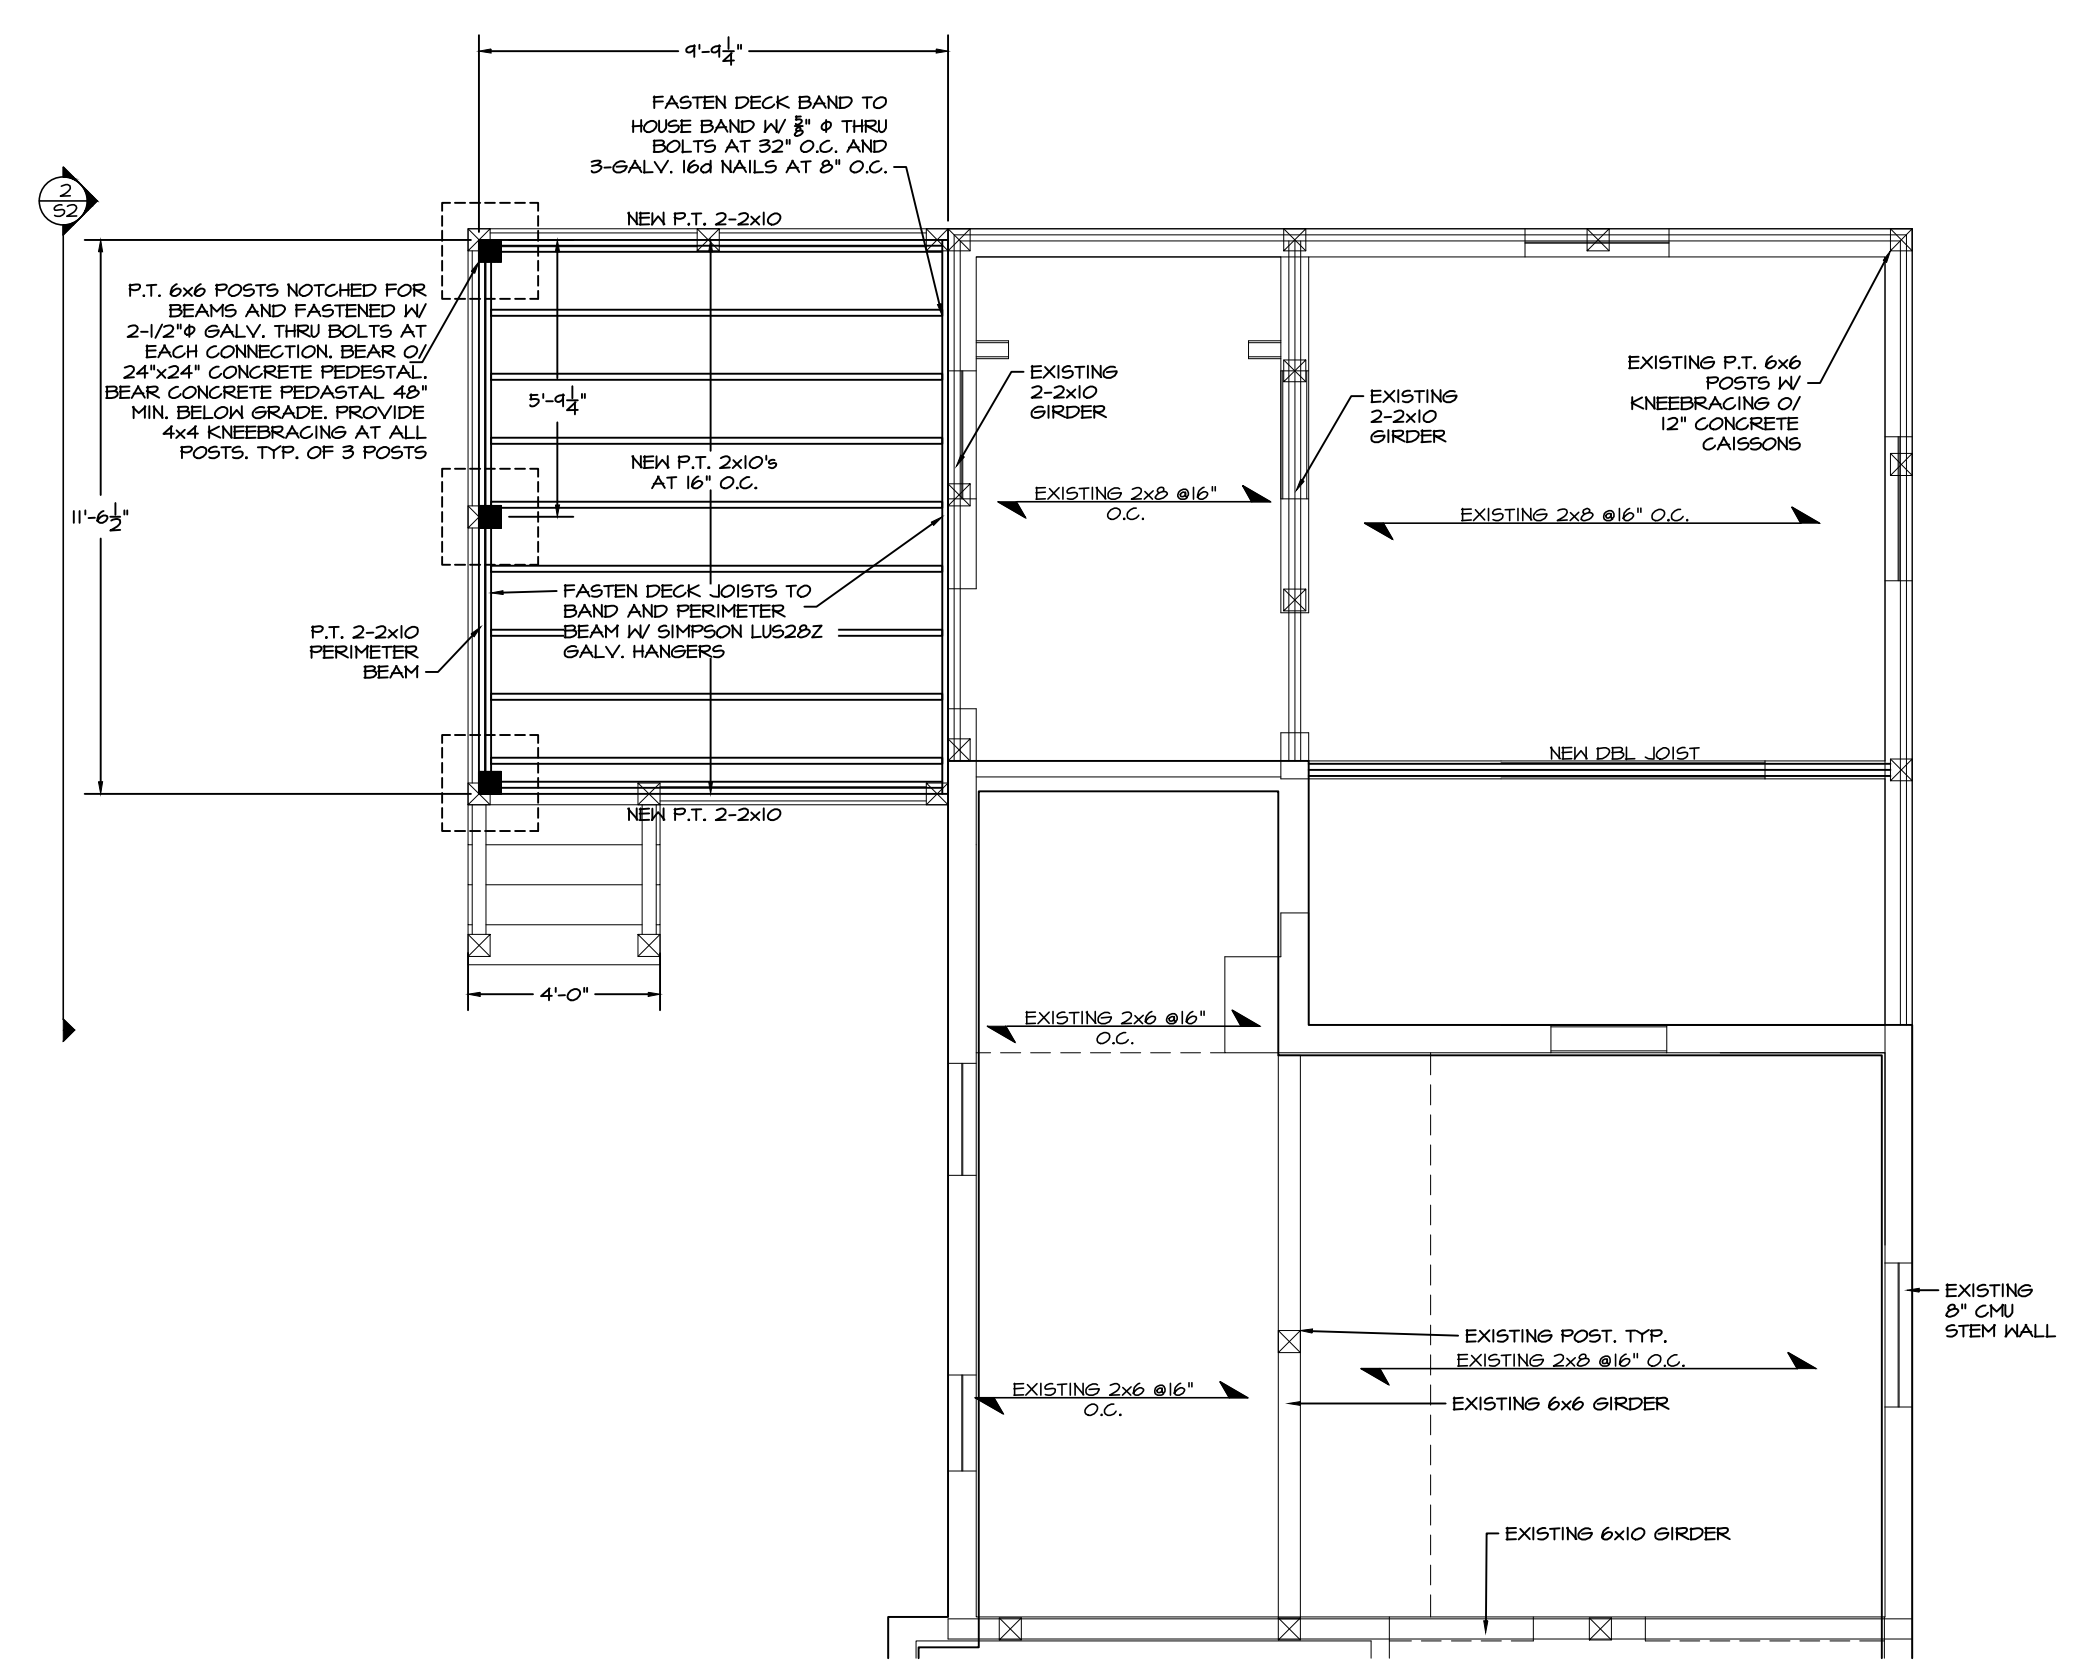

4 FIRST FLOOR FRAMING REINF. PLAN
SCALE: 1/2" = 1'-0"

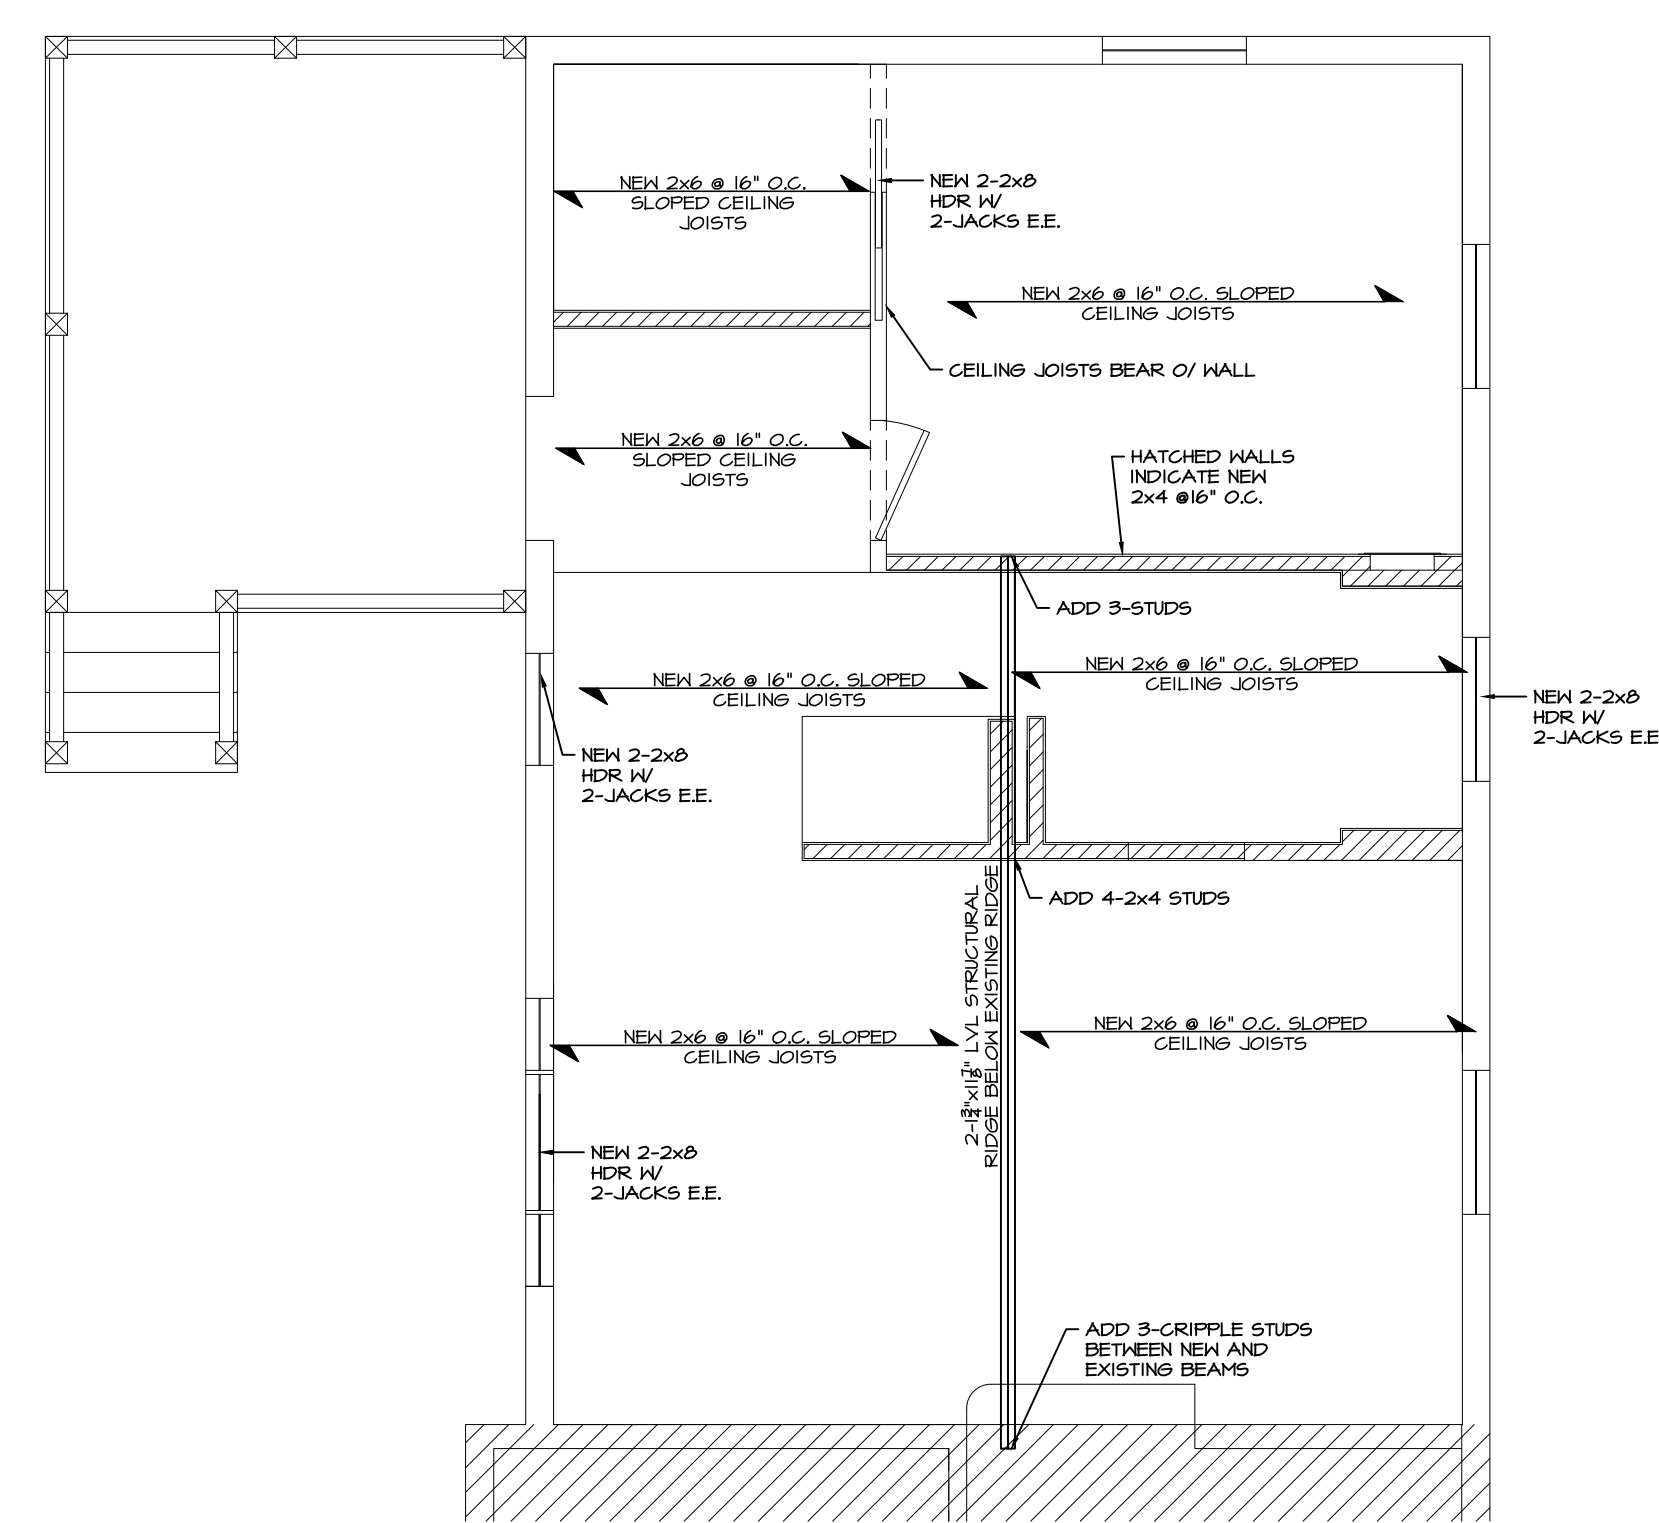

5 FIRST FLOOR CEILING FRAMING PLAN
SCALE: 1/2" = 1'-0"

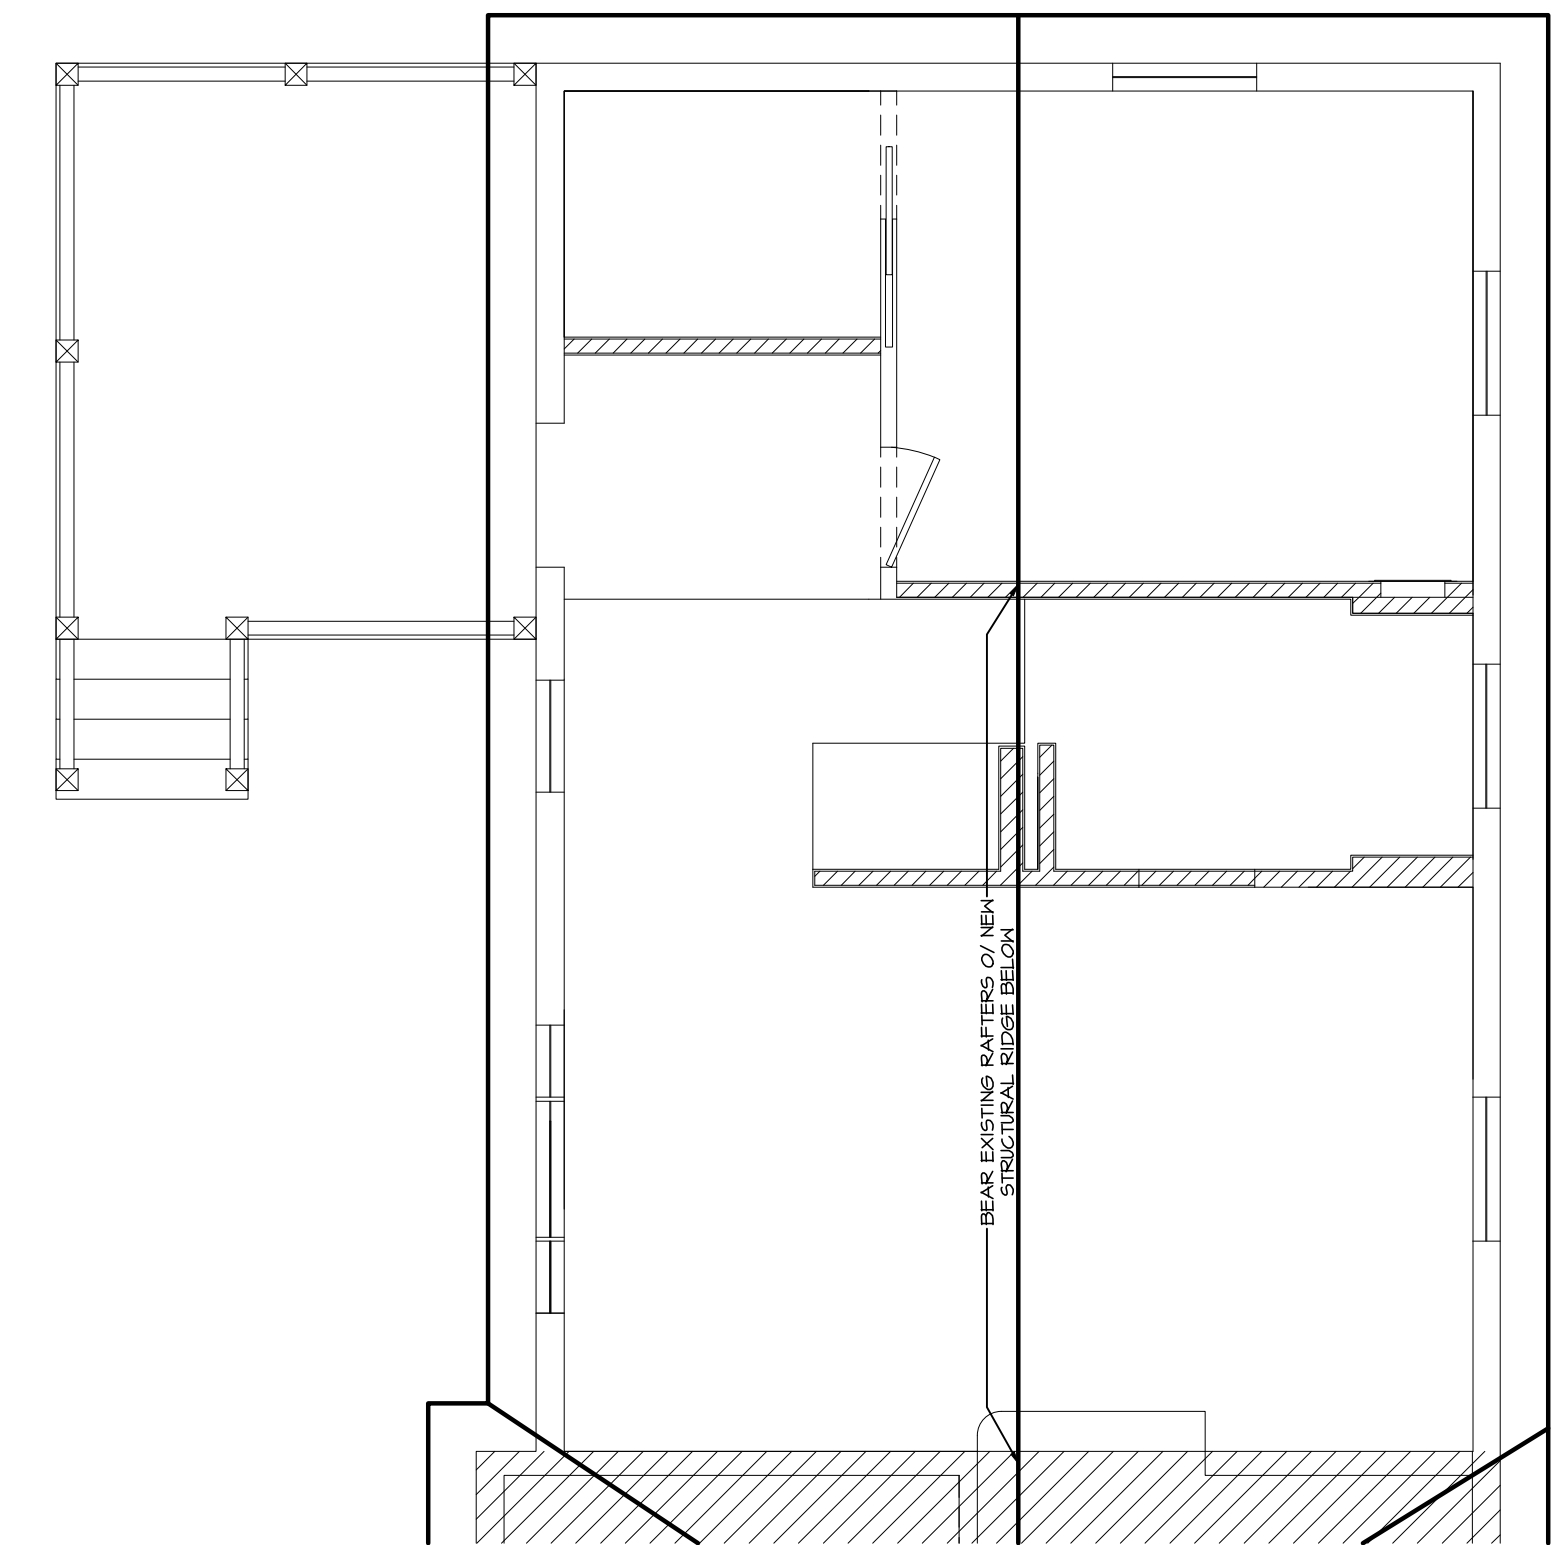

6 ROOF PLAN
SCALE: 1/4" = 1'-0"

PROJECT:

ISSUE DATE:
MAY 22, 2017

DRAWN BY:
A. GREGORY

REVISIONS:

SHEET:

S1