



	ACT-1: 2x2 SUSPENDED CEILING SYSTEM		2x4 FLUORESCENT FIXTURE REF. ELECTRICAL		RETURN AIR DEVICE REF. MECHANICAL
	ACT-2: 2x4 SUSPENDED CEILING SYSTEM		2x2 FLUORESCENT FIXTURE REF. ELECTRICAL		SUPPLY AIR DEVICE REF. MECHANICAL
	GWB: SUSPENDED GYPSUM WALL BOARD CEILING SYSTEM. GWB TO BE 5/8" TYPE "X"		SURFACE MOUNTED LIGHT FIXTURE. REF. ELECTRICAL		EXHAUST FAN DEVICE REF. MECHANICAL
			RECESSED FIXTURE REF. ELECTRICAL		FAN/LIGHT DEVICE REF. MECHANICAL
			EXIT LIGHT REF. ELECTRICAL		
			48" STRIP FIXTURE, REF. ELECTRICAL		

1 REFLECTED CEILING LEGEND
 REFERENCED FROM: _____
 SCALE: 1/4" = 1'-0"

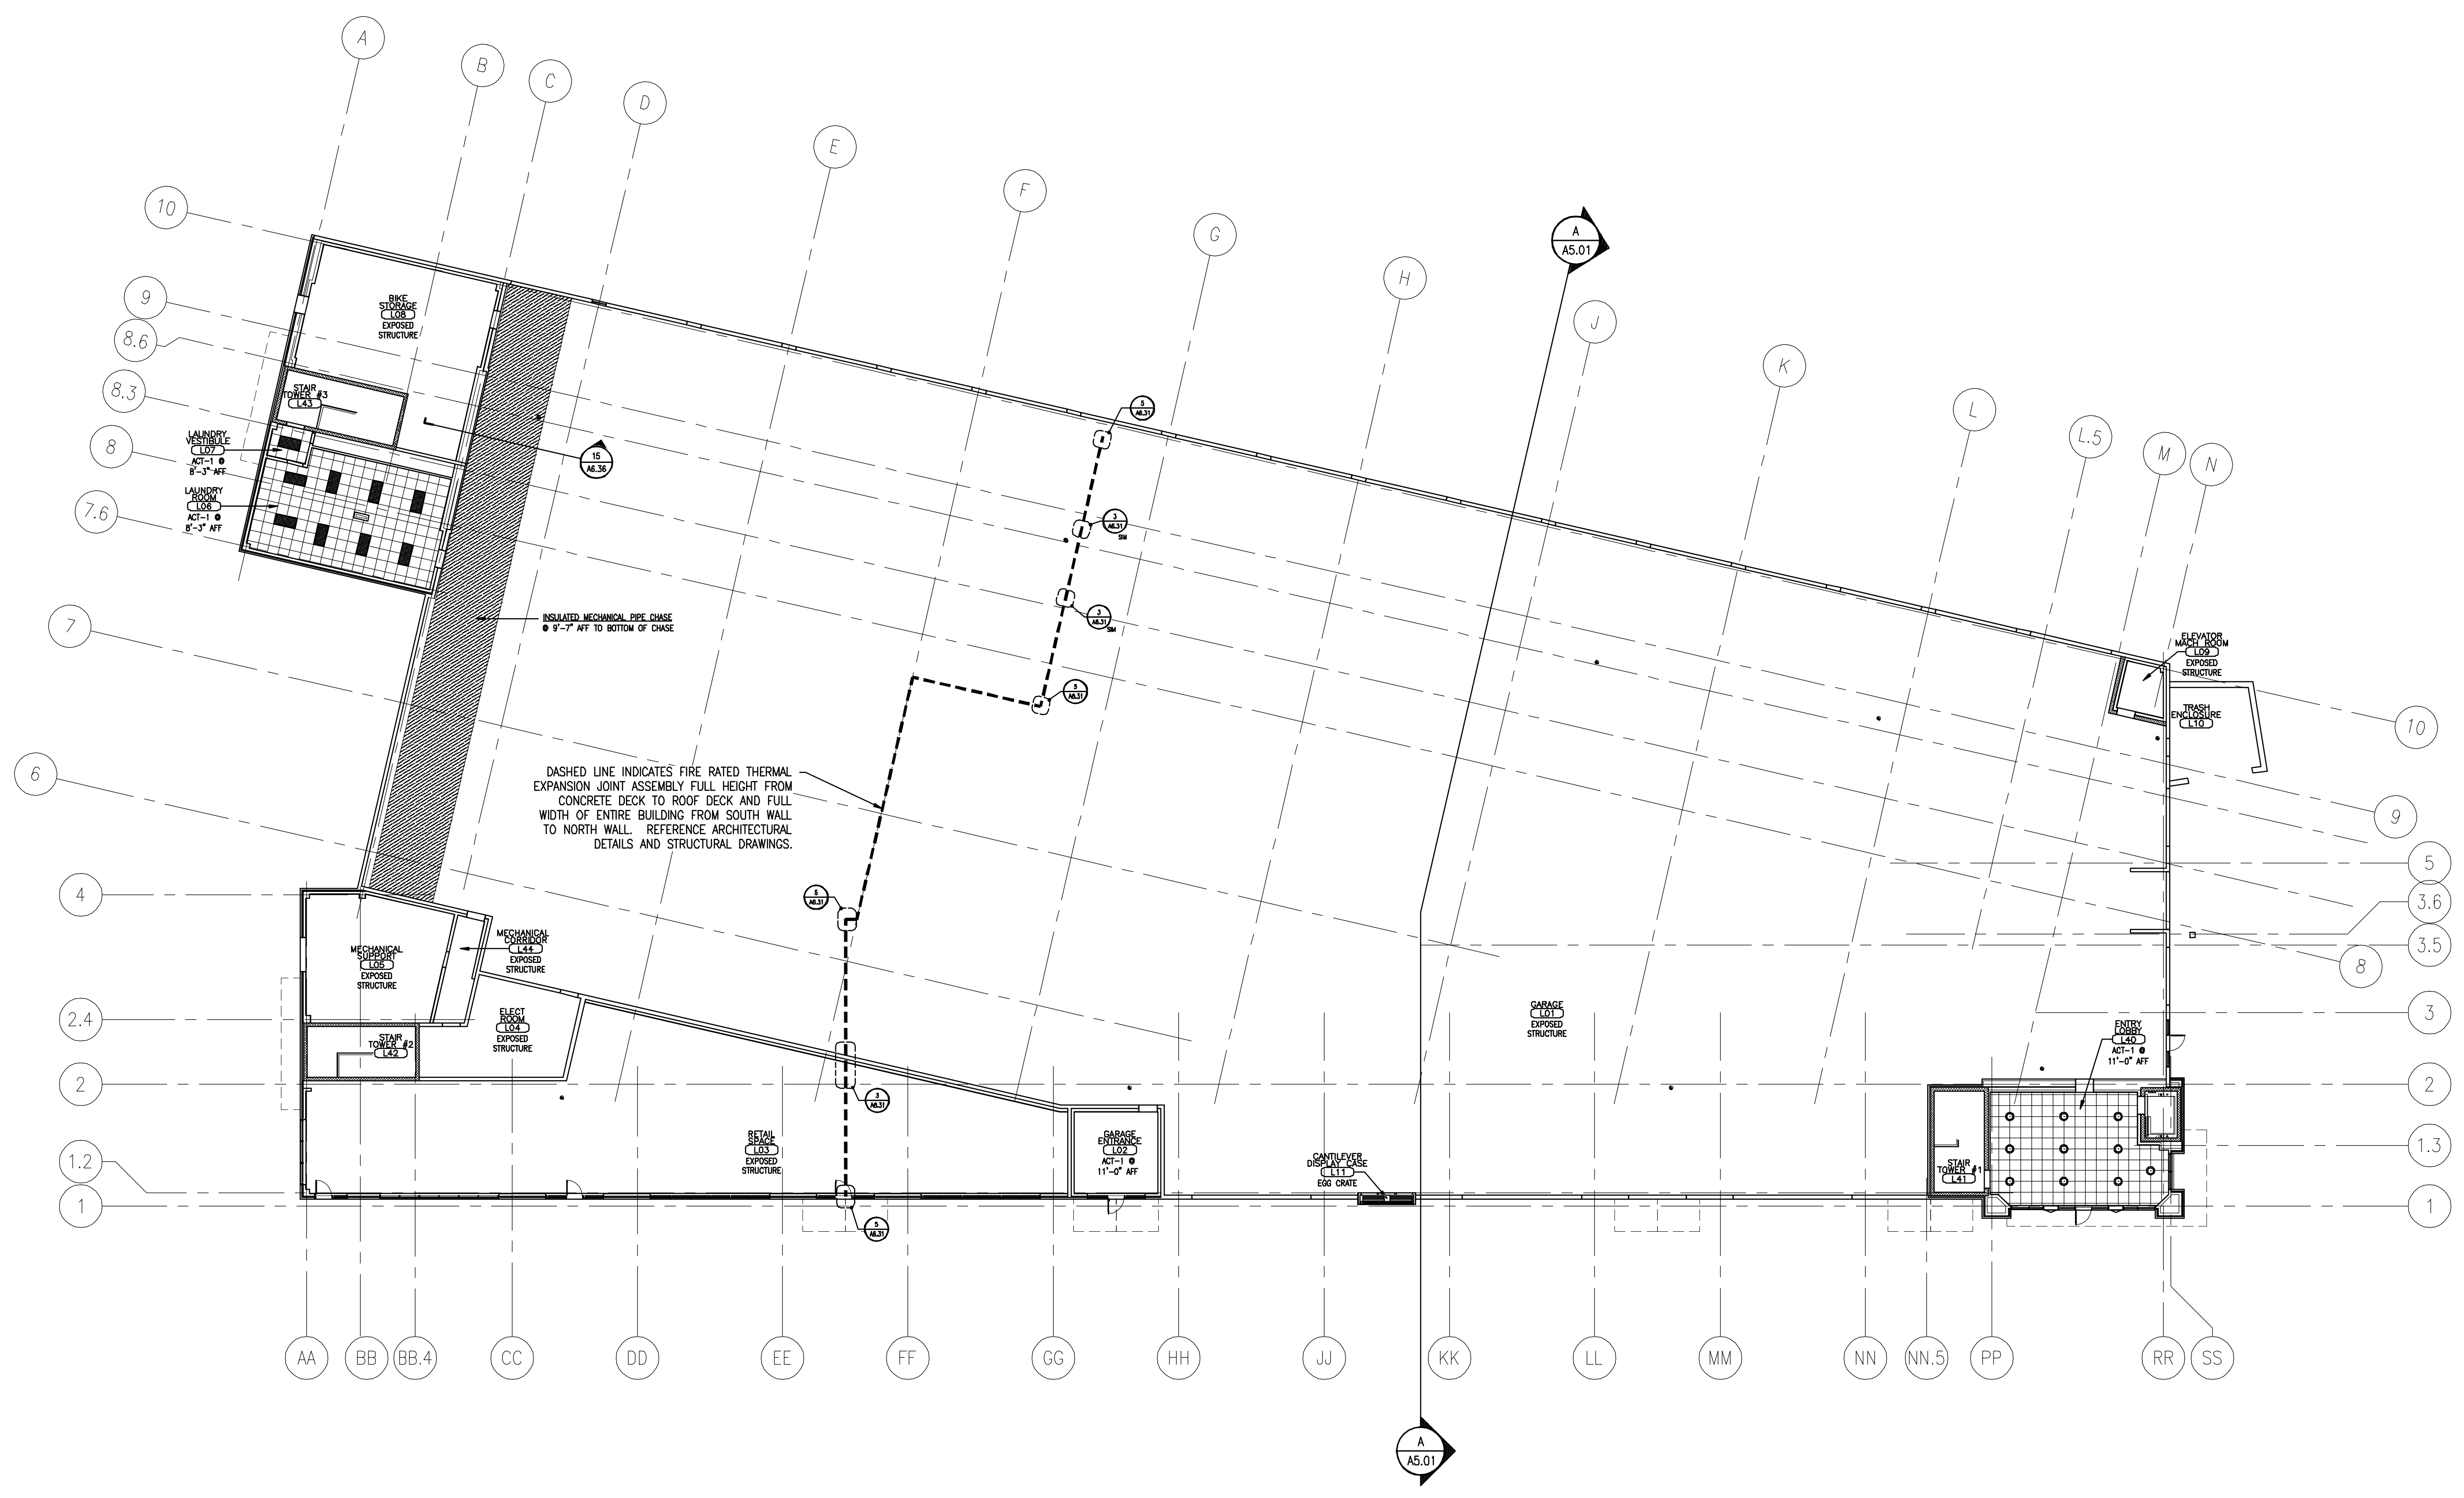

A OVERALL REFLECTED CEILING PLAN - LOWER LEVEL
 REFERENCED FROM: _____
 SCALE: 1/16" = 1'-0"

CWS
CWS Architects
 Architecture
 Space Planning
 Value Design
 434 Cumberland Avenue
 Portland, ME 04101
 Phone: (207)774-4441
 Fax: (207)774-4016
 www.CWSarch.com

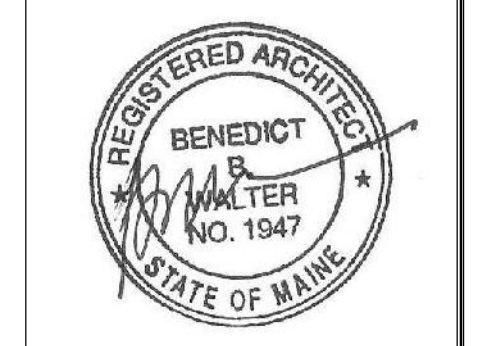

Owner: **SOUTHERN MAINE STUDENT HOUSING LLC**
 247 COMMERCIAL STREET
 ROCKPORT, MAINE 04856
 TEL: (207) 236-4067

Contractor: **PIZZAGALLI CONSTRUCTION**
 131 PRESUMPSCOT STREET
 PORTLAND, ME 04103
 TEL: (207) 874-2323
 FAX: (207) 874-2727

BAYSIDE VILLAGE - A STUDENT HOUSING COMPLEX
 132 MARGINAL WAY
 PORTLAND, MAINE

Project No: 2006-432/BVP
 Drawing Title: **OVERALL REFLECTED CEILING PLAN - LOWER LEVEL**

Scale: 1/16" = 1'-0"
 Date: SEPTEMBER 14, 2007
 Revisions: _____

Drawing Number: **A2.GO**