

**NOTE:**

1. SEE SHEET E-001 FOR LEGEND AND GENERAL NOTES.


**ESB**  
**E.S. BOULOS CO**  
 ELECTRICAL CONTRACTORS

45 BRADLEY DRIVE  
 WESTBROOK, ME 04092  
 TEL: (207) 464-3706  
 FAX: (207) 464-1833

**SM**  
**RT**

ARCHITECTURE ENGINEERING PLANNING  
 SMART

144 Fore Street/P.O. Box 618  
 Portland, Maine 04104  
 tel. (207) 772-3846  
 fax. (207) 772-1070

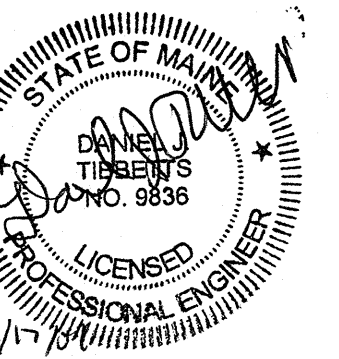

BAYSIDE VILLAGE  
 STUDENT HOUSING COMPLEX  
 PORTLAND, ME

ISSUED FOR CONSTRUCTION  
 9-14-07

PROJECT TITLE

CURRENT ISSUE STATUS

REV	DESCRIPTION	DATE
0	ISSUED FOR CONSTRUCTION	9-14-07

GRAPHIC SCALE:



SCALE: 1/8"=1'-0"

PROJECT MANAGER: DJT

JC/DRAWN BY: CDS

A/E OF RECORD: DJT

CAD FILE: EL100A-07125

PROJECT NO: 07125

DATE: 9-14-07


SHEET TITLE:

LOWER LEVEL LIGHTING PLAN A

SHEET No.

EL100A

© COPYRIGHT 2007 SMART INC.

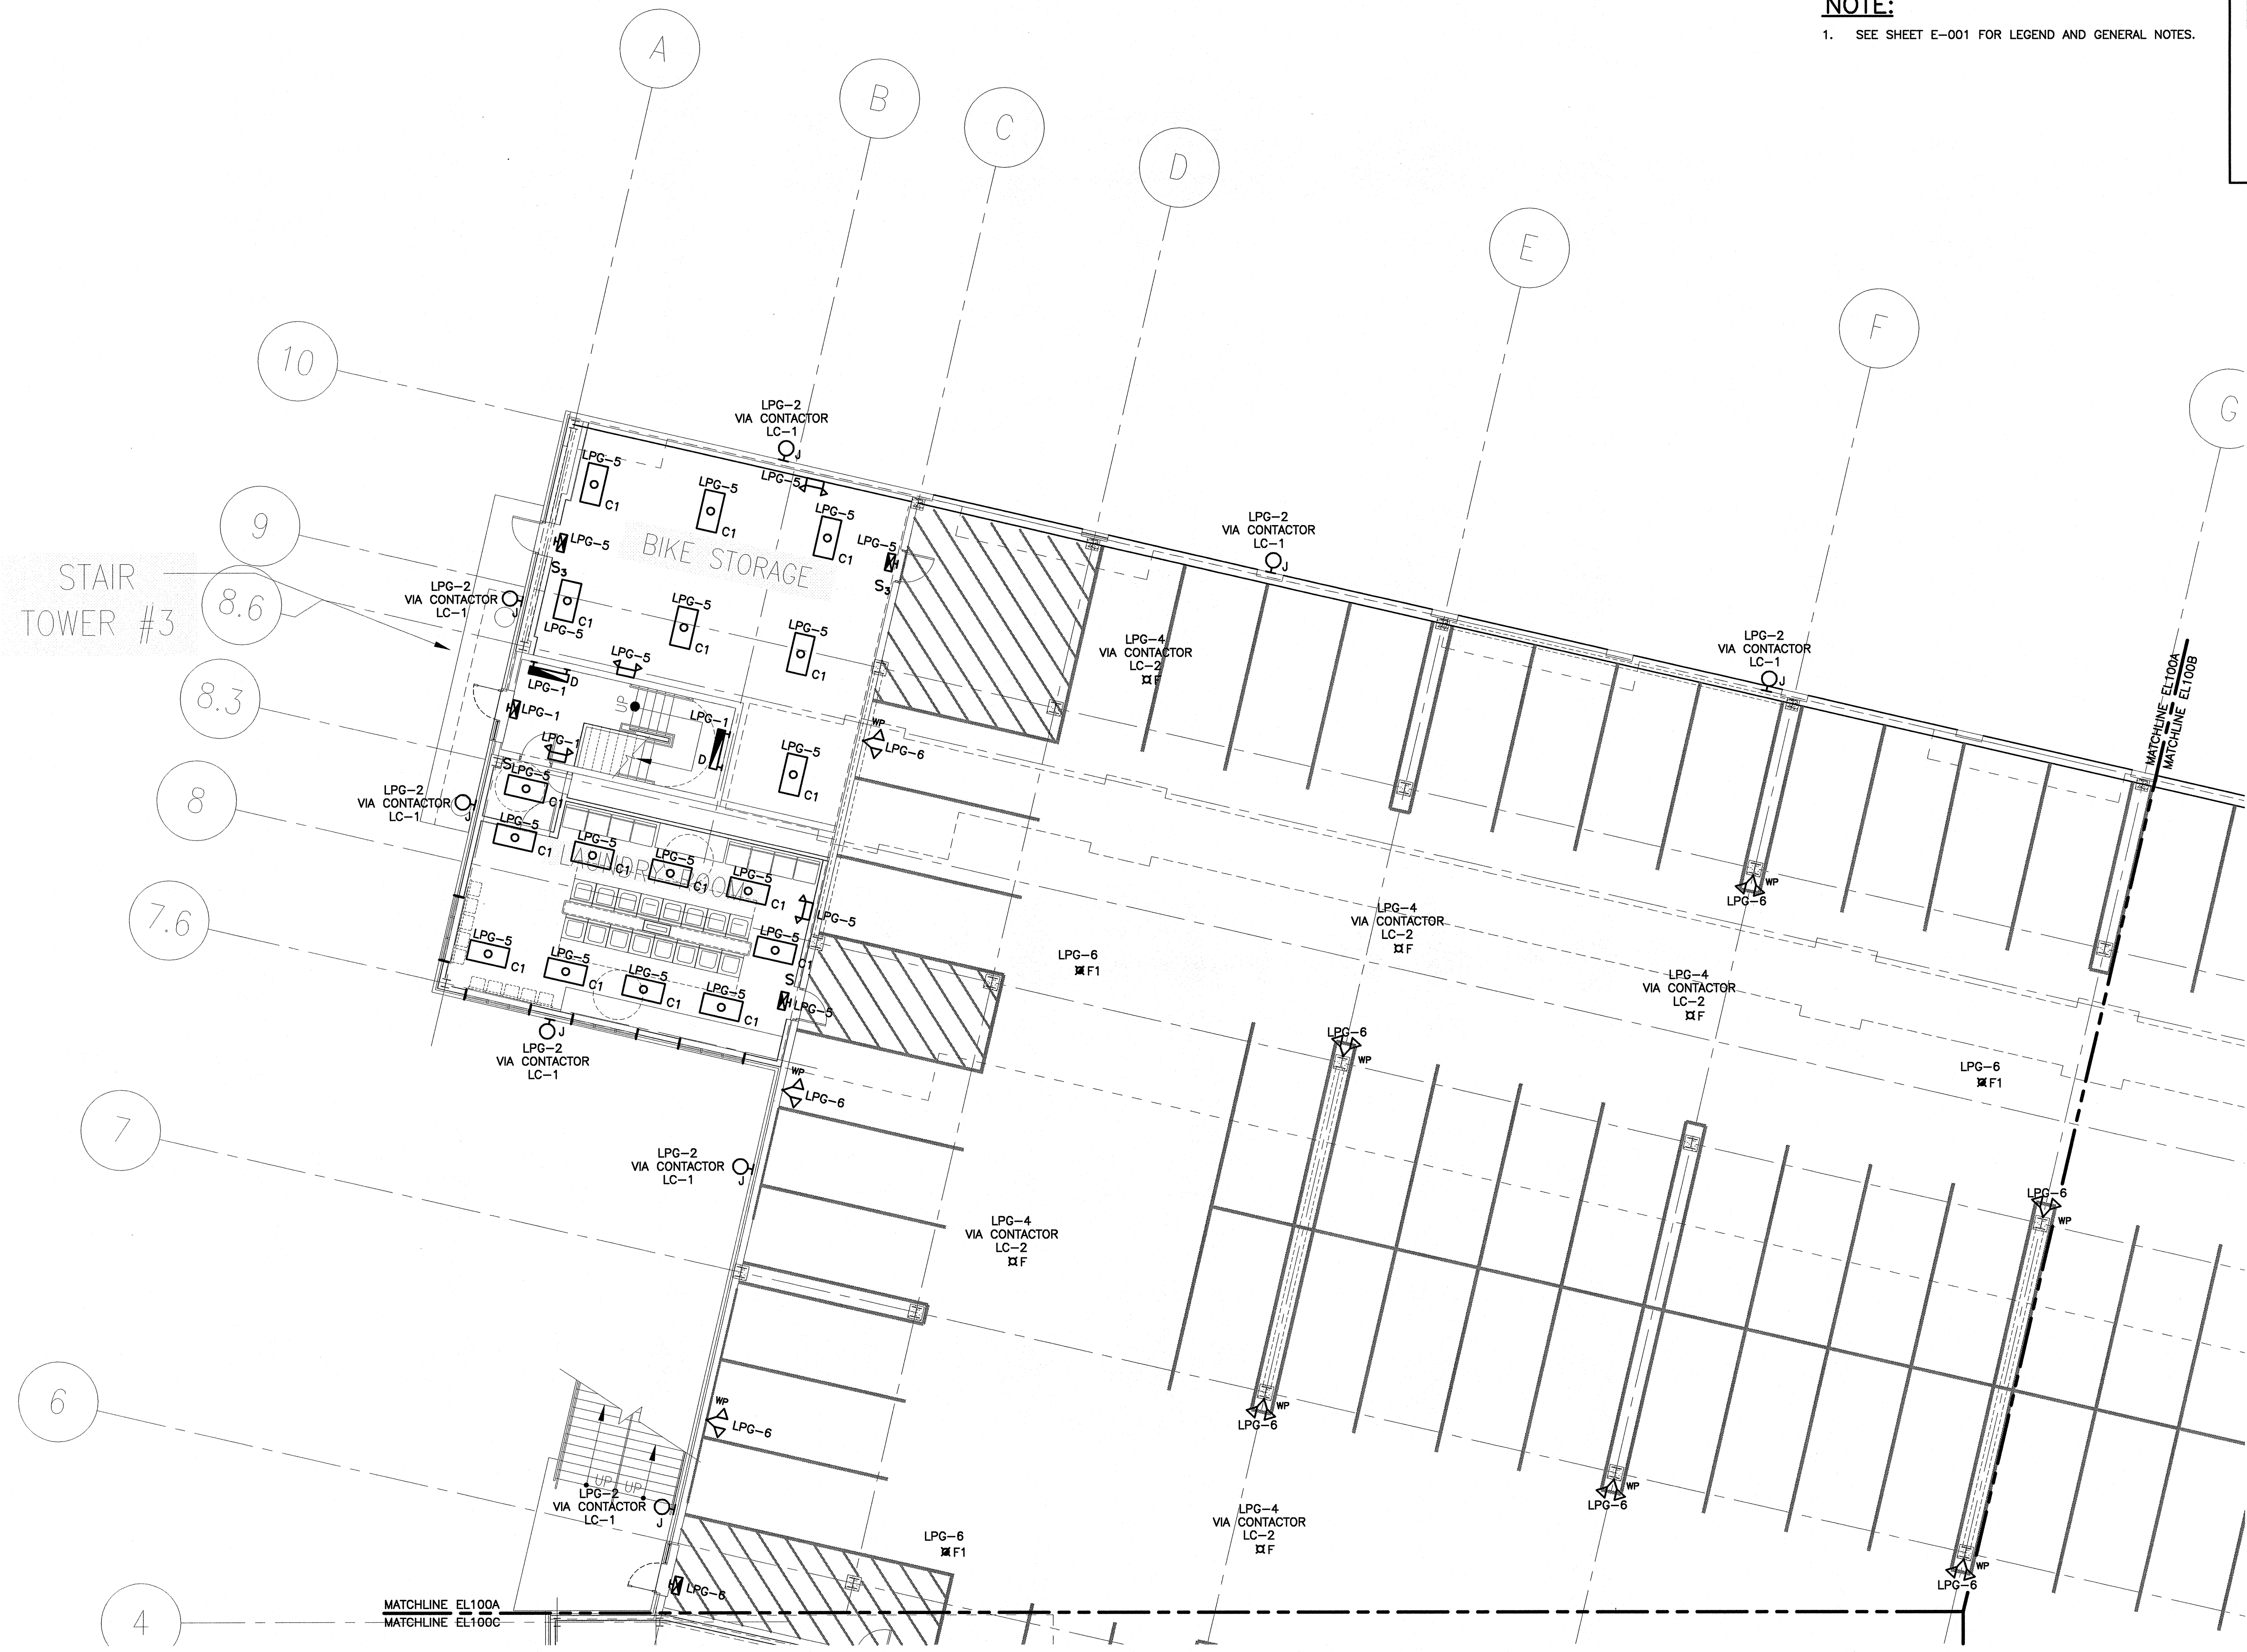

**A1** LOWER LEVEL PLAN

1/8"=1'-0"