


**NOTE:**  
1. SEE SHEET E-001 FOR LEGEND AND GENERAL NOTES.

**ESB**  
E.S. BOULOS CO  
ELECTRICAL CONTRACTORS  
45 BRADLEY DRIVE  
WESTBROOK, ME 04092  
TEL: (207) 464-3706  
FAX: (207) 464-1833

**SM  
RT**

ARCHITECTURE ENGINEERING PLANNING  
SMRT  
144 Fore Street/P.O. Box 618  
Portland, Maine 04104  
tel. (207) 772-3846  
fax. (207) 772-1070

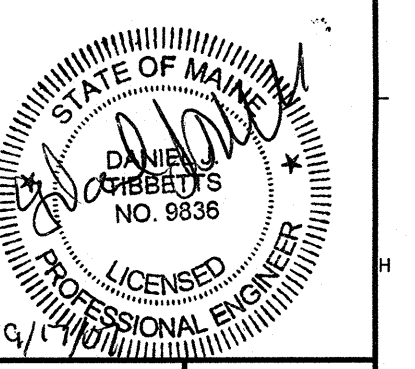


PROJECT TITLE  
**BAYSIDE VILLAGE  
STUDENT HOUSING COMPLEX**  
PORTLAND, ME  
CURRENT ISSUE STATUS  
**ISSUED FOR CONSTRUCTION  
9-14-07**

REV	DESCRIPTION	DATE
0	ISSUED FOR CONSTRUCTION	9-14-07

GRAPHIC SCALE:  
0" 1"  
SCALE: 1/8"=1'-0"  
PROJECT MANAGER: DJT  
JC/DRAWN BY: CDS  
A/E OF RECORD: DJT  
CAD FILE: EL100B-07125  
PROJECT NO: 07125  
DATE: 9-14-07

SHEET TITLE:  
**LOWER LEVEL LIGHTING PLAN B**

SHEET No.  
**EL100B**  
© copyright 2007 smrt inc.

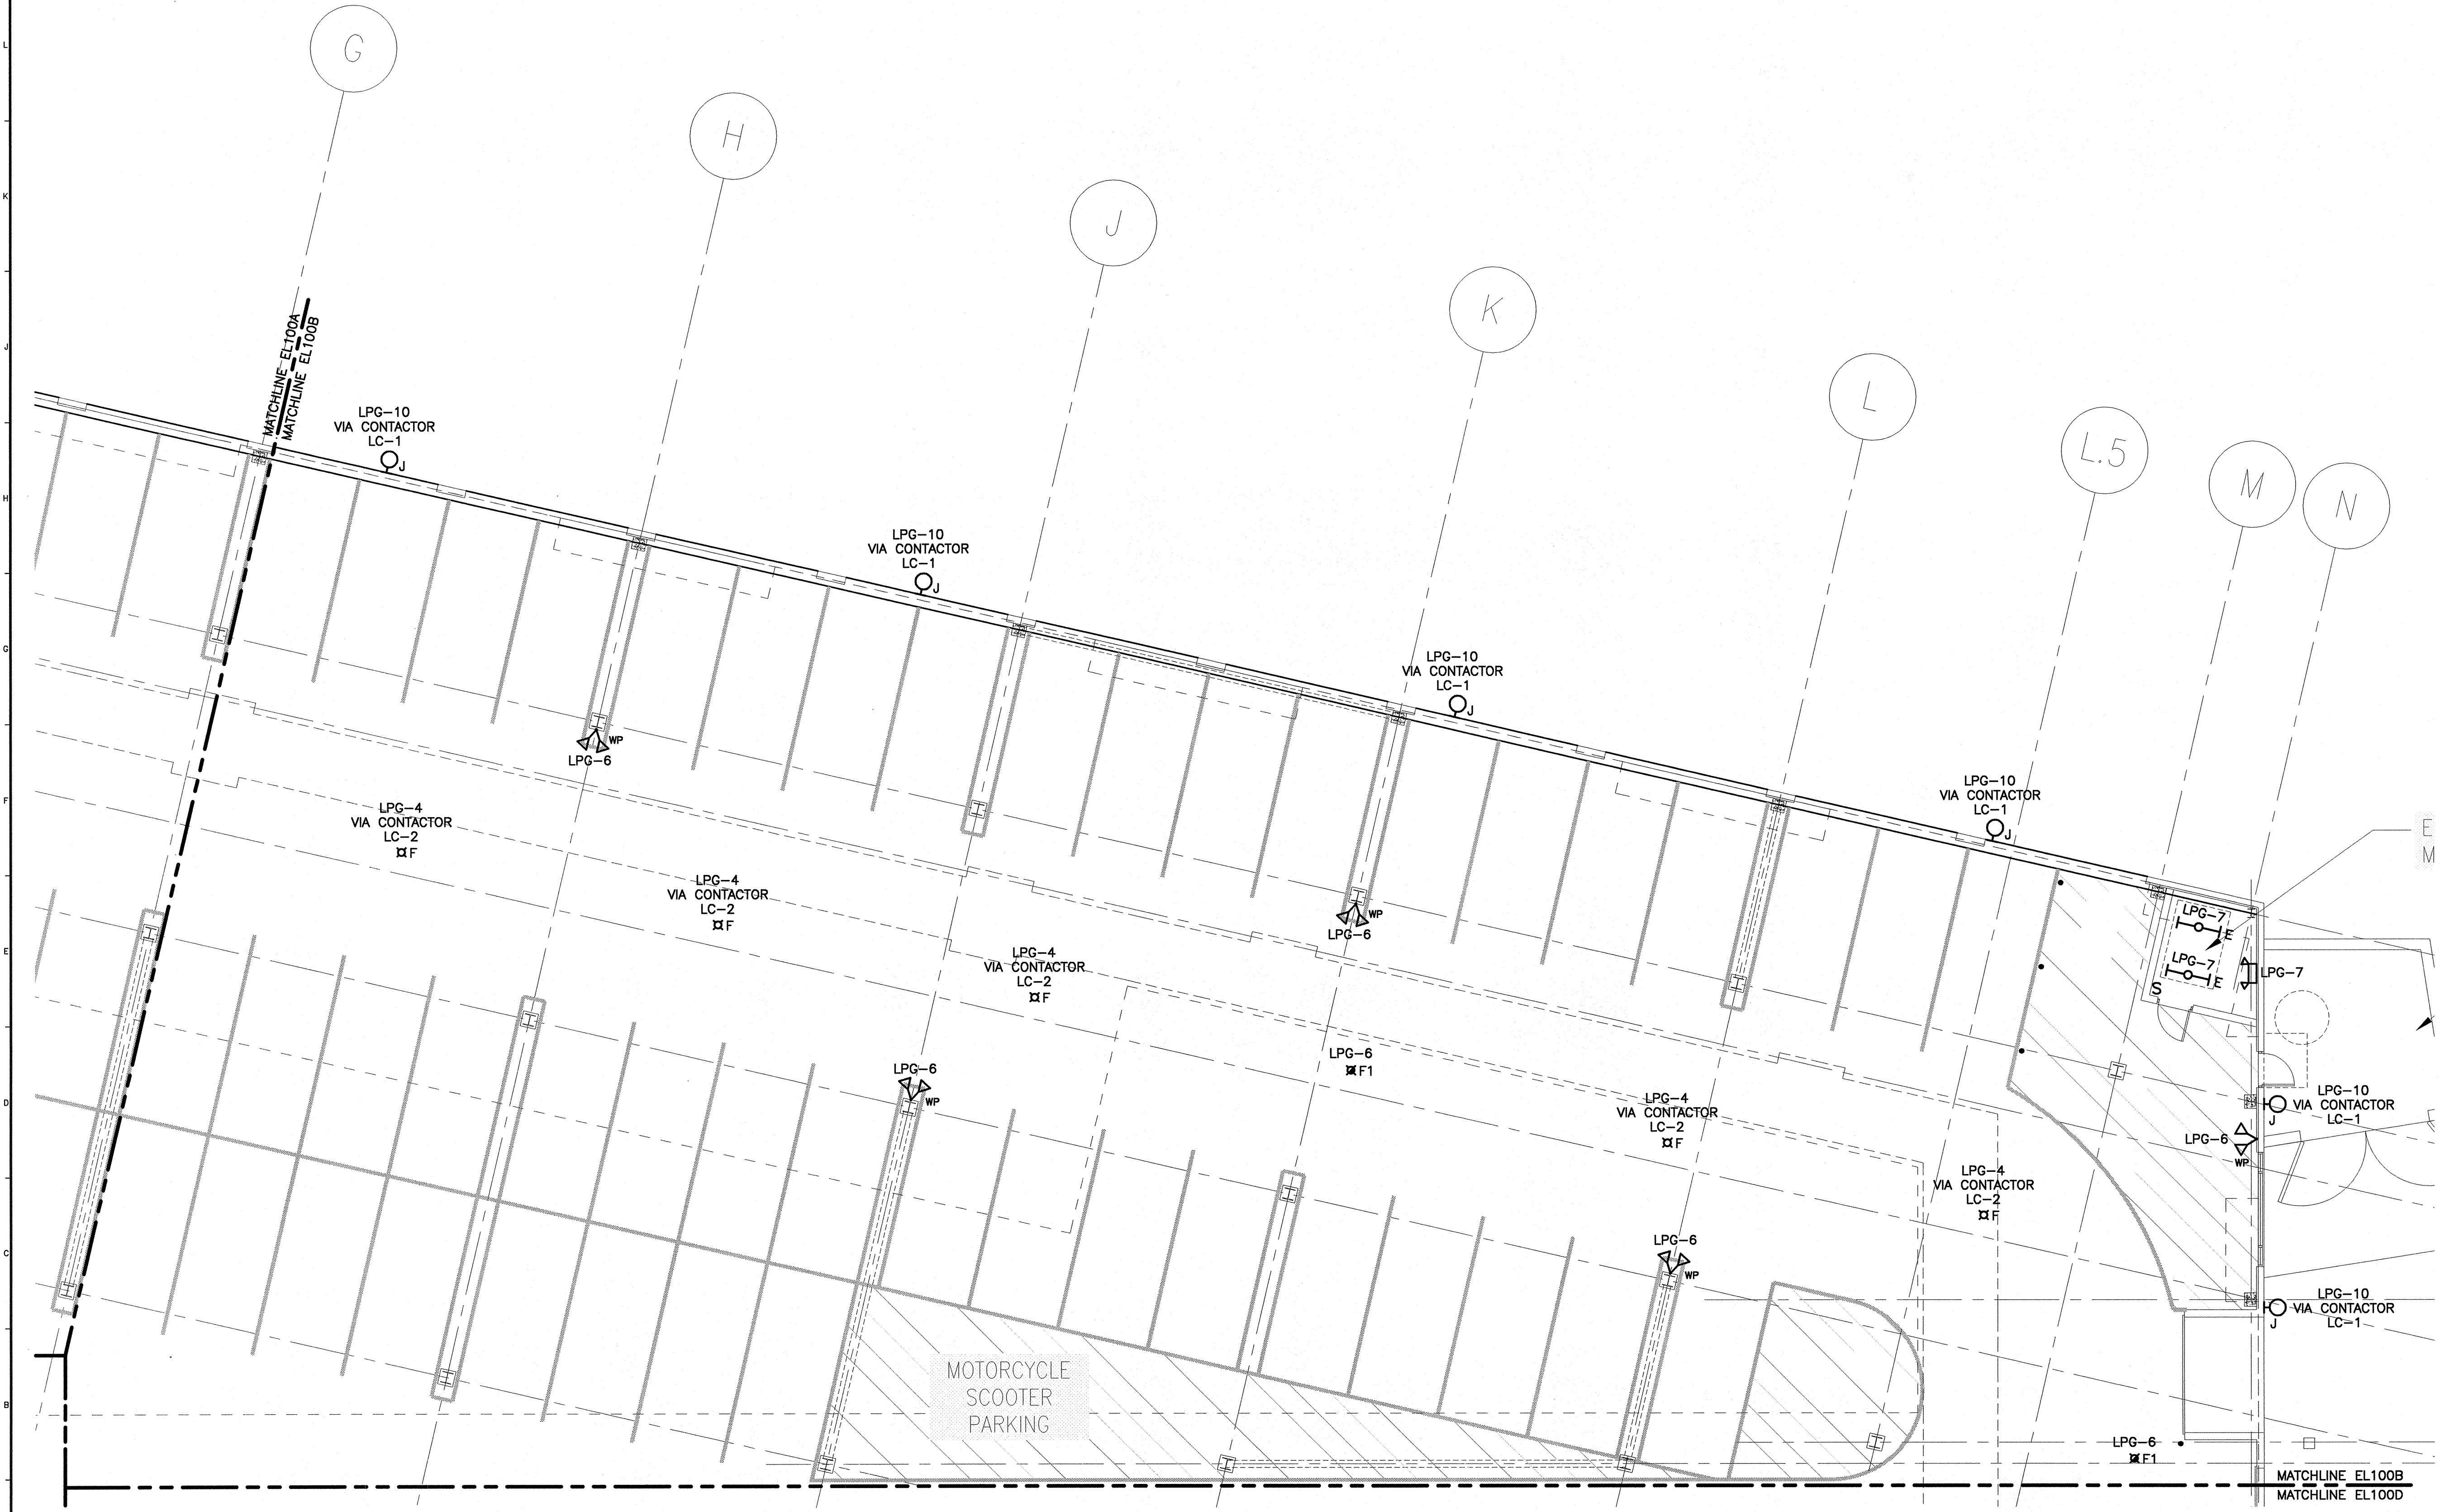

A1 LOWER LEVEL PLAN  
1/8"=1'-0"