
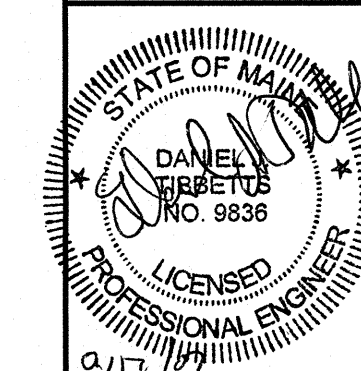


NOTE:

1. SEE SHEET E-001 FOR LEGEND AND GENERAL NOTES.

KEYED NOTE:

① SEE SHEET EL103C FOR LOCATION OF SECOND THREE WAY SWITCH.

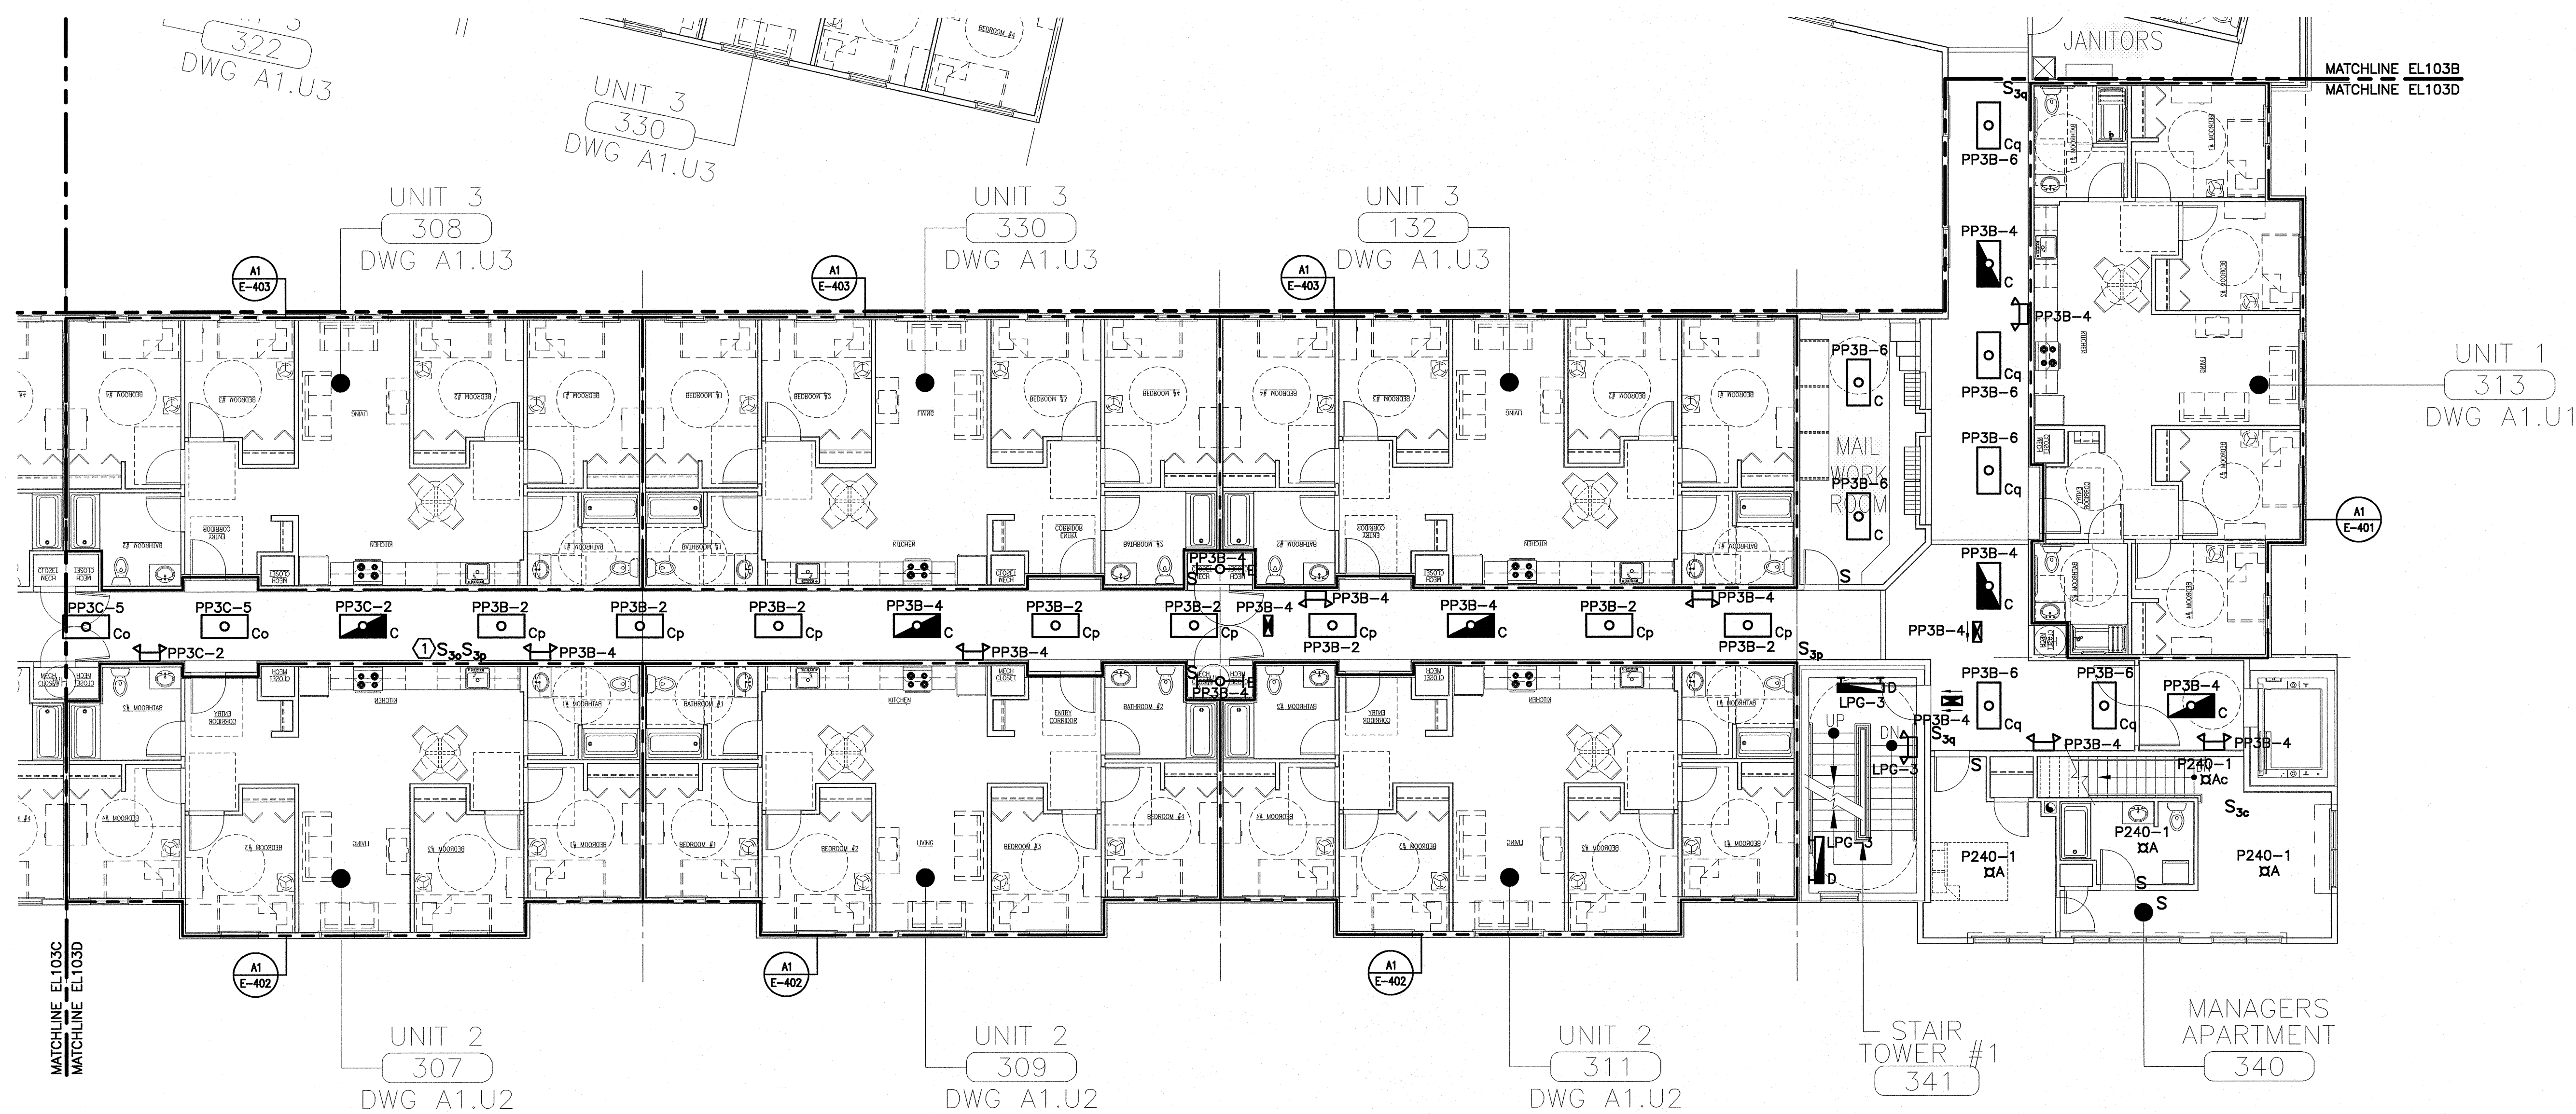

BAYSIDE VILLAGE
STUDENT HOUSING COMPLEX
 PORTLAND, ME

PROJECT TITLE:
 CURRENT ISSUE STATUS:
ISSUED FOR CONSTRUCTION
 9-14-07

REV	DESCRIPTION	DATE
0	ISSUED FOR CONSTRUCTION	9-14-07

GRAPHIC SCALE:
 0" = 1"

SCALE: 1/8"=1'-0"
 PROJECT MANAGER: DJT
 JC/DRAWN BY: CDS
 A/E OF RECORD: DJT
 CAD FILE: EL103D-07125
 PROJECT NO: 07125
 DATE: 9-14-07

SHEET TITLE:
THIRD FLOOR LIGHTING PLAN D

SHEET No.
EL103D
© copyright 2007 ESB Inc.

A1 THIRD FLOOR PLAN

1/8"=1'-0"