

NOTE:


1. SEE SHEET E-001 FOR LEGEND AND GENERAL NOTES.

ESB
E.S. BOULOS CO
 ELECTRICAL CONTRACTORS

45 BRADLEY DRIVE
 WESTBROOK, ME 04092
 TEL: (207) 464-3706
 FAX: (207) 464-1833

SM
RT

ARCHITECTURE ENGINEERING PLANNING
 SWRT
 144 Fore Street/P.O. Box 618
 Portland, Maine 04104
 tel. (207) 772-3846
 fax. (207) 772-1070

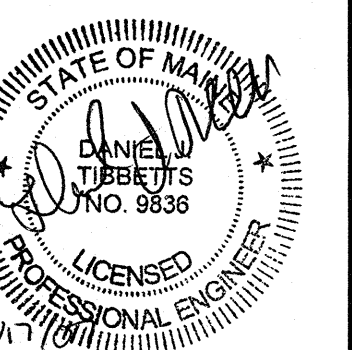

PROJECT TITLE:
**BAYSIDE VILLAGE
 STUDENT HOUSING COMPLEX**
 PORTLAND, ME

CURRENT ISSUE STATUS:
**ISSUED FOR CONSTRUCTION
 9-14-07**


REV.	DESCRIPTION	DATE
0	ISSUED FOR CONSTRUCTION	9-14-07

GRAPHIC SCALE:
 0" = 1"

SCALE: 1/8"=1'-0"
 PROJECT MANAGER: DJT
 JC/DRAWN BY: CDS
 A/E OF RECORD: DJT
 CAD FILE: EP100C-07125
 PROJECT NO: 07125
 DATE: 9-14-07

SHEET TITLE:
**LOWER LEVEL
 POWER PLAN C**

SHEET No.
EP100C

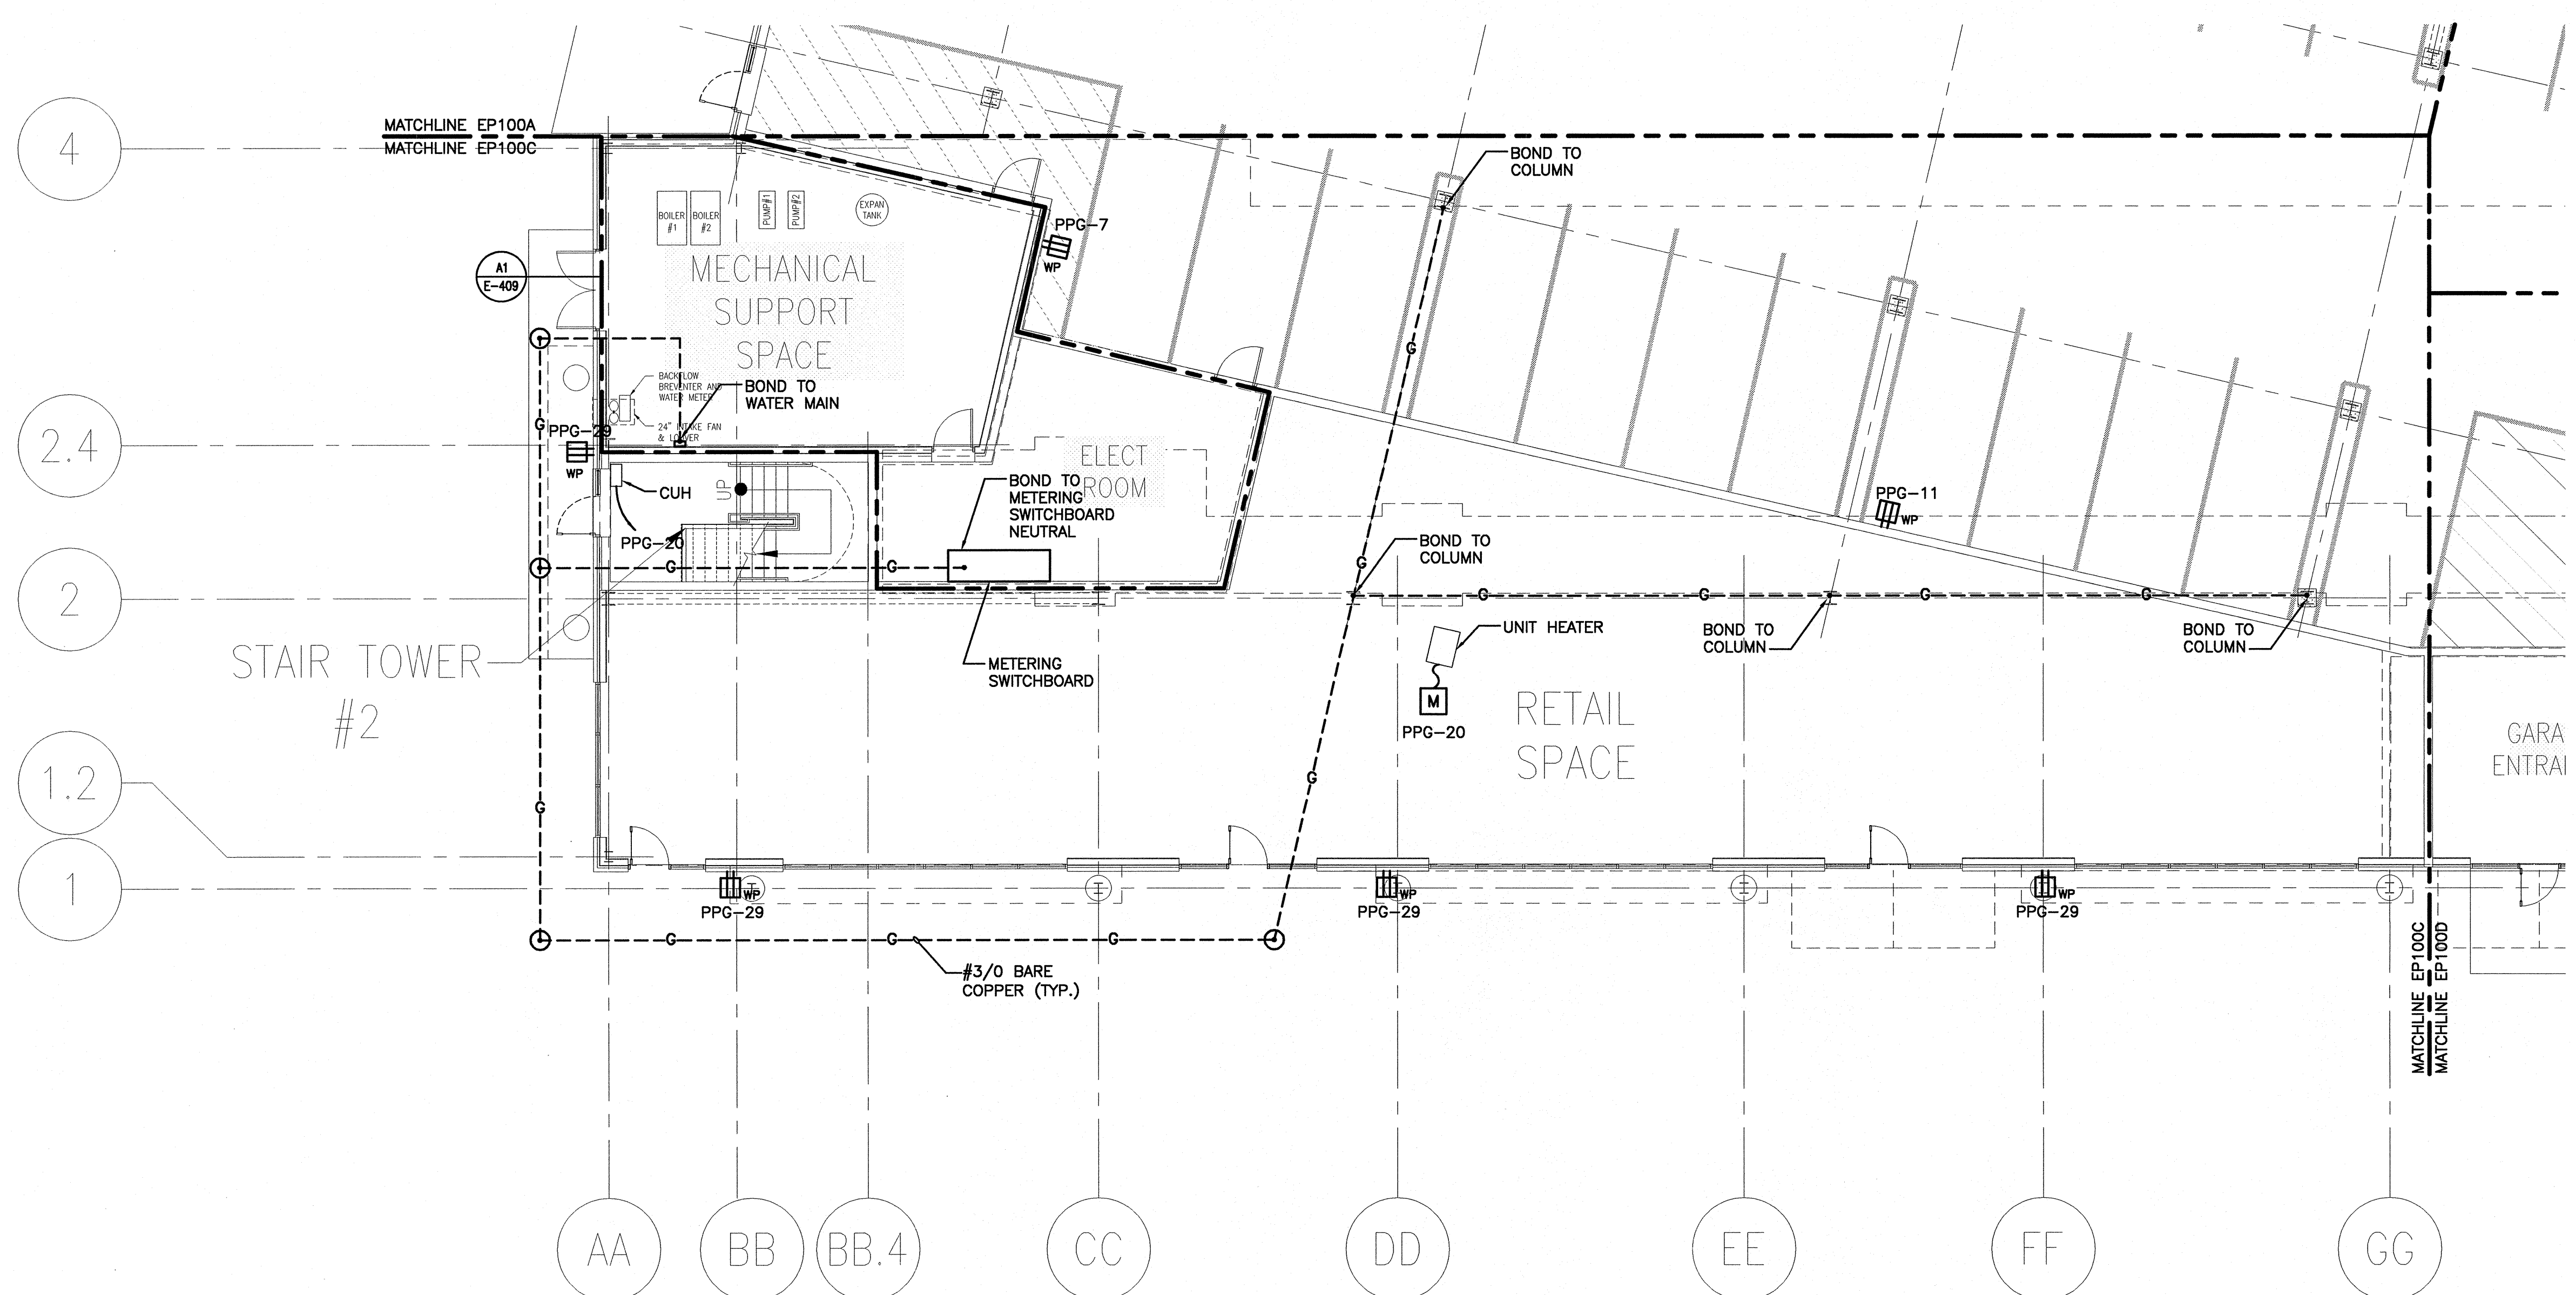

A1 LOWER LEVEL PLAN
 1/8"=1'-0"