

NOTE:

1. SEE SHEET E-001 FOR LEGEND AND GENERAL NOTES.


ESB
E.S. BOULOS CO
 ELECTRICAL CONTRACTORS

45 BRADLEY DRIVE
 WESTBROOK, ME 04092
 TEL: (207) 464-3706
 FAX: (207) 464-1833

SM
RT

ARCHITECTURE ENGINEERING PLANNING
 SMART

144 Fore Street/P.O. Box 618
 Portland, Maine 04104
 tel. (207) 773-3846
 fax. (207) 773-1070

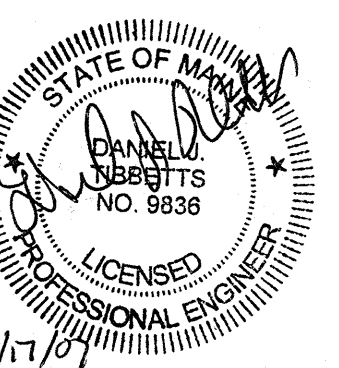

PROJECT TITLE:
**BAYSIDE VILLAGE
 STUDENT HOUSING COMPLEX**
 PORTLAND, ME


CURRENT ISSUE STATUS:
ISSUED FOR CONSTRUCTION
9-14-07

REV	DESCRIPTION	DATE
0	ISSUED FOR CONSTRUCTION	9-14-07

GRAPHIC SCALE:
 0" 1"
 SCALE: 1/8"=1'-0"
 PROJECT MANAGER: DJT
 JC/DRAWN BY: CDS
 A/E OF RECORD: DJT
 CAD FILE: EP101C-07125
 PROJECT NO: 07125
 DATE: 9-14-07
 SHEET TITLE:

**FIRST FLOOR
 POWER PLAN C**

SHEET No.
EP101C

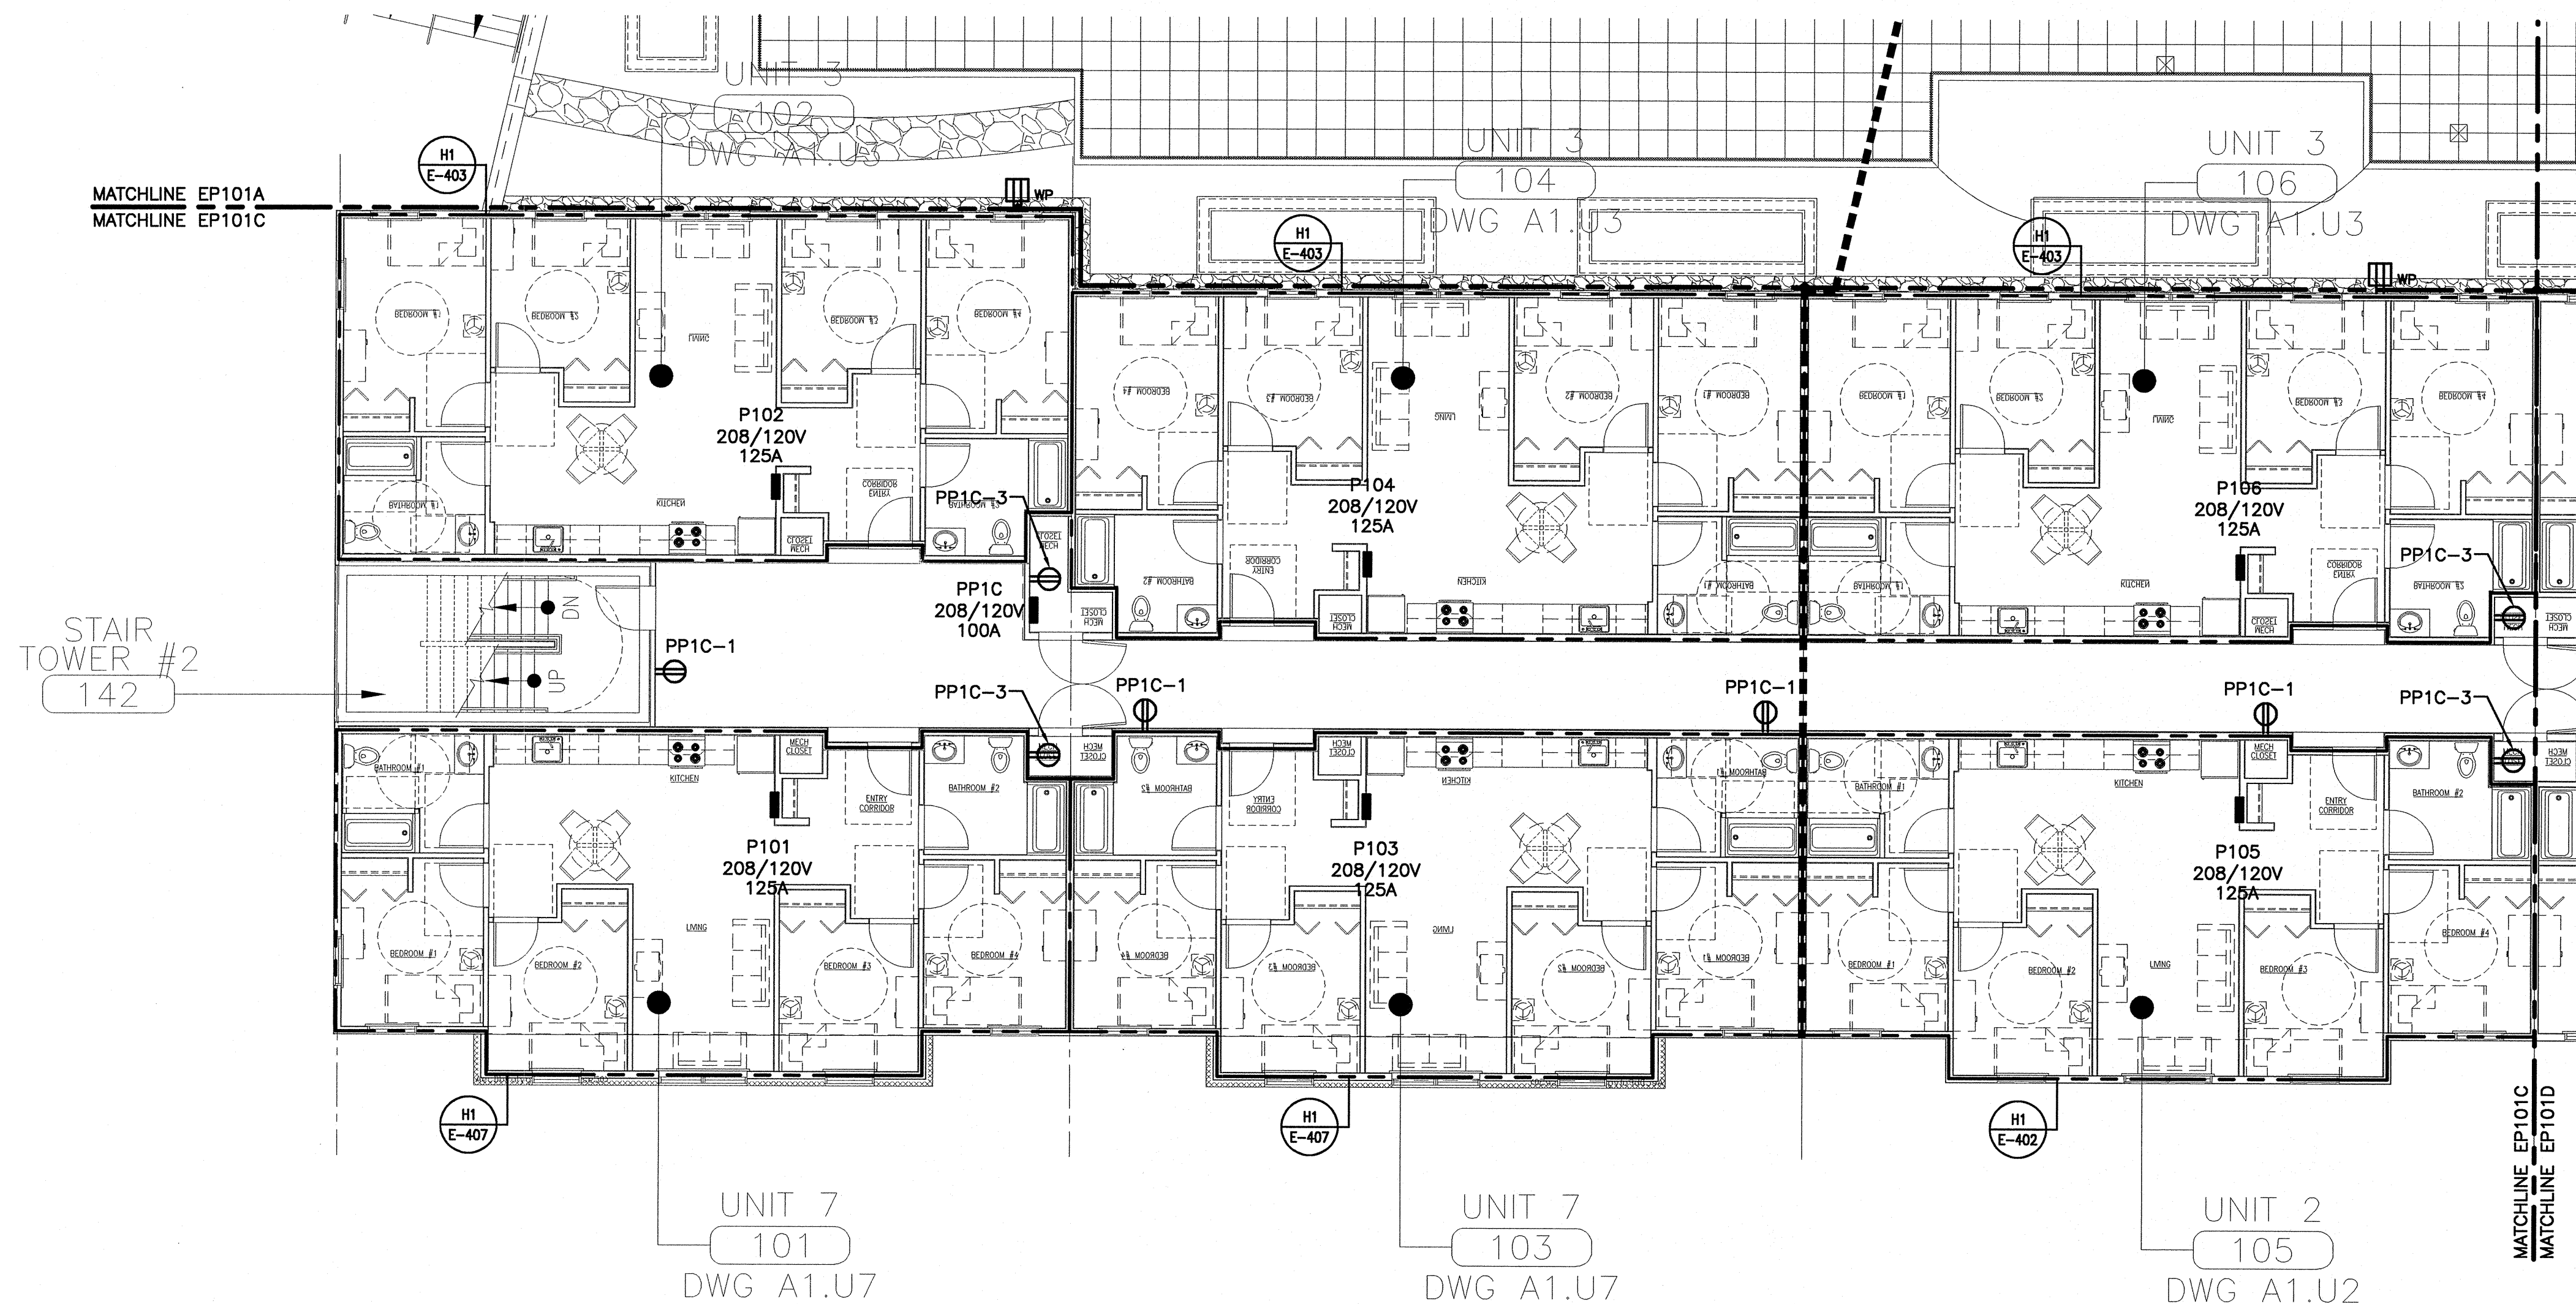

A1 FIRST FLOOR PLAN

1/8"=1'-0"