


**NOTE:**  
 1. SEE SHEET E-001 FOR LEGEND AND GENERAL NOTES.

**KEYED NOTE:**  
 ① MOUNT RECEPTACLE 42" AFF TO BOTTOM OF DEVICE.  
 ② PROVIDE POWER FOR HVAC CONTROLS. FIELD COORDINATE EXACT LOCATION OF ELECTRICAL CONNECTION.

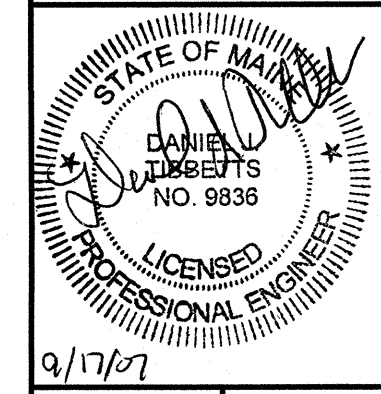

9/17/07


PROJECT TITLE:  
**BAYSIDE VILLAGE**  
**STUDENT HOUSING COMPLEX**  
 PORTLAND, ME  
 CURRENT ISSUE STATUS:  
**ISSUED FOR CONSTRUCTION**  
 9-14-07

REV	DESCRIPTION	DATE
0	ISSUED FOR CONSTRUCTION	9-14-07

GRAPHIC SCALE:  
 0" 1"  
 SCALE: 1/8"=1'-0"  
 PROJECT MANAGER: DJT  
 JC/DRAWN BY: CDS  
 A/E OF RECORD: DJT  
 CAD FILE: EP101D-07125  
 PROJECT NO: 07125  
 DATE: 9-14-07  
 SHEET TITLE:

**FIRST FLOOR**  
**POWER PLAN D**

SHEET No.  
**EP101D**  
© COPYRIGHT 2007 SMI INC.

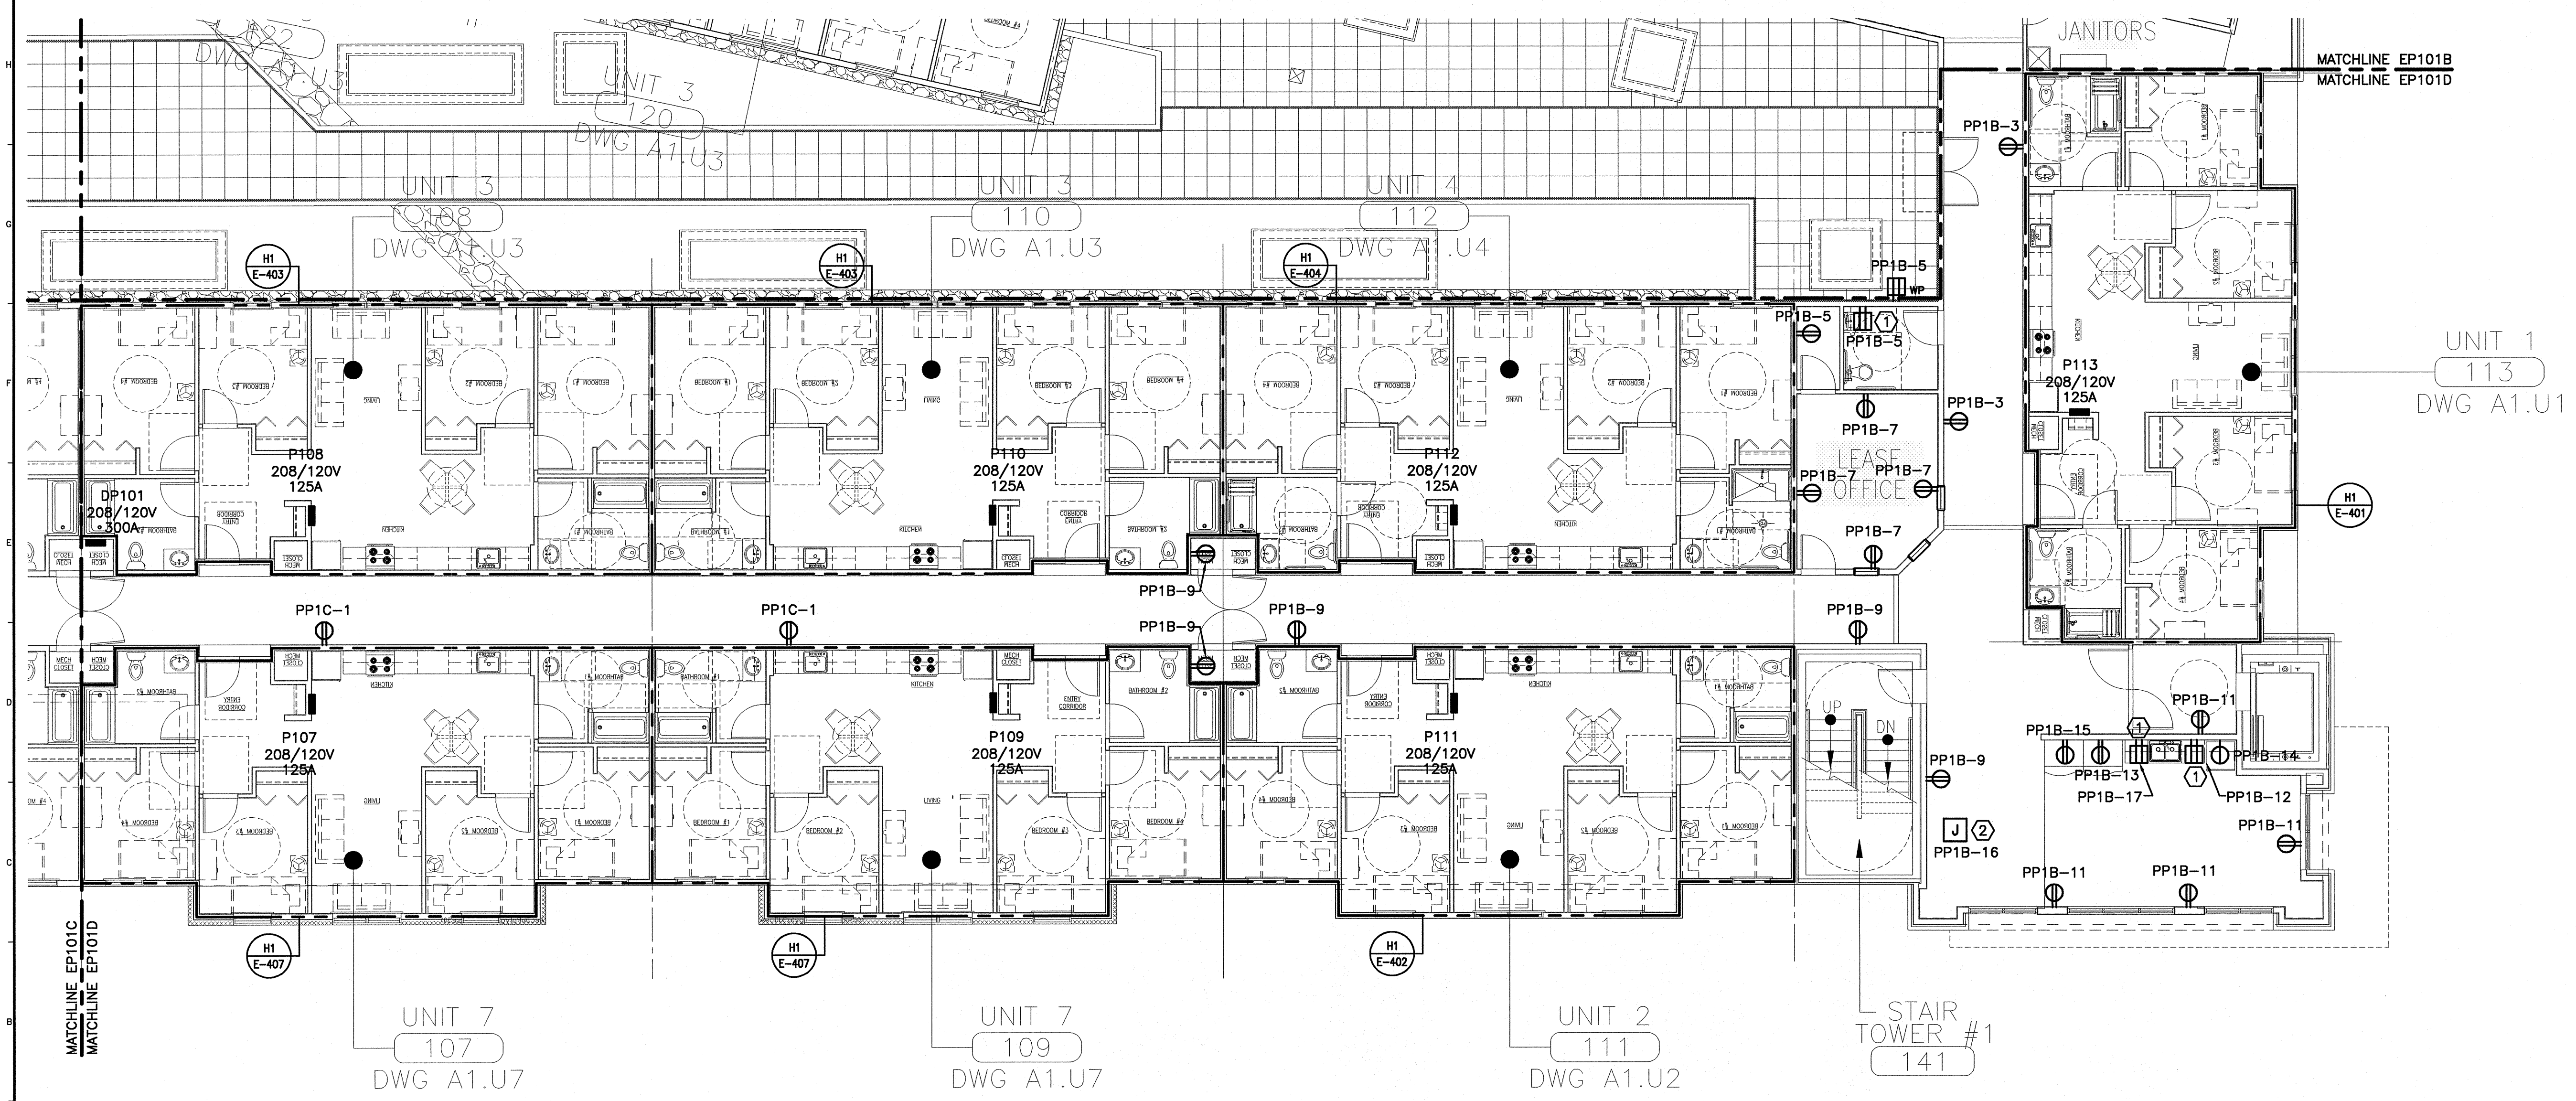

**A1** FIRST FLOOR PLAN

1/8"=1'-0"