

NOTE:

1. SEE SHEET E-001 FOR LEGEND AND GENERAL NOTES.


ESB
E.S. BOULOS CO
 ELECTRICAL CONTRACTORS

45 BRADLEY DRIVE
 WESTBROOK, ME 04092
 TEL: (207) 464-3706
 FAX: (207) 464-1833

SM
RT

ARCHITECTURE ENGINEERING PLANNING

SMRT
 144 Fore Street/P.O. Box 618
 Portland, Maine 04104
 tel. (207) 772-3846
 fax. (207) 772-1070

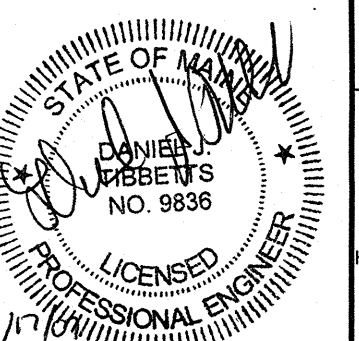

PROJECT TITLE:
**BAYSIDE VILLAGE
 STUDENT HOUSING COMPLEX**
 PORTLAND, ME


CURRENT ISSUE STATUS:
**ISSUED FOR CONSTRUCTION
 9-14-07**

| REV | DESCRIPTION | DATE |
|-----|-------------------------|---------|
| 0 | ISSUED FOR CONSTRUCTION | 9-14-07 |

GRAPHIC SCALE:
 0" 1"
 SCALE: 1/8"=1'-0"
 PROJECT MANAGER: DJT
 JC/DRAWN BY: CDS
 A/E OF RECORD: DJT
 CAD FILE: EP102C-07125
 PROJECT NO: 07125
 DATE: 9-14-07

SHEET TITLE:
**SECOND FLOOR
 POWER PLAN C**

SHEET No.
EP102C

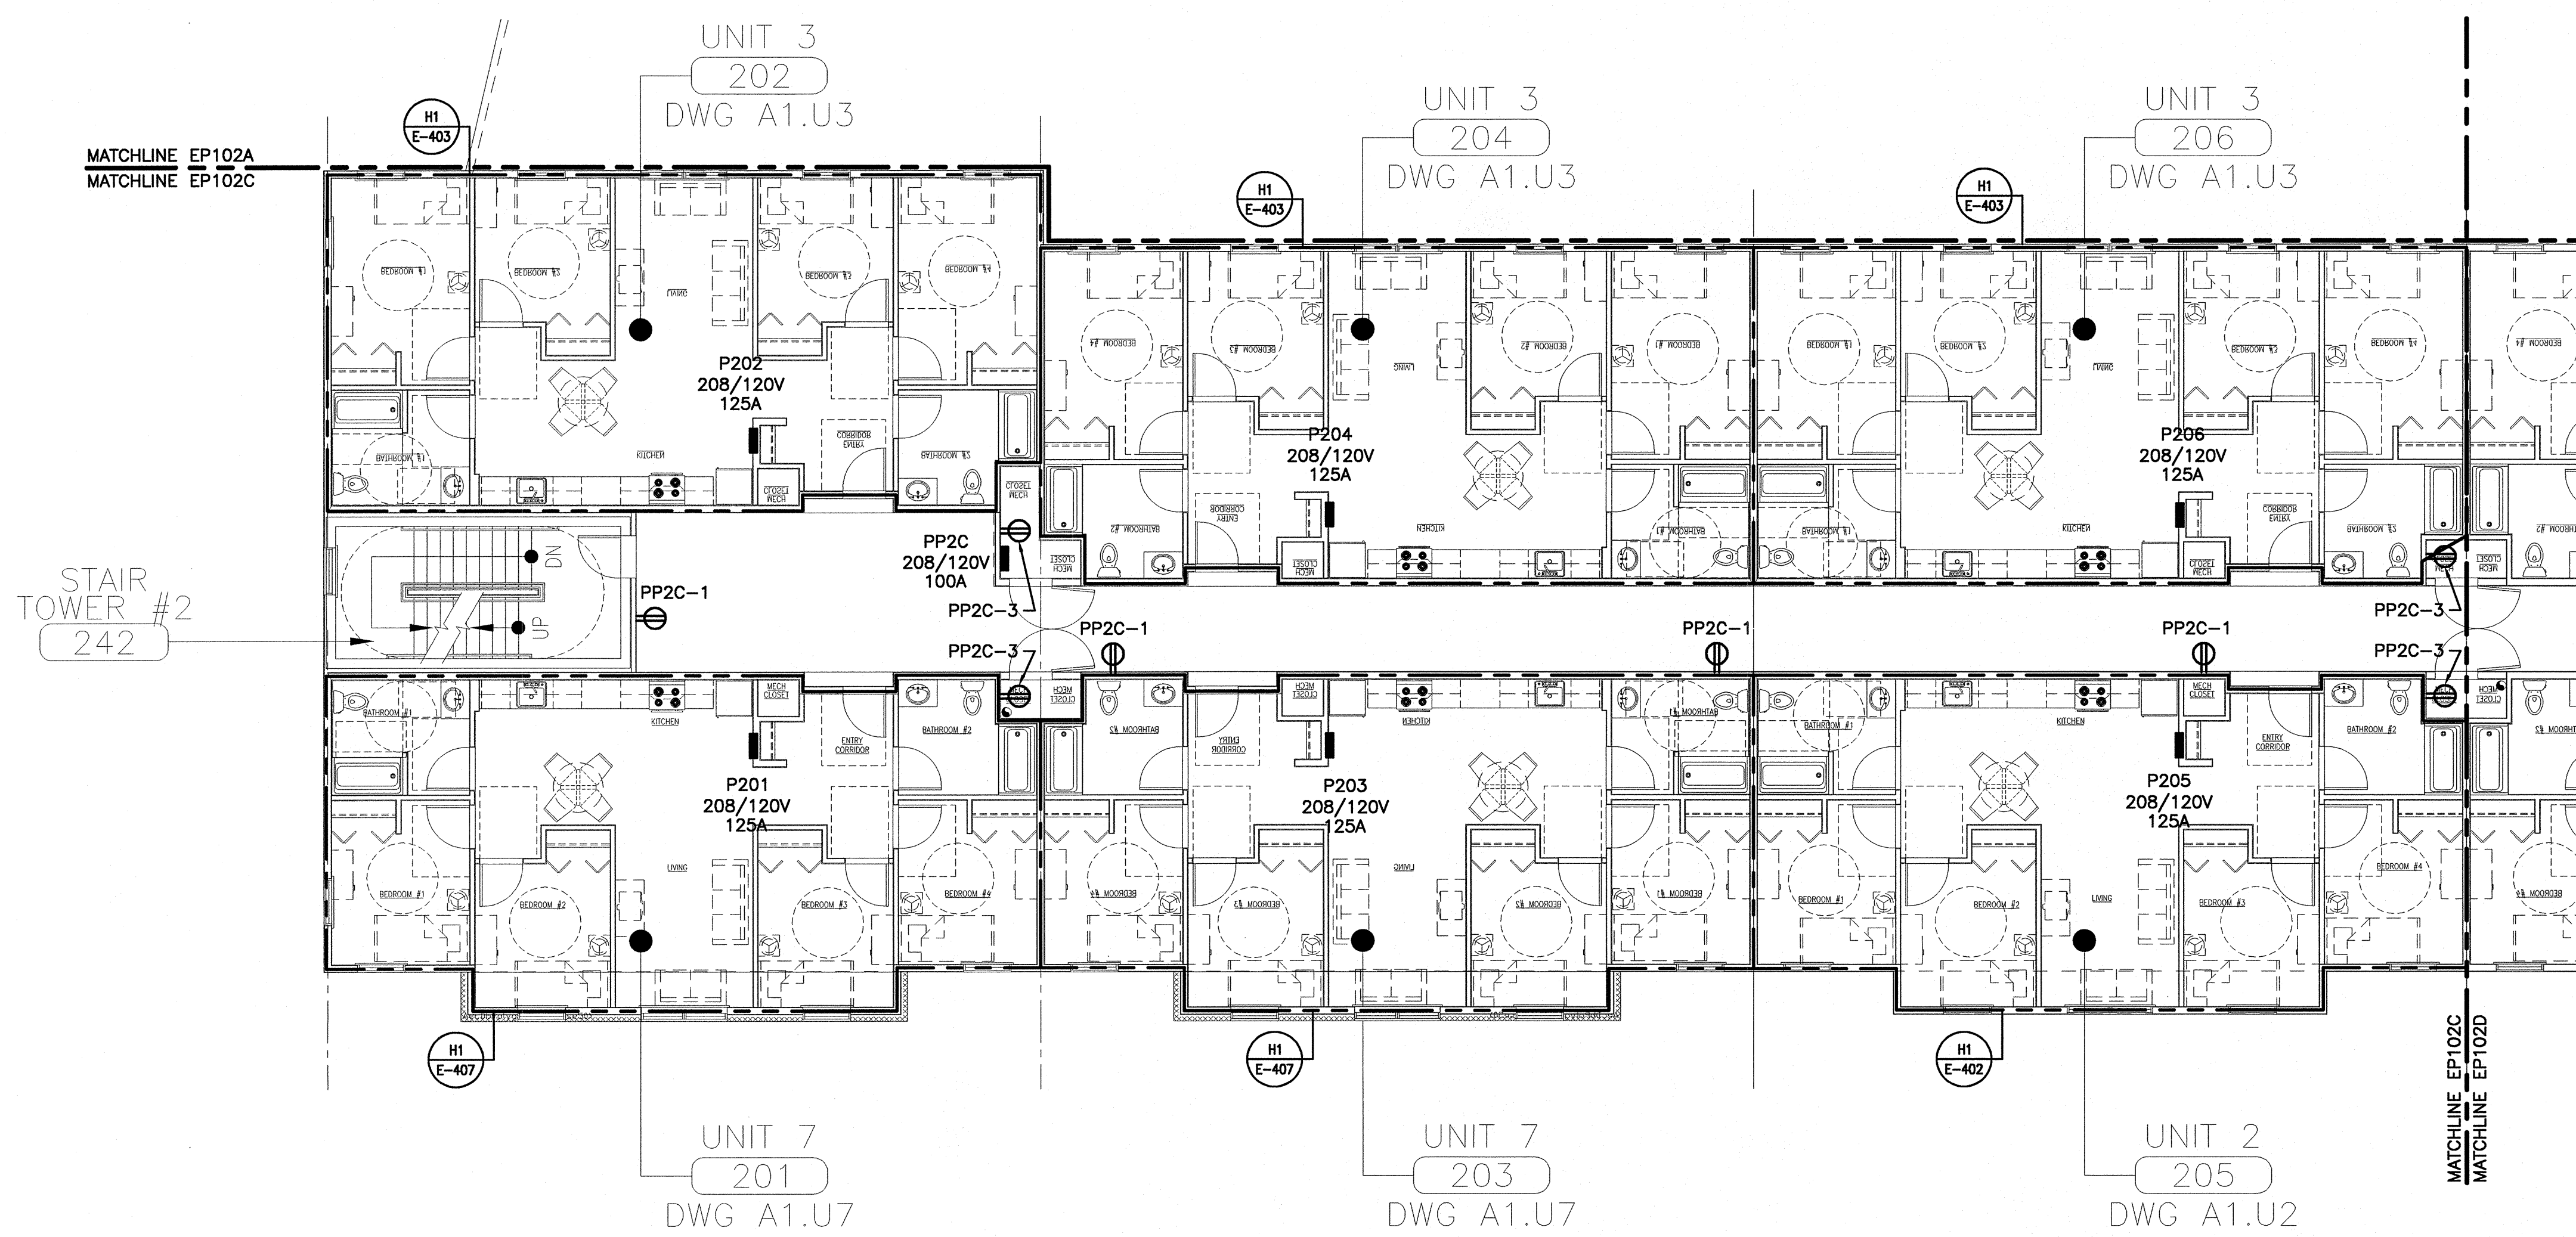

A1 SECOND FLOOR PLAN

1/16"=1'-0"

© copyright 2007 SMRT INC