
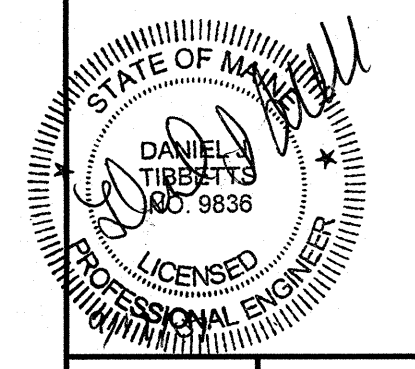


NOTE:
 1. SEE SHEET E-001 FOR LEGEND AND GENERAL NOTES.

KEYED NOTE:
 (1) PROVIDE POWER FOR HVAC CONTROLS. FIELD COORDINATE EXACT LOCATION OF ELECTRICAL CONNECTION.

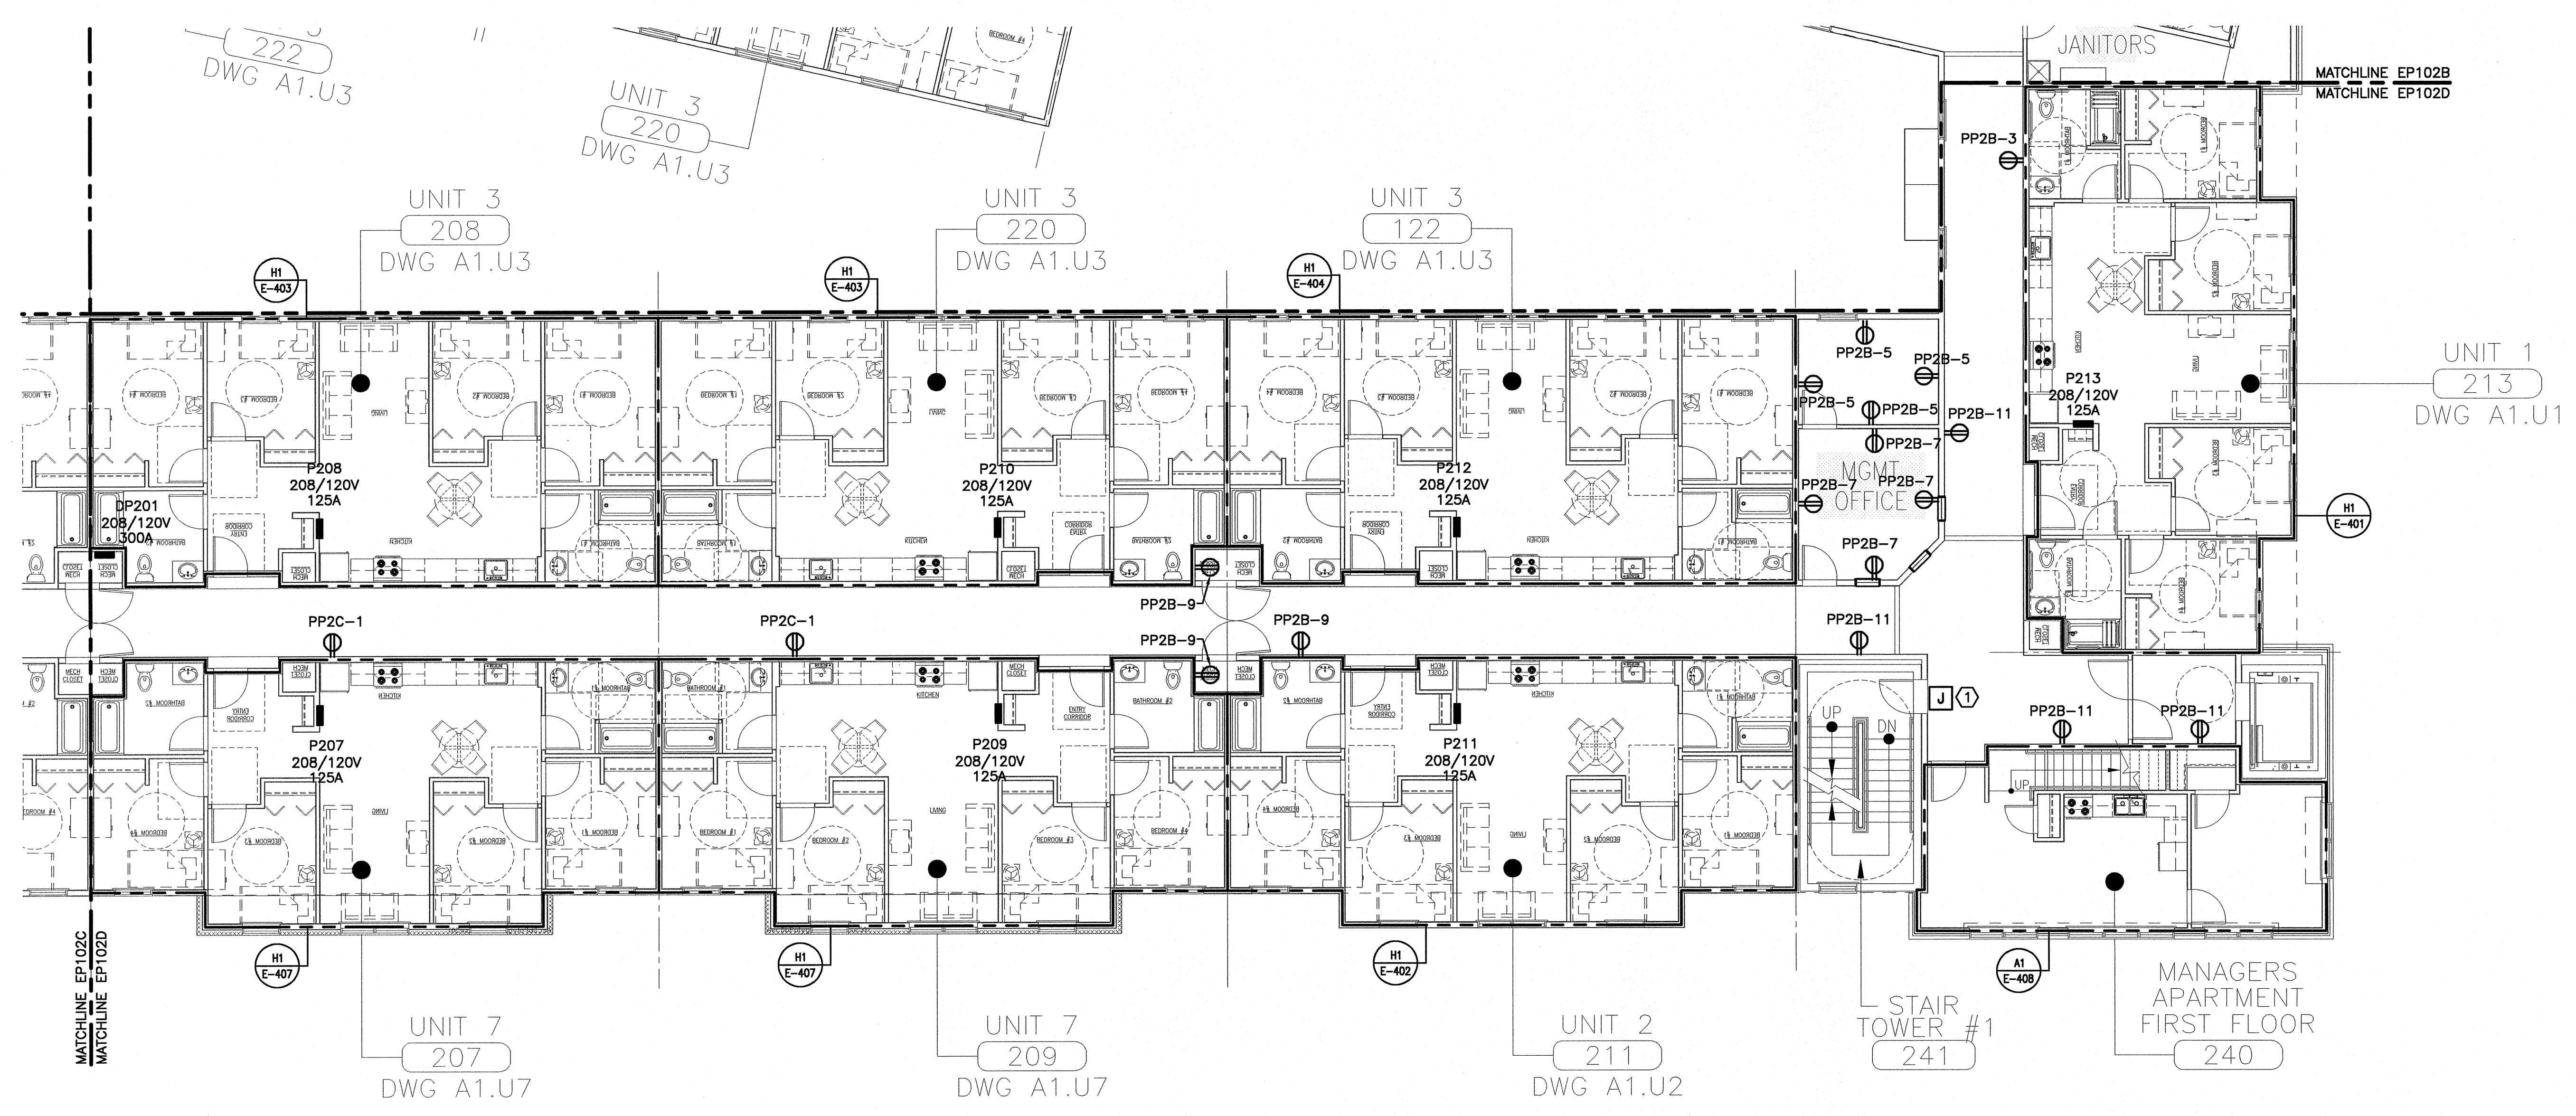

PROJECT TITLE:
BAYSIDE VILLAGE
STUDENT HOUSING COMPLEX
 PORTLAND, ME

CURRENT ISSUE STATUS:
ISSUED FOR CONSTRUCTION
 9-14-07

REV	DESCRIPTION	DATE
0	ISSUED FOR CONSTRUCTION	9-14-07

GRAPHIC SCALE:
 0" 1"

SCALE: 1/8"=1'-0"
 PROJECT MANAGER: DJT
 JC/DRAWN BY: CDS
 A/E OF RECORD: DJT
 CAD FILE: EP102D-07125
 PROJECT NO: 07125
 DATE: 9-14-07

SHEET TITLE:
SECOND FLOOR
POWER PLAN D

SHEET No.
EP102D

A1 SECOND FLOOR PLAN

1/16"=1'-0"