

NOTE:


1. SEE SHEET E-001 FOR LEGEND AND GENERAL NOTES.

ESB
E.S. BOULOS CO
 ELECTRICAL CONTRACTORS

45 BRADLEY DRIVE
 WESTBROOK, ME 04092
 TEL: (207) 464-3706
 FAX: (207) 464-1833

SM
RT

ARCHITECTURE ENGINEERING PLANNING
 SMART
 144 Fore Street/P.O. Box 618
 Portland, Maine 04104
 tel. (207) 772-3846
 fax. (207) 772-1070

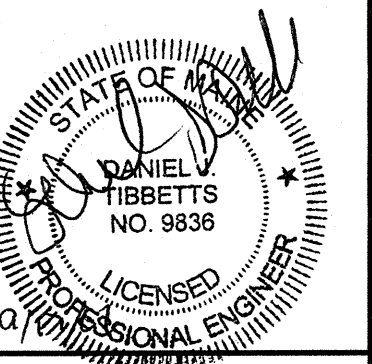

BAYSIDE VILLAGE
STUDENT HOUSING COMPLEX
 PORTLAND, ME
ISSUED FOR CONSTRUCTION
9-14-07

PROJECT TITLE:
 CURRENT ISSUE STATUS:


REV	DESCRIPTION	DATE
0	ISSUED FOR CONSTRUCTION	9-14-07

GRAPHIC SCALE:
 0" 1"

SCALE: 1/8"=1'-0"
 PROJECT MANAGER: DJT
 JC/DRAWN BY: CDS
 A/E OF RECORD: DJT
 CAD FILE: EP103A-07125
 PROJECT NO: 07125
 DATE: 9-14-07

SHEET TITLE:
THIRD FLOOR POWER PLAN A

SHEET No.
EP103A

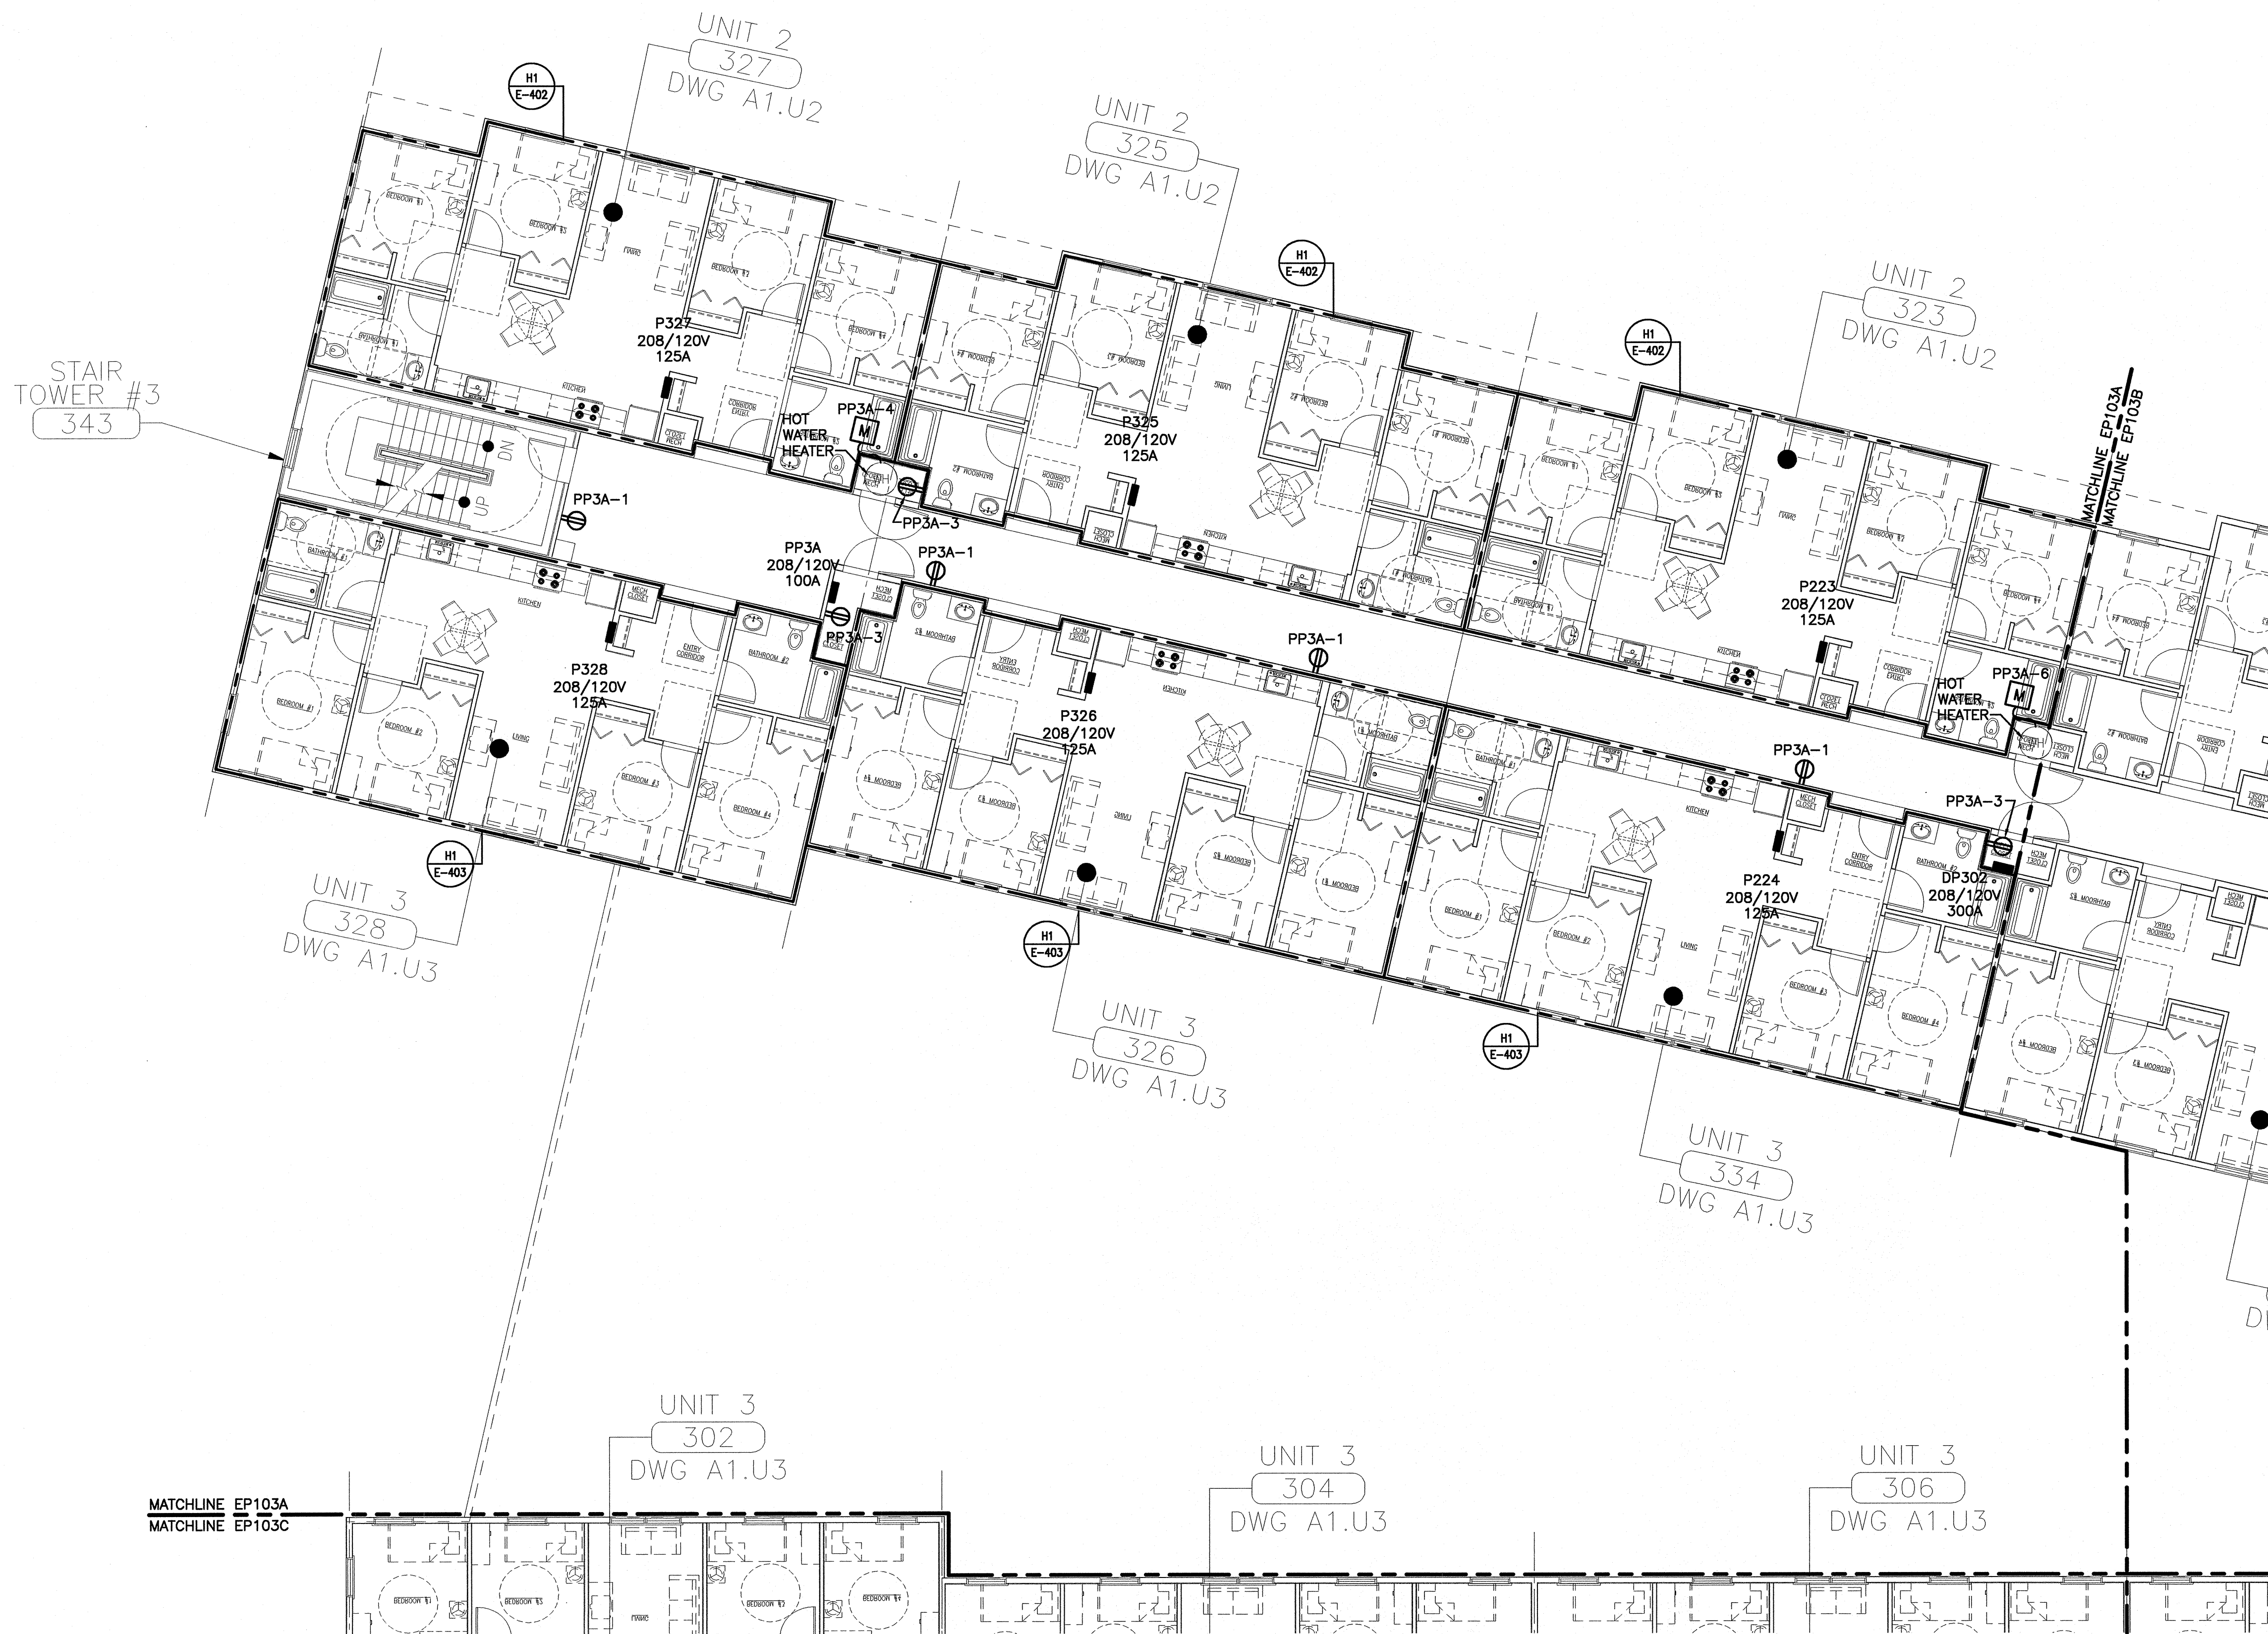

A1 **THIRD FLOOR PLAN**

1/8"=1'-0"