

NOTE:


1. SEE SHEET E-001 FOR LEGEND AND GENERAL NOTES.

ESB
E.S. BOULOS CO
 ELECTRICAL CONTRACTORS

45 BRADLEY DRIVE
 WESTBROOK, ME 04092
 TEL: (207) 464-3706
 FAX: (207) 464-1833

SM
RT

ARCHITECTURE ENGINEERING PLANNING
 SMART
 144 Fore Street/P.O. Box 618
 Portland, Maine 04104
 tel. (207) 772-3846
 fax. (207) 772-1070

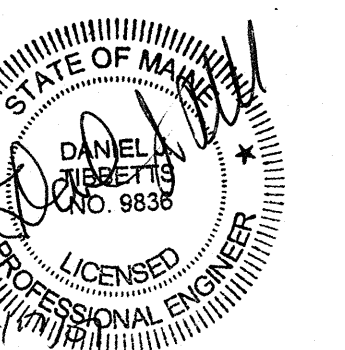

PROJECT TITLE:
**BAYSIDE VILLAGE
 STUDENT HOUSING COMPLEX**
 PORTLAND, ME

CURRENT ISSUE STATUS:
ISSUED FOR CONSTRUCTION
 9-14-07

REV	DESCRIPTION	DATE
0	ISSUED FOR CONSTRUCTION	9-14-07

GRAPHIC SCALE:

SCALE: 1/8"=1'-0"

PROJECT MANAGER: DJT

JC/DRAWN BY: CDS

A/E OF RECORD: DJT

CAD FILE: EP104C-07125

PROJECT NO: 07125

DATE: 9-14-07


SHEET TITLE:

**FOURTH FLOOR
 POWER PLAN C**

SHEET No.

EP104C

© copyright 2007 ESB Inc.

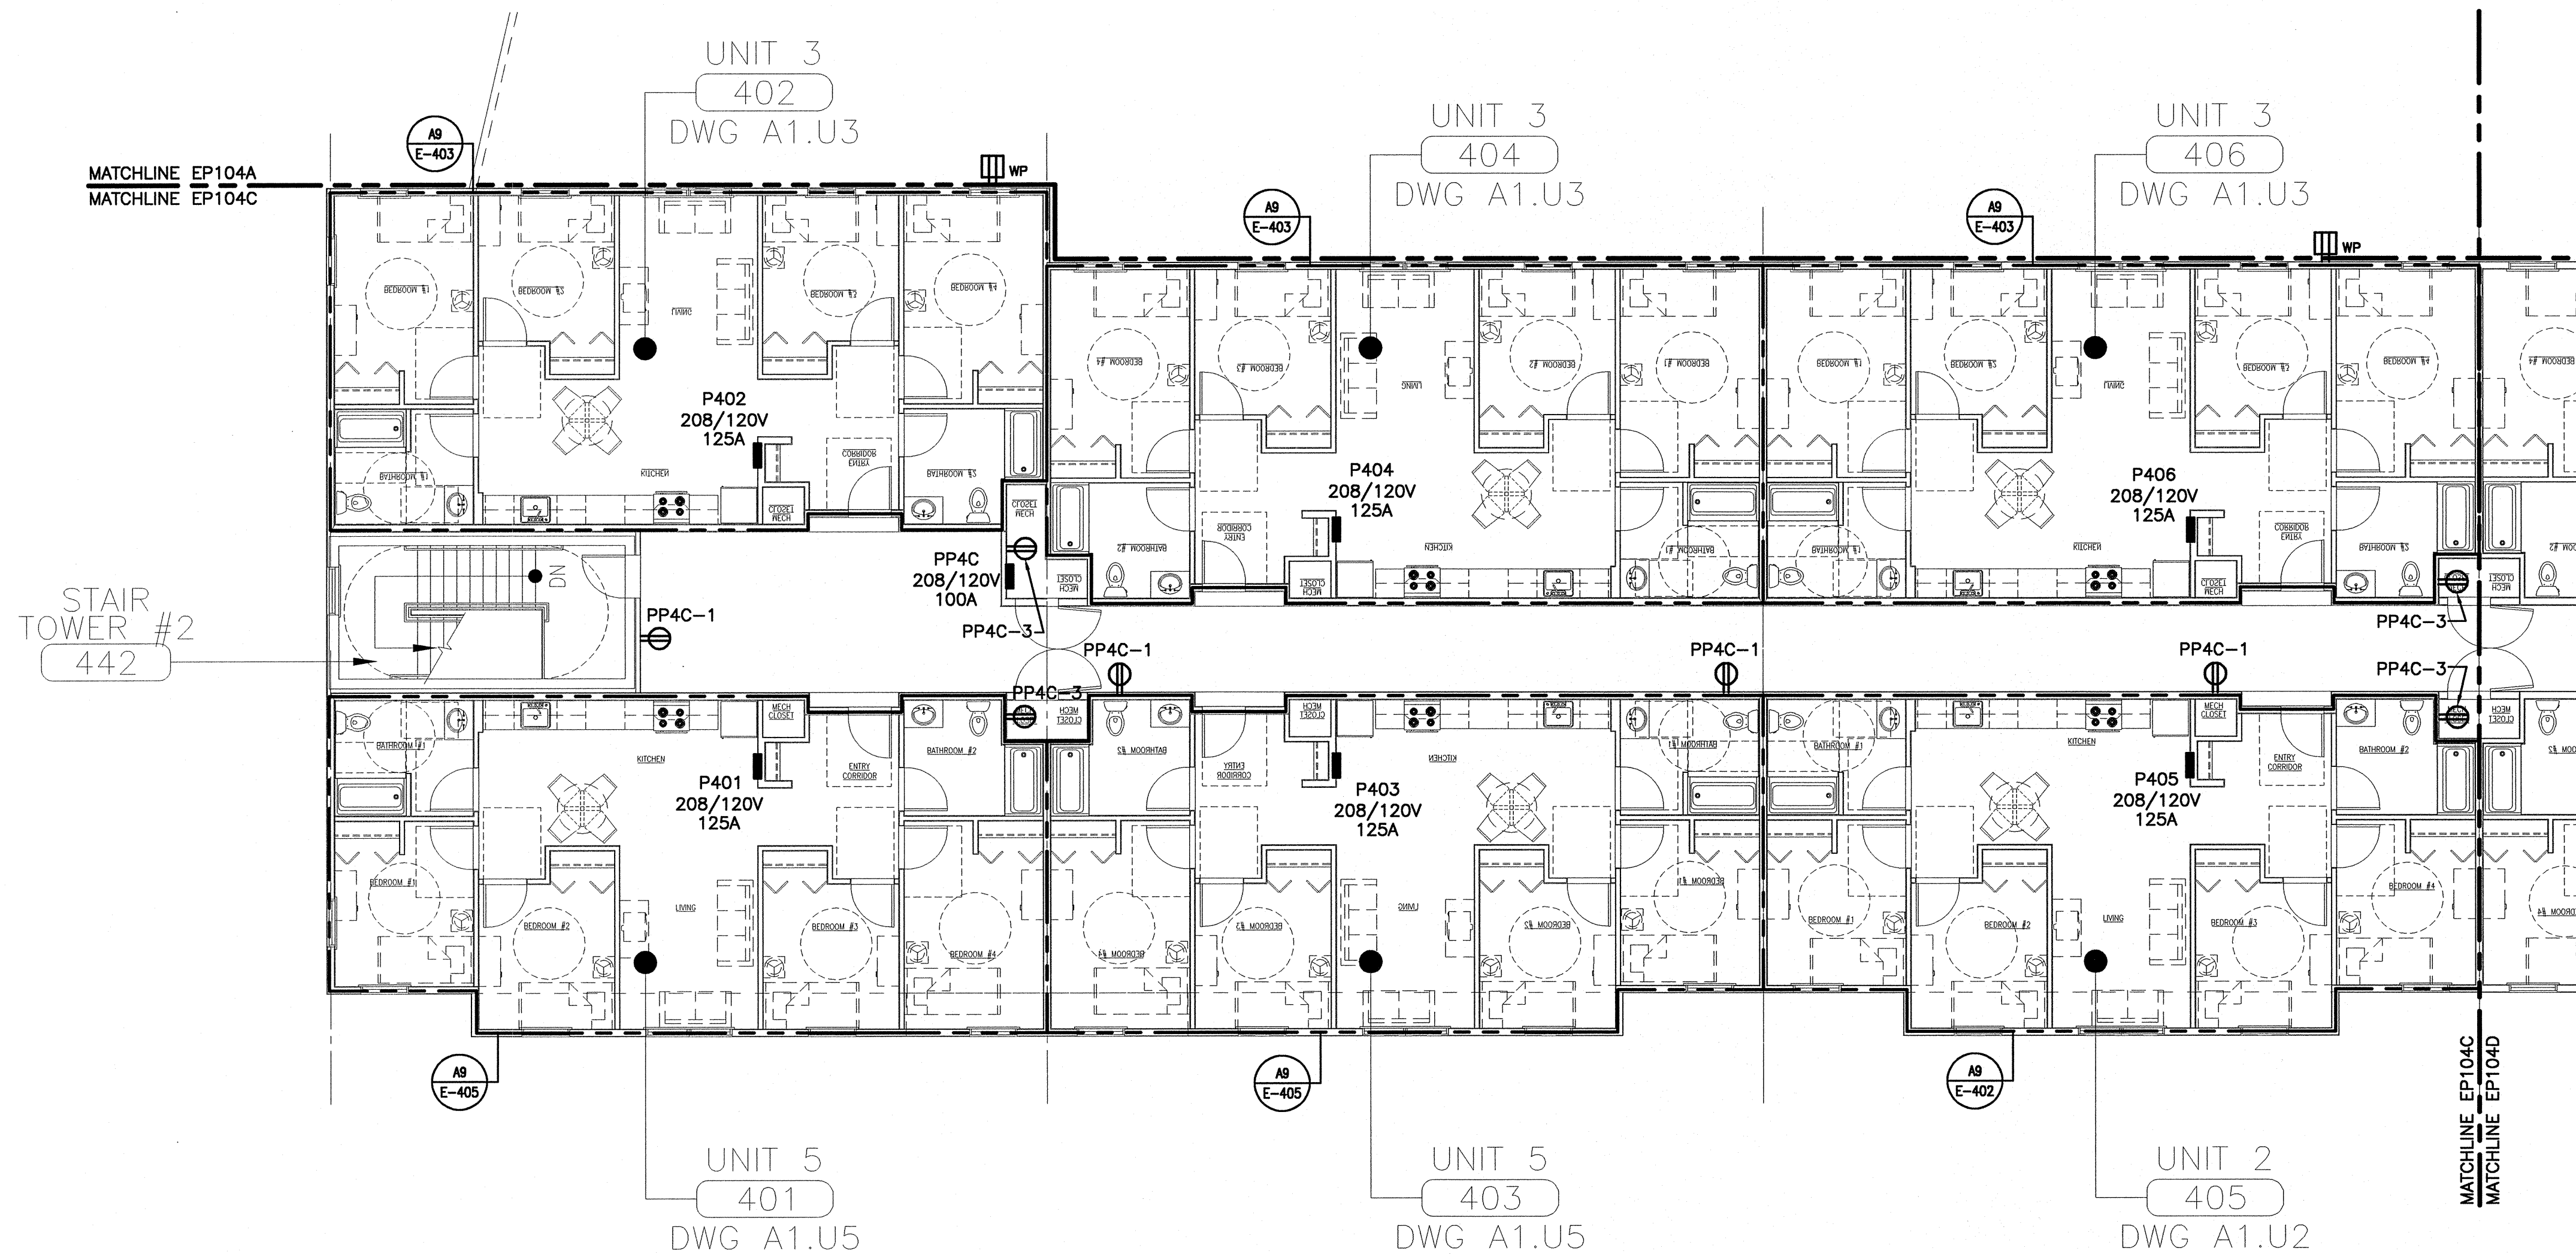

A1 **FOURTH FLOOR PLAN**

1/8"=1'-0"